
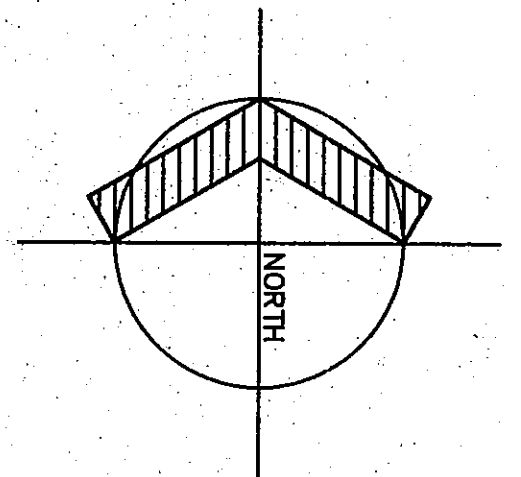


62

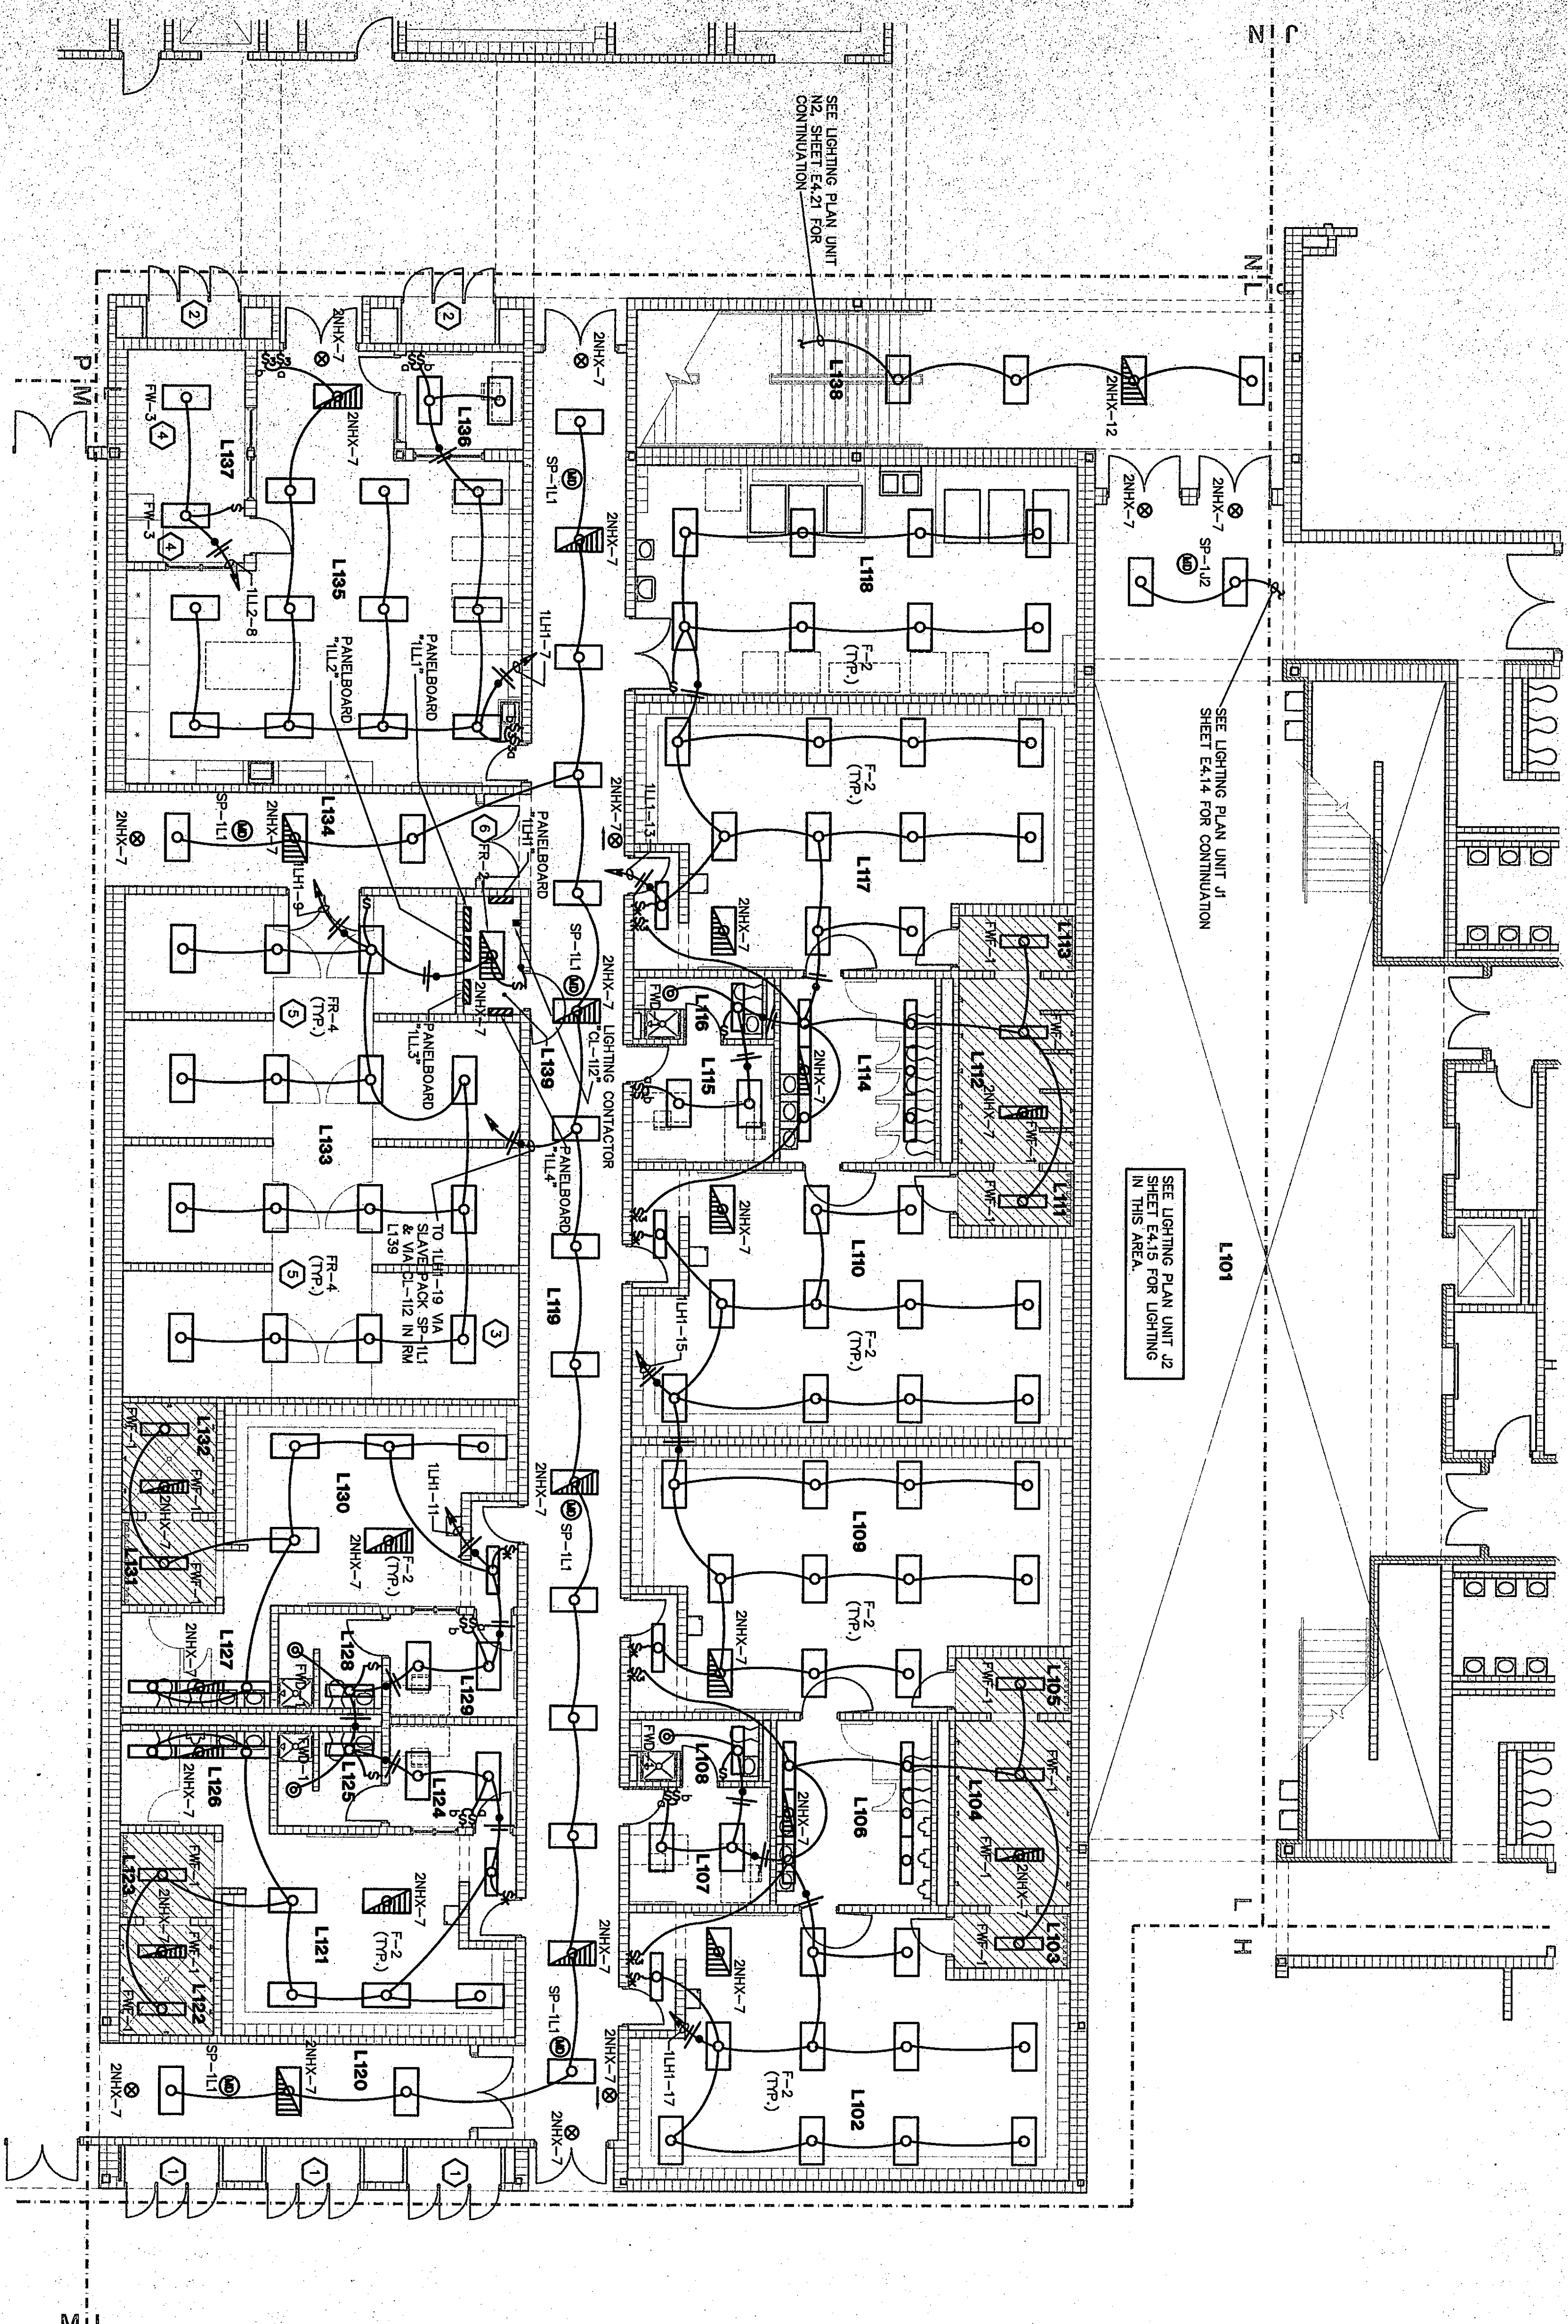

LIGHTING PLAN UNIT L
SCALE 1/8" = 1'-0"

ROOM LEGEND "L1"		AREA	BEING
ROOM NO.	NAME	S.F.	BEING
L101	CORRIDOR	1882	9'-4"
L102	BOYS' ATHLETIC LOCKER	782	9'-4"
L103	BOYS' DRYING ROOM	46	9'-4"
L104	BOYS' DRYING ROOM	46	9'-4"
L105	BOYS' DRYING ROOM	46	9'-4"
L106	ATHLETIC OFFICE	208	9'-4"
L107	ATHLETIC OFFICE	208	9'-4"
L108	ATHLETIC OFFICE	208	9'-4"
L109	ATHLETIC OFFICE	208	9'-4"
L110	ATHLETIC OFFICE	208	9'-4"
L111	ATHLETIC OFFICE	208	9'-4"
L112	ATHLETIC OFFICE	208	9'-4"
L113	ATHLETIC OFFICE	208	9'-4"
L114	ATHLETIC OFFICE	208	9'-4"
L115	ATHLETIC OFFICE	208	9'-4"
L116	ATHLETIC OFFICE	208	9'-4"
L117	ATHLETIC OFFICE	208	9'-4"
L118	ATHLETIC OFFICE	208	9'-4"
L119	ATHLETIC OFFICE	208	9'-4"
L120	ATHLETIC OFFICE	208	9'-4"
L121	ATHLETIC OFFICE	208	9'-4"
L122	ATHLETIC OFFICE	208	9'-4"
L123	ATHLETIC OFFICE	208	9'-4"
L124	ATHLETIC OFFICE	208	9'-4"
L125	ATHLETIC OFFICE	208	9'-4"
L126	ATHLETIC OFFICE	208	9'-4"
L127	ATHLETIC OFFICE	208	9'-4"
L128	ATHLETIC OFFICE	208	9'-4"
L129	ATHLETIC OFFICE	208	9'-4"
L130	ATHLETIC OFFICE	208	9'-4"
L131	ATHLETIC OFFICE	208	9'-4"
L132	ATHLETIC OFFICE	208	9'-4"
L133	ATHLETIC OFFICE	208	9'-4"
L134	ATHLETIC OFFICE	208	9'-4"
L135	ATHLETIC OFFICE	208	9'-4"
L136	ATHLETIC OFFICE	208	9'-4"
L137	ATHLETIC OFFICE	208	9'-4"
L138	ATHLETIC OFFICE	208	9'-4"
L139	ATHLETIC OFFICE	208	9'-4"

- PLAN NOTES:**
1. SEE LIGHTING PLAN UNIT K, SHEET E4.16 FOR DISPLAY CASE LIGHTING REQUIREMENTS.
 2. SEE LIGHTING PLAN UNIT M, SHEET E4.20 FOR DISPLAY CASE LIGHTING REQUIREMENTS.
 3. FOR CORRIDOR LIGHTING CONTROL, SEE DETAIL 8/E1.4.
 4. PROVIDE LIGHT FIXTURE TYPE FW-3 IN THIS ROOM WITH A 120V BALLAST.
 5. MOUNT LIGHT FIXTURE TYPE RR-4 AT 13'-0" ABOVE FINISH FLOOR.
 6. MOUNT LIGHT FIXTURE TYPE RR-2 AT 9'-6" ABOVE FINISH FLOOR.
- ALL 2'x4' LIGHT FIXTURES SHALL BE PLAN TYPE F-3 UNLESS OTHERWISE NOTED.
ALL 1'x4' LIGHT FIXTURES SHALL BE PLAN TYPE F-1 UNLESS OTHERWISE NOTED.
ALL 2'x2' LIGHT FIXTURES SHALL BE PLAN TYPE F-22 UNLESS OTHERWISE NOTED.
ALL RECESS CAN LIGHTS SHALL BE PLAN TYPE RD-1 UNLESS OTHERWISE NOTED.
ALL EXIT SIGNS SHALL BE PLAN TYPE XB-1 UNLESS OTHERWISE NOTED.

- KEY PLAN**
-

THE NEW
CHESTERTON HIGH SCHOOL
FOR THE
DUNELAND SCHOOL CORPORATION
CHESTERTON, INDIANA

Copyright 1997 by Fanning/Howey Associates, Inc.

Fanning/Howey Associates, Inc.
Architects Engineers Consultants

LIGHTING PLAN UNIT L

DRAWN BY: MRS. COMM. NO.: 95067.00
CHECKED BY: WBH DATE: APRIL 21, 1997

E4.17

REVISIONS NO. DATE