



179

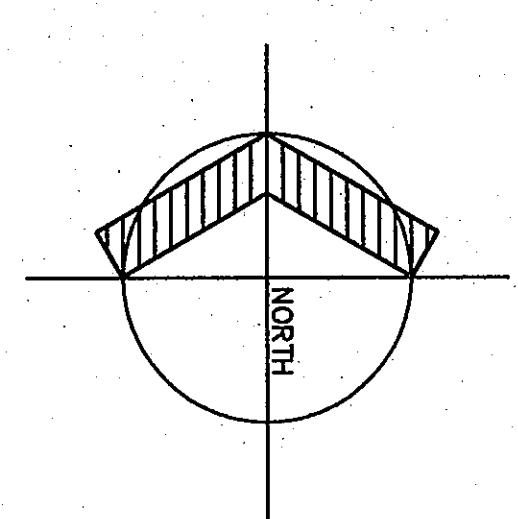

LIGHTING PLAN UNIT M2

SCALE 1/8" = 1'-0"

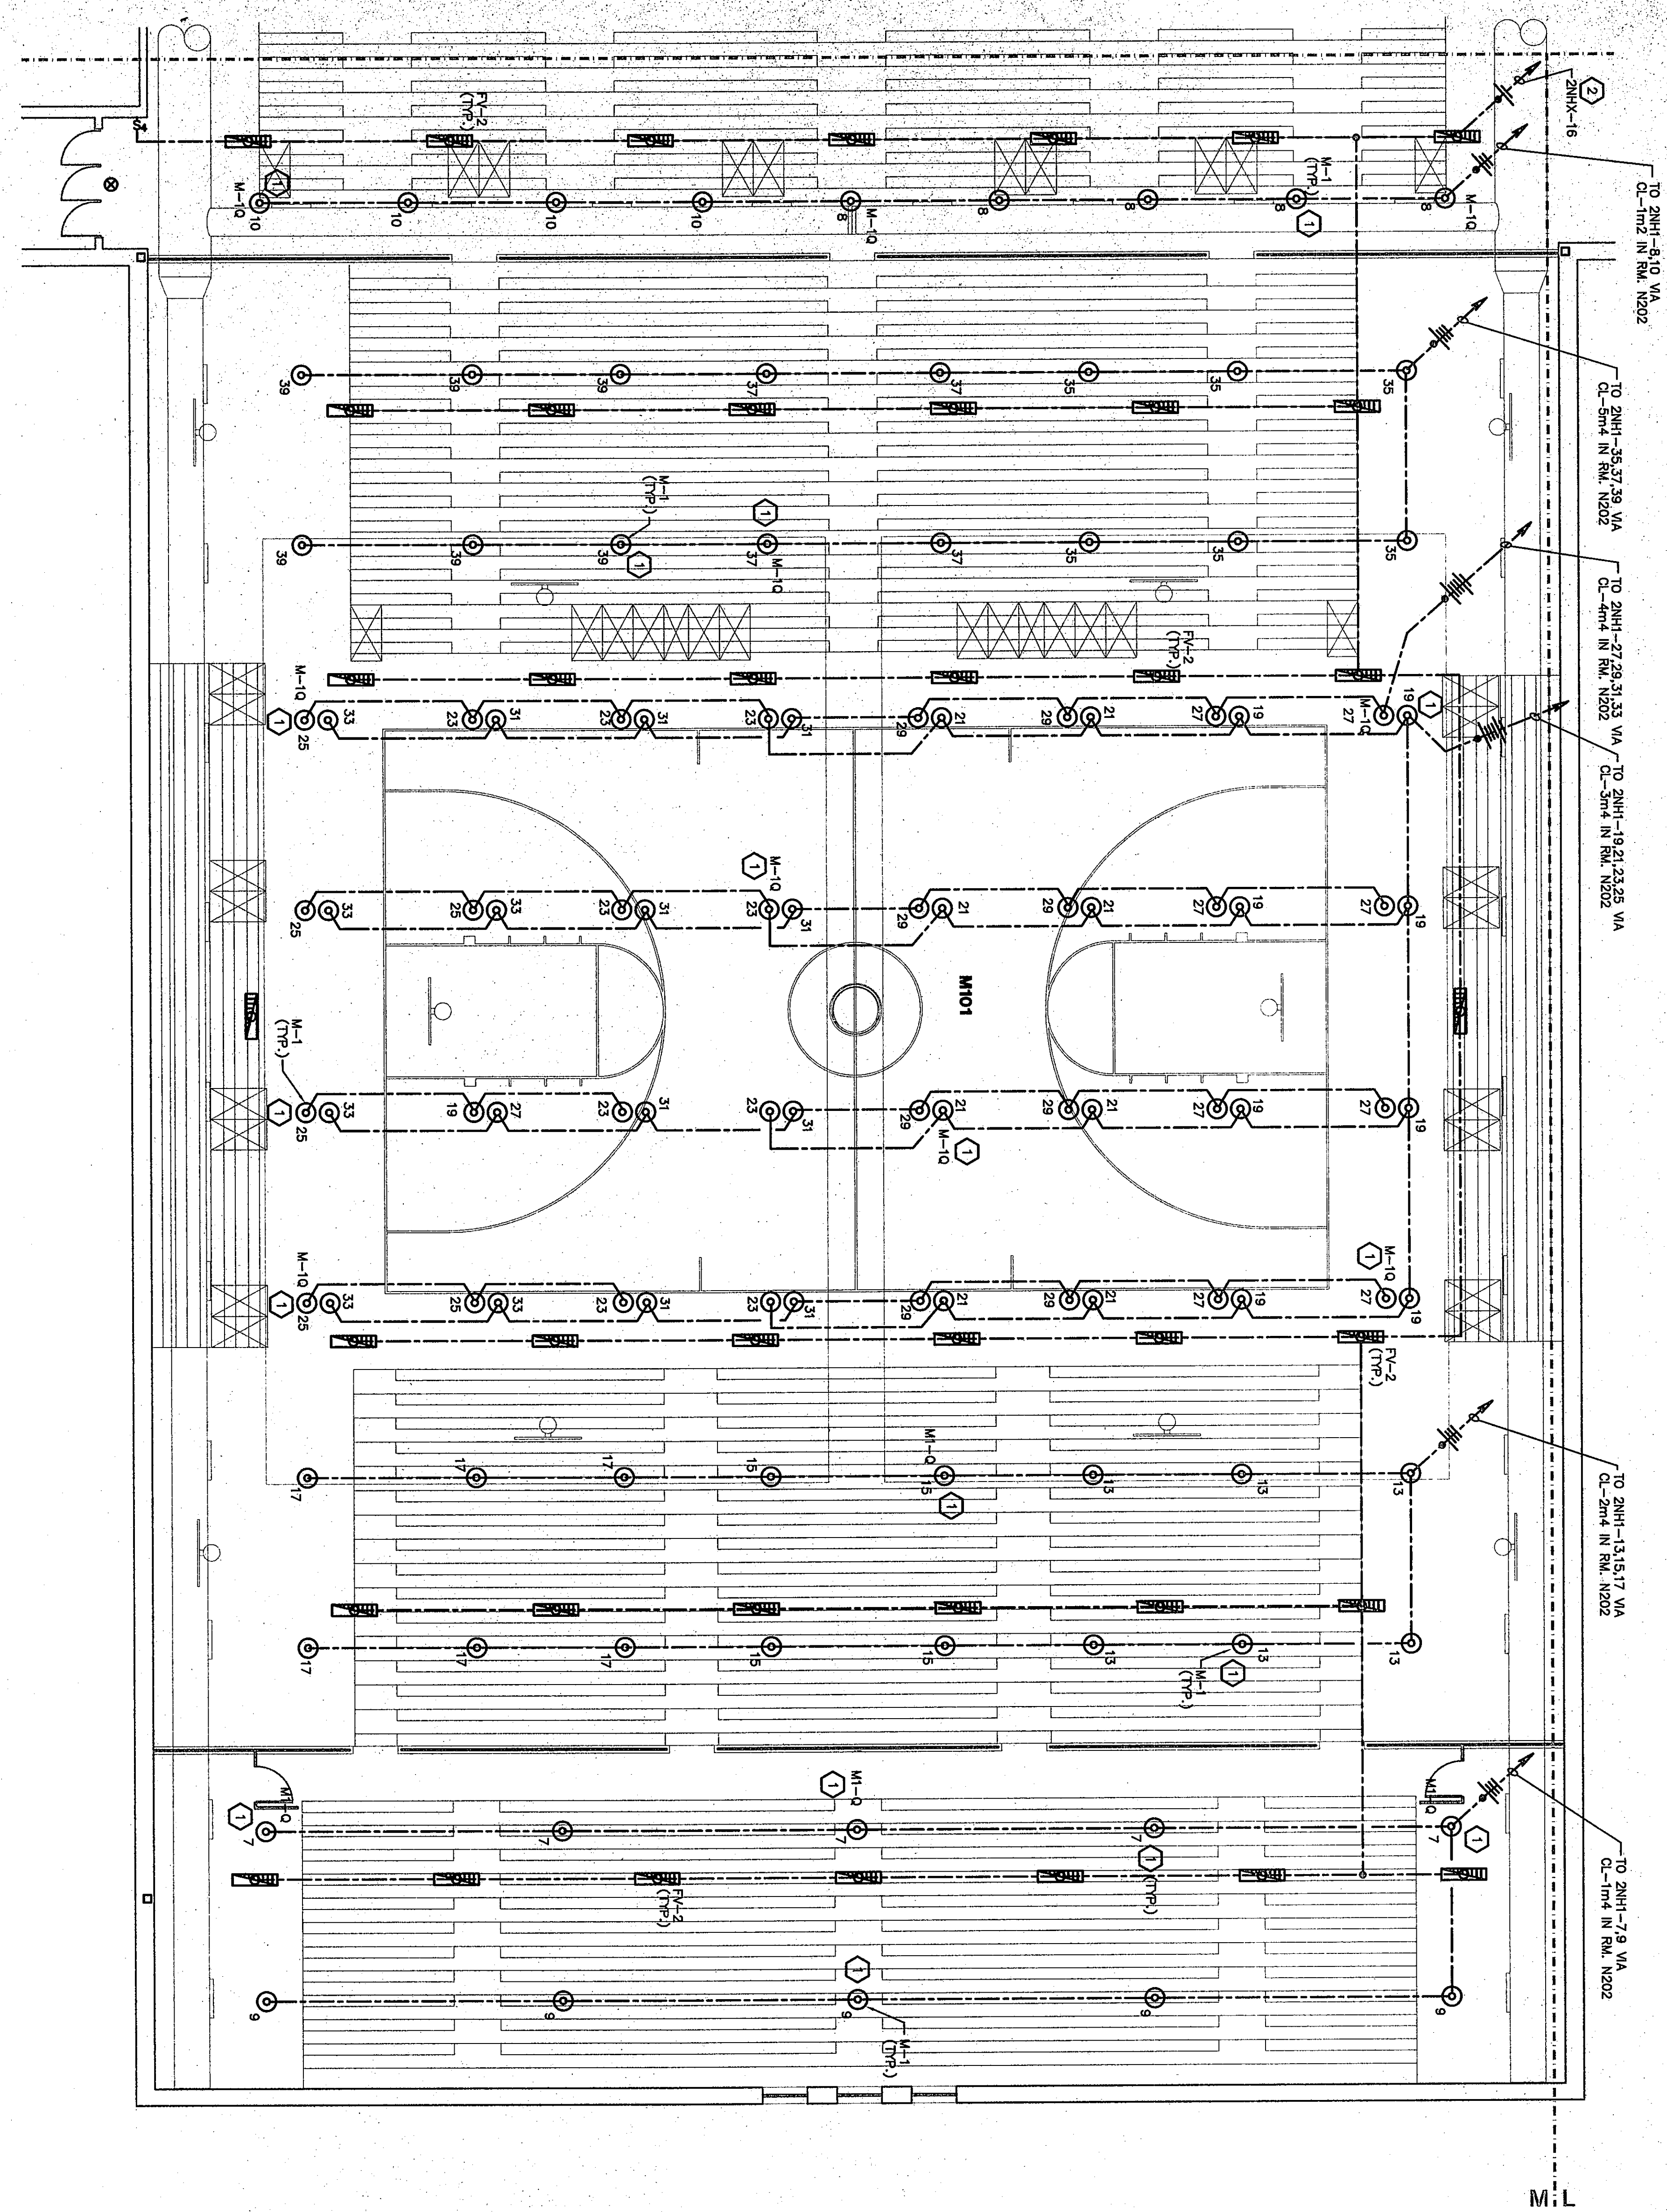


PLAN NOTES:

- MOUNT BOTTOM OF LIGHT FIXTURE(S) IN THIS AREA AT SAME HEIGHT AS THE BOTTOM OF STRUCTURAL STEEL. REFER TO DETAIL 2/E15 FOR ADDITIONAL INFORMATION.
- ⊕ PROVIDE AN EMERGENCY CONTROL RELAY FOR THIS CIRCUIT. REFER TO DETAIL 1/E15.


- ALL 2'x4' LIGHT FIXTURES SHALL BE PLAN TYPE F-3 UNLESS OTHERWISE NOTED.
- ALL 1'x4' LIGHT FIXTURES SHALL BE PLAN TYPE F-1 UNLESS OTHERWISE NOTED.
- ⊞ ALL 2'x2' LIGHT FIXTURES SHALL BE PLAN TYPE F-22 UNLESS OTHERWISE NOTED.
- ⊙ ALL RECESS CAN LIGHTS SHALL BE PLAN TYPE FC-1 UNLESS OTHERWISE NOTED.
- ⊗ ALL EXIT SIGNS SHALL BE PLAN TYPE XB-1 UNLESS OTHERWISE NOTED.

ROOM LEGEND "M2"			
ROOM NO.	ROOM NAME	AREA S.F.	CEILING HEIGHT
M201	SEATING MEZZANINE	3746	

07-E-00


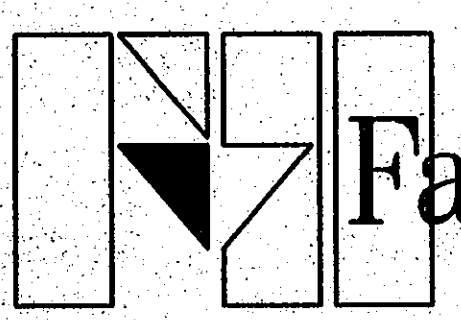


Fanning/Howey Associates, Inc.
Architects Engineers Consultants

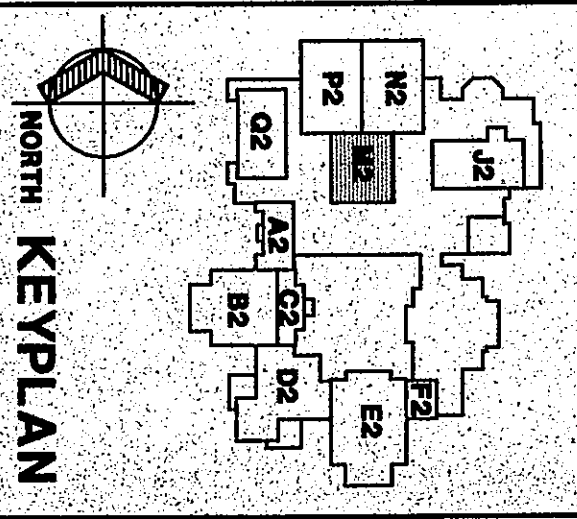

THE NEW
CHESTERTON HIGH SCHOOL
FOR THE
DUNELAND SCHOOL CORPORATION
CHESTERTON, INDIANA

COPYRIGHT 1997 BY FANNING/HOWEY ASSOCIATES, INC.

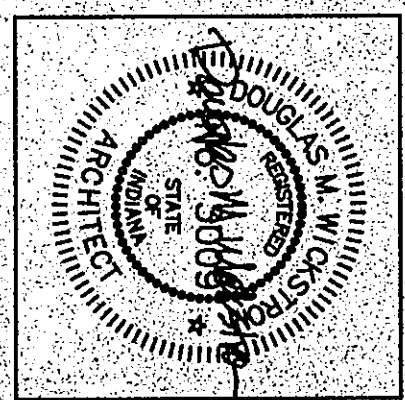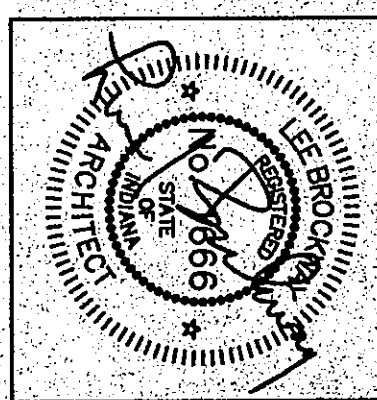

LIGHTING PLAN UNIT M2

DRAWN BY: MRS. COMM. NO.: 95067.00
CHECKED BY: WBH DATE: APRIL 21, 1997

E4.19

REVISIONS NO. DATE