



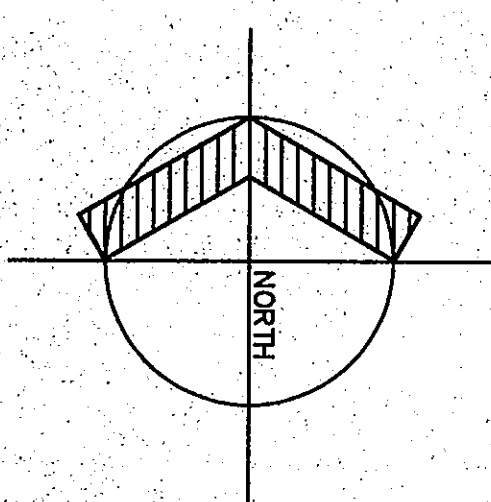

SCALE 1/8" = 1'-0"

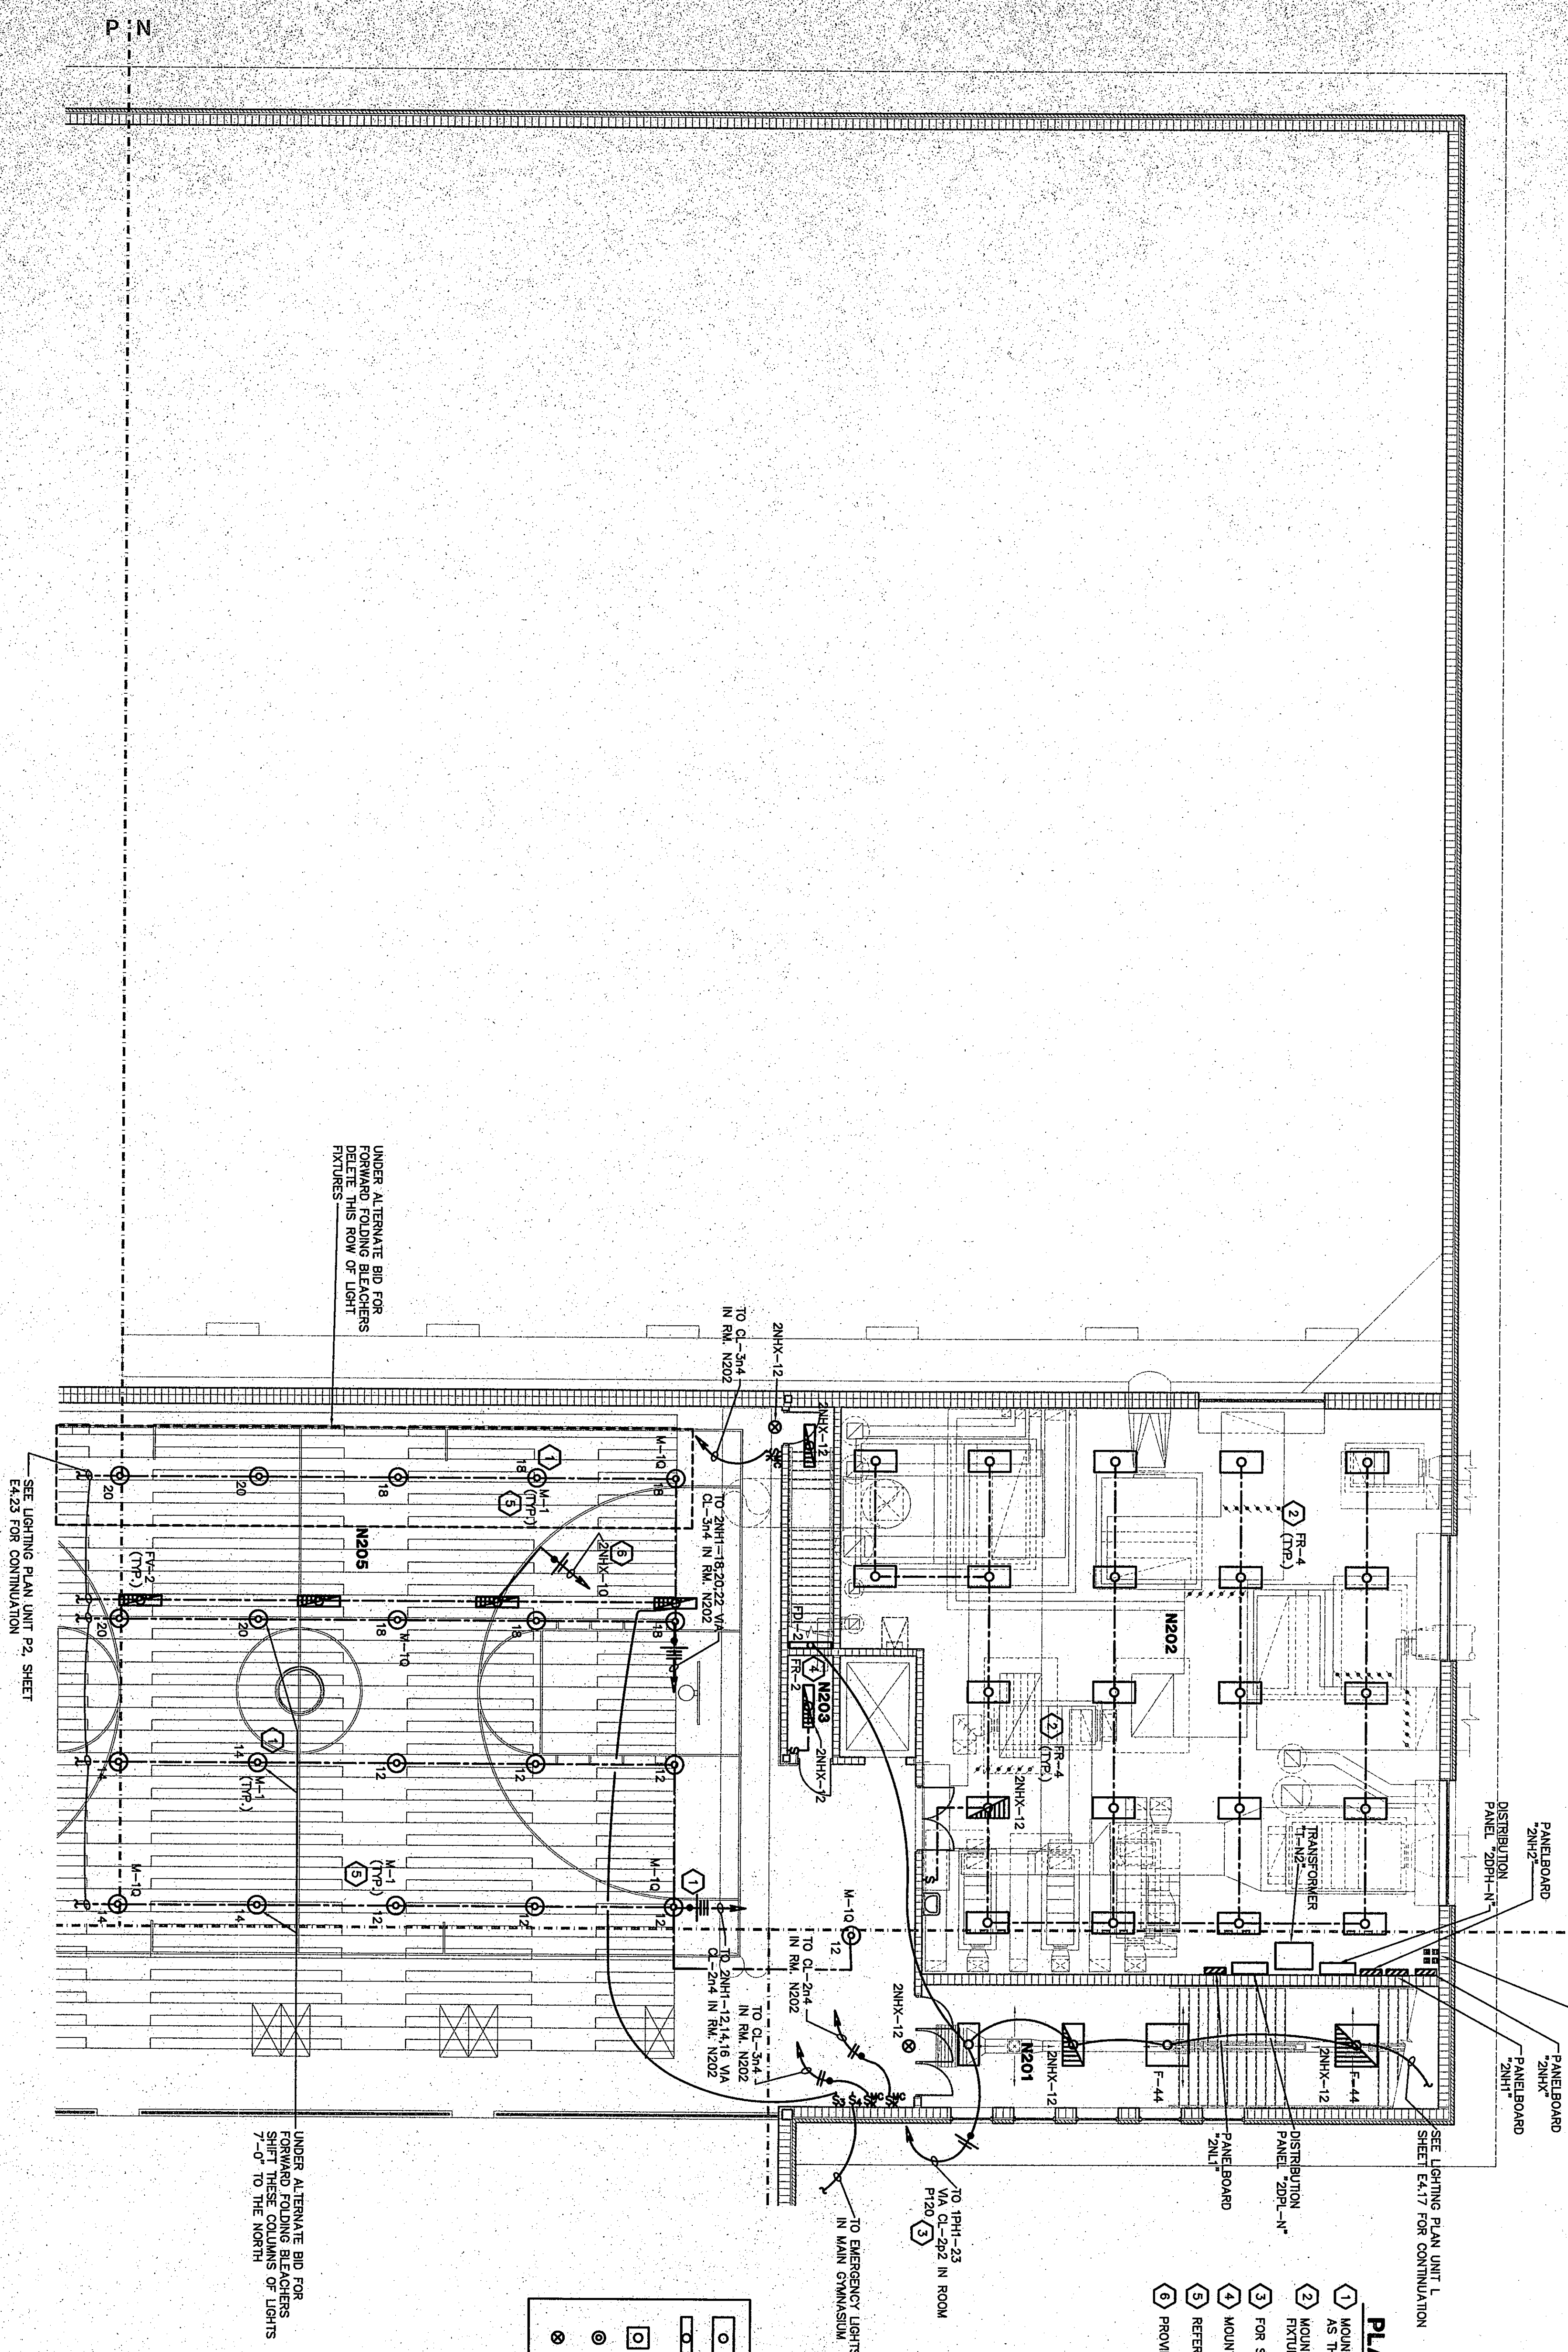

- ① MOUNT THE BOTTOM OF LIGHT EXTURE TYPE M-1, M-10, AND P-2 AT THE SAME HEIGHT AS THE STRUCTURAL STEEL. REFER TO DETAIL 7/E/1.9.
- ② MOUNT LIGHT EXTURE TYPE RR-4 AT 11'-0" ABOVE FINISH FLOOR. MOUNT LIGHT EXTURES TO MEET ALL MECHANICAL EQUIPMENT.
- ③ FOR STAIR LIGHTING CONTROL, SEE DETAIL 8/E/1.4.
- ④ MOUNT LIGHT EXTURE TYPE RR-2 AT 9'-6" ABOVE FINISH FLOOR.
- ⑤ REFER TO DETAIL 2/E/1.9 FOR MOUNTING REQUIREMENTS.
- ⑥ PROVIDE EMERGENCY RELAY, WIRE PER DETAIL 1/E/1.5.

PLAN NOTES:

- | | |
|---|---|
|  | ALL 2'x4' LIGHT FIXTURES SHALL BE PLAIN TYPE F-3 UNLESS OTHERWISE NOTED. |
|  | ALL 1'x4' LIGHT FIXTURES SHALL BE PLAIN TYPE F-11 UNLESS OTHERWISE NOTED. |
|  | ALL 2'x2' LIGHT FIXTURES SHALL BE PLAIN TYPE F-22 UNLESS OTHERWISE NOTED. |
|  | ALL RECESS CAN LIGHTS SHALL BE PLAIN TYPE RD-1 UNLESS OTHERWISE NOTED. |
|  | ALL EXIT SIGNS SHALL BE PLAIN TYPE XB-1 UNLESS OTHERWISE NOTED. |

ROOM LEGEND "N2"		
ROOM NO.	ROOM NAME	AREA S.F. CEILING HEIGHT
N201	STAIR	579 10'-8"
N202	MECHANICAL ROOM	2866
N203	ELEVATOR EQUIPMENT	37
N204	NOT USED	---
N205	BALCONY COURT	4681

ROOM LEGEND "N2"


ROOM NO.	ROOM NAME	AREA S.F.	CEILING HEIGHT
N201	STAIR	579	10'-6"
N202	MECHANICAL ROOM	2886	---
N203	ELEVATOR EQUIPMENT	37	---
N204	NOT USED	---	---
N205	BALCONY COURT	4661	---

LIGHTING PLAN UNIT N2


DRAWN BY: MRS	COMM. NO.: 95067.00
CHECKED BY: WBH	DATE: APRIL 21, 1997

E4.21

REVISIONS	NO.	DATE

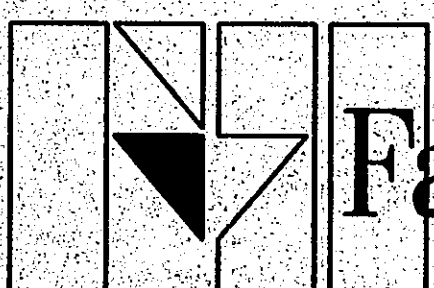

Fanning/Howey
Associates, Inc.
Architects Engineers Consultants

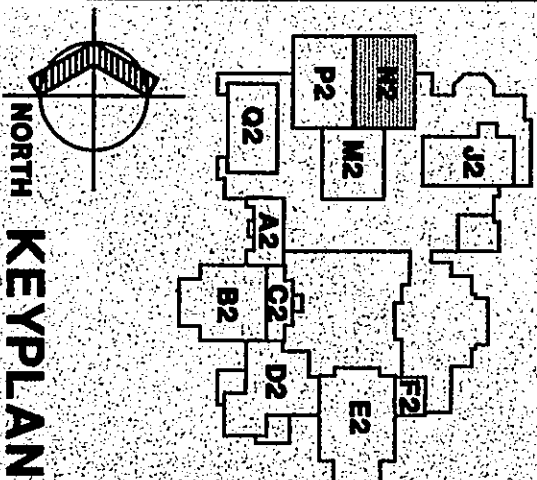

KEYPLAN

THE NEW
CHESTERTON HIGH SCHOOL
FOR THE
DUNELAND SCHOOL CORPORATION
CHESTERTON, INDIANA

COPYRIGHT 1997 BY FANNING/HOWEY ASSOCIATES, INC.

