

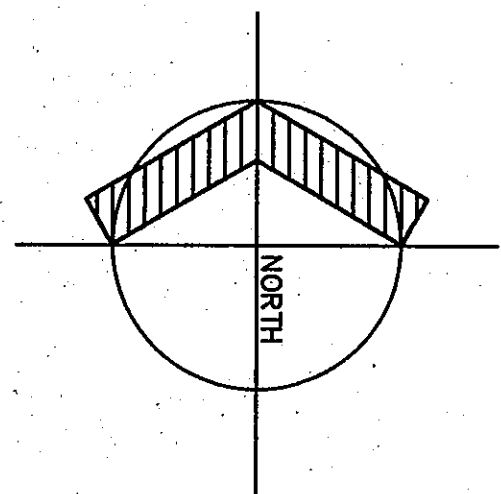


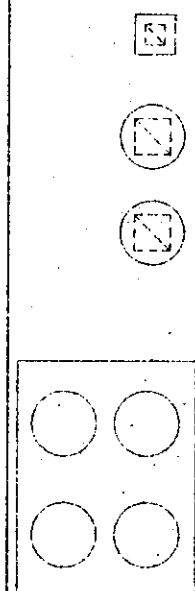

LIGHTING PLAN UNIT Q2

SCALE 1/8" = 1'-0"

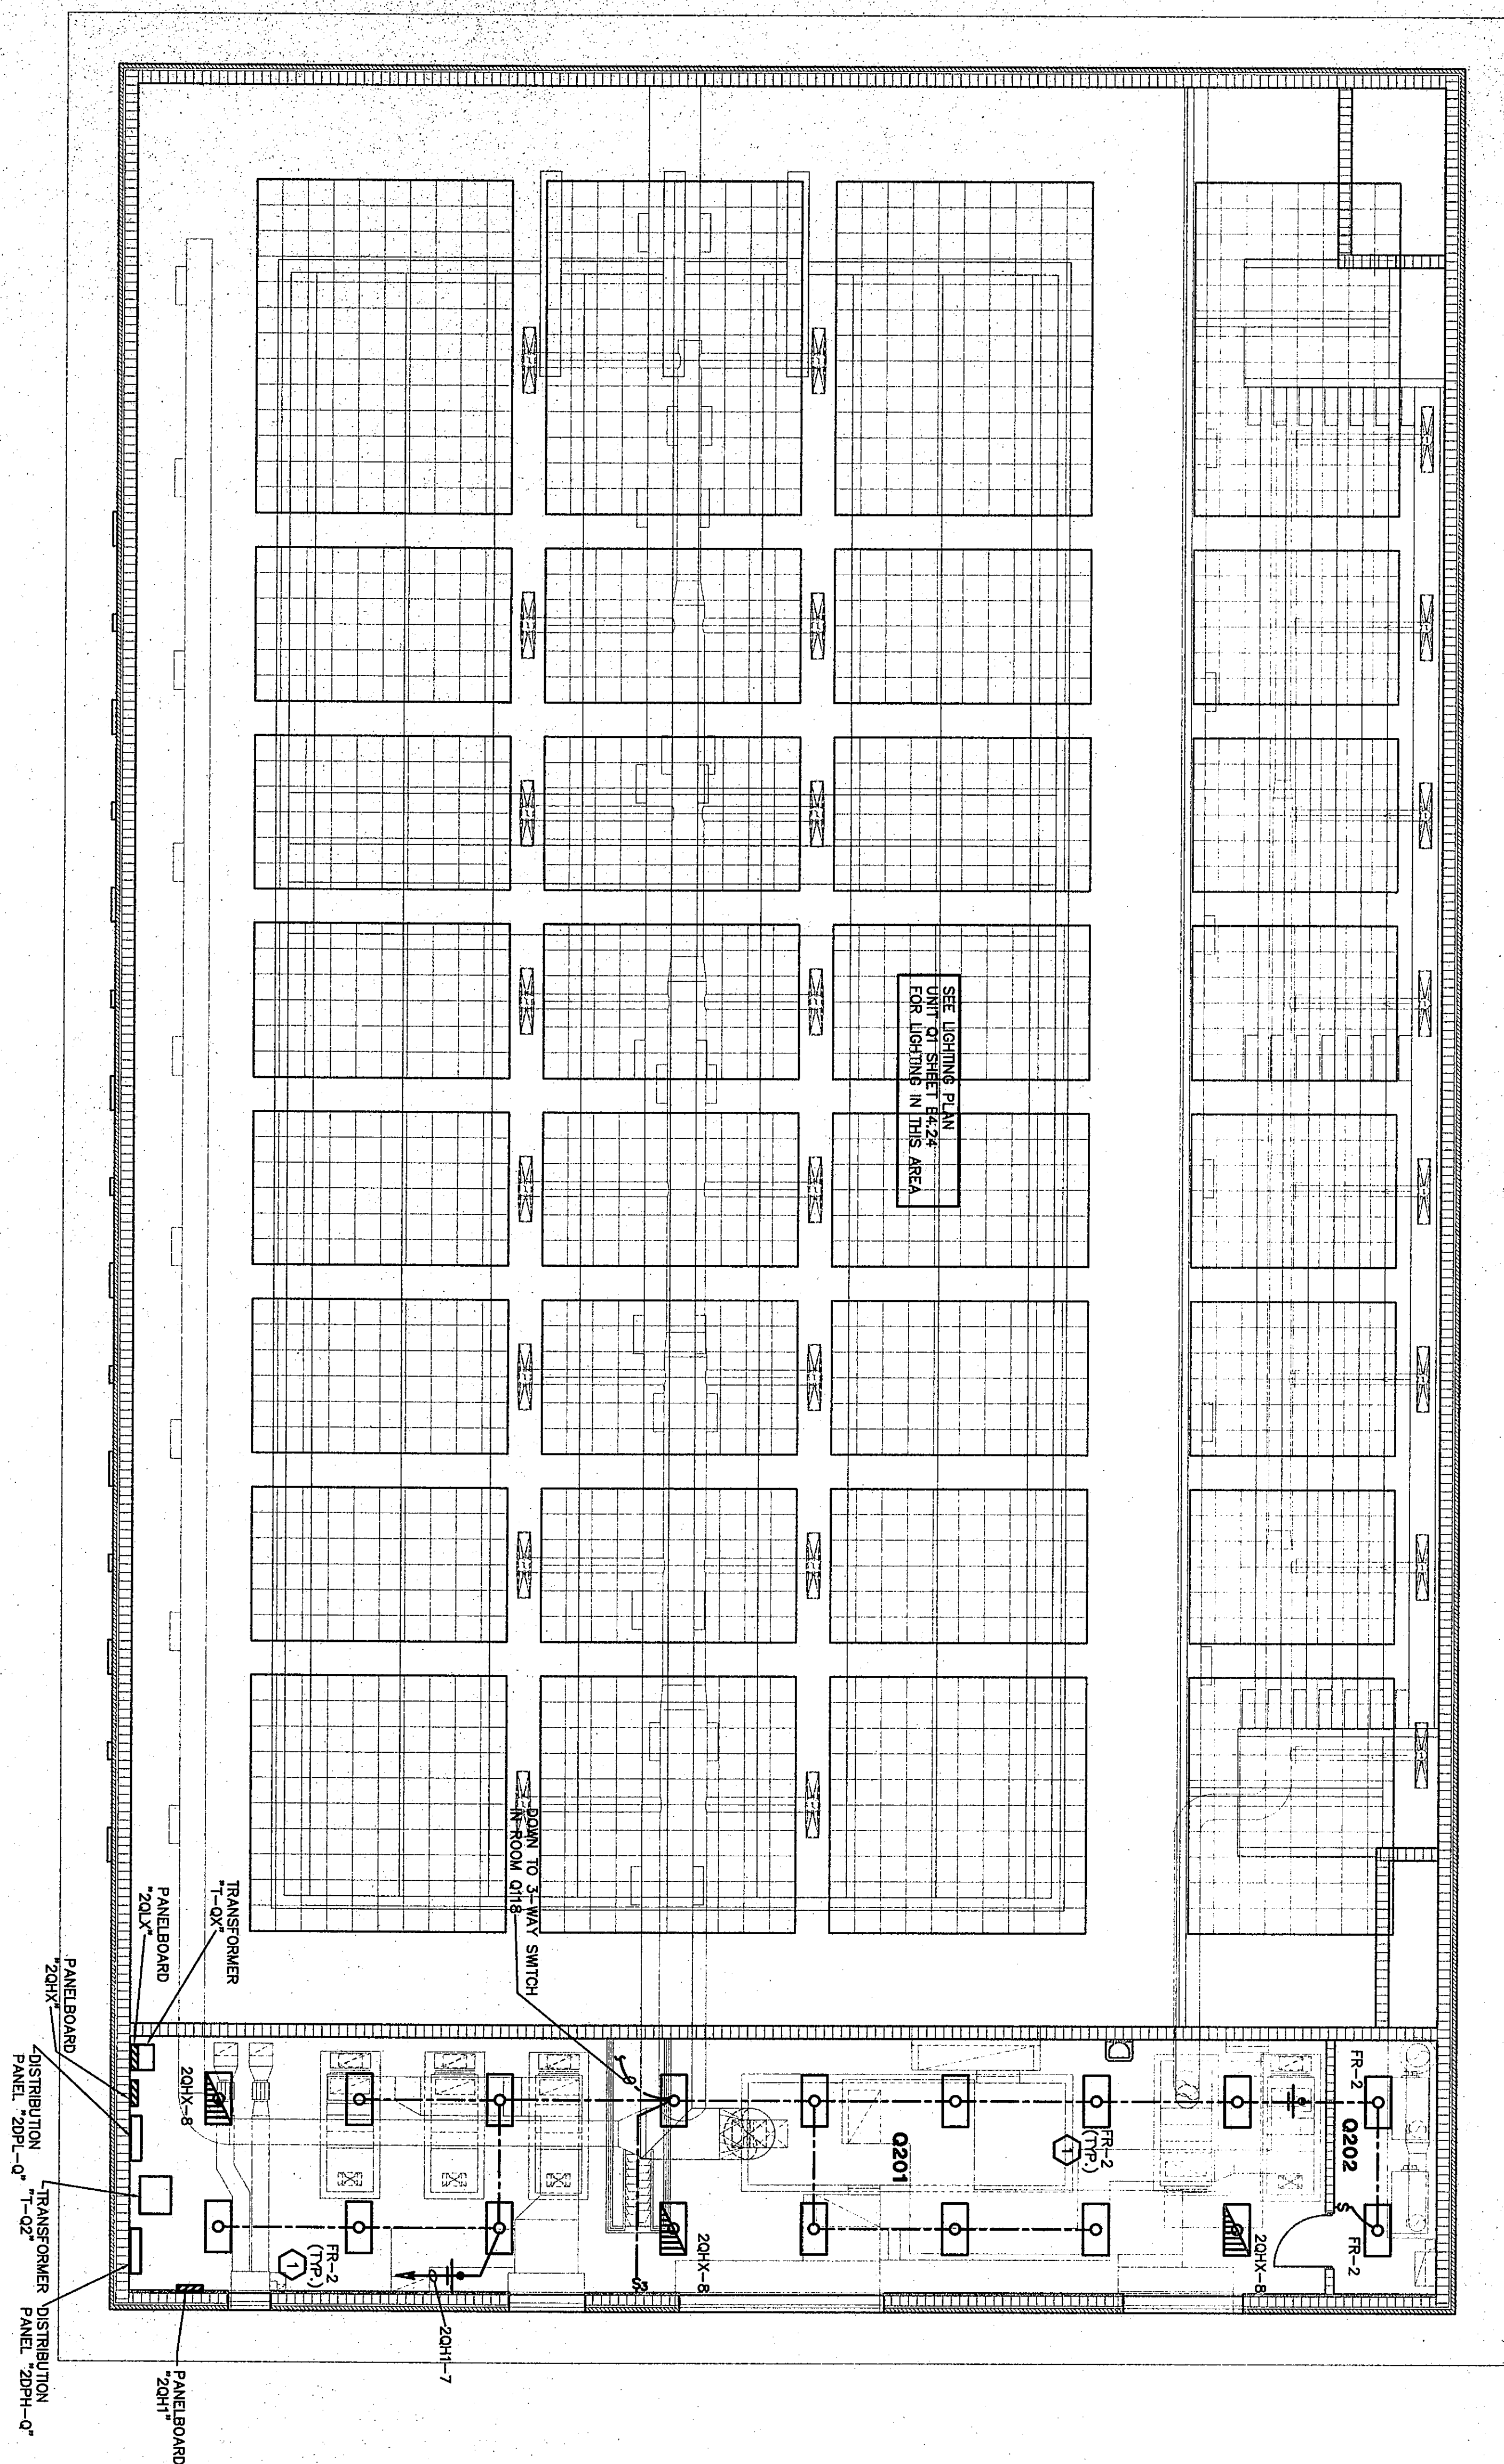

ROOM LEGEND "Q2"

ROOM NAME	AREA S.F.	CEILING HEIGHT
Q201	2043	15'
Q202	159	15'

PLAN NOTES:
1. MOUNT LIGHT FIXTURE TYPE R-2 AT 8'-6" ABOVE FINISH FLOOR. MOUNT LIGHT FIXTURES TO MEET ALL MECHANICAL EQUIPMENT.


02-E-068

LIGHTING PLAN UNIT Q2

DRAWN BY: MRS. COMM. NO.: 95067.00
CHECKED BY: WBH DATE: APRIL 21, 1997

E4.25

REVISIONS NO. DATE

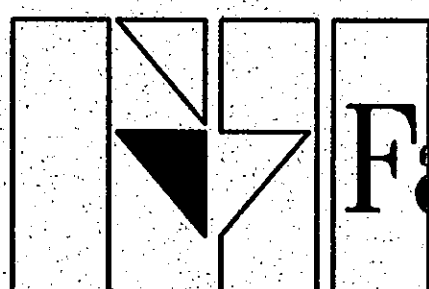

Fanning/Howey
Associates, Inc.
Architects Engineers Consultants



THE NEW
CHESTERTON HIGH SCHOOL
FOR THE
DUNELAND SCHOOL CORPORATION
CHESTERTON, INDIANA

COPYRIGHT 1997 BY FANNING/HOWEY ASSOCIATES, INC.

