
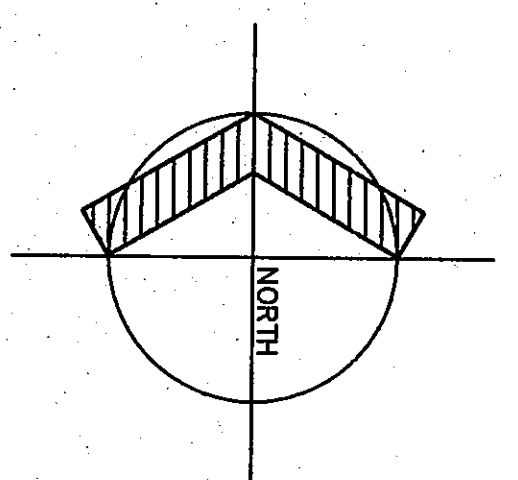


FUTURE ROOF MOUNTED
SATELLITE DISH BY OWNER

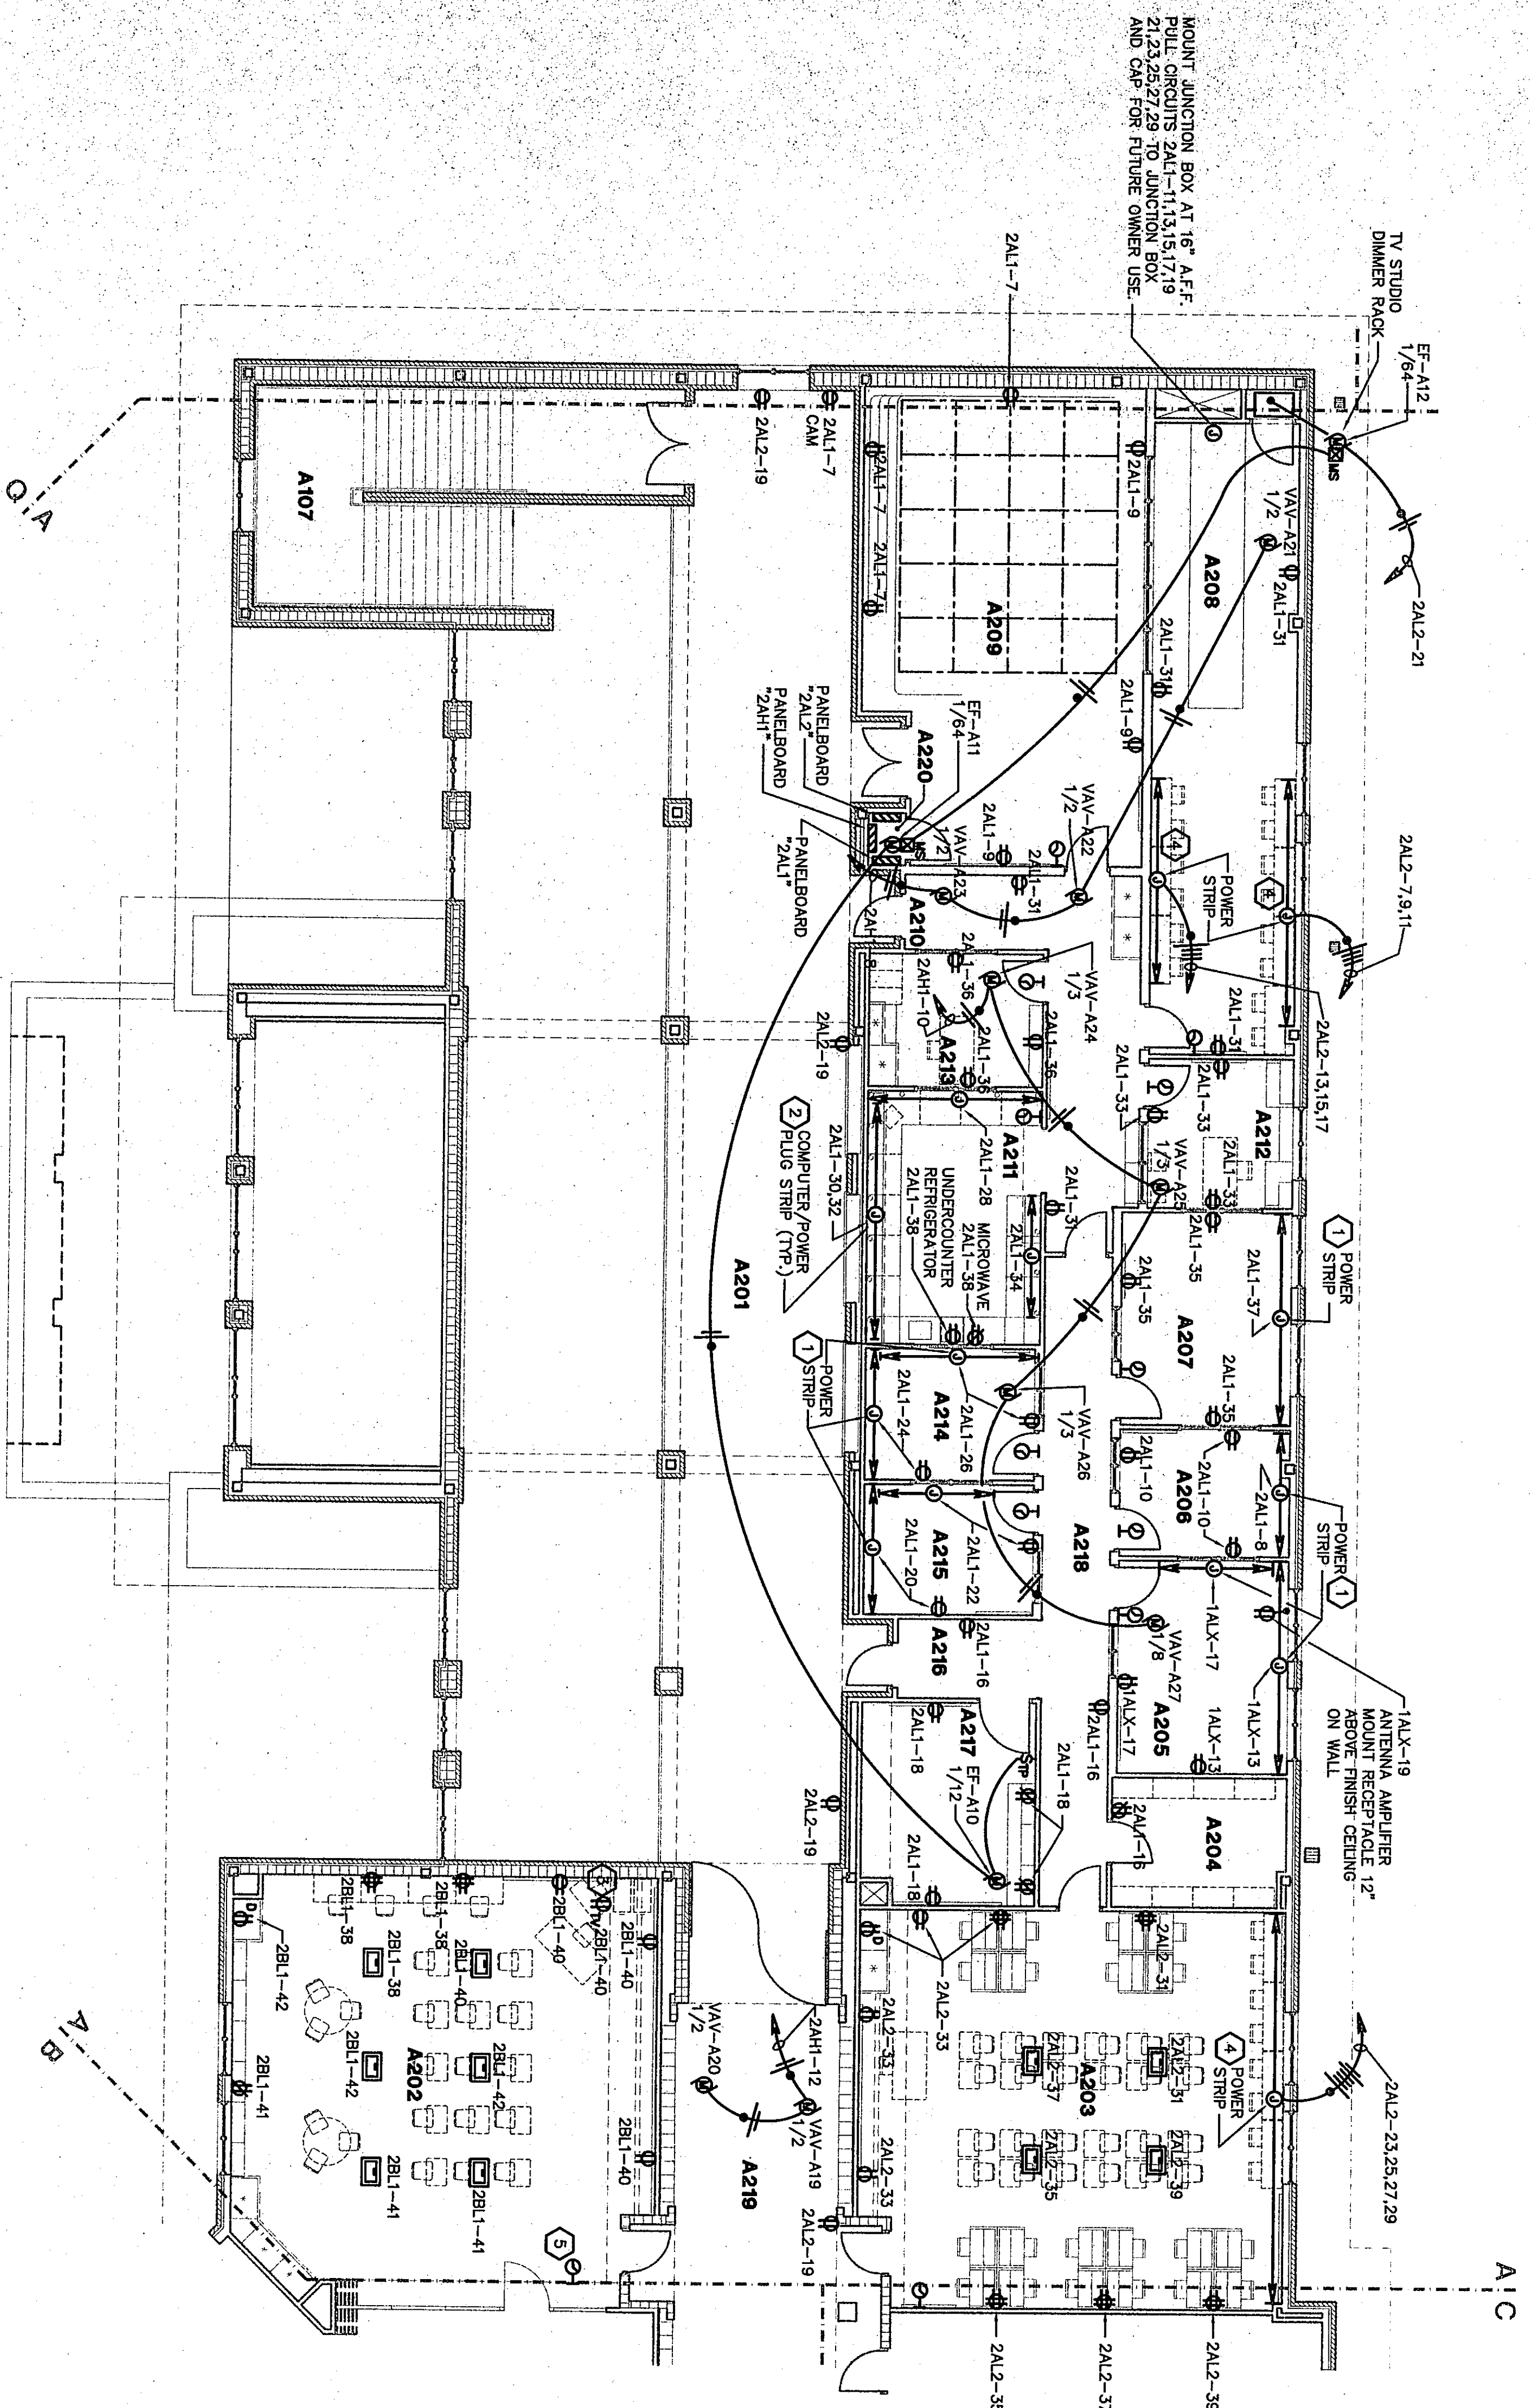

POWER PLAN UNIT A2

SCALE 1/8" = 1'-0"

ROOM LEGEND "A2"			
ROOM NO.	ROOM NAME	AREA SQ. FT.	Ceiling Height
A201	CORRIDOR	1552	9'-4"
A202	CLASSROOM	960	9'-4"
A203	CLASSROOM	902	9'-4"
A204	CLASSROOM	902	9'-4"
A205	CLASSROOM	902	9'-4"
A206	CLASSROOM	902	9'-4"
A207	CLASSROOM	902	9'-4"
A208	CLASSROOM	902	9'-4"
A209	CLASSROOM	902	9'-4"
A210	CLASSROOM	902	9'-4"
A211	TV STUDIO	577	9'-4"
A212	CONTROL ROOM	121	9'-4"
A213	CORRIDOR	125	9'-4"
A214	CORRIDOR	125	9'-4"
A215	CORRIDOR	125	9'-4"
A216	CORRIDOR	125	9'-4"
A217	CORRIDOR	125	9'-4"
A218	CORRIDOR	125	9'-4"
A219	CORRIDOR	125	9'-4"
A220	ELECTRICAL CLOSET	339	10'-0"
A221	ELECTRICAL CLOSET	9	9'-4"
A222	CORRIDOR	183	9'-4"

FLOOR BOXES ARE SHOWN ON
AUXILIARY AND POWER PLANS

PLAN NOTES:

- POWER PLUG STRIP SEE DETAIL 6/E1.6. MOUNT PLUG-STRIP AT 16 INCHES ABOVE FINISH FLOOR.
- COMPUTER/POWER PLUG STRIP SEE DETAIL 5/E1.6 AND 2/E1.10.
- REFER TO VIDEO ROUGH-IN AND TELEVISION RECEPTACLE LOCATION, DETAILS 6/E1.5 AND 9/E1.5 FOR ADDITIONAL INFORMATION.
- POWER PLUG STRIP SEE DETAIL 6/E1.6. MOUNT PLUG STRIP AT 36 INCHES ABOVE FINISH FLOOR.
- MOUNT CLOCK ON BULKHEAD AT 6'-6" ABOVE FINISH FLOOR.
- RUN A 3/4 INCH CONDUIT FROM SATELLITE DISH TO PANELBOARD "2AL2" FOR FUTURE USE.

07-e-70