



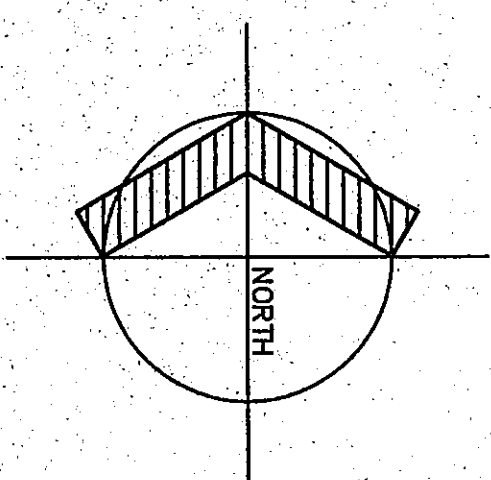

POWER PLAN UNIT B1

SCALE 1/8" = 1'-0"

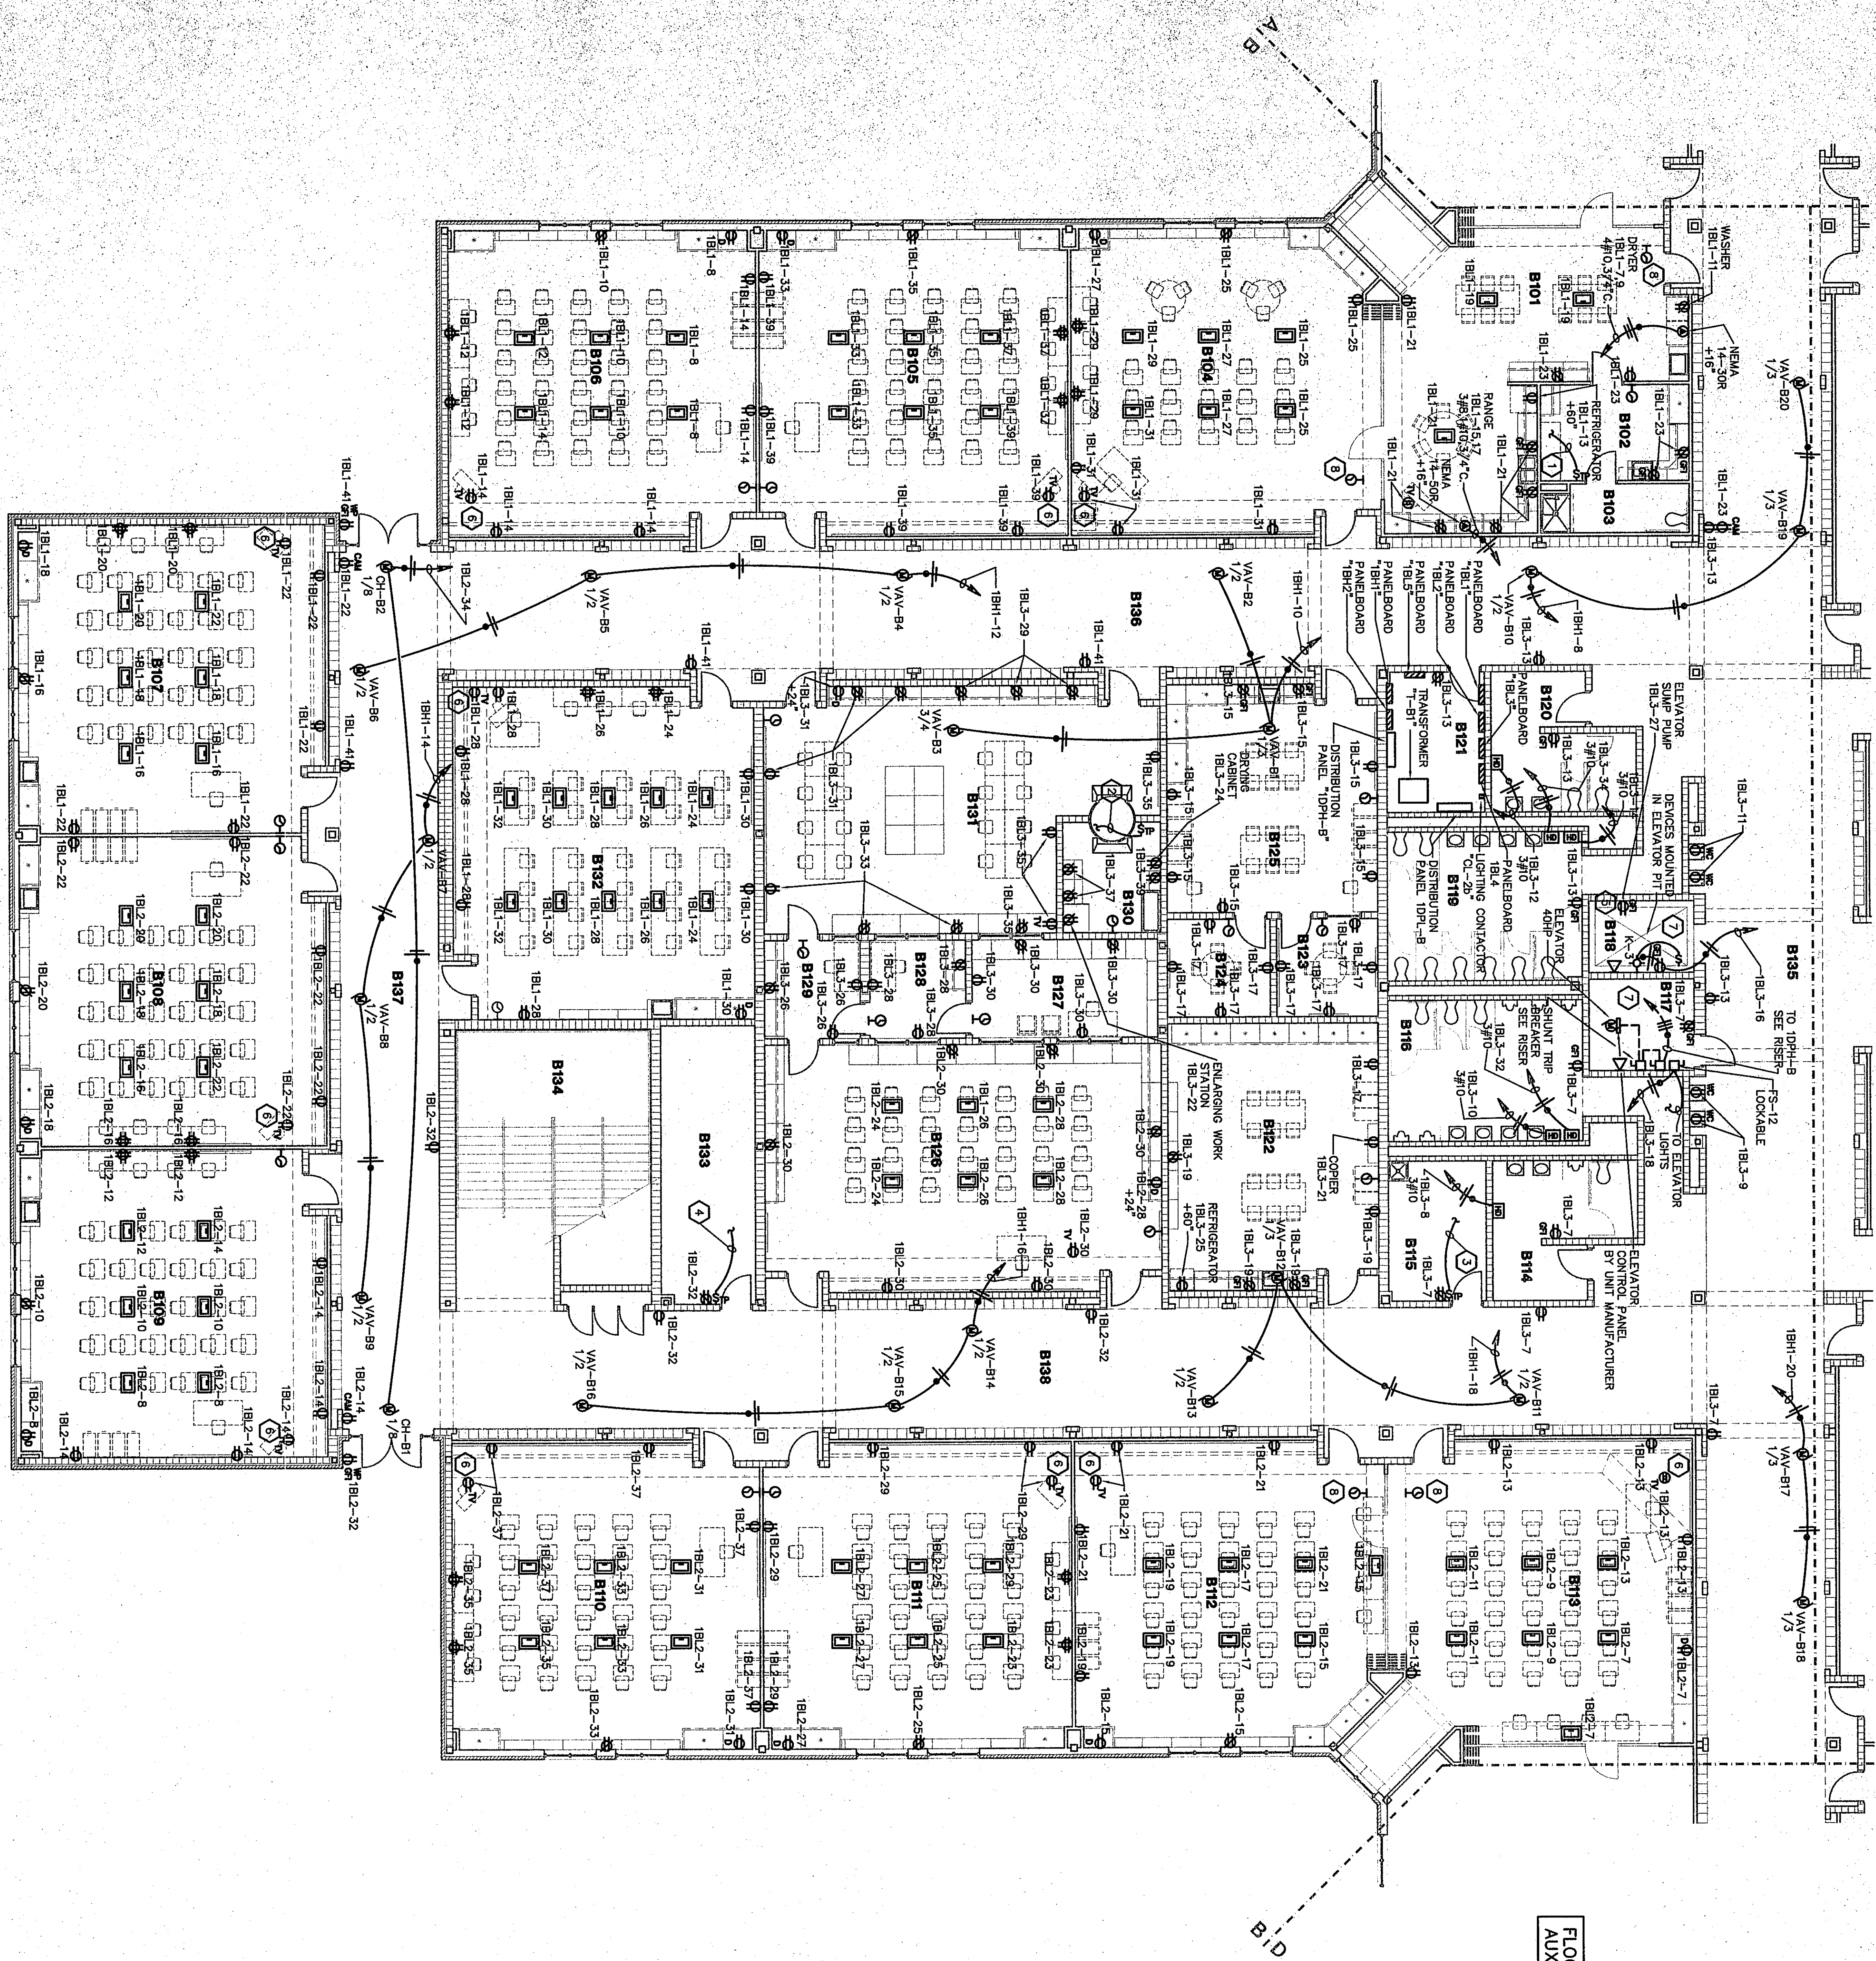

FLOOR BOXES ARE SHOWN ON
AUXILIARY AND POWER PLANS.


PLAN NOTES:

- 1 TO EF-86 IN MEZZANINE B229. SEE POWER PLAN UNIT B2 SHEET ES.4.
- 2 TO EF-813 IN MEZZANINE B229. SEE POWER PLAN UNIT B2 SHEET ES.4.
- 3 TO EF-816 IN MEZZANINE B229. SEE POWER PLAN UNIT B2 SHEET ES.4.
- 4 TO EF-81 IN MEZZANINE B224. SEE POWER PLAN UNIT B2 SHEET ES.4.
- 5 VERIFY EXACT LOCATION OF SLUMP PUMP WITH DIVISION 15.
- 6 REFER TO VIDEO ROOM-IN AND TELEVISION RECEPTION LOCATION, DETAILS 6/E15 AND 9/E15 FOR ADDITIONAL INFORMATION.
- 7 VERIFY EXACT LOCATION OF ALL DEVICES IN ELEVATOR PIT AND CONTROL ROOM WITH MANUFACTURER BEFORE ROUGH-IN.
- 8 MOUNT CLOCK ON BULKHEAD AT 8'-6" ABOVE FINISH FLOOR.


ROOM LEGEND "B1"

ROOM NO.	ROOM NAME	AREA S.F.	CEILING HEIGHT
B101	LIFE SHULS	753	9'-4"
B102	HEALTH TOWEL	729	9'-4"
B103	CLASSROOM	959	9'-4"
B104	CLASSROOM	959	9'-4"
B105	CLASSROOM	959	9'-4"
B106	CLASSROOM	959	9'-4"
B107	CLASSROOM	959	9'-4"
B108	CLASSROOM	959	9'-4"
B109	CLASSROOM	959	9'-4"
B110	CLASSROOM	959	9'-4"
B111	CLASSROOM	959	9'-4"
B112	CLASSROOM	959	9'-4"
B113	CLASSROOM	959	9'-4"
B114	CLASSROOM	959	9'-4"
B115	CLASSROOM	959	9'-4"
B116	CLASSROOM	959	9'-4"
B117	CLASSROOM	959	9'-4"
B118	CLASSROOM	959	9'-4"
B119	CLASSROOM	959	9'-4"
B120	CLASSROOM	959	9'-4"
B121	CLASSROOM	959	9'-4"
B122	CLASSROOM	959	9'-4"
B123	CLASSROOM	959	9'-4"
B124	CLASSROOM	959	9'-4"
B125	CLASSROOM	959	9'-4"
B126	CLASSROOM	959	9'-4"
B127	CLASSROOM	959	9'-4"
B128	CLASSROOM	959	9'-4"
B129	CLASSROOM	959	9'-4"
B130	CLASSROOM	959	9'-4"
B131	CLASSROOM	959	9'-4"
B132	CLASSROOM	959	9'-4"
B133	CLASSROOM	959	9'-4"
B134	CLASSROOM	959	9'-4"
B135	CLASSROOM	959	9'-4"
B136	CLASSROOM	959	9'-4"

THE NEW
CHESTERTON HIGH SCHOOL
FOR THE
DUNELAND SCHOOL CORPORATION
CHESTERTON, INDIANA

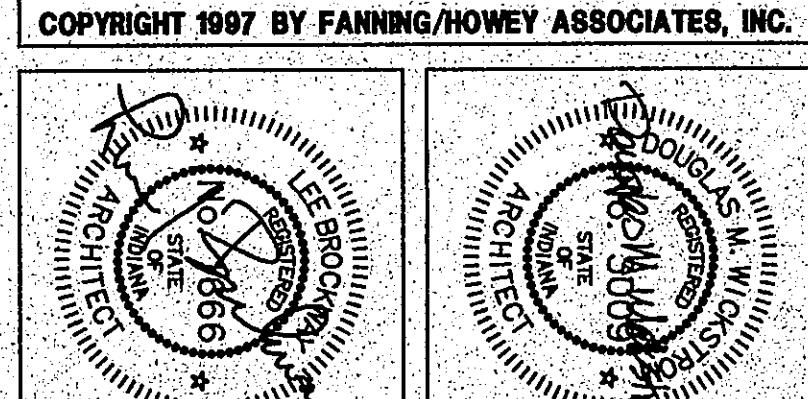

Fanning/Howey Associates, Inc.
Architects Engineers Consultants

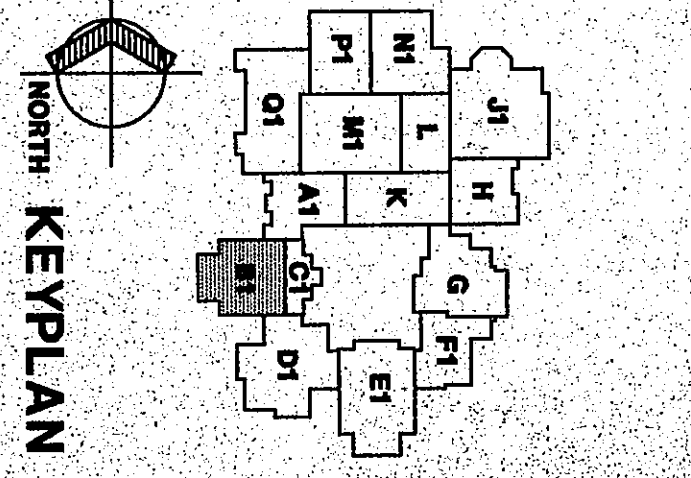

POWER PLAN UNIT B1

DRAWN BY: MRS. COMM. NO.: 95067.00
CHECKED BY: WBH DATE: APRIL 21, 1997

E5.3

REVISIONS NO. DATE