



35

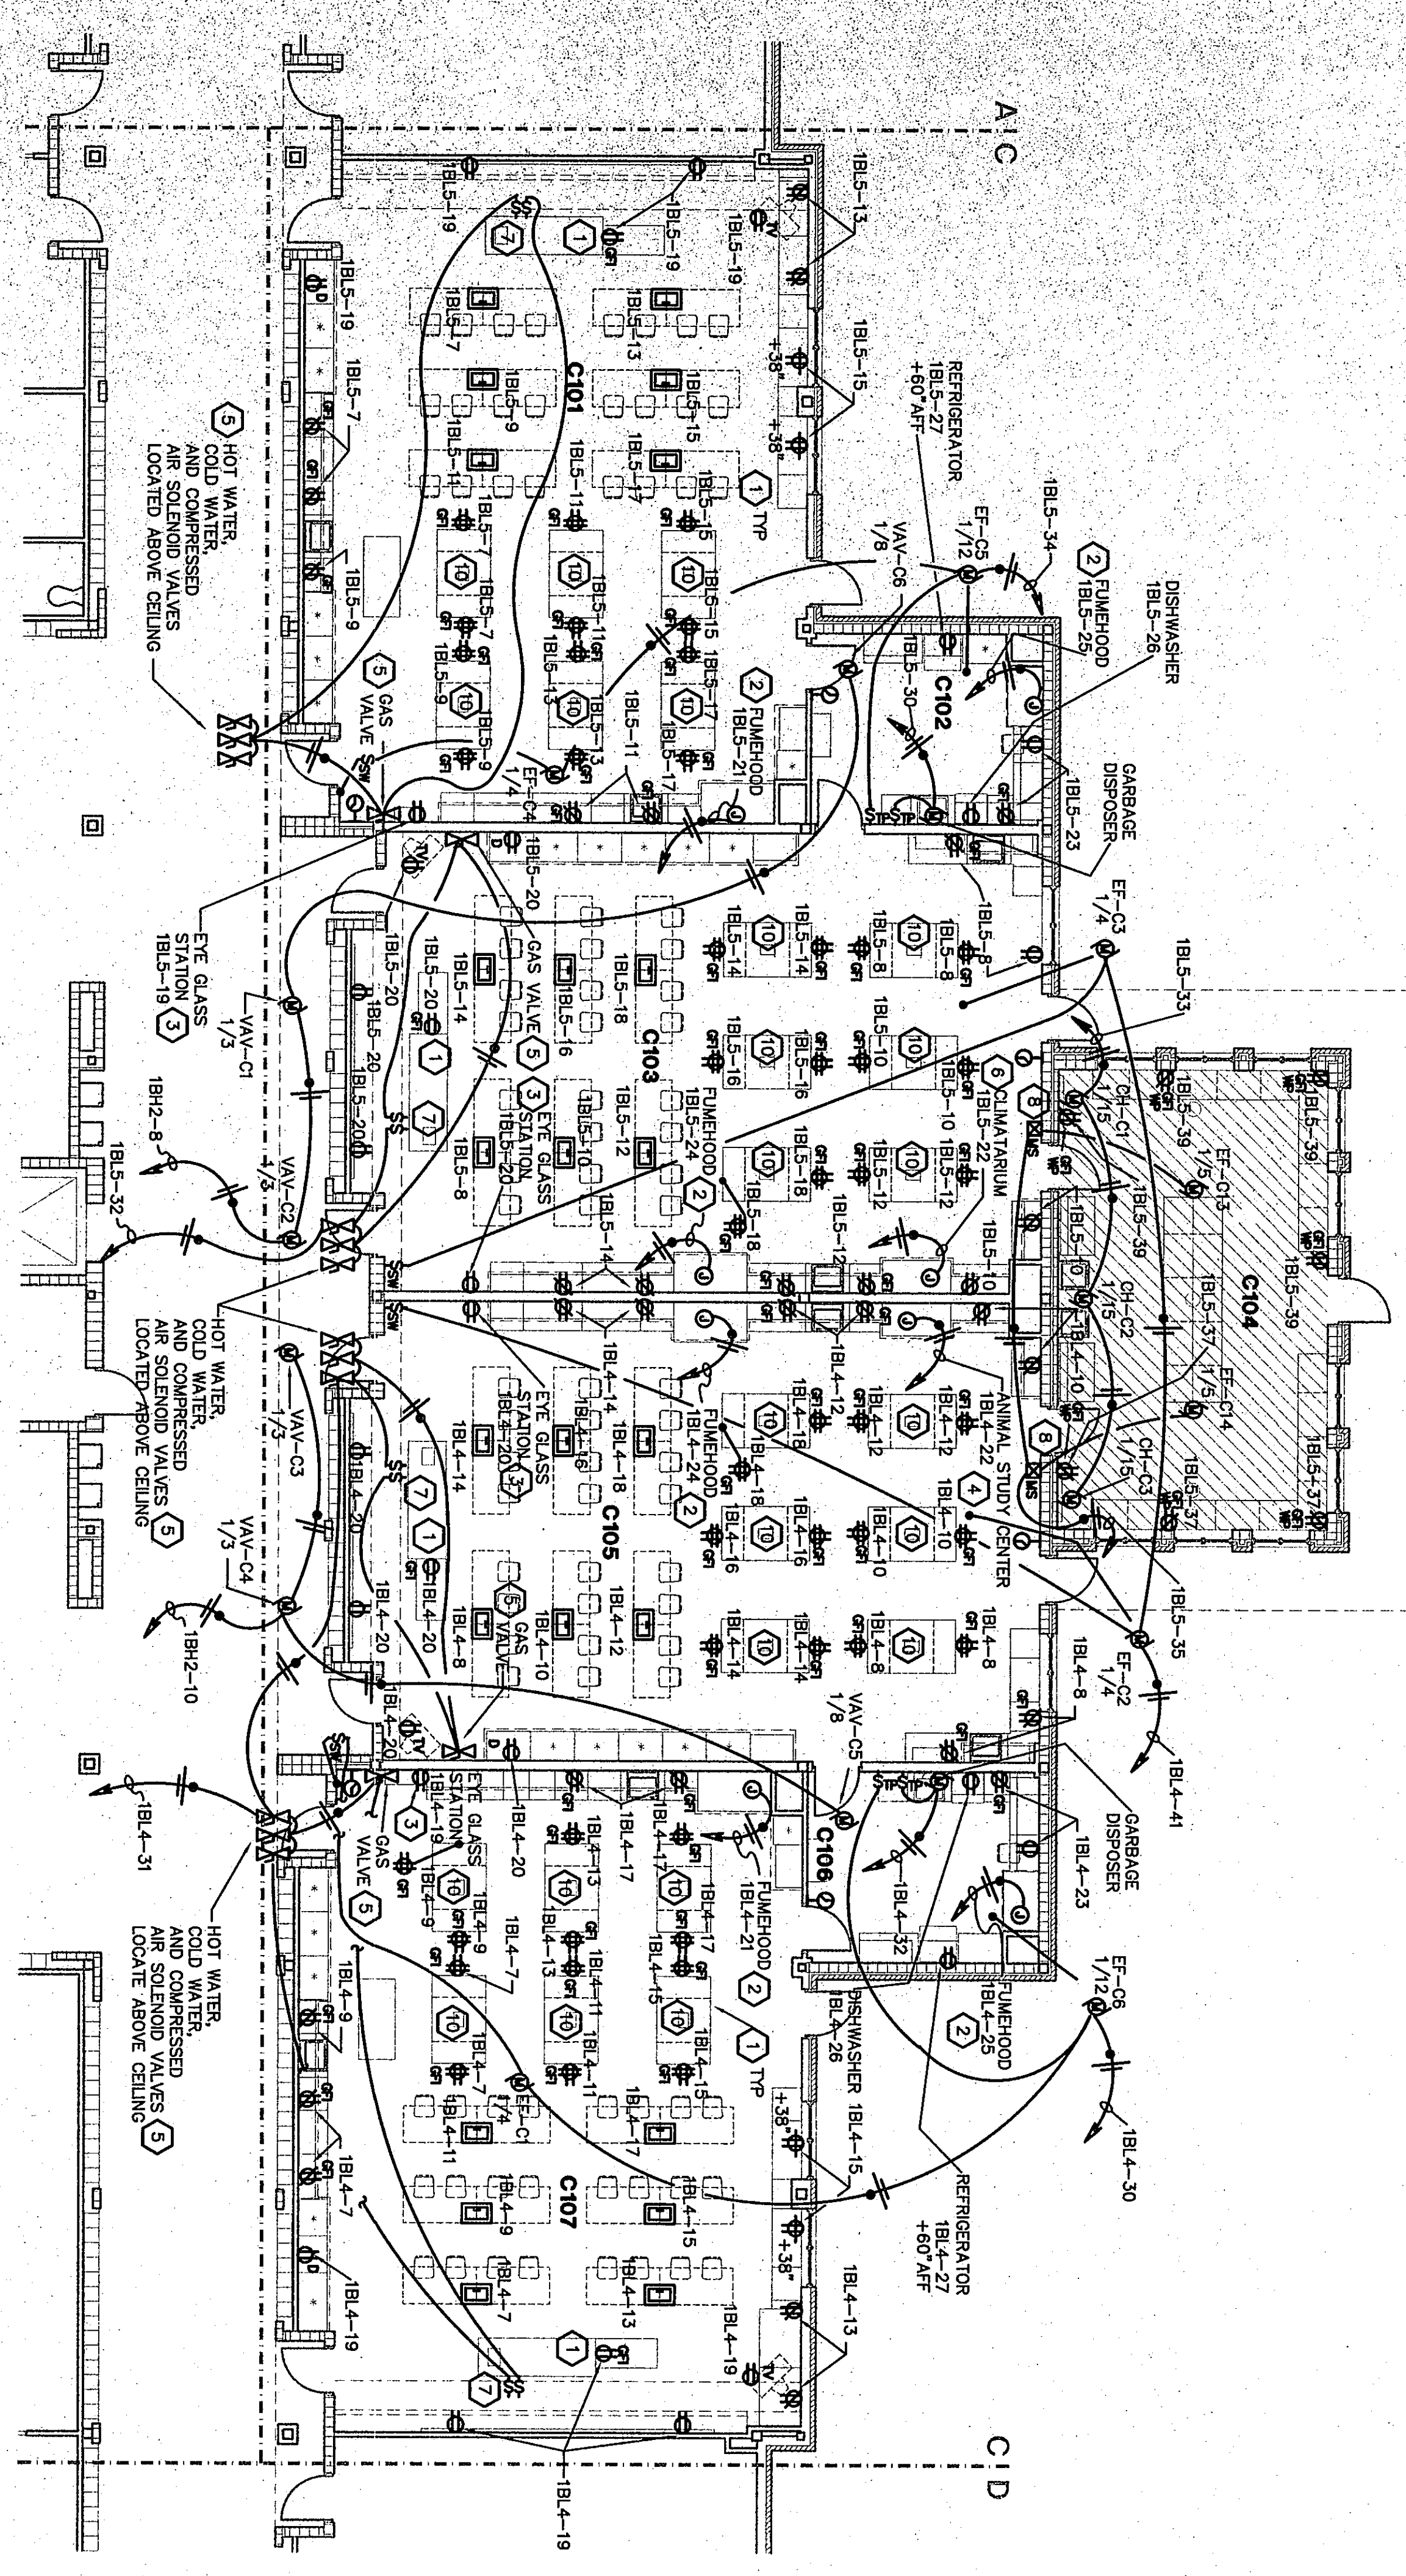

POWER PLAN UNIT C1

SCALE: 1/8" = 1'-0"

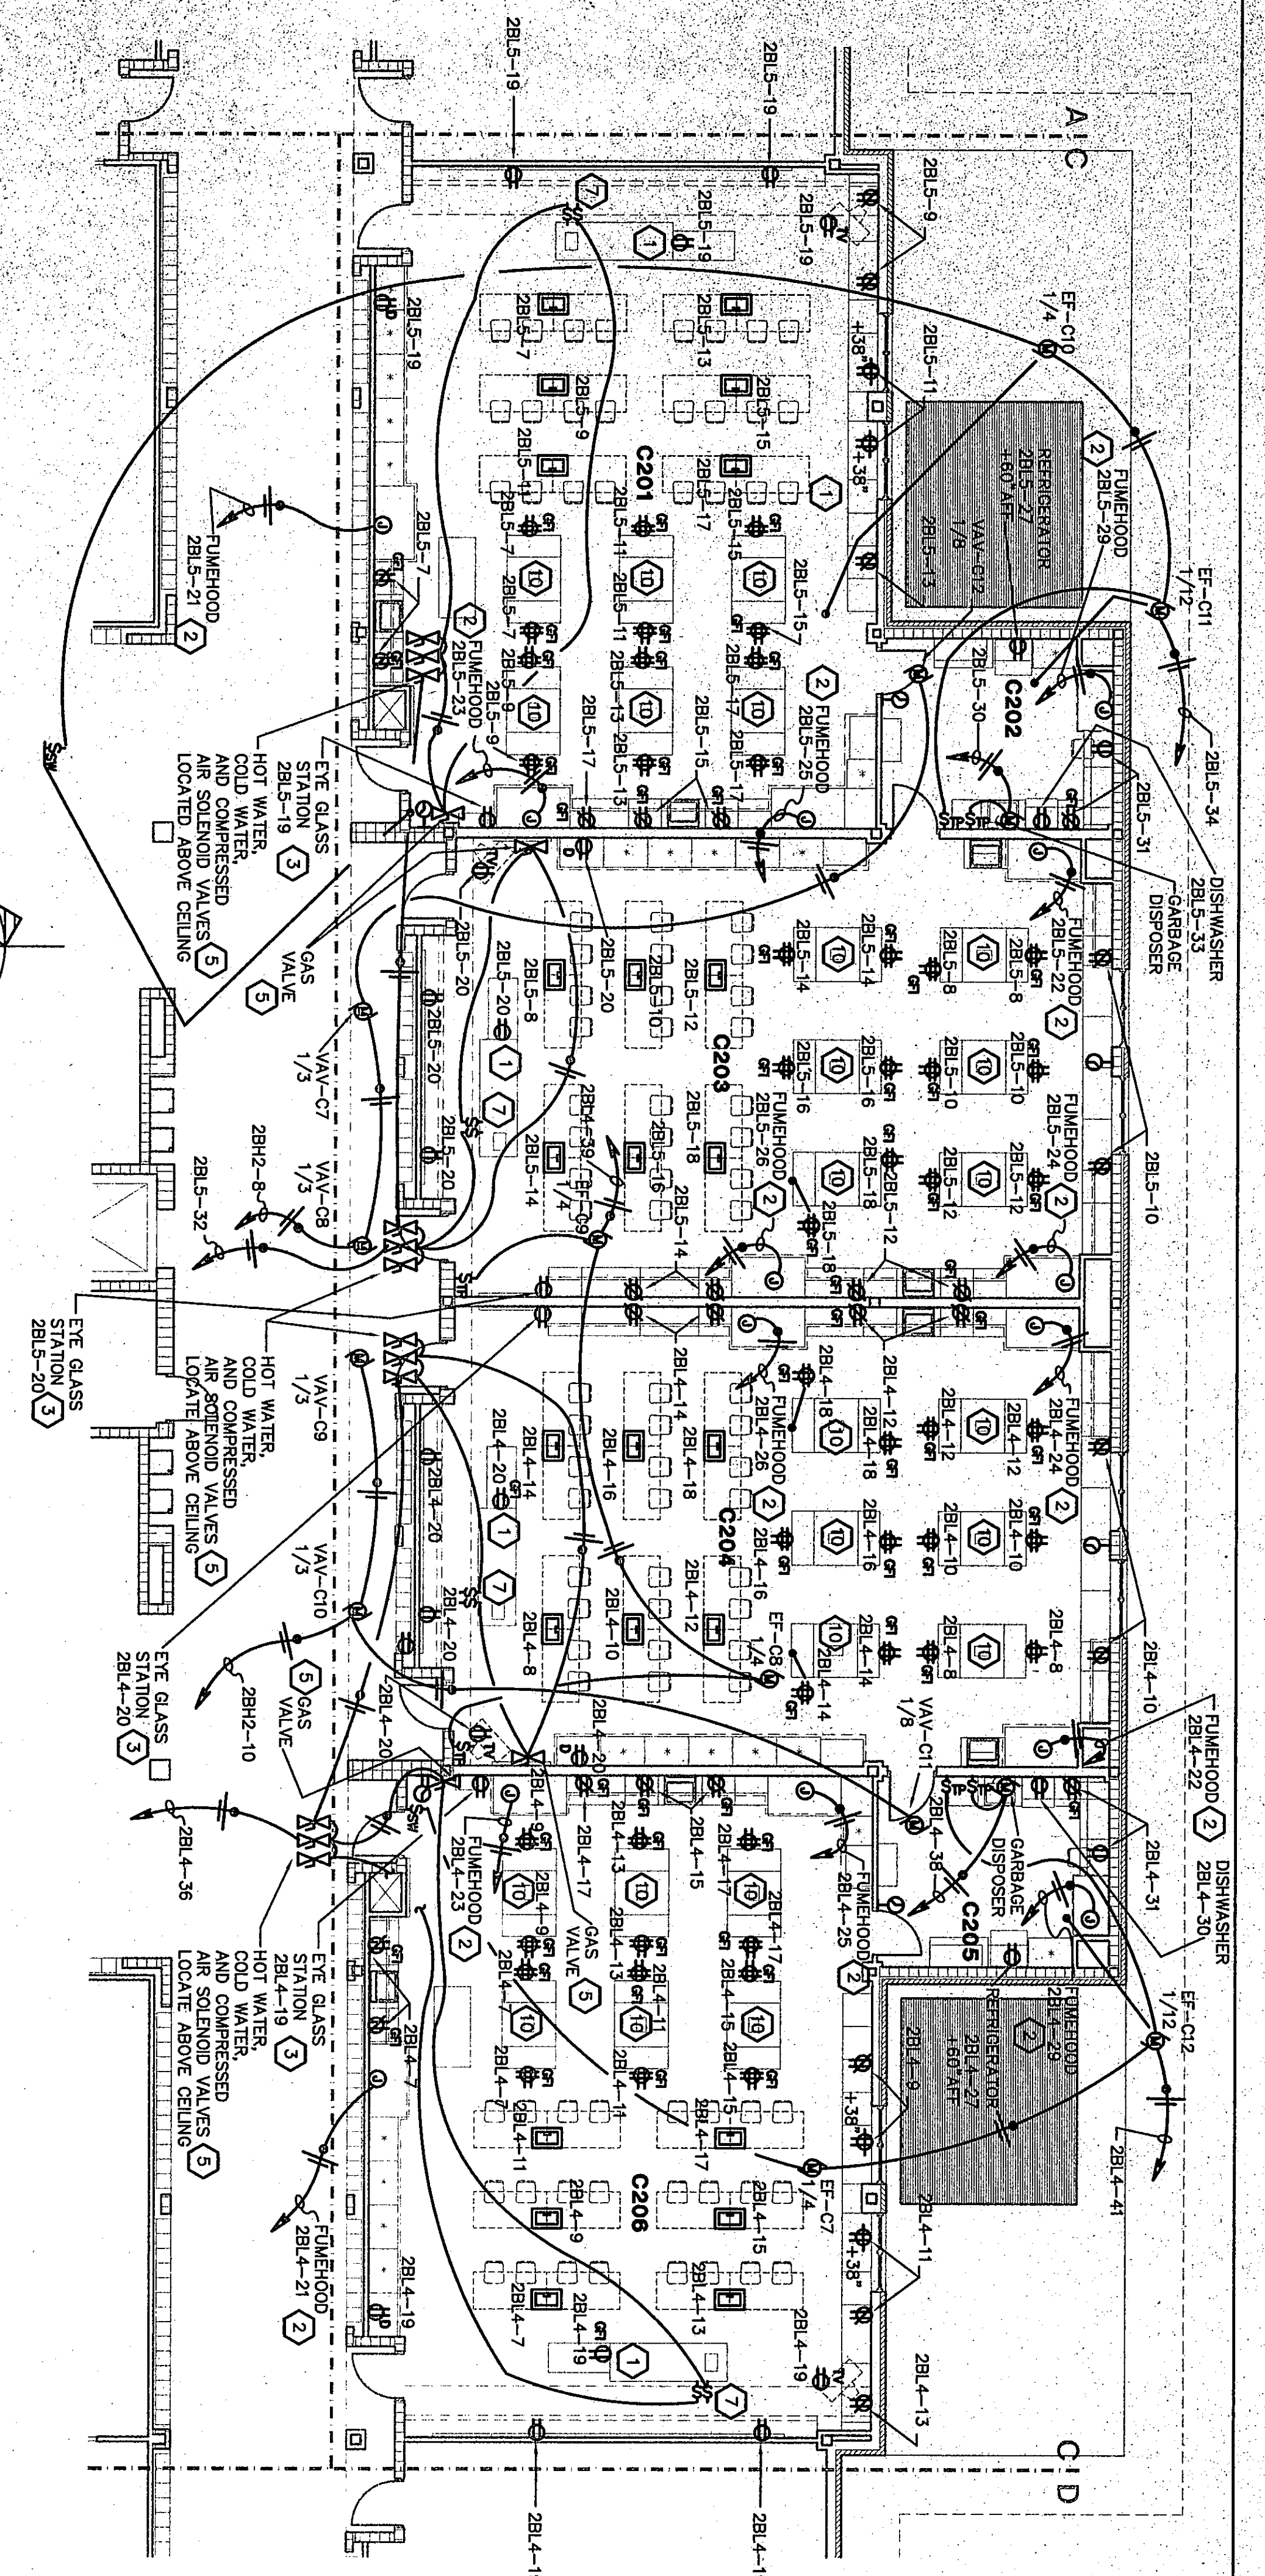

POWER PLAN UNIT C2

SCALE: 1/8" = 1'-0"

PLAN NOTES:

1. DUPLEX RECEPTACLE LOCATED IN CASEWORK, CASEWORK MANUFACTURER TO LOCATE AND CUT OUT FOR ELECTRICAL TRUCK BOX. VERIFY EXACT LOCATION OF RECEPTACLE IN THE FIELD. SEE DETAIL 4/6/11.
2. FLOOR HOOD LIGHT FIXTURE, LIGHT SWITCH, FAN AND EXHAUST FAN. SEE DETAIL 4/6/11.
3. VERIFY EXACT LOCATION OF POWER RECEPTACLE FOR EYE HEATING UNIT, ETC. BY UNIT MANUFACTURER. DIVISION 16 TO WIRE EACH PIECE OF EQUIPMENT.
4. SOLID VALVE PROVIDED BY DIVISION 15, WIRING BY DIVISION 16. VERIFY LOCATION IN FIELD BEFORE ROUGH-IN.
5. CLIMATE CENTER LIGHT FIXTURE, LIGHT SWITCH, FAN, WIRE EACH PIECE OF EQUIPMENT.
6. CLIMATE CENTER LIGHT FIXTURE, LIGHT SWITCH, FAN, WIRE EACH PIECE OF EQUIPMENT.
7. MOUNT SWITCHES TO CONTROL SOLID VALVES IN TEACHER CLASSROOM CEILING.
8. MOUNT SWITCHES FOR GREENHOUSE EXHAUST FAN 12' ABOVE CLASSROOM CEILING.
9. ALL CONDUIT RUN IN GREENHOUSE THAT IS NOT CONCEALED IN WALL IS TO BE PVC OR SEAL-100.
10. DUPLEX RECEPTACLE LOCATED IN CASEWORK, CASEWORK MANUFACTURER TO LOCATE AND CUT OUT FOR ELECTRICAL TRUCK BOX. VERIFY EXACT LOCATION OF RECEPTACLE IN THE FIELD. SEE DETAIL 4/6/11.

FLOOR BOXES ARE SHOWN ON AUXILIARY AND POWER PLANS.

ROOM LEGEND "C2"


ROOM NO.	ROOM NAME	AREA S.F.	CEILING HEIGHT
C201	SCIENCE LAB	1509	VARIABLE
C202	SCIENCE LAB	1456	VARIABLE
C203	SCIENCE LAB	1436	VARIABLE
C204	SCIENCE LAB	200	VARIABLE
C205	SCIENCE LAB	1835	VARIABLE

ROOM LEGEND "C1"

ROOM NO.	ROOM NAME	AREA S.F.	CEILING HEIGHT
C101	SCIENCE LAB	1509	VARIABLE
C102	SCIENCE LAB	1456	VARIABLE
C103	SCIENCE LAB	1436	VARIABLE
C104	SCIENCE LAB	200	VARIABLE
C105	SCIENCE LAB	1835	VARIABLE

07-E-23

Fanning/Howey Associates, Inc.
Architects Engineers Consultants

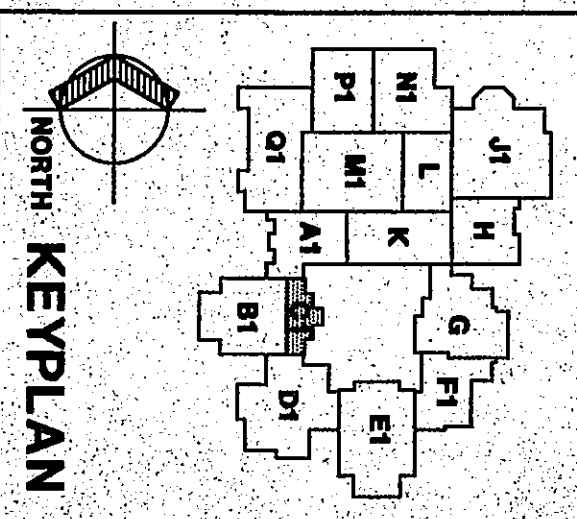

THE NEW
CHESTERTON HIGH SCHOOL
FOR THE
DUNELAND SCHOOL CORPORATION
CHESTERTON, INDIANA

Copyright 1997 by Fanning/Howey Associates, Inc.

POWER PLAN UNIT C1,C2

DRAWN BY: MRS. COMM. NO. 95067.00
CHECKED BY: WBH DATE: APRIL 21, 1997

REVISIONS NO. DATE

E5.5

CHESTERTON HIGH SCHOOL
05/05/95