


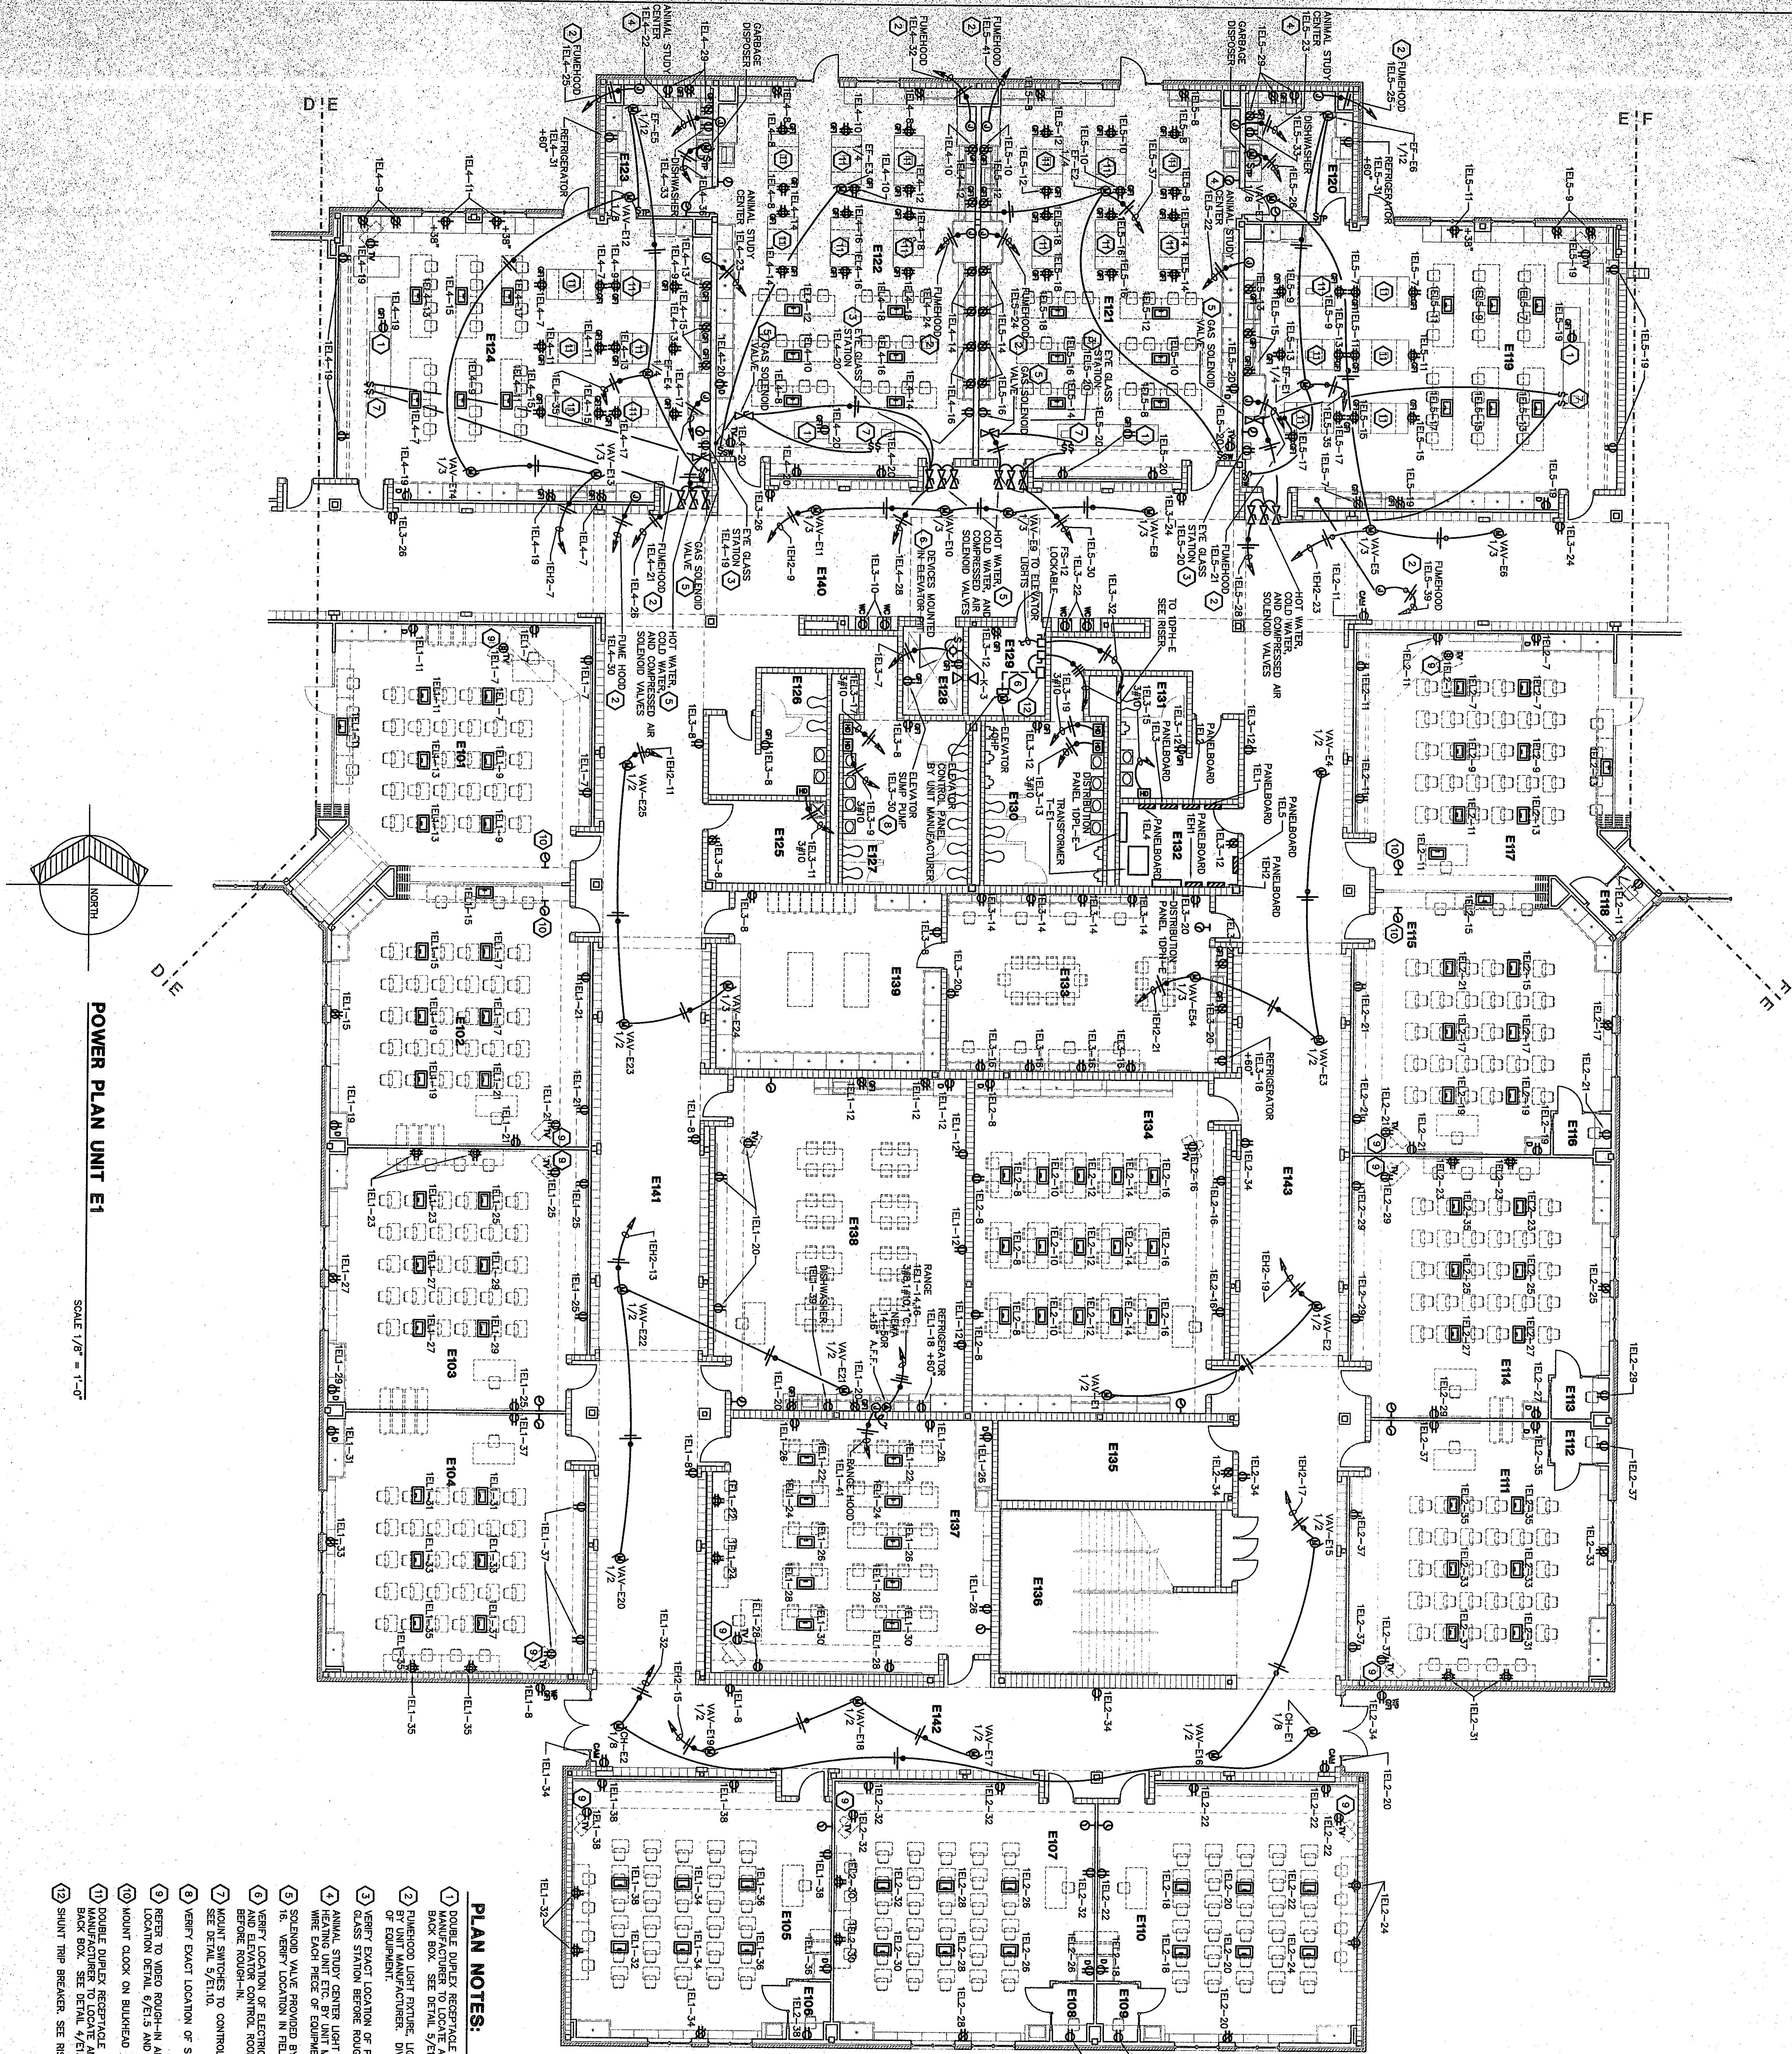

POWER PLAN UNIT E1

SCALE 1/8" = 1'-0"

PLAN NOTES:

- ① DOUBLE DUPLEX RECEPTACLE LOCATED IN CASKWORK, CASKWORK MANUFACTURER TO LOCATE AND CUT OUT FOR ELECTRICAL BACK BOX. SEE DETAIL 5/ET/10.
- ② PUMPHOOD LIGHT FIXTURE, LIGHT SWITCH, F.M., AND RECEPTACLE BY UNIT MANUFACTURER. DIVISION 16 TO WIRE EACH PIECE OF EQUIPMENT.
- ③ VERIFY EXACT LOCATION OF POWER RECEPTACLE FOR EYE GLASS STATION BEFORE ROUGH-IN.
- ④ ANNUAL STUDY CENTER LIGHT FIXTURE, LIGHT SWITCH, F.M., HEATING UNIT CTR. BY UNIT MANUFACTURER. DIVISION 16 TO WIRE EACH PIECE OF EQUIPMENT.
- ⑤ SLOTTED VALVE ARE PROVIDED BY DIVISION 15, WIRED BY DIVISION 16. VERIFY LOCATION IN FIELD BEFORE ROUGH-IN.
- ⑥ VERIFY LOCATION OF ELECTRICAL EQUIPMENT IN ELEVATOR PIT AND ELEVATOR CONTROL ROOM, WITH ELEVATOR MANUFACTURER BEFORE ROUGH-IN.
- ⑦ MOUNT SWITCHES TO CONTROL SLOTTED VALVES IN CABINET BASE. SEE DETAIL 5/ET/10.
- ⑧ VERIFY EXACT LOCATION OF SLUMP PUMP WITH DIVISION 15.
- ⑨ REFER TO VIDEO ROUGH-IN AND TELEVISION RECEPTACLE LOCATION DETAIL 6/ET/5 AND 9/ET/5 FOR ADDITIONAL INFORMATION.
- ⑩ MOUNT CLOCK ON BLURRED AT 6'-6" ABOVE FINISH FLOOR.
- ⑪ DOUBLE DUPLEX RECEPTACLE LOCATED IN CASKWORK, CASKWORK MANUFACTURER TO LOCATE AND CUT OUT FOR ELECTRICAL BACK BOX. SEE DETAIL 5/ET/10.
- ⑫ SHUNT TRIP BREAKER, SEE RISER.

ROOM LEGEND "E1"

ROOM	ROOM NAME	AREA	CEILING
E101	CLASSROOM	866	9'-6"
E102	CLASSROOM	866	9'-6"
E103	CLASSROOM	972	9'-6"
E104	CLASSROOM	967	9'-6"
E105	CLASSROOM	967	9'-6"
E106	RECORDING ROOM	33	9'-6"
E107	RECORDING ROOM	33	9'-6"
E108	RECORDING ROOM	33	9'-6"
E109	RECORDING ROOM	33	9'-6"
E110	CLASSROOM	929	9'-6"
E111	CLASSROOM	929	9'-6"
E112	RECORDING ROOM	33	9'-6"
E113	RECORDING ROOM	33	9'-6"
E114	CLASSROOM	821	9'-6"
E115	CLASSROOM	821	9'-6"
E116	RECORDING ROOM	35	9'-6"
E117	RECORDING ROOM	35	9'-6"
E118	RECORDING ROOM	35	9'-6"
E119	SCIENCE LAB	1512	9'-6"
E120	SCIENCE LAB	1427	9'-6"
E121	SCIENCE LAB	1427	9'-6"
E122	SCIENCE LAB	1437	9'-6"
E123	SCIENCE LAB	1437	9'-6"
E124	SCIENCE LAB	1400	9'-6"
E125	GAZ. TOILET	143	9'-6"
E126	GAZ. TOILET	177	9'-6"
E127	ELEVATOR	79	9'-6"
E128	ELEVATOR	79	9'-6"
E129	ELEVATOR EQUIPMENT	33	9'-6"
E130	ELEVATOR EQUIPMENT	33	9'-6"
E131	DIATRICAL CLOSET	147	9'-6"
E132	DIATRICAL CLOSET	147	9'-6"
E133	STORAGE ROOM	177	9'-6"
E134	STORAGE ROOM	1203	9'-6"
E135	STORAGE ROOM	271	9'-6"
E136	STORAGE ROOM	1018	9'-6"
E137	STORAGE ROOM	1203	9'-6"
E138	STORAGE ROOM	1203	9'-6"
E139	STORAGE ROOM	1203	9'-6"
E140	STORAGE ROOM	2238	10'-0"
E141	CORRIDOR	1826	10'-0"
E142	CORRIDOR	1826	10'-0"
E143	CORRIDOR	1603	10'-0"


**FLOOR BOXES ARE SHOWN ON
AUXILIARY AND POWER PLANS.**

POWER PLAN UNIT E1


DRAWN BY: MRS	COMM. NO.: 95067.00
CHECKED BY: WBH	DATE: APRIL 21, 1997

E5.8

REVISIONS	NO.	DATE
-----------	-----	------

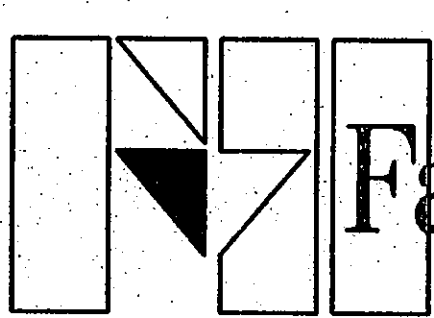

Fanning/Howey
Associates, Inc.
Engineers Consultants

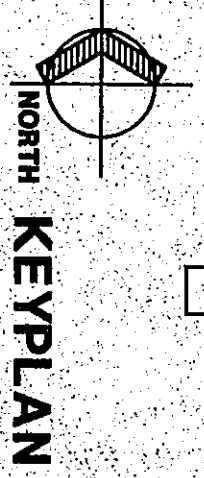

**THE NEW
CHESTERTON HIGH SCHOOL
FOR THE
DUNELAND SCHOOL CORPORATION
CHESTERTON, INDIANA**

COPYRIGHT 1997 BY FANNING/HOWEY ASSOCIATES, INC.

