



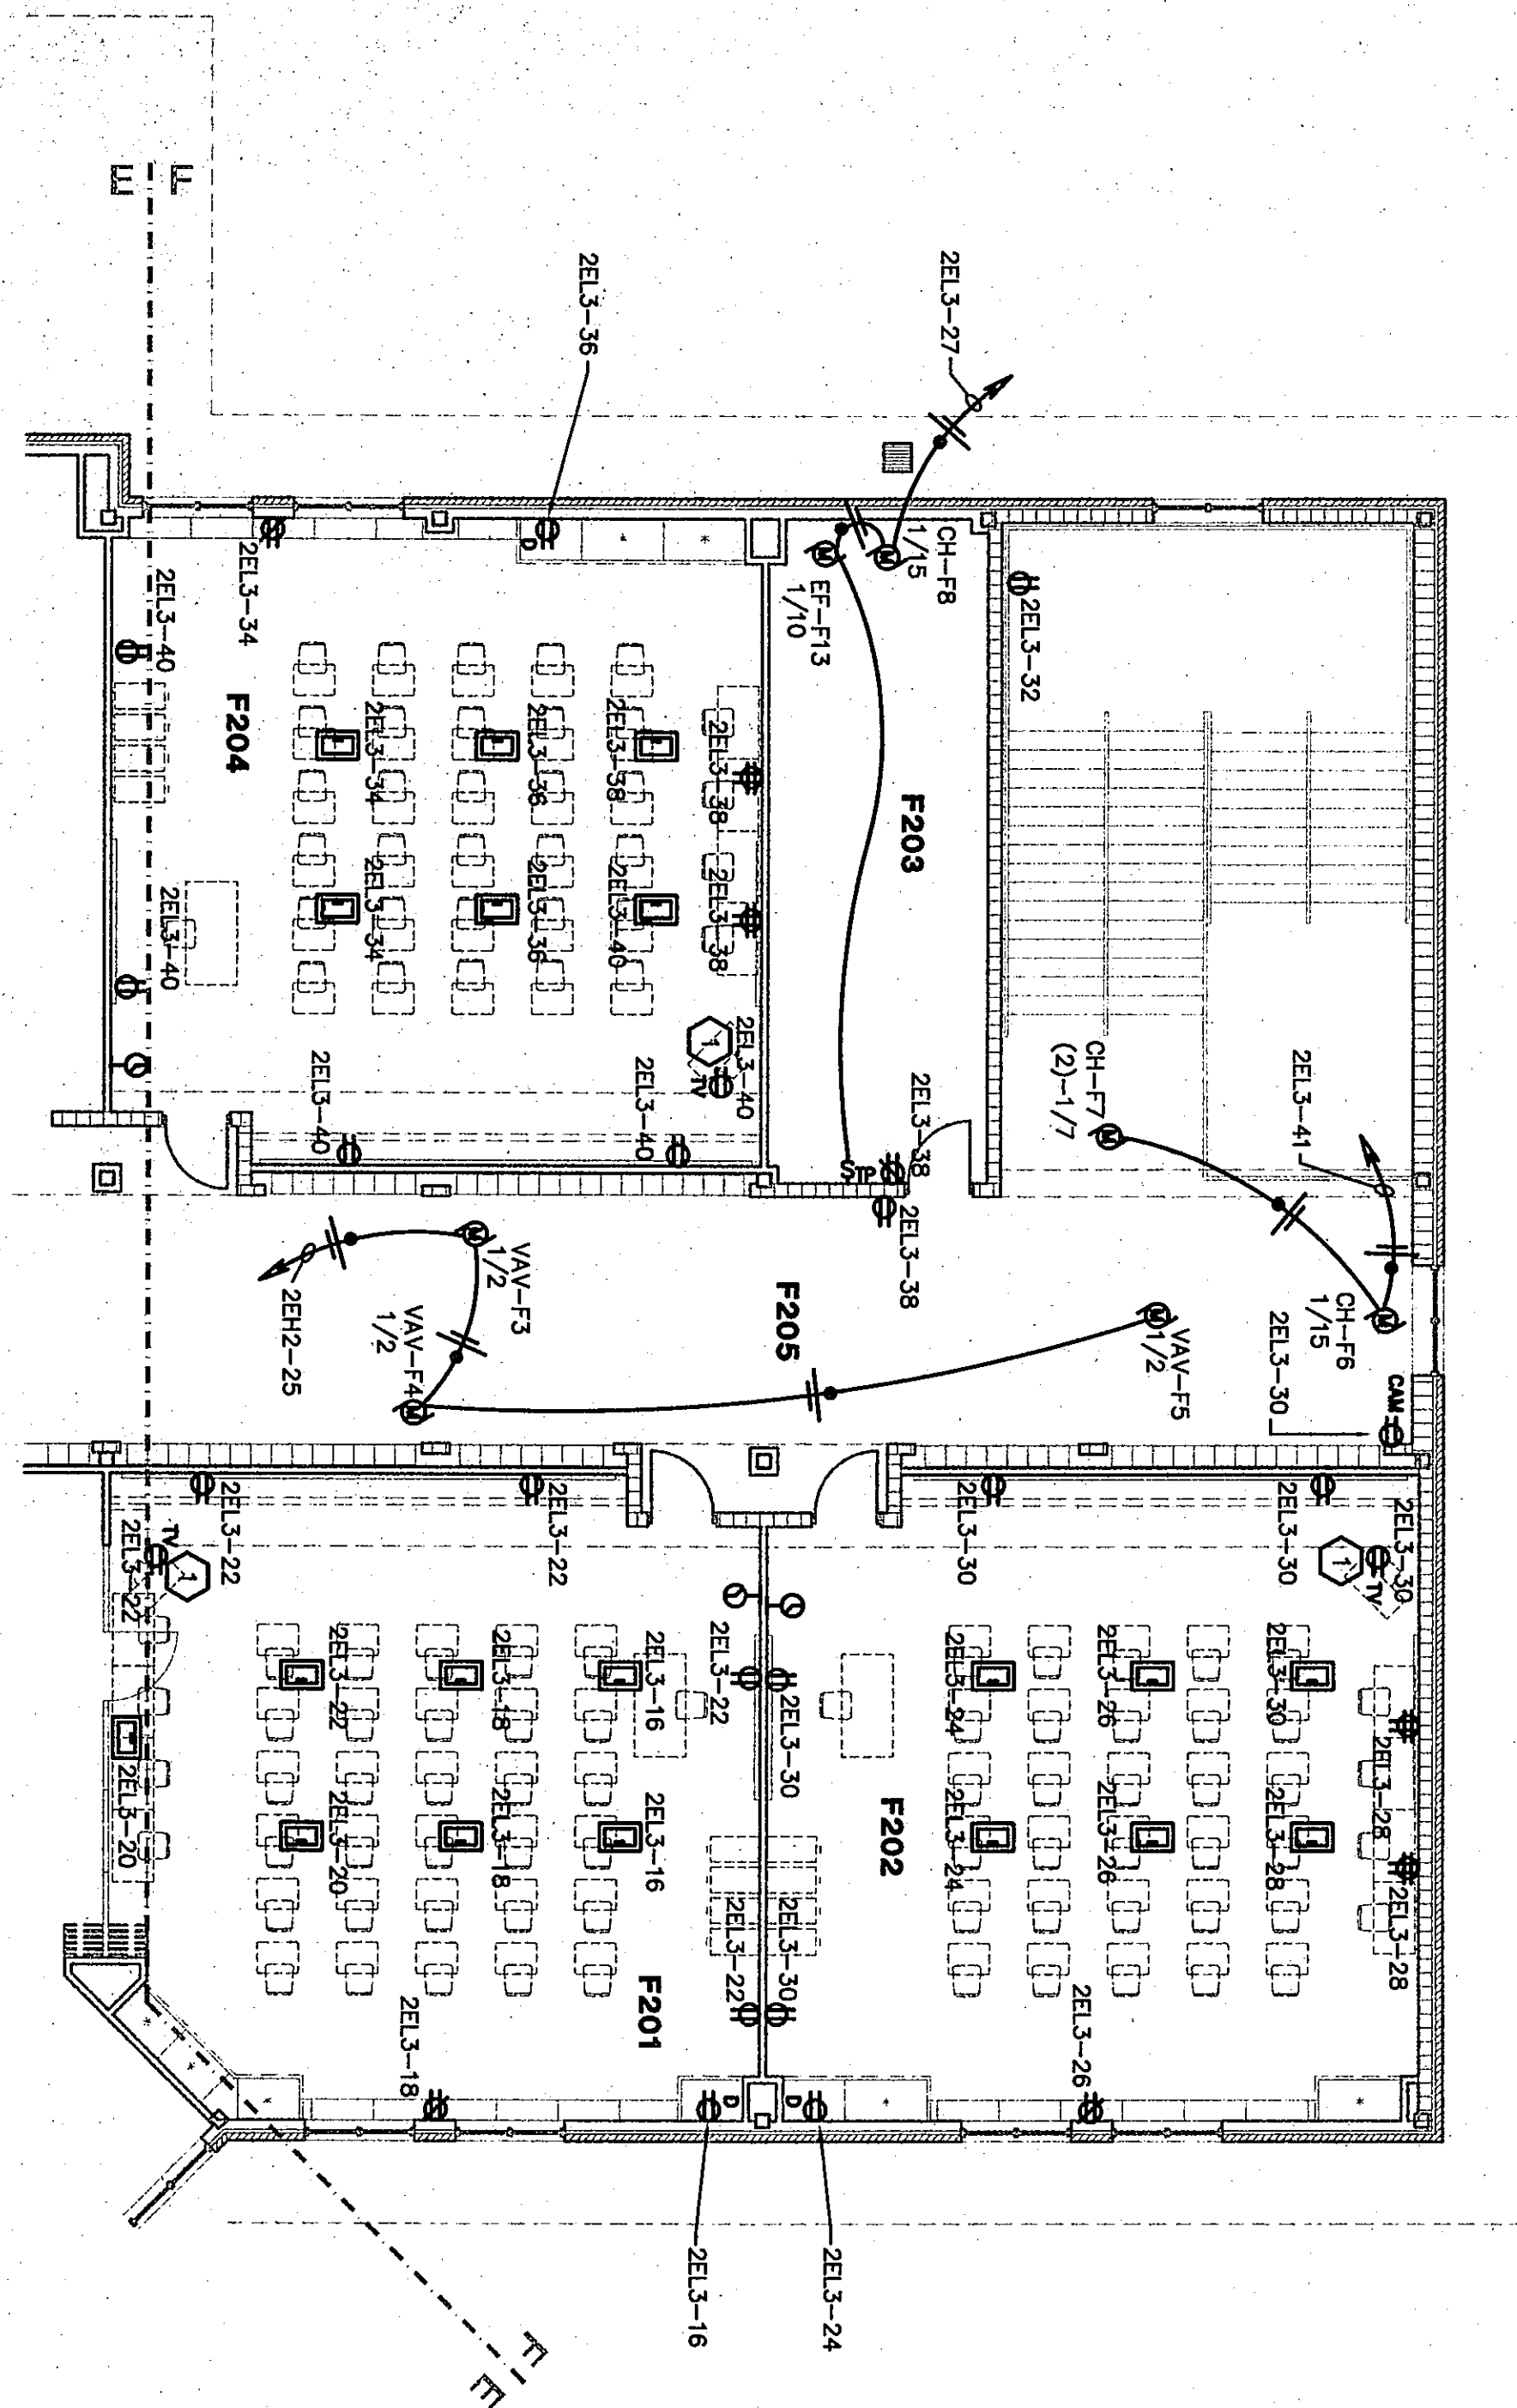

FLOOR BOXES ARE SHOWN ON
AUXILIARY AND POWER PLANS.

PLAN NOTES:
1 REFER TO VIDEO ROUGH-IN AND TELEVISION RECEPTACLE
LOCATION, DEFINES 6/E/1'S AND 9/E/1'S FOR ADDITIONAL INFORMATION.

ROOM LEGEND "F1"		
ROOM	AREA	CEILING
F201	960	VARIES
F202	972	VARIES
F203	340	9'-4"
F204	224	9'-4"
F205	823	10'-0"

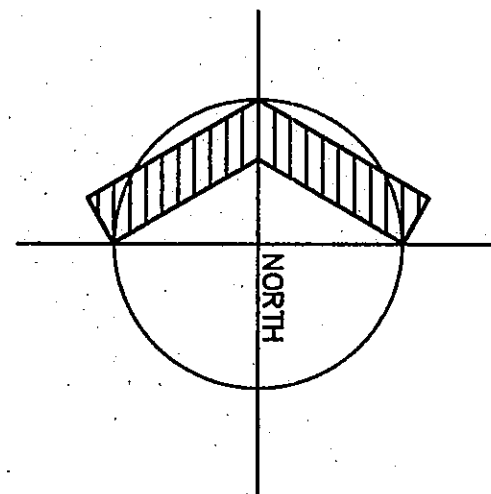

POWER PLAN UNIT F2

SCALE 1/8" = 1'-0"

01-E-79


CHESTERTON HIGH SCHOOL
95067.00

POWER PLAN UNIT F2


DRAWN BY: MRS. COMM. NO.: 95067.00
CHECKED BY: WGH DATE: APRIL 21, 1997

E5.11

REVISIONS NO. DATE

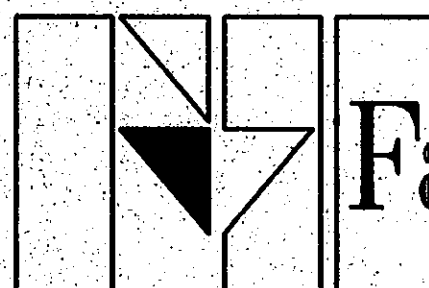

Fanning/Howey
Associates, Inc.
Architects Engineers Consultants

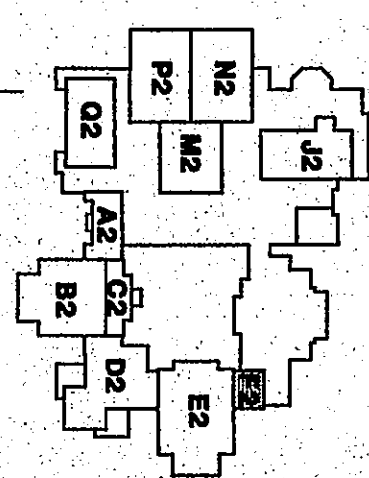

THE NEW
CHESTERTON HIGH SCHOOL
FOR THE
DUNELAND SCHOOL CORPORATION
CHESTERTON, INDIANA

COPYRIGHT 1997 BY FANNING/HOWEY ASSOCIATES, INC.

