
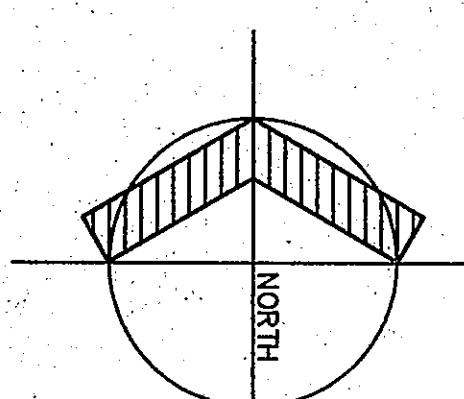


3

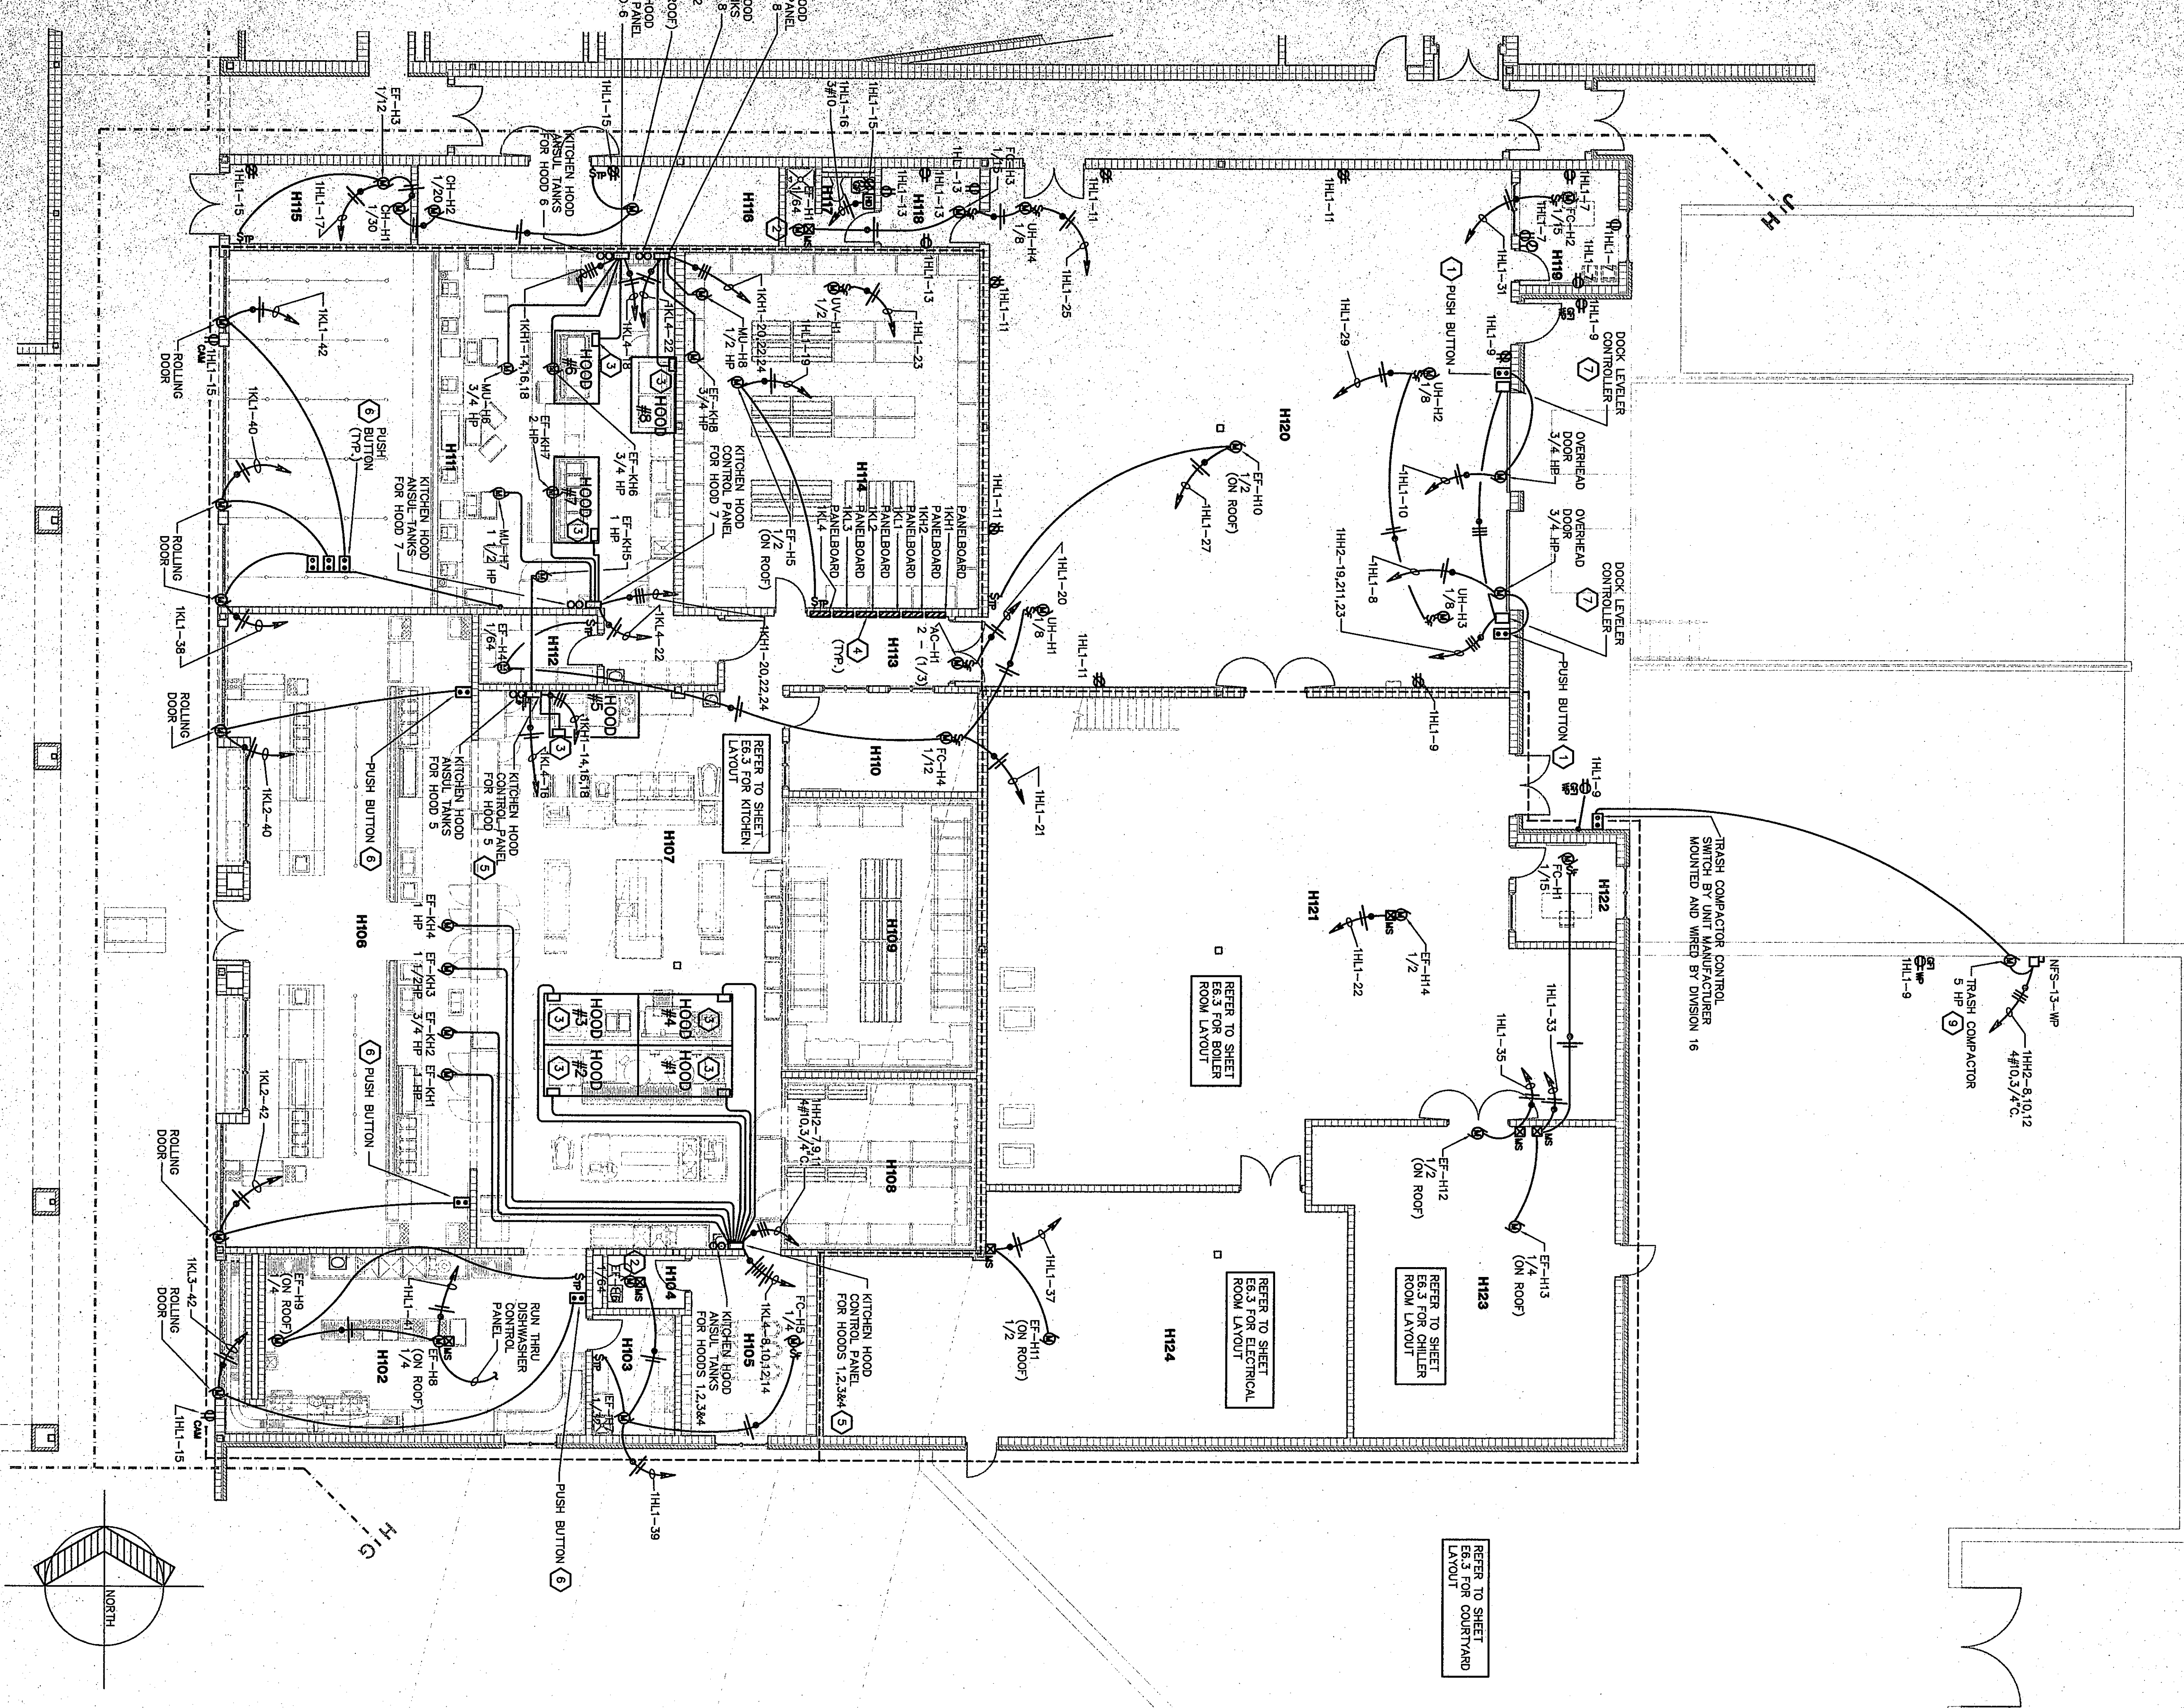


POWER PLAN UNIT H1

SCALE 1/8" = 1'-0"


POWER PLAN UNIT H2

SCALE 1/8" = 1'-0"

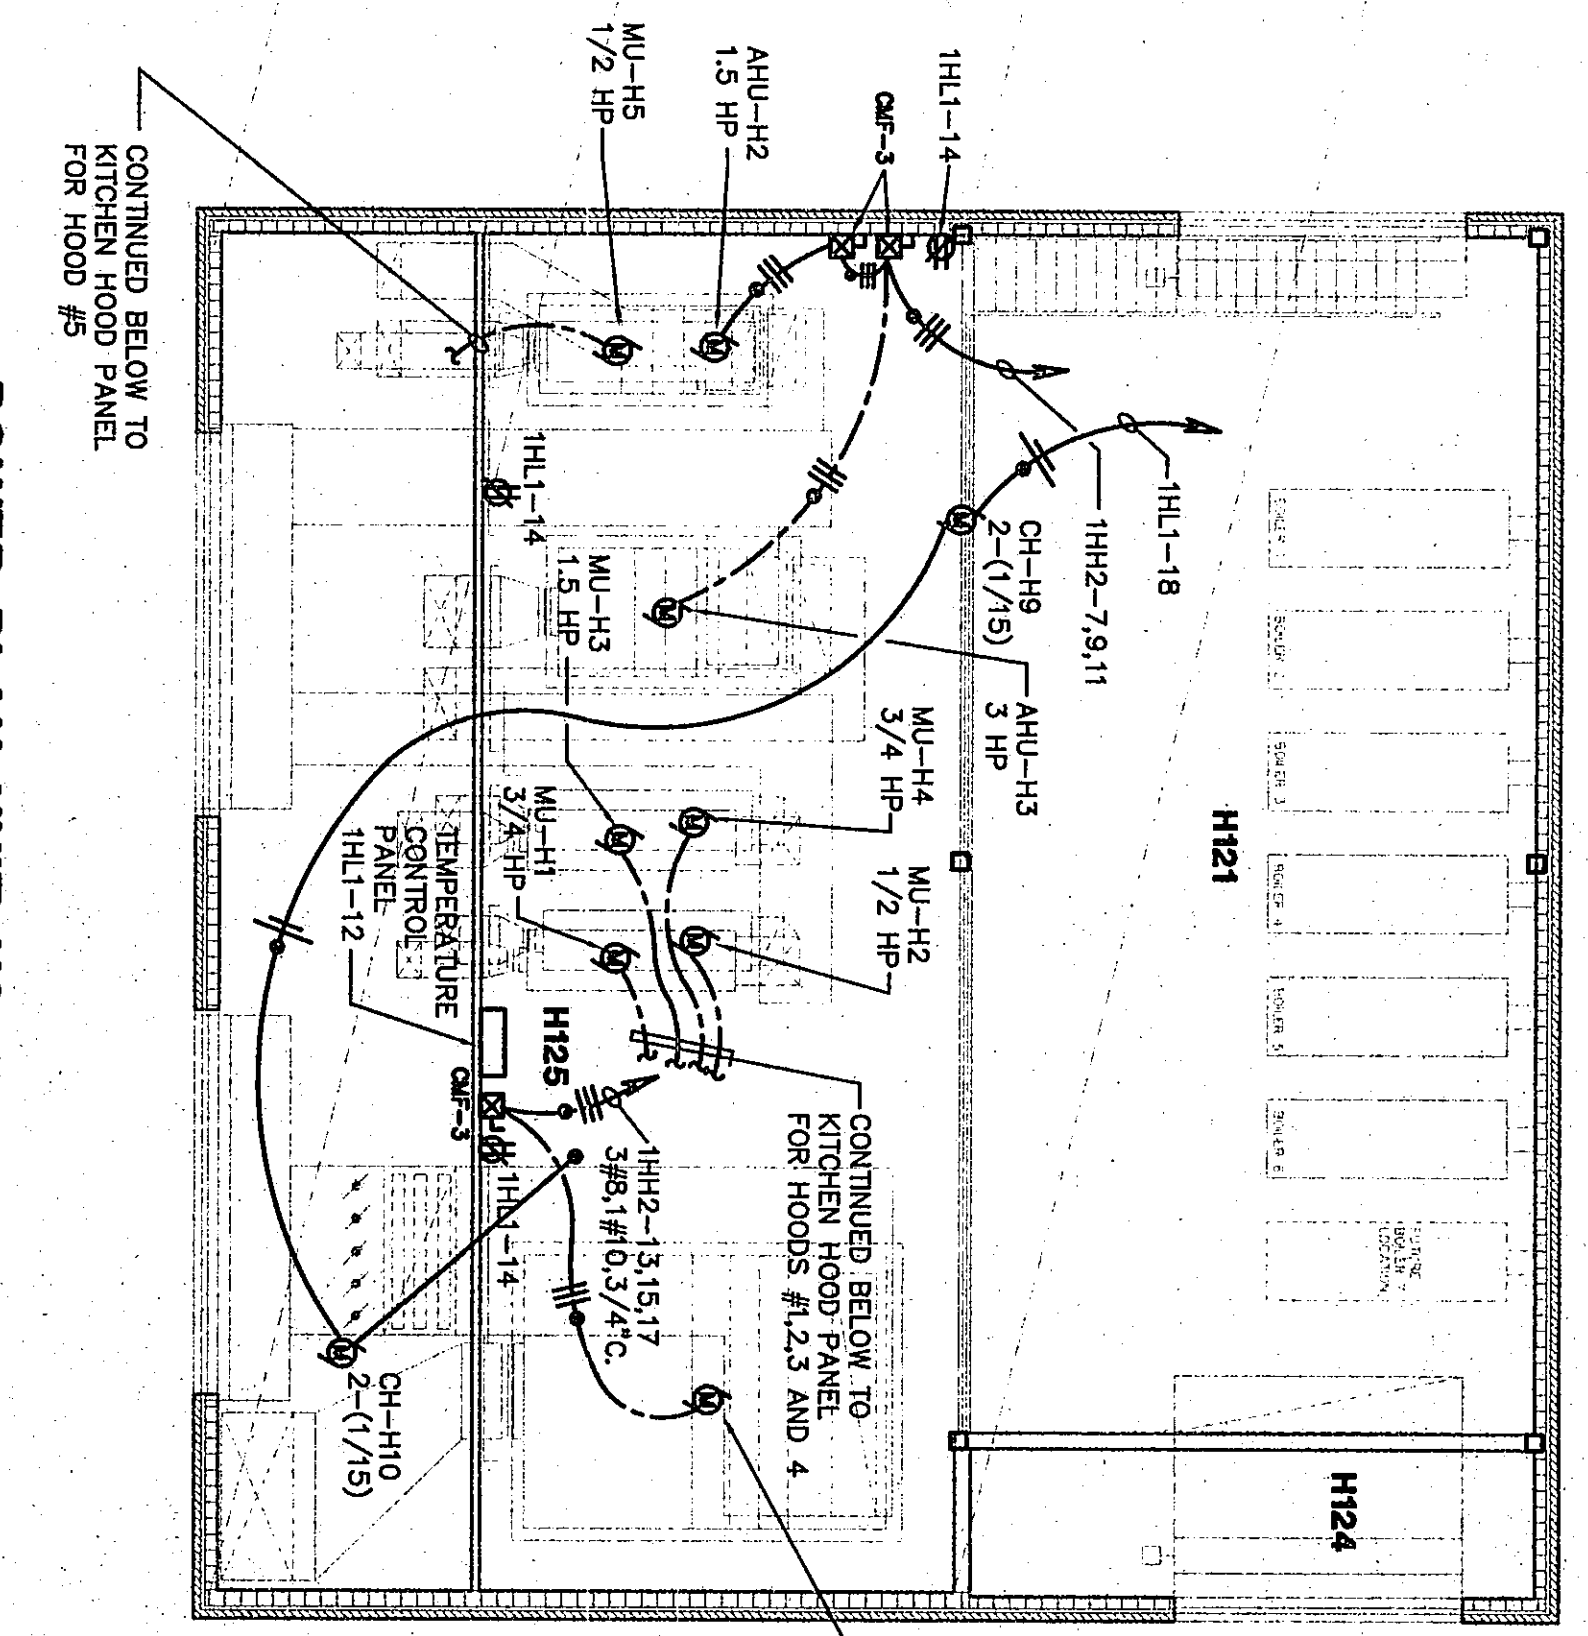


- PLAN NOTES:**
1. OVERHEAD DOOR PUSH BUTTON CONTROLLER BY UNIT MANUFACTURER, DIVISION 16 SHALL MOUNT AND WIRE EACH CONTROLLER.
 2. PROVIDE EXHAUST FAN STARTER WITH A 277V. COIL TAPPED IN THIS ROOM.
 3. REMOTE HOOD CONTROL PANEL.
 4. REFER TO DETAIL 7/E1/6 FOR PANELBOARD LAYOUT.
 5. REFER TO DETAIL 7/E1/2 FOR ADDITIONAL KITCHEN HOOD REQUIREMENTS.
 6. ROLLING DOOR PUSH BUTTON CONTROLLER BY UNIT MANUFACTURER, DIVISION 16 SHALL MOUNT AND WIRE EACH PUSH BUTTON.
 7. DOCK LEVELER CONTROLLER, DIVISION 16 TO COORDINATE CONDUITS AND WIRING TO BE BY DOCK LEVELER MANUFACTURER.
 8. PROVIDE PHASE FAULT RELAY, SQUARE D MODEL, R430-D45N OR ENGINEER APPROVED EQUAL, AND CIRCUIT OF STARTER TO OPEN STARTER UPON SENSING PHASE LOSS.
 9. VERIFY EXACT LOCATION OF TRASH COMPACTOR BEFORE ROLL-IN.

ROOM LEGEND "H1"			
ROOM NO.	ROOM NAME	AREA S.F.	CEILING HEIGHT
H101	CORRIDOR	2240	10'-0"
H102	WASHING	600	9'-4"
H103	WASHING	42	9'-4"
H104	TOILET	42	9'-4"
H105	LOCKER/BREAK ROOM	242	9'-4"
H106	LOCKER/BREAK ROOM	242	9'-4"
H107	COOKING/BAKING	2252	9'-4"
H108	COOKING/BAKING	342	9'-4"
H109	COOKING/BAKING	342	9'-4"
H110	OFFICE	191	9'-4"
H111	FAST FOOD SERVING	1711	9'-4"
H112	FAST FOOD SERVING	159	9'-4"
H113	PASSAGE	1090	9'-4"
H114	FAST FOOD SERVING	1090	9'-4"
H115	FAST FOOD SERVING	1090	9'-4"
H116	FAST FOOD SERVING	1090	9'-4"
H117	TOILET	70	9'-4"
H118	TOILET	70	9'-4"
H119	TOILET	70	9'-4"
H120	SHIPPING/RECEIVING	2728	9'-4"
H121	OFFICE	102	9'-4"
H122	OFFICE	102	9'-4"
H123	CHILLER ROOM	695	9'-4"
H124	MECHANICAL	1229	9'-4"
H125	MECHANICAL	1229	9'-4"

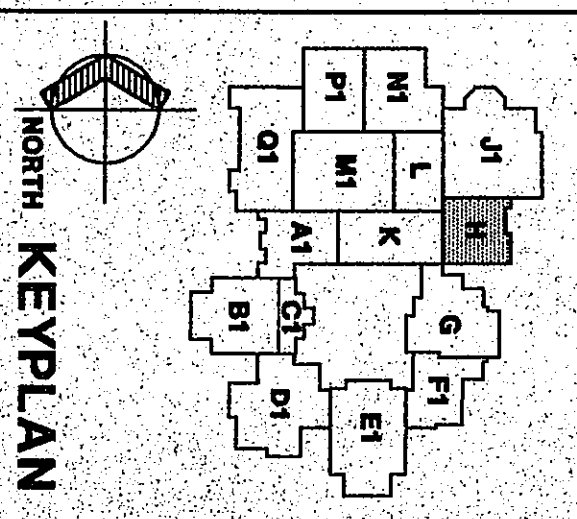

KEY PLAN

THE NEW
CHESTERTON HIGH SCHOOL
FOR THE
DUNELAND SCHOOL CORPORATION
CHESTERTON, INDIANA

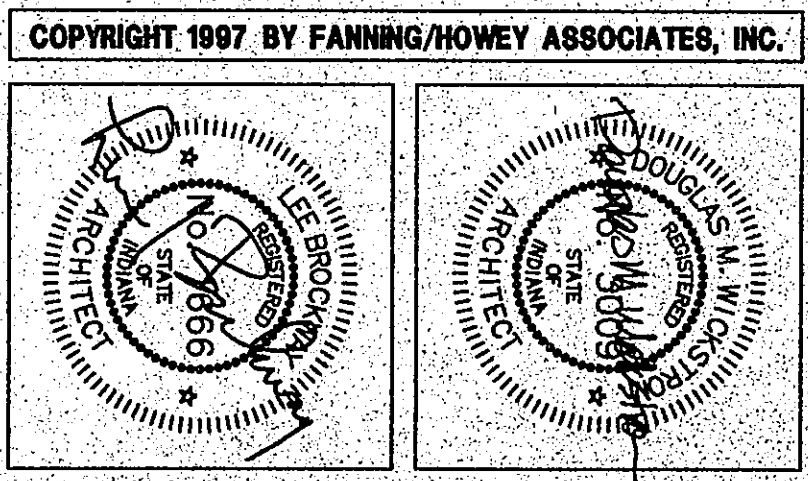

POWER PLAN UNIT H1,H2			
DRAWN BY: MRS	COMM. NO.: 95067.00		
CHECKED BY: WGH	DATE: APRIL 21, 1997		
E5.13		REVISIONS NO. DATE	

Fanning/Howey Associates, Inc.
Architects Engineers Consultants