


h2

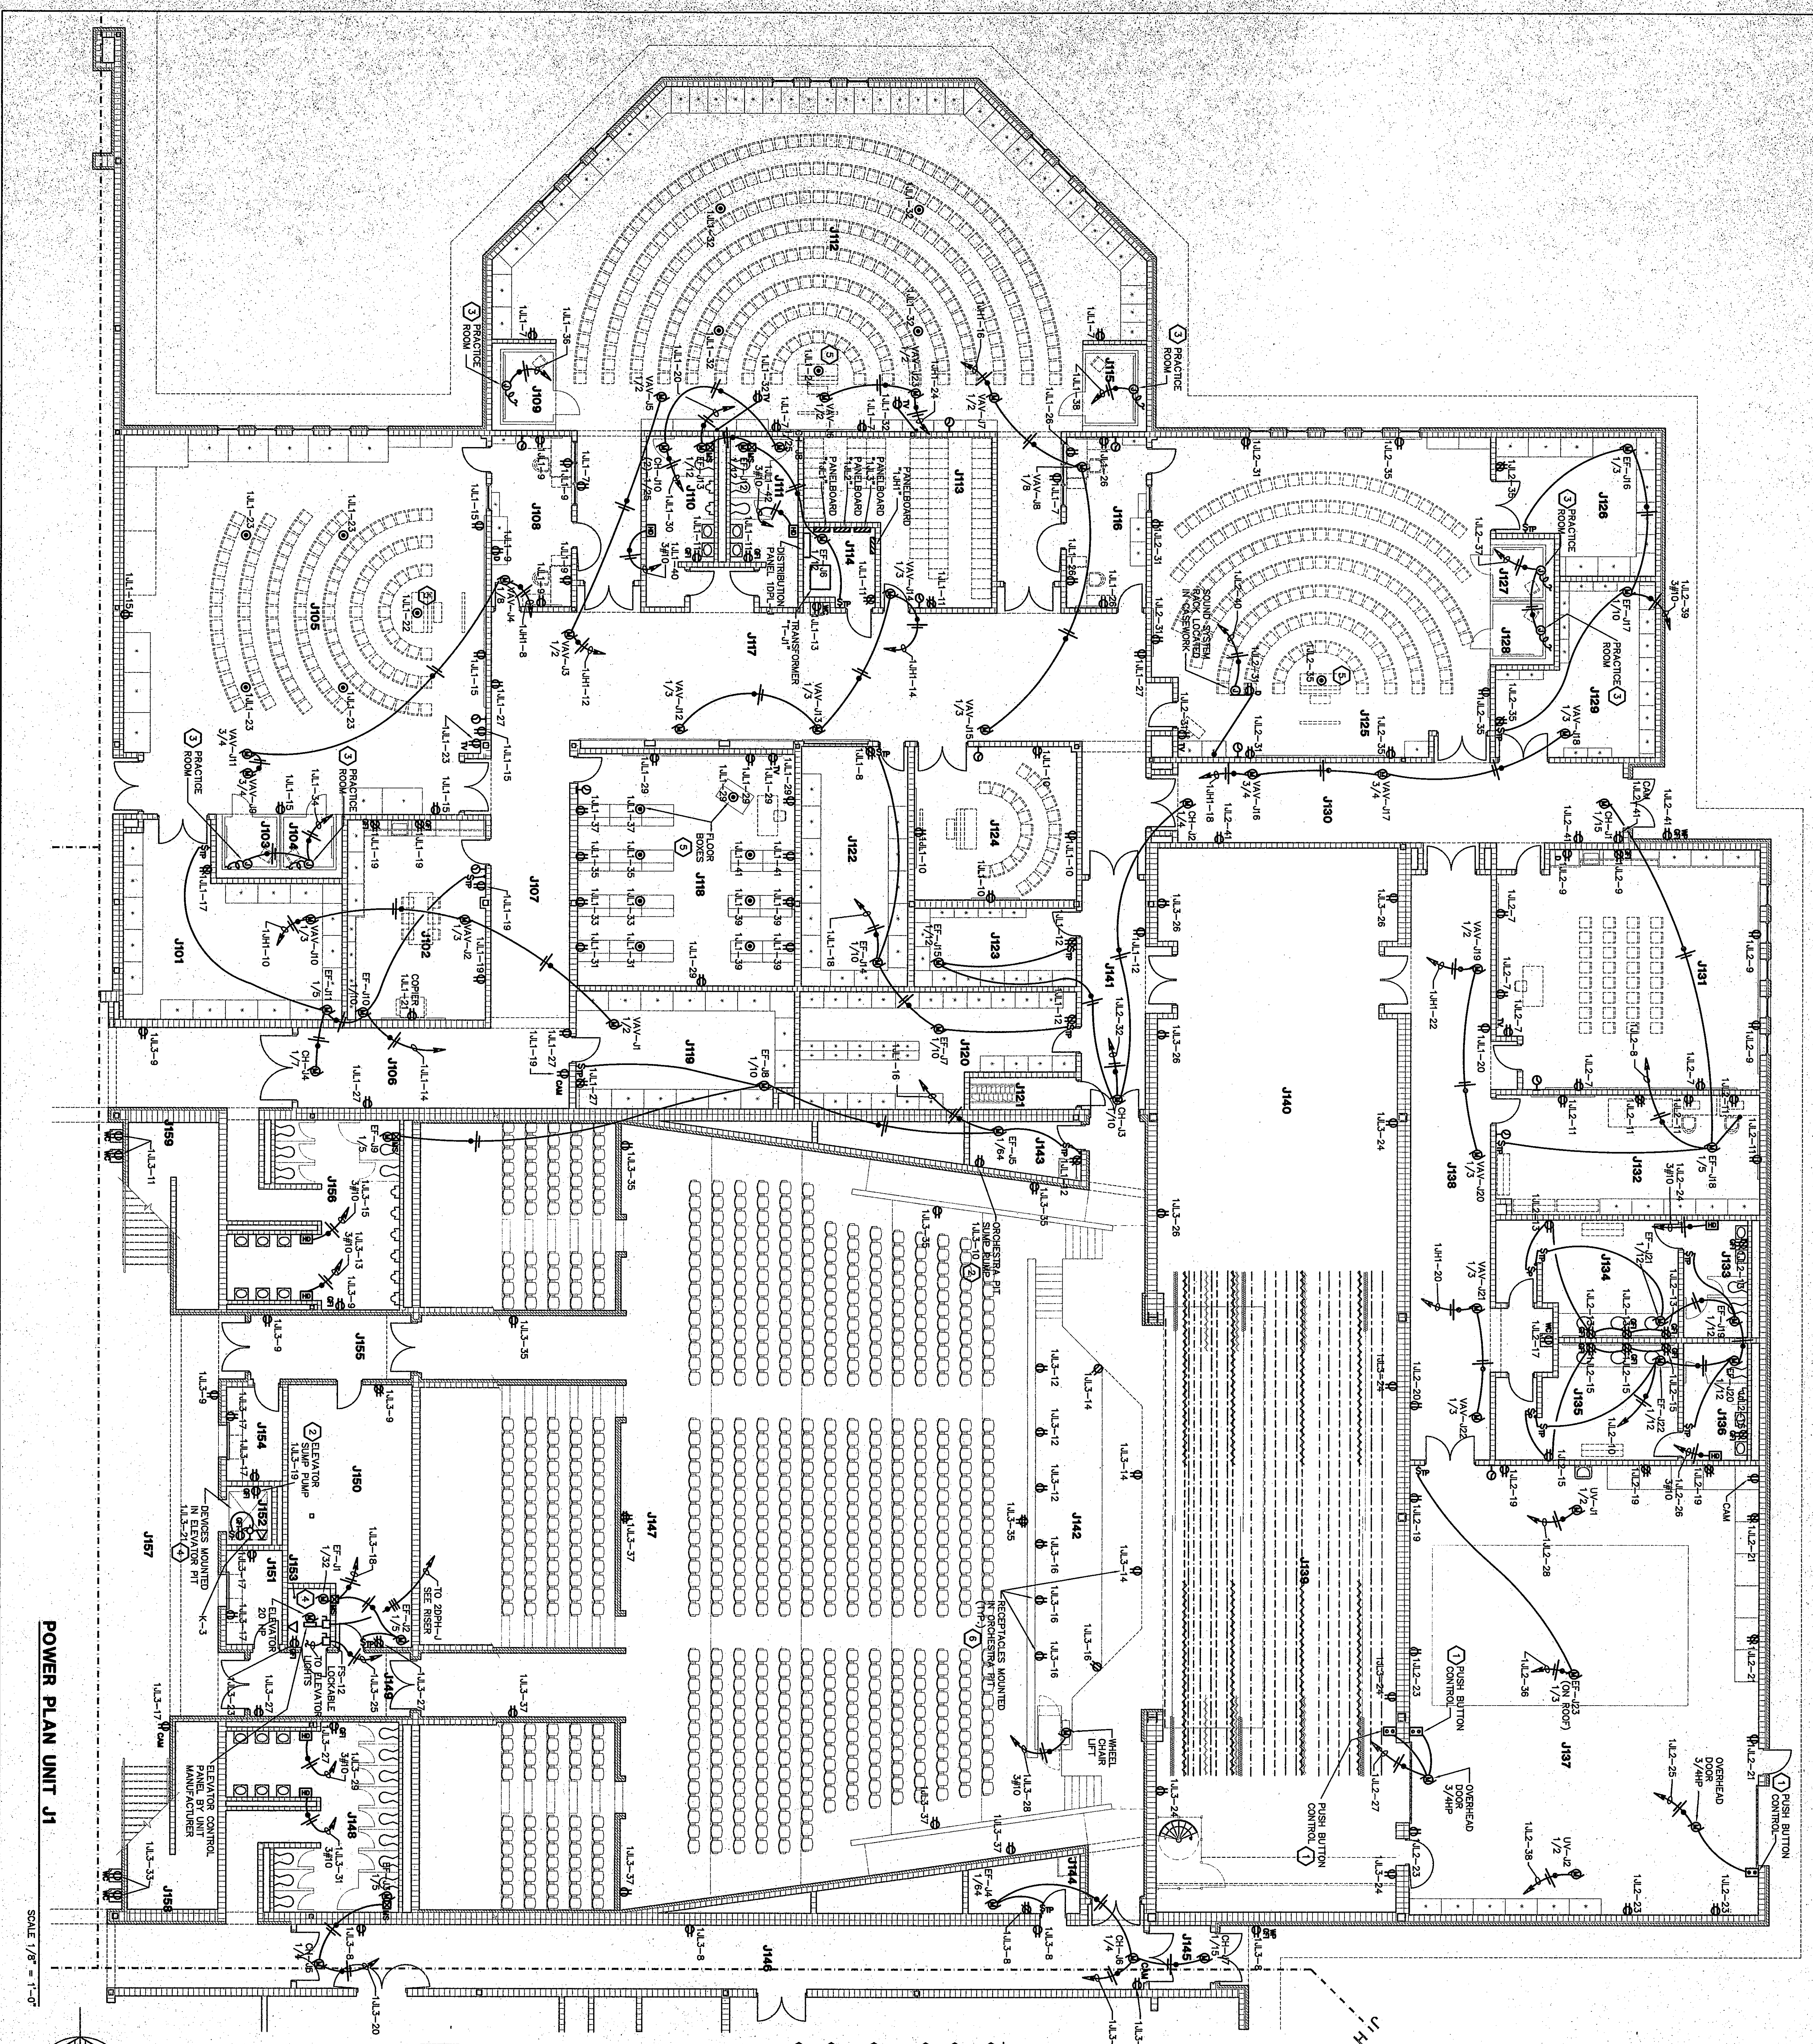

POWER PLAN UNIT J1

SCALE 1/8" = 1'-0"

FLOOR BOXES ARE SHOWN ON
AUXILIARY AND POWER PLANS.


PLAN NOTES:

- 1 OVERHEAD DOOR PUSH BUTTON CONTROLLER BY UNIT EACH CONTROLLER.
- 2 VERIFY EXACT LOCATION OF SLUMP PUMP WITH DIVISION 15.
- 3 DIVISION 15 SHALL PUT A JUNCTION BOX ABOVE EACH MUSIC PRACTICE ROOM, WIRE FROM JUNCTION BOX TO ORCHESTRA PIT WITH UNIT MANUFACTURER'S.
- 4 VERIFY EXACT LOCATION OF ALL DEVICES IN ELEVATOR PIT ROOM-IN ROOM, WITH MANUFACTURER BEFORE.
- 5 SEE AUXILIARY PLAN UNIT J1, SHEET E5.14 FOR FLOOR BOX RECOMMENDATIONS.
- 6 MOUNT RECEPTACLES FLUSH IN ORCHESTRA PIT WALL AT 16" ABOVE FINISH FLOOR OF ORCHESTRA PIT.

ROOM LEGEND "J1"

ROOM	NO.	AREA	BEING
101	556	556	9'-4"
102	430	430	9'-4"
103	430	430	9'-4"
104	2089	2089	10'-0"
105	2089	2089	10'-0"
106	213	213	9'-4"
107	213	213	9'-4"
108	160	160	9'-4"
109	160	160	9'-4"
110	4025	4025	9'-4"
111	4025	4025	9'-4"
112	4025	4025	9'-4"
113	4025	4025	9'-4"
114	4025	4025	9'-4"
115	4025	4025	9'-4"
116	4025	4025	9'-4"
117	4025	4025	9'-4"
118	4025	4025	9'-4"
119	4025	4025	9'-4"
120	4025	4025	9'-4"
121	4025	4025	9'-4"
122	4025	4025	9'-4"
123	4025	4025	9'-4"
124	4025	4025	9'-4"
125	4025	4025	9'-4"
126	4025	4025	9'-4"
127	4025	4025	9'-4"
128	4025	4025	9'-4"
129	4025	4025	9'-4"
130	4025	4025	9'-4"
131	4025	4025	9'-4"
132	4025	4025	9'-4"
133	4025	4025	9'-4"
134	4025	4025	9'-4"
135	4025	4025	9'-4"
136	4025	4025	9'-4"
137	4025	4025	9'-4"
138	4025	4025	9'-4"
139	4025	4025	9'-4"
140	4025	4025	9'-4"
141	4025	4025	9'-4"
142	4025	4025	9'-4"
143	4025	4025	9'-4"
144	4025	4025	9'-4"
145	4025	4025	9'-4"
146	4025	4025	9'-4"
147	4025	4025	9'-4"
148	4025	4025	9'-4"
149	4025	4025	9'-4"
150	4025	4025	9'-4"
151	4025	4025	9'-4"
152	4025	4025	9'-4"
153	4025	4025	9'-4"
154	4025	4025	9'-4"
155	4025	4025	9'-4"
156	4025	4025	9'-4"
157	4025	4025	9'-4"
158	4025	4025	9'-4"
159	4025	4025	9'-4"

THE NEW
CHESTERTON HIGH SCHOOL
FOR THE
DUNELAND SCHOOL CORPORATION
CHESTERTON, INDIANA

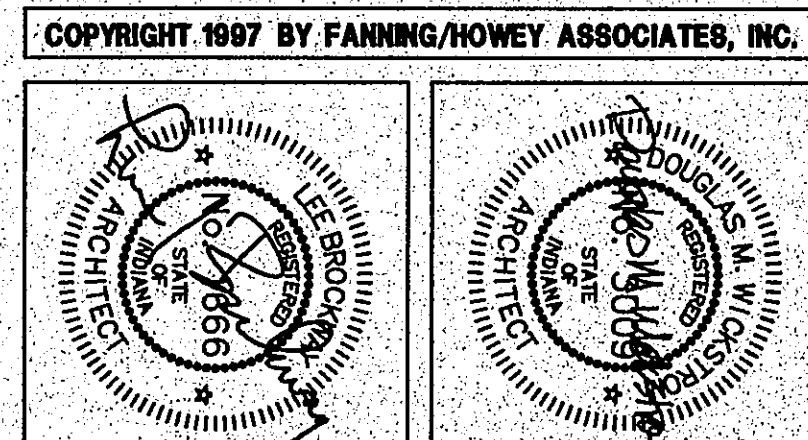

POWER PLAN UNIT J1

DRAWN BY: MRS. COMM. NO. 95067.00
CHECKED BY: WGH DATE: APRIL 21, 1997

E5.14

REVISIONS NO. DATE

Fanning/Howey
Associates, Inc.
Architects Engineers Consultants

