
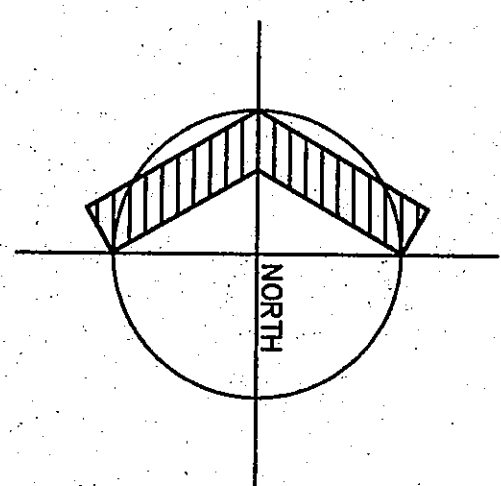


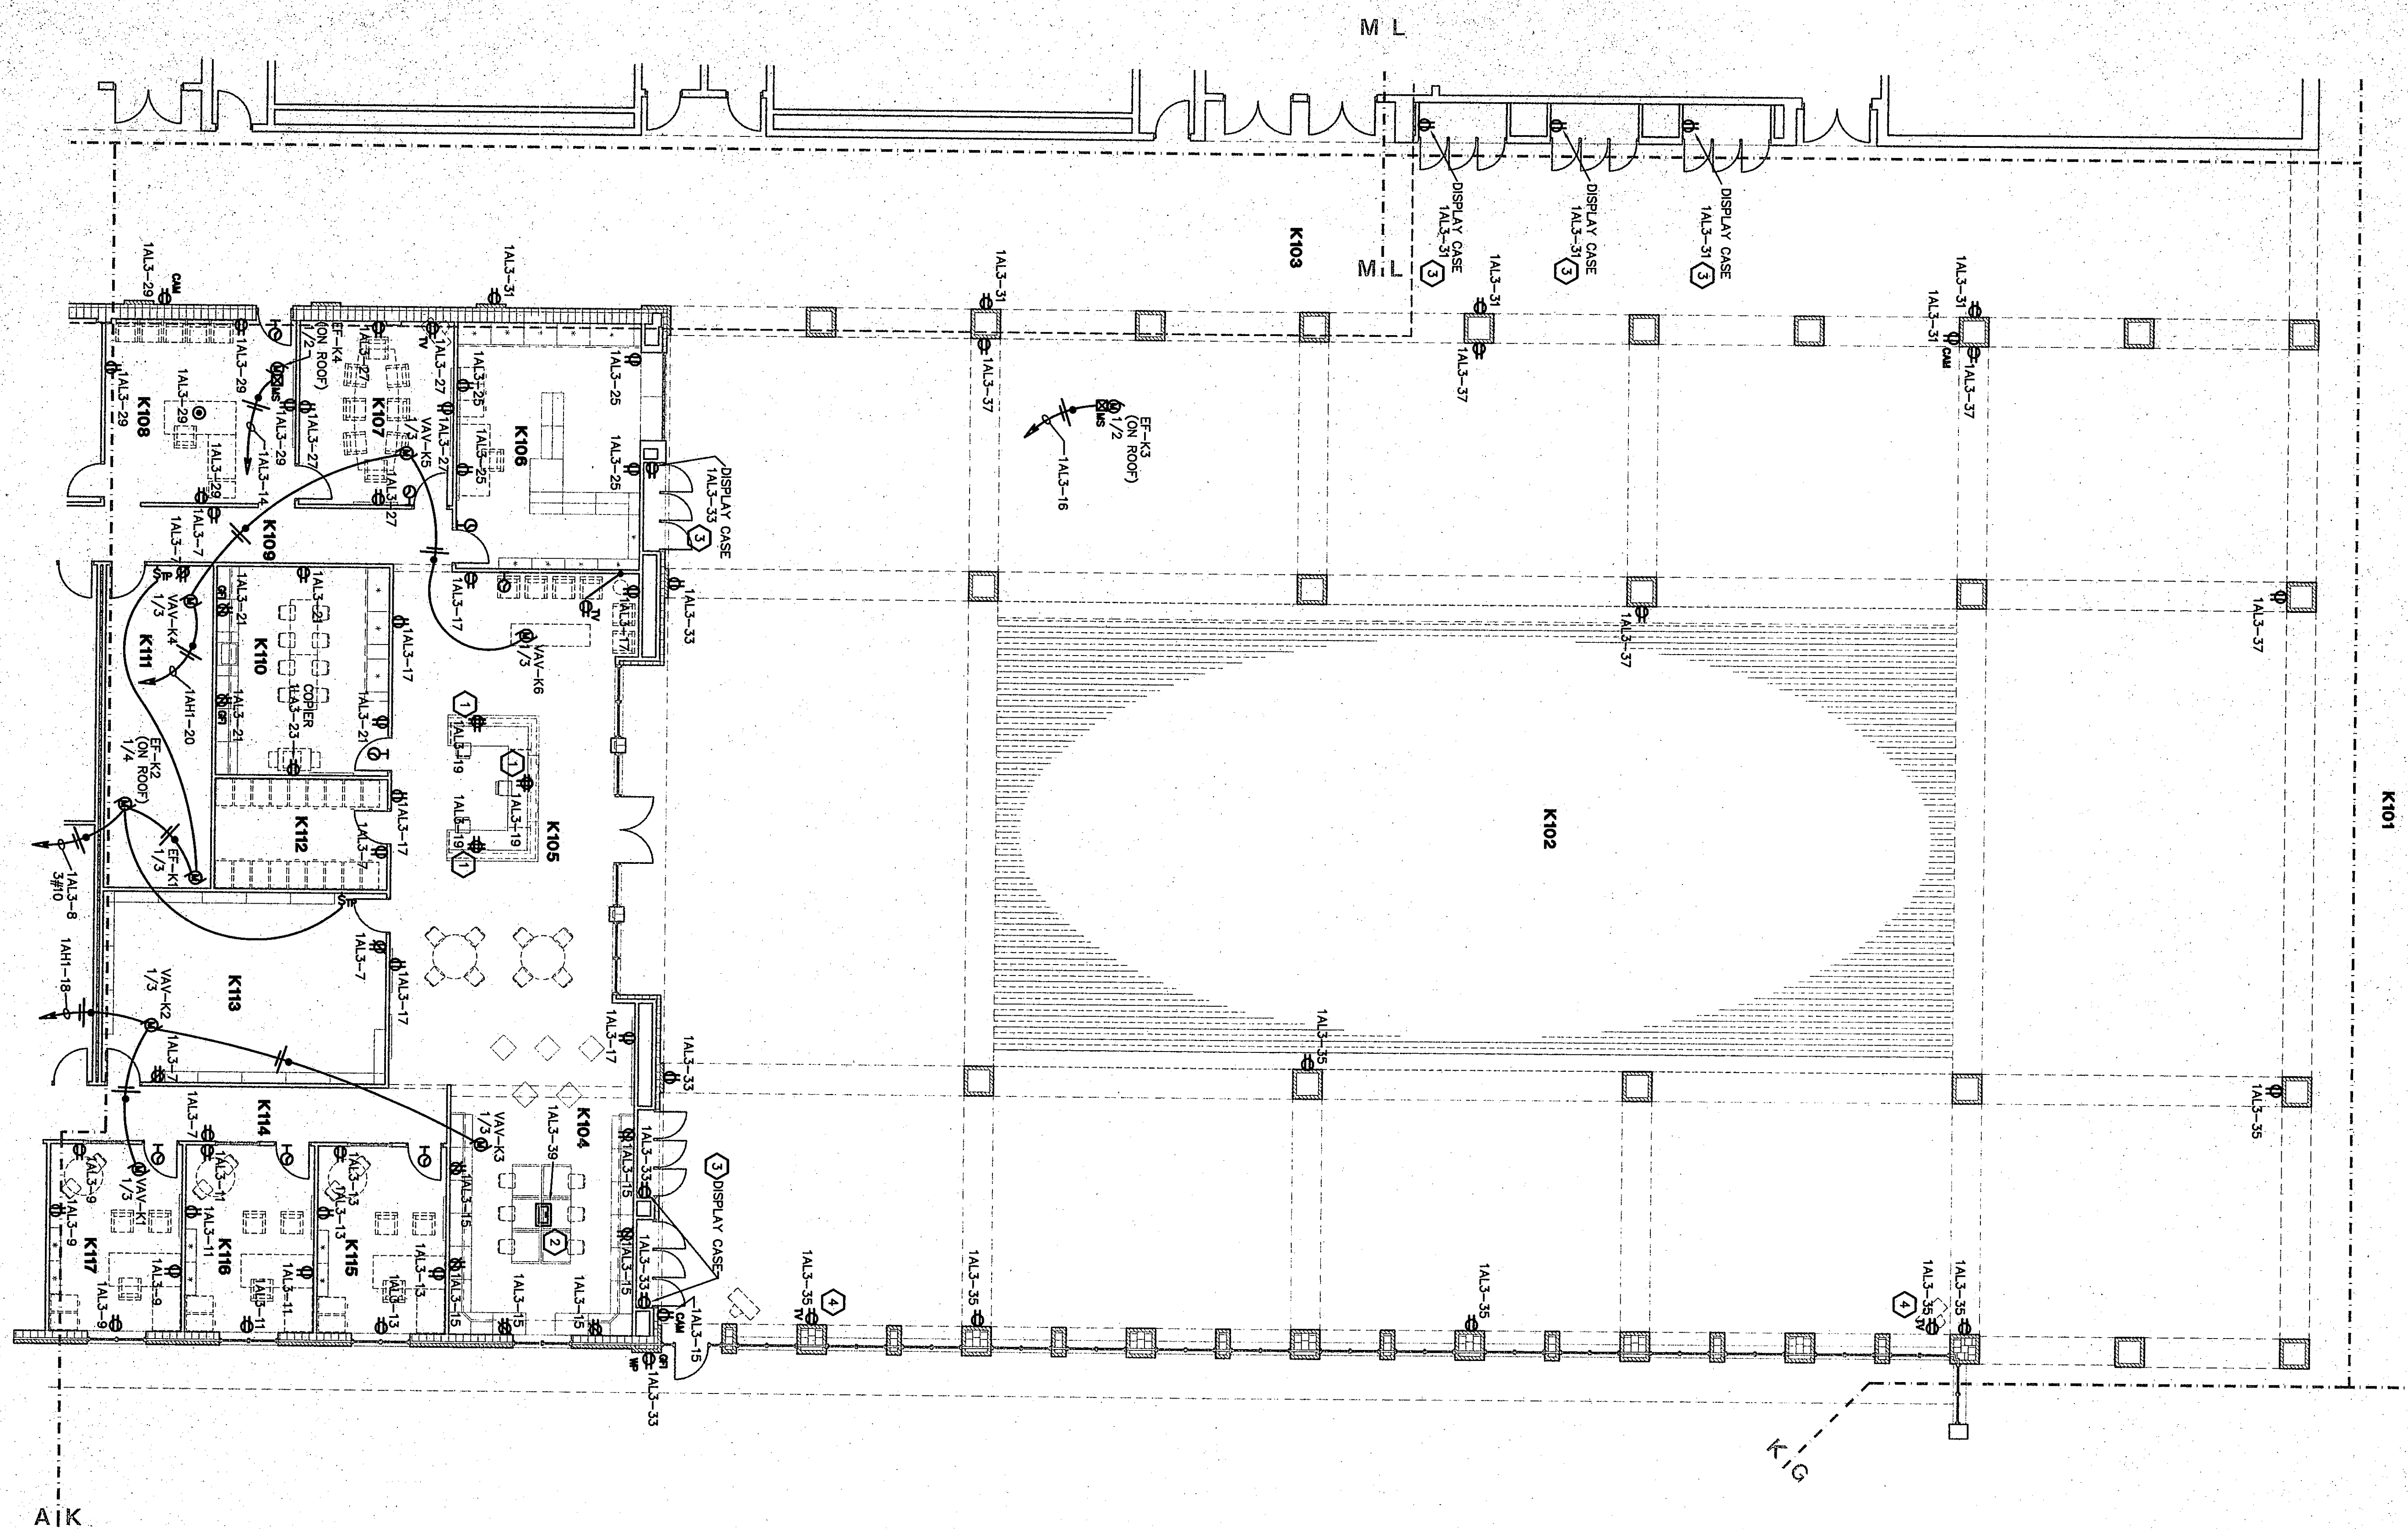

POWER PLAN UNIT K

SCALE 1/8" = 1'-0"

PLAN NOTES:

- ① STRIP CONDUIT UP THRU FLOOR AND INTO CHASE OF CASEWORK. MOUNT RECEPTACLE AT 16 INCHES ABOVE FINISH FLOOR SEE DETAIL 6/E/10.
- ② PROVIDE FLOOR BOX WITH 3 DUPLEX RECEPTACLE OUTLETS AND TWO BLANK COVERS FOR DATA.
- ③ MOUNT DUPLEX RECEPTACLE IN DISPLAY CASE PER DETAIL 1/E/12.
- ④ MOUNT TELEVISION RECEPTACLE ON FACE OF BULKHEAD.


ROOM NO.	ROOM NAME	AREA S.F.	CEILING HEIGHT
K101	NOT USED	1349.6	10'-0"
K102	STUDENT DINING	324.4	10'-0"
K103	CORRIDOR	9.4	9'-4"
K104	RECEPTIONIST	8.1	9'-4"
K105	RECEPTIONIST	9.4	9'-4"
K106	BOOKSTORE	372	9'-4"
K107	RECEPTIONIST	9.4	9'-4"
K108	SECRETARY	281	9'-4"
K109	CORRIDOR	165	9'-4"
K110	CORRIDOR	157	9'-4"
K111	STORAGE	9.4	9'-4"
K112	FILES	157	9'-4"
K113	STORAGE	9.4	9'-4"
K114	CORRIDOR	156	9'-4"
K115	GUIDANCE OFFICE	198	9'-4"
K116	GUIDANCE OFFICE	198	9'-4"
K117	GUIDANCE OFFICE	201	9'-4"

POWER PLAN UNIT K


DRAWN BY: MRS	COMM. NO.: 95067.00
CHECKED BY: WBH	DATE: APRIL 21, 1997

E5.16

REVISIONS	NO.	DATE
-----------	-----	------

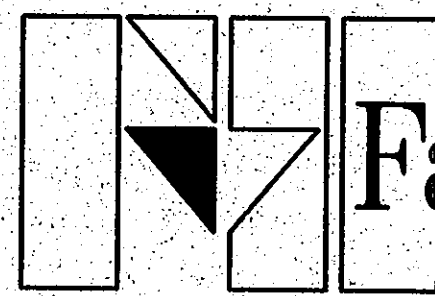

**Fanning/Howey
Associates, Inc.**
Architects Engineers Consultants

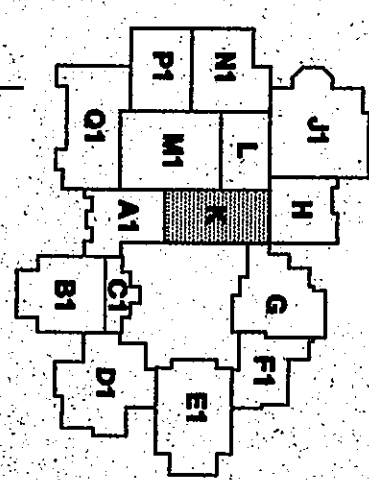

THE NEW
CHESTERTON HIGH SCHOOL
FOR THE
DUNELAND SCHOOL CORPORATION
CHESTERTON, INDIANA

COPYRIGHT 1997 BY FANNING/HOWEY ASSOCIATES, INC

