



28

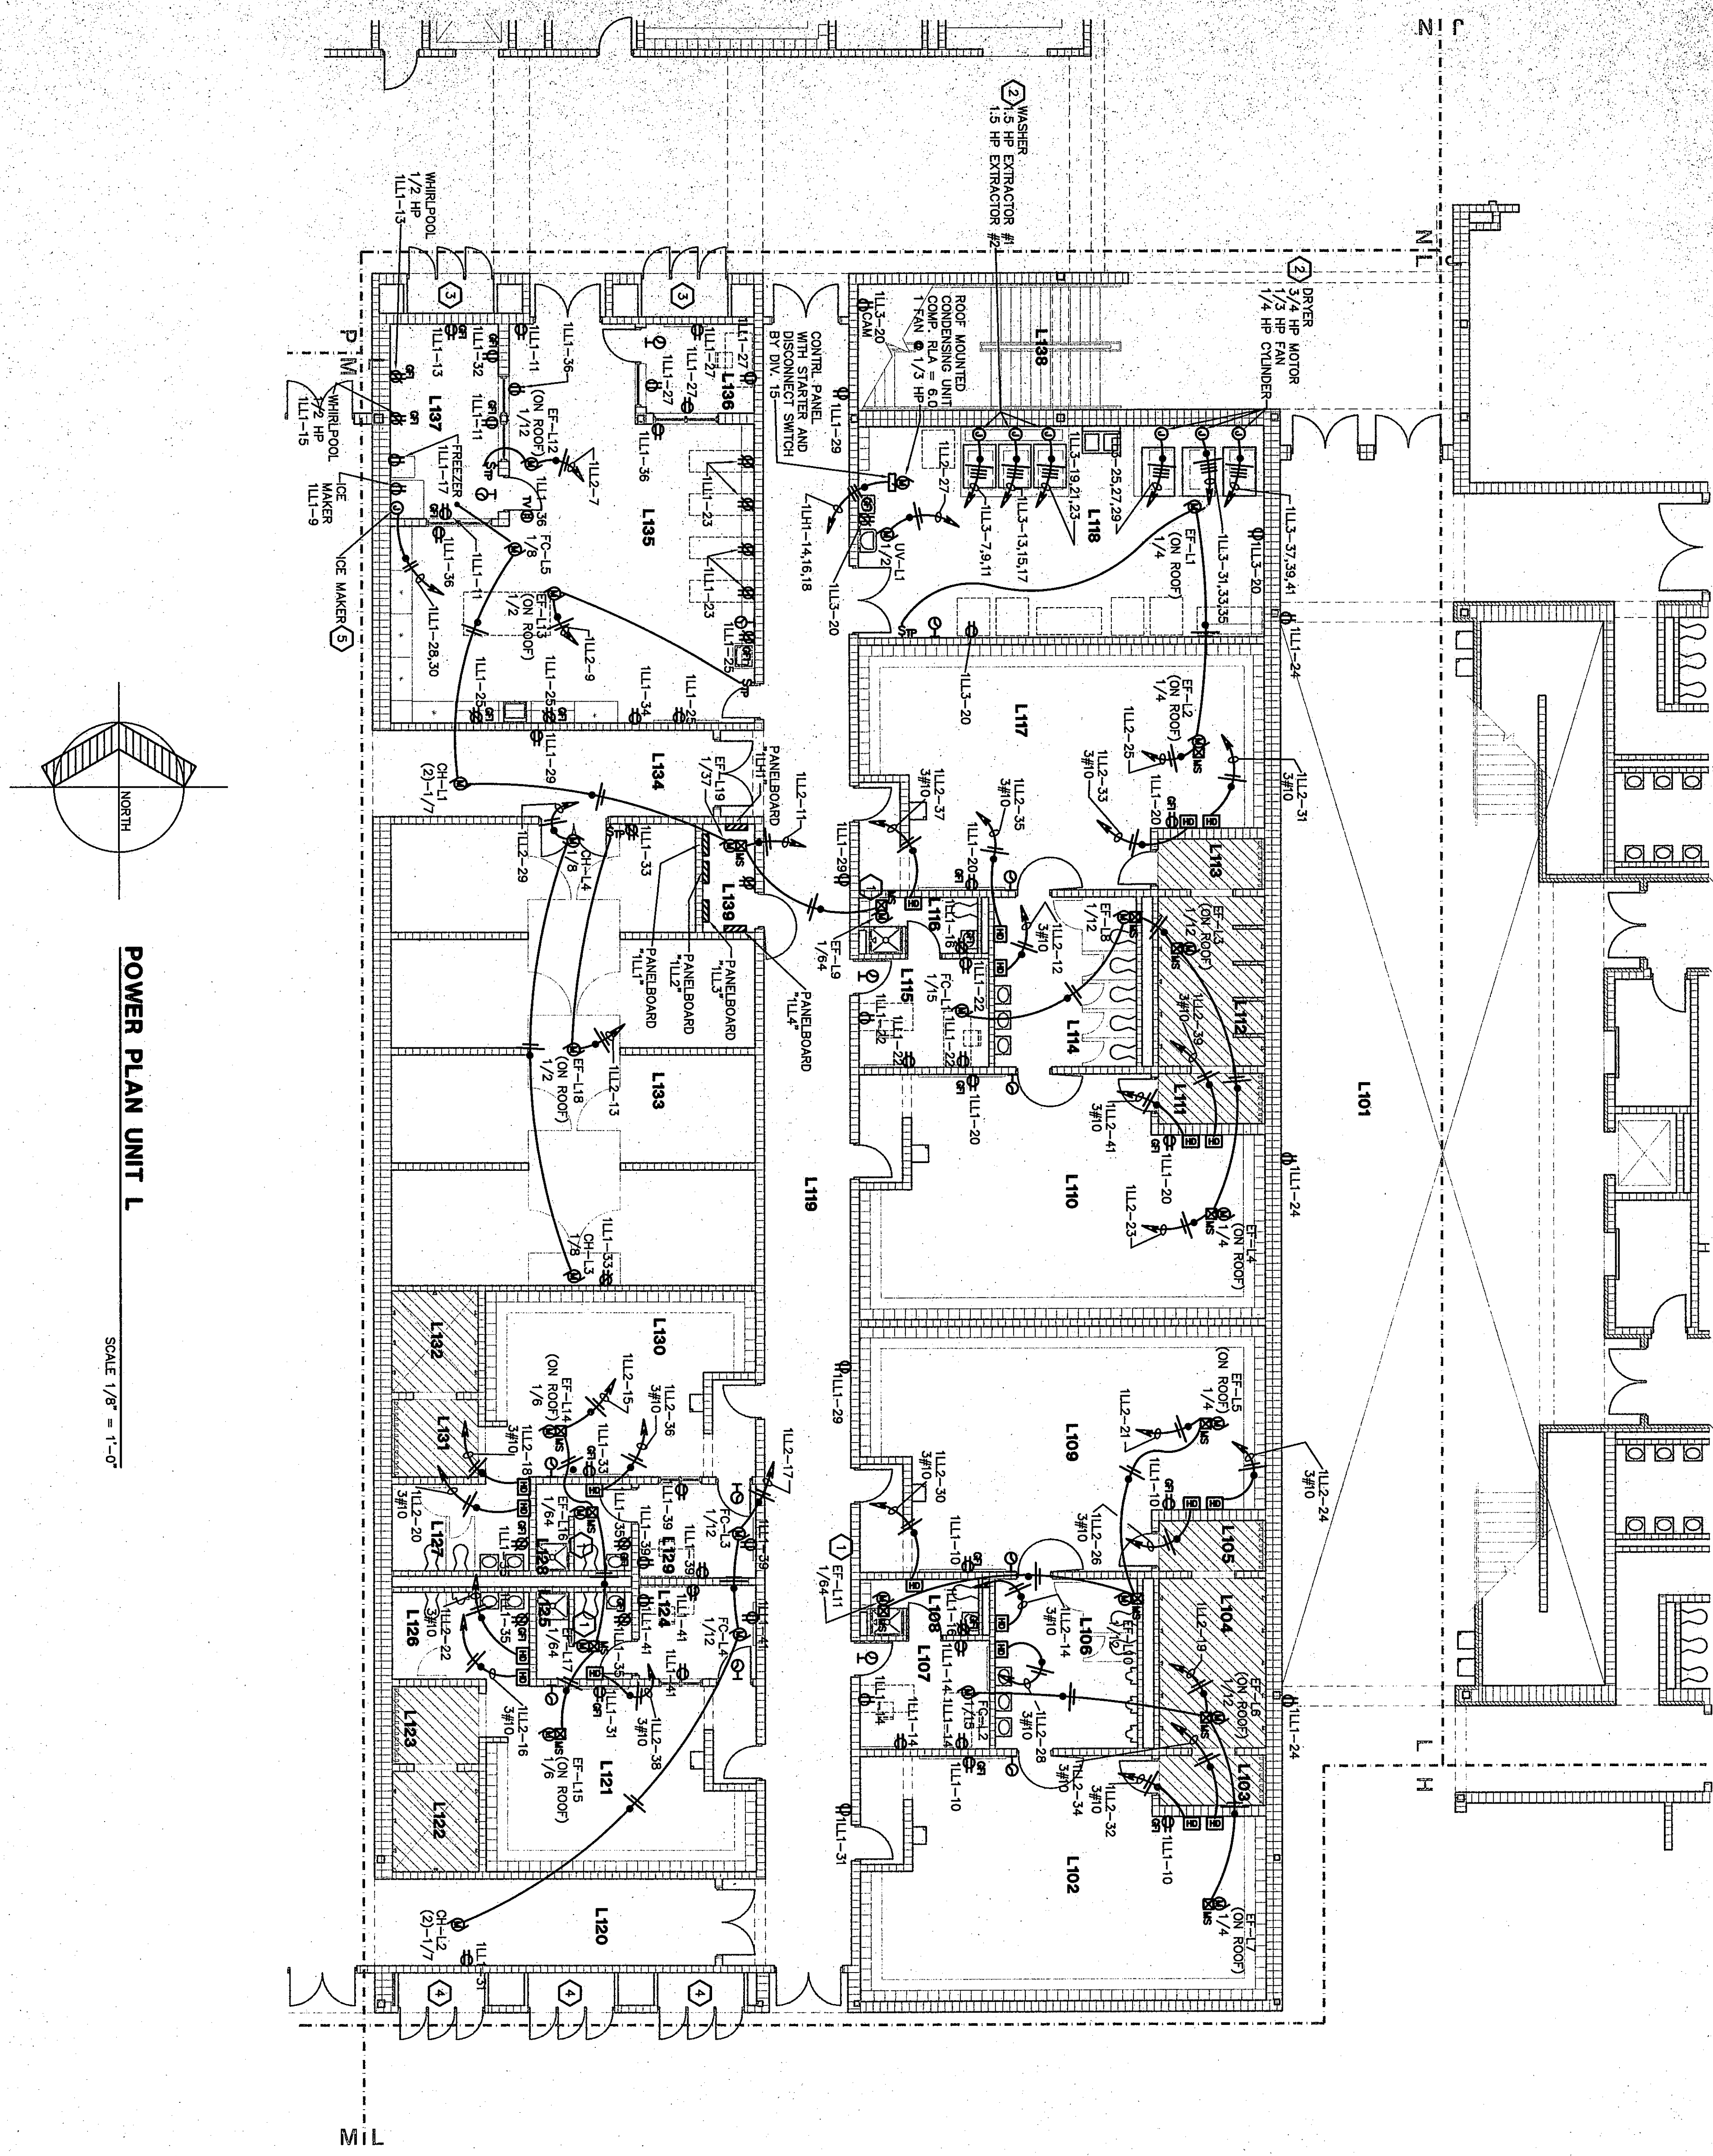


POWER PLAN UNIT L
SCALE 1/8" = 1'-0"

ROOM LEGEND "L"			
ROOM NO.	ROOM NAME	AREA S.F.	CEILING HEIGHT
L101	CORRIDOR	182	9'-0"
L102	BOYS' ATHLETIC LOCKER	782	9'-0"
L103	BOYS' DRESSING ROOM	44	9'-0"
L104	BOYS' SHOWER	154	9'-0"
L105	BOYS' TRAINING ROOM	46	9'-0"
L106	BOYS' LOCKER	46	9'-0"
L107	ATHLETIC OFFICE	120	9'-0"
L108	TOILET	54	9'-0"
L109	BOYS' ATHLETIC LOCKER	782	9'-0"
L110	BOYS' DRESSING ROOM	44	9'-0"
L111	BOYS' SHOWER	154	9'-0"
L112	BOYS' TRAINING ROOM	46	9'-0"
L113	BOYS' LOCKER	46	9'-0"
L114	ATHLETIC OFFICE	120	9'-0"
L115	TOILET	54	9'-0"
L116	BOYS' ATHLETIC LOCKER	782	9'-0"
L117	BOYS' DRESSING ROOM	44	9'-0"
L118	BOYS' SHOWER	154	9'-0"
L119	BOYS' TRAINING ROOM	46	9'-0"
L120	BOYS' LOCKER	46	9'-0"
L121	CORRIDOR	123	10'-0"
L122	ATHLETIC LOCKER	237	10'-0"
L123	DRIVING ROOM	75	9'-0"
L124	DRIVING ROOM	57	9'-0"
L125	TOILET	66	9'-0"
L126	TOILET	104	9'-0"
L127	TOILET	104	9'-0"
L128	TOILET	104	9'-0"
L200	TOILET	104	9'-0"

- PLAN NOTES:**
1. PROVIDE EXHAUST FAN STARTER WITH A 277V COIL WIRE COIL TO THE SAME VOLTAGE AS THE LIGHT FIXTURE IN THIS ROOM.
 2. DIVISION 16 SHALL VERIFY EXACT LOCATION OF ROUGH-IN CONDUIT FROM WALL MOUNTED JUNCTION BOX TO EACH UNIT.
 3. SEE POWER PLAN UNIT N, SHEET E5.20 FOR DISPLAY CASE POWER REQUIREMENTS.
 4. SEE POWER PLAN UNIT K, SHEET E5.16 FOR DISPLAY CASE POWER REQUIREMENTS.
 5. DIVISION 16 SHALL WIRE FROM WALL MOUNTED JUNCTION BOX TO THE ICE MAKER TERMINALS IN SEAL TIGHT CONDUIT.

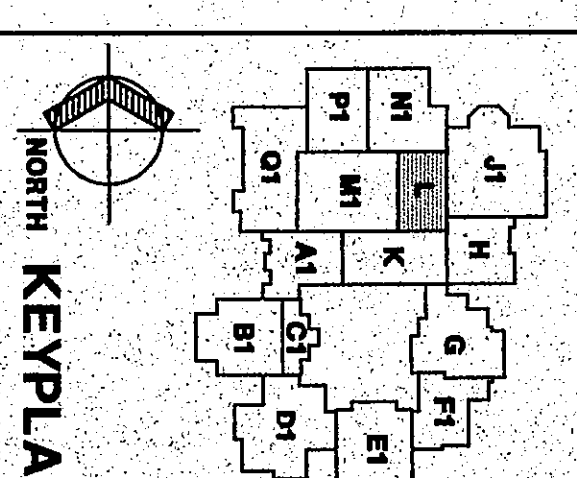

THE NEW
CHESTERTON HIGH SCHOOL
FOR THE
DUNELAND SCHOOL CORPORATION
CHESTERTON, INDIANA

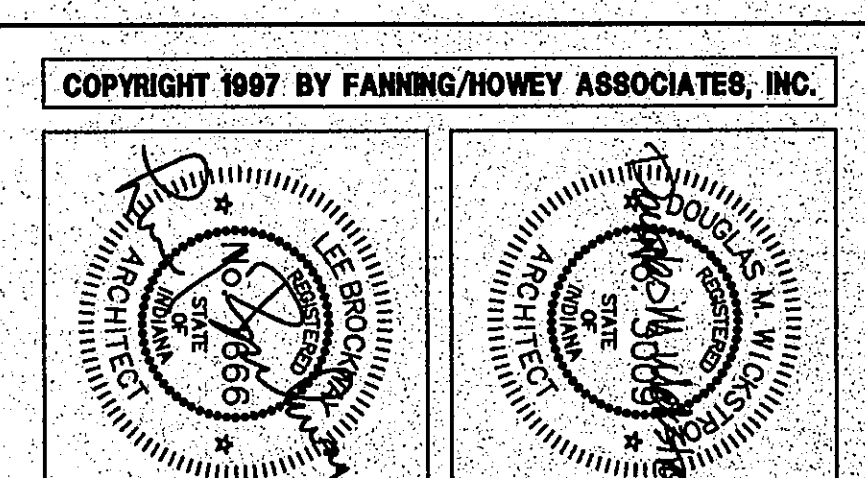

POWER PLAN UNIT L

DRAWN BY: MRS. COMM. NO.: 95067.00
CHECKED BY: WBH DATE: APRIL 21, 1997

E5.17

REVISIONS NO. DATE

Fanning/Howey Associates, Inc.
Architects Engineers Consultants

CHESTERTON HIGH SCHOOL
05/01/00