


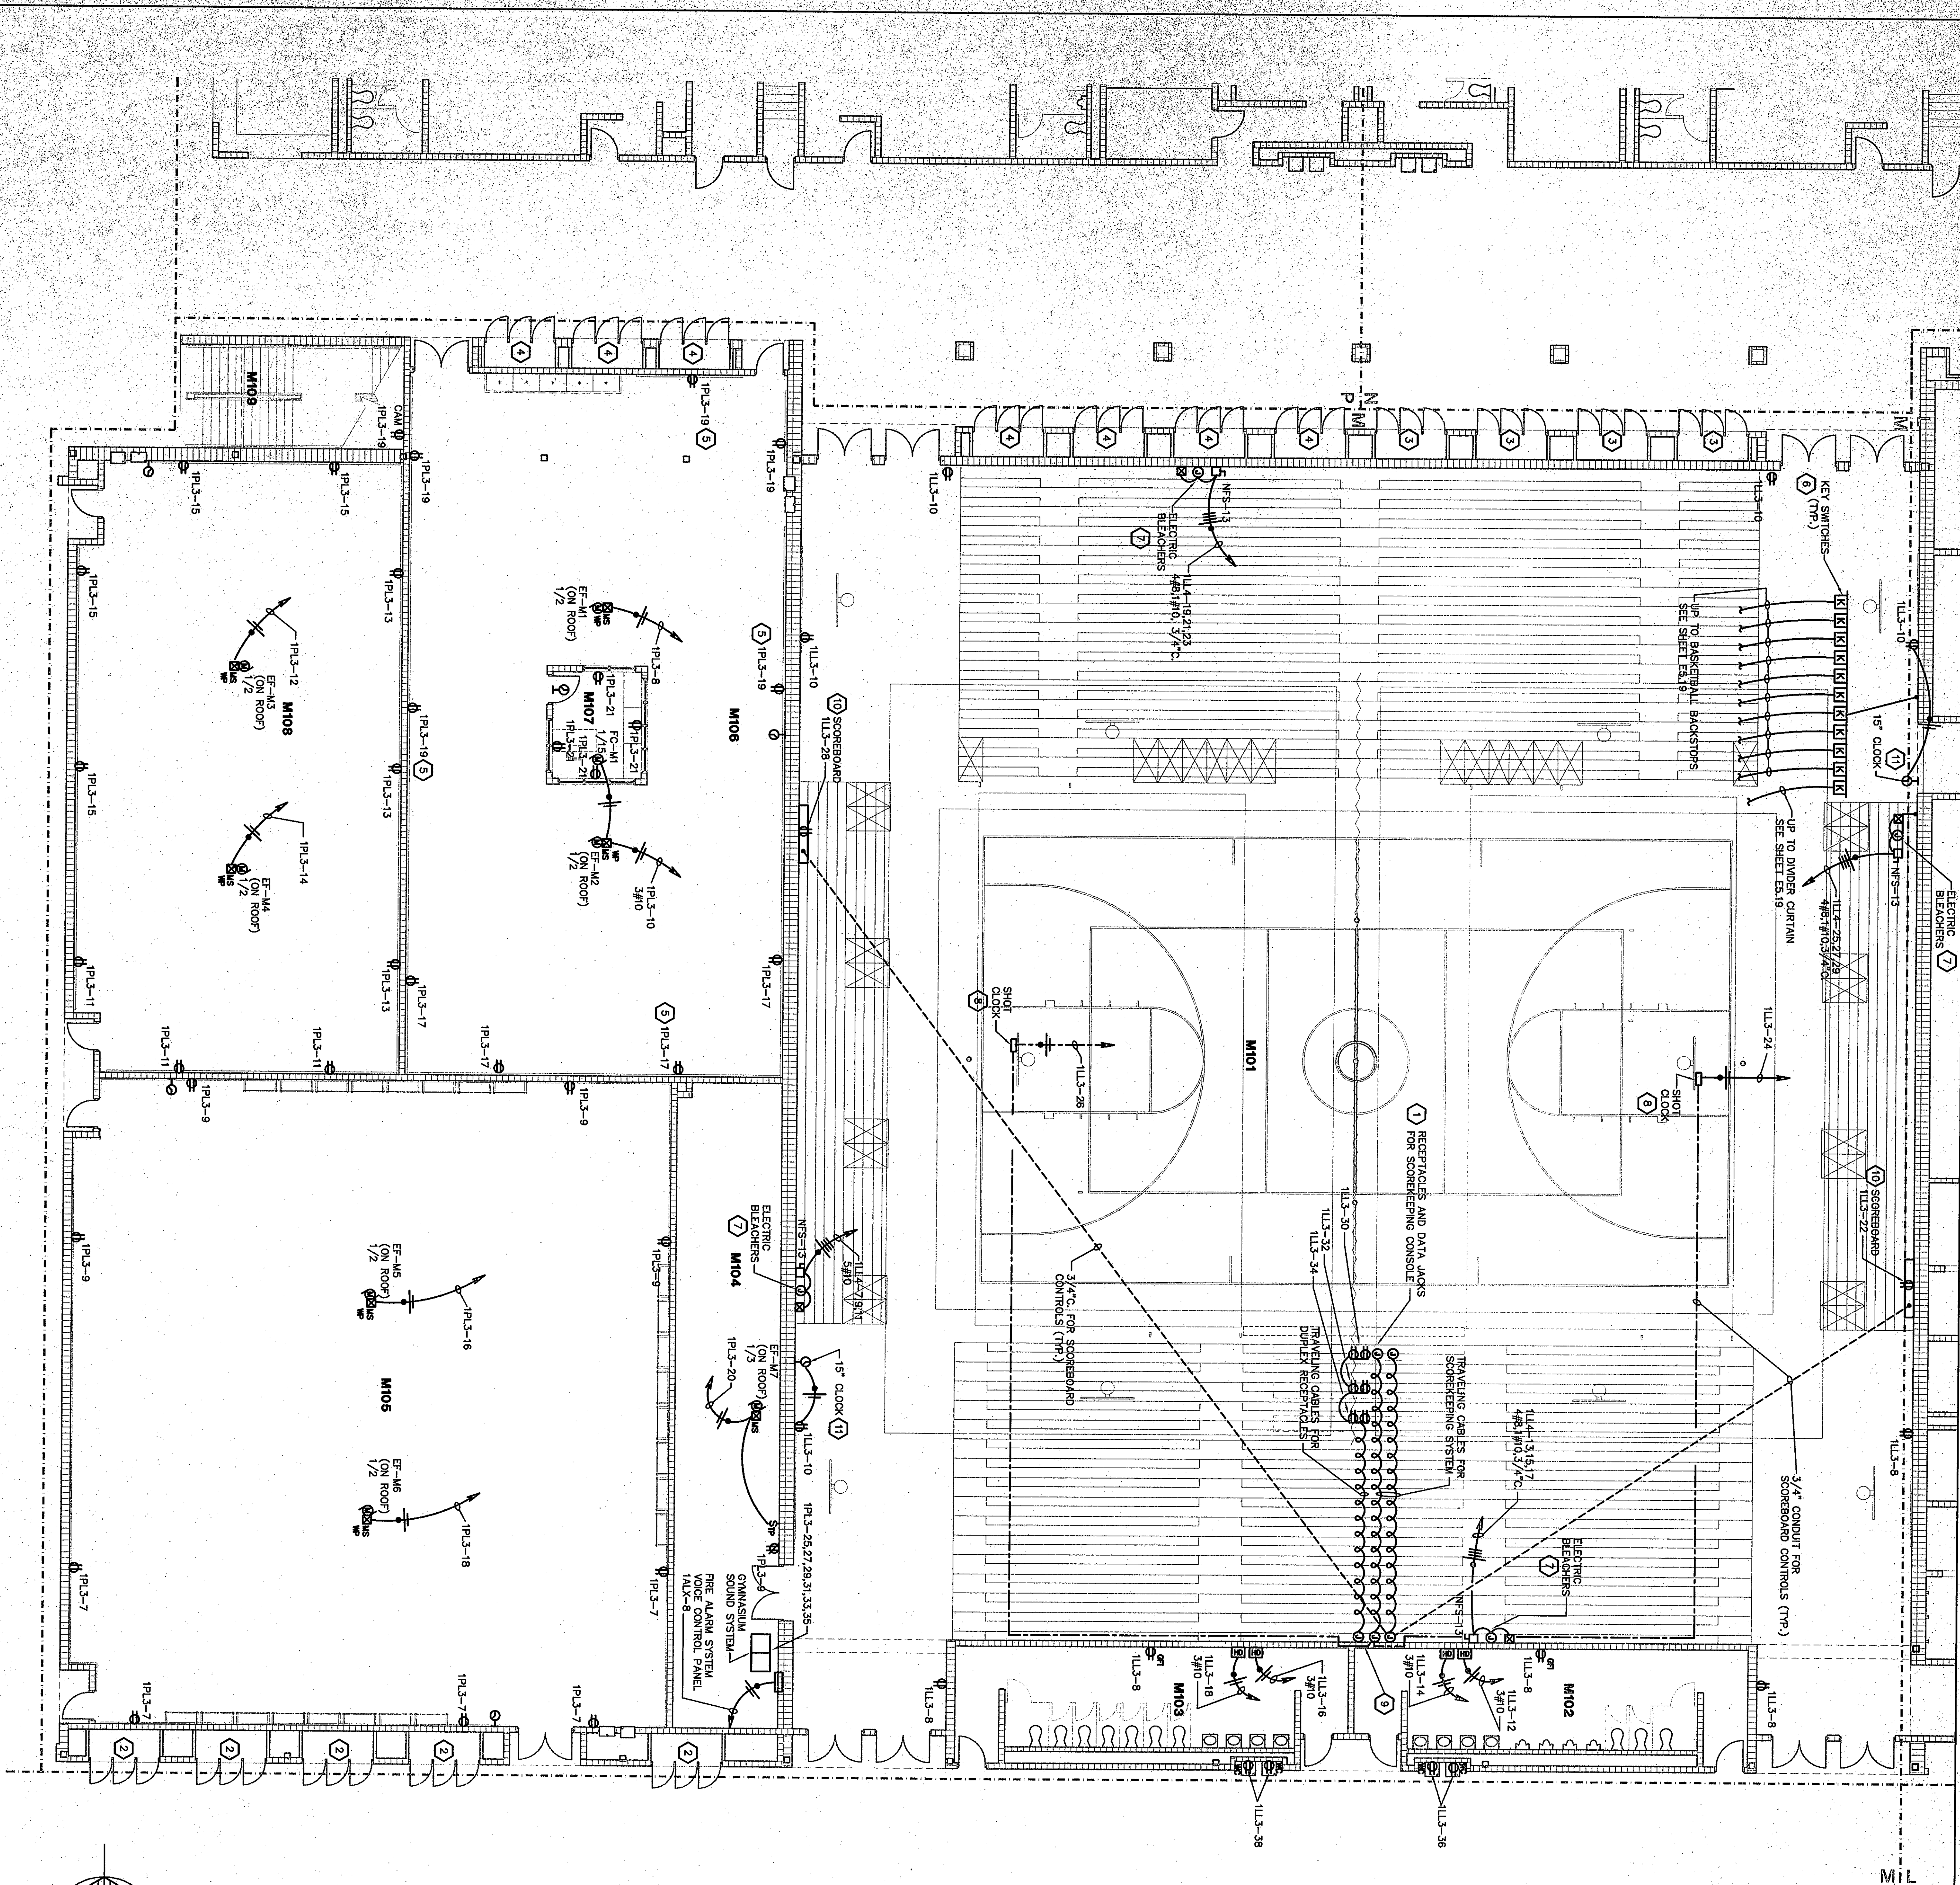


ROOM LEGEND "M1"			
ROOM NO.	ROOM NAME	AREA S.F.	CEILING HEIGHT
M101	GYMNASIUM	17084	9'-4"
M102	MEN'S TOILET	482	9'-4"
M103	WOMEN'S TOILET	482	9'-4"
M104	STORAGE	857	10'-0"
M105	RESTROOM	4853	10'-0"
M106	OFFICE	1201	9'-4"
M107	OFFICE	2475	10'-0"
M108	STAIR	247	

- PLAN NOTES:**
- RECEPTACLES AND SCORING JAWS MOUNTED ON THE FACE OF SECOND BLEACHER. SEE DETAILS 7/E/19 AND 5/E/19.
 - SEE POWER PLAN UNIT A1, SHEET E5.1, FOR DISPLAY CASE POWER REQUIREMENTS.
 - SEE POWER PLAN UNIT N1, SHEET E5.20, FOR DISPLAY CASE POWER REQUIREMENTS.
 - SEE POWER PLAN UNIT P1, SHEET E5.22, FOR DISPLAY CASE POWER REQUIREMENTS.
 - MOUNT ALL DUPLEX RECEPTACLES IN ROOM M106 AT 8 INCHES ABOVE FINISH FLOOR TO MISS WIRING.
 - KEY SWITCHES FOR BASKETBALL BACKSTOPS AND DIVIDER 16 SHALL MOUNT AND WIRE EACH KEY SWITCH DIVISOR MANUFACTURER. VERIFY EXACT LOCATION IN DETAIL 5/E/19 FOR ADDITIONAL INFORMATION.
 - BLEACHER JUNCTION BOX. VERIFY EXACT LOCATION IN DETAIL 5/E/19 FOR ADDITIONAL INFORMATION.
 - REFER TO DETAIL 6/E/19 FOR ADDITIONAL INFORMATION ON WALL JUNCTION BOXES.
 - MOUNT SCOREBOARD RECEPTACLE PER MANUFACTURER REQUIREMENTS. REFER TO DETAIL 7/E/19 FOR SCOREBOARD MOUNTING HEIGHT.
 - PROVIDE CLOCK WITH WIRE GUARD.

POWER PLAN UNIT M1

SCALE 1/8" = 1'-0"

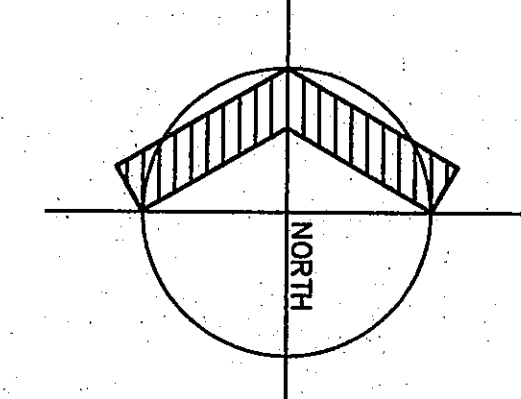

POWER PLAN UNIT M1

DRAWN BY: MRS. WDH

CHECKED BY: WDH

COMM. NO.: 95067.00


DATE: APRIL 21, 1997

REVISIONS NO. DATE

E5.18

Fanning/Howey Associates, Inc.

Architects Engineers Consultants

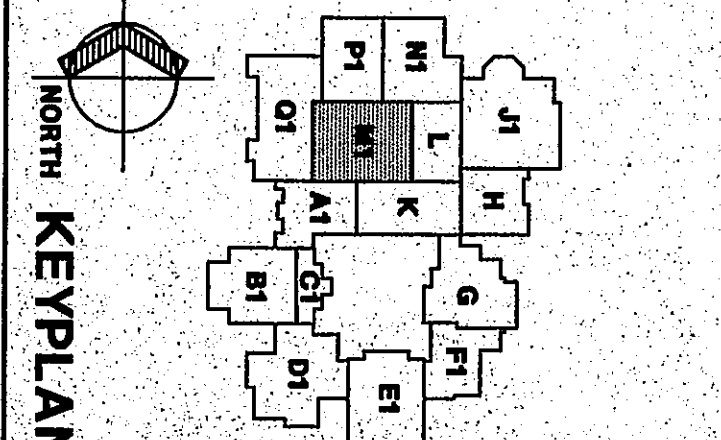

THE NEW

CHESTERTON HIGH SCHOOL

FOR THE

DUNELAND SCHOOL CORPORATION

CHESTERTON, INDIANA

COPYRIGHT 1997 BY FANNING/HOWEY ASSOCIATES, INC.