
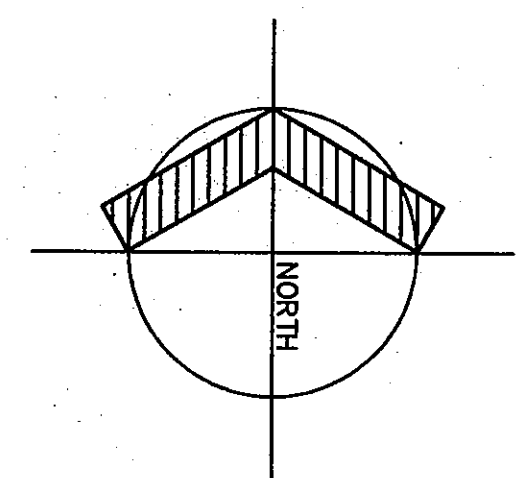


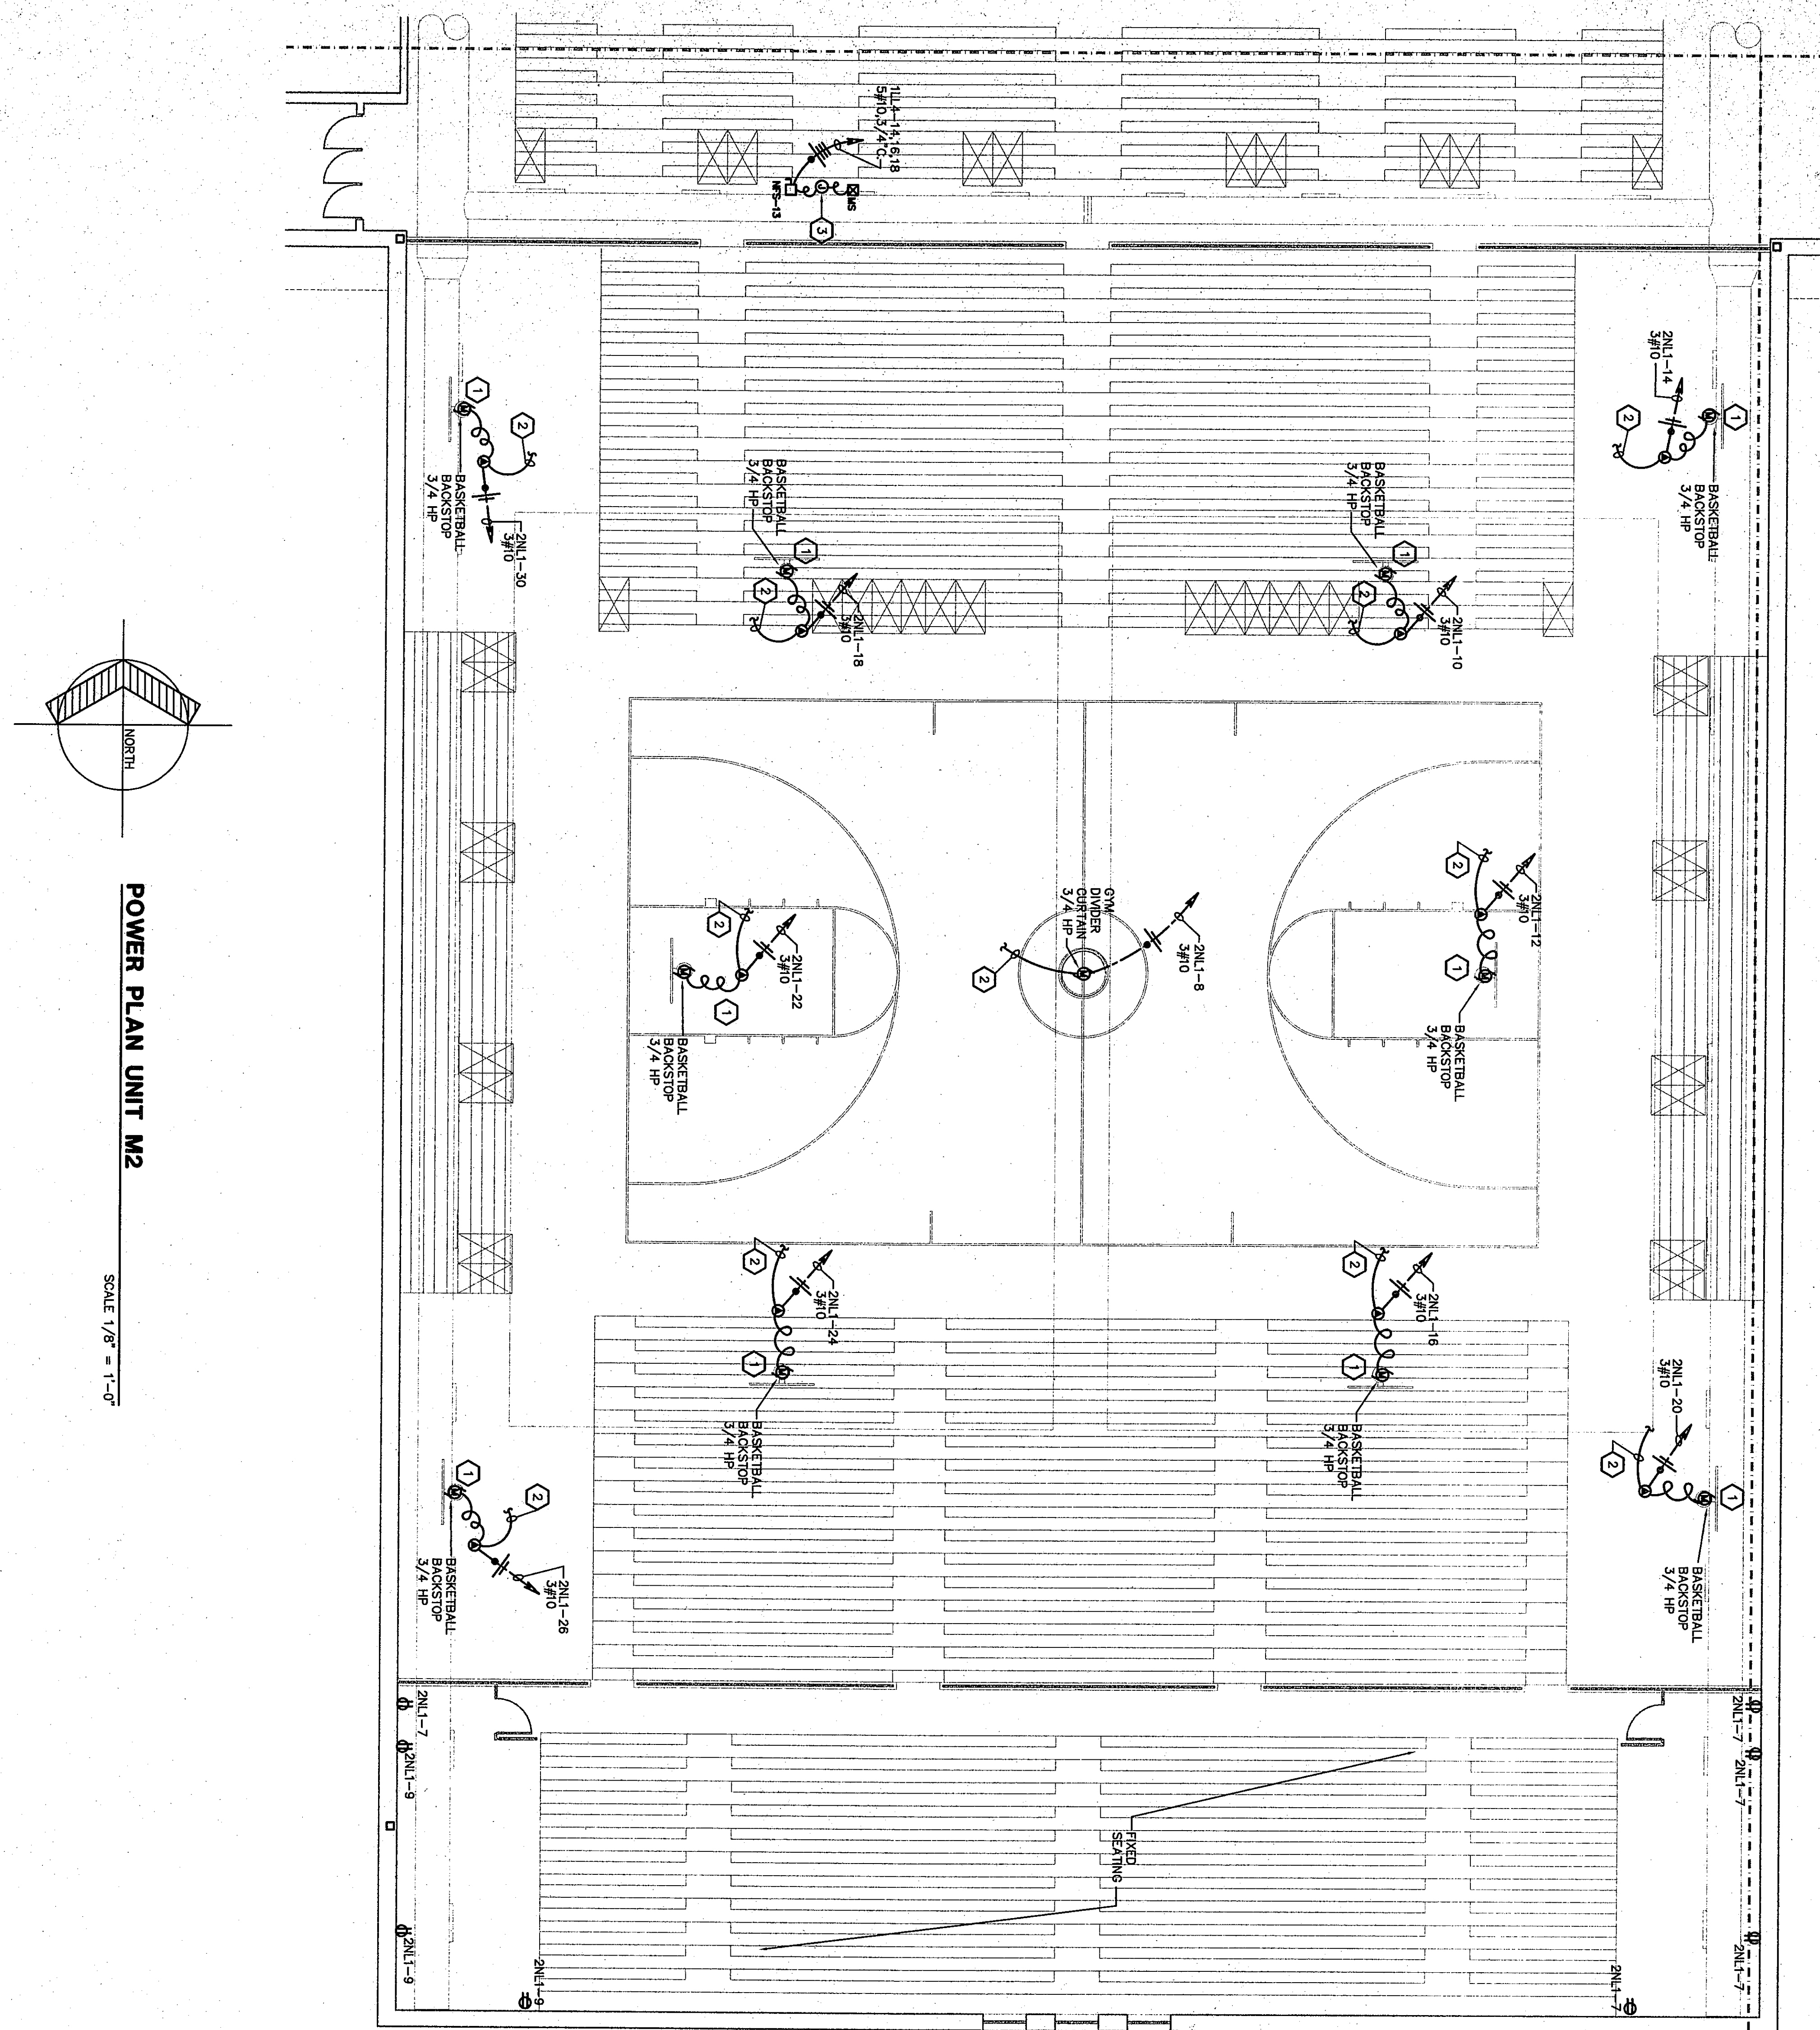

POWER PLAN UNIT M2

SCALE 1/8" = 1'-0"

ROOM LEGEND "M2"			
ROOM NO.	ROOM NAME	AREA S.F.	CEILING HEIGHT
M201	SEATING MEZZANINE	3746	---

PLAN NOTES:

- 1 BASKETBALL BACKSTOP SHALL BE RECEIVED BY UNIT MANUFACTURER. DIVISION 16 SHALL COUNT AND REPAIR. VERIFY EXACT LOCATION OF BACKSTOP MOTOR AND RECEPTACLE BEFORE ROUGH-IN.
- 2 DIVISION 16 SHALL RUN CONTROL WIRES FROM BACKSTOP AND DIVIDE CURRENT TO KEY SWITCHES. SEE SHEET E518 FOR LOCATION. VERIFY EXACT NUMBER OF CONTROL WIRES WITH UNIT MANUFACTURER.
- 3 BLEACHER JUNCTION BOX LOCATION UNDER SEAT COLUMNS BLEACHER. ALTERNATE. VERIFY EXACT LOCATION IN FIELD WITH BLEACHER MANUFACTURER. REFER TO DETAIL E-5119 FOR ADDITIONAL INFORMATION.

M-E-87

POWER PLAN UNIT M2

DRAWN BY: MRS. COMM. NO.: 95067.00

CHECKED BY: WBH DATE: APRIL 21, 1997

REVISIONS NO. DATE

E5.19

Fanning/Howey Associates, Inc.
Architects Engineers Consultants

NORTH KEY PLAN

THE NEW
CHESTERTON HIGH SCHOOL
FOR THE
DUNELAND SCHOOL CORPORATION
CHESTERTON, INDIANA

COPYRIGHT 1997 BY FANNING/HOWEY ASSOCIATES, INC.