


06


POWER PLAN GYMNASIUMS AREA
(ALTERNATE BID)

SCALE 1/8" = 1'-0"

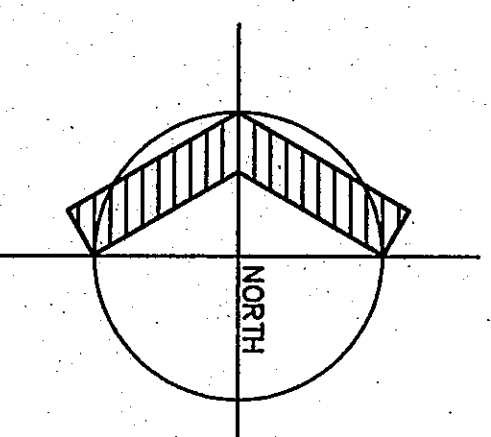

POWER PLAN UNIT N1

SCALE 1/8" = 1'-0"

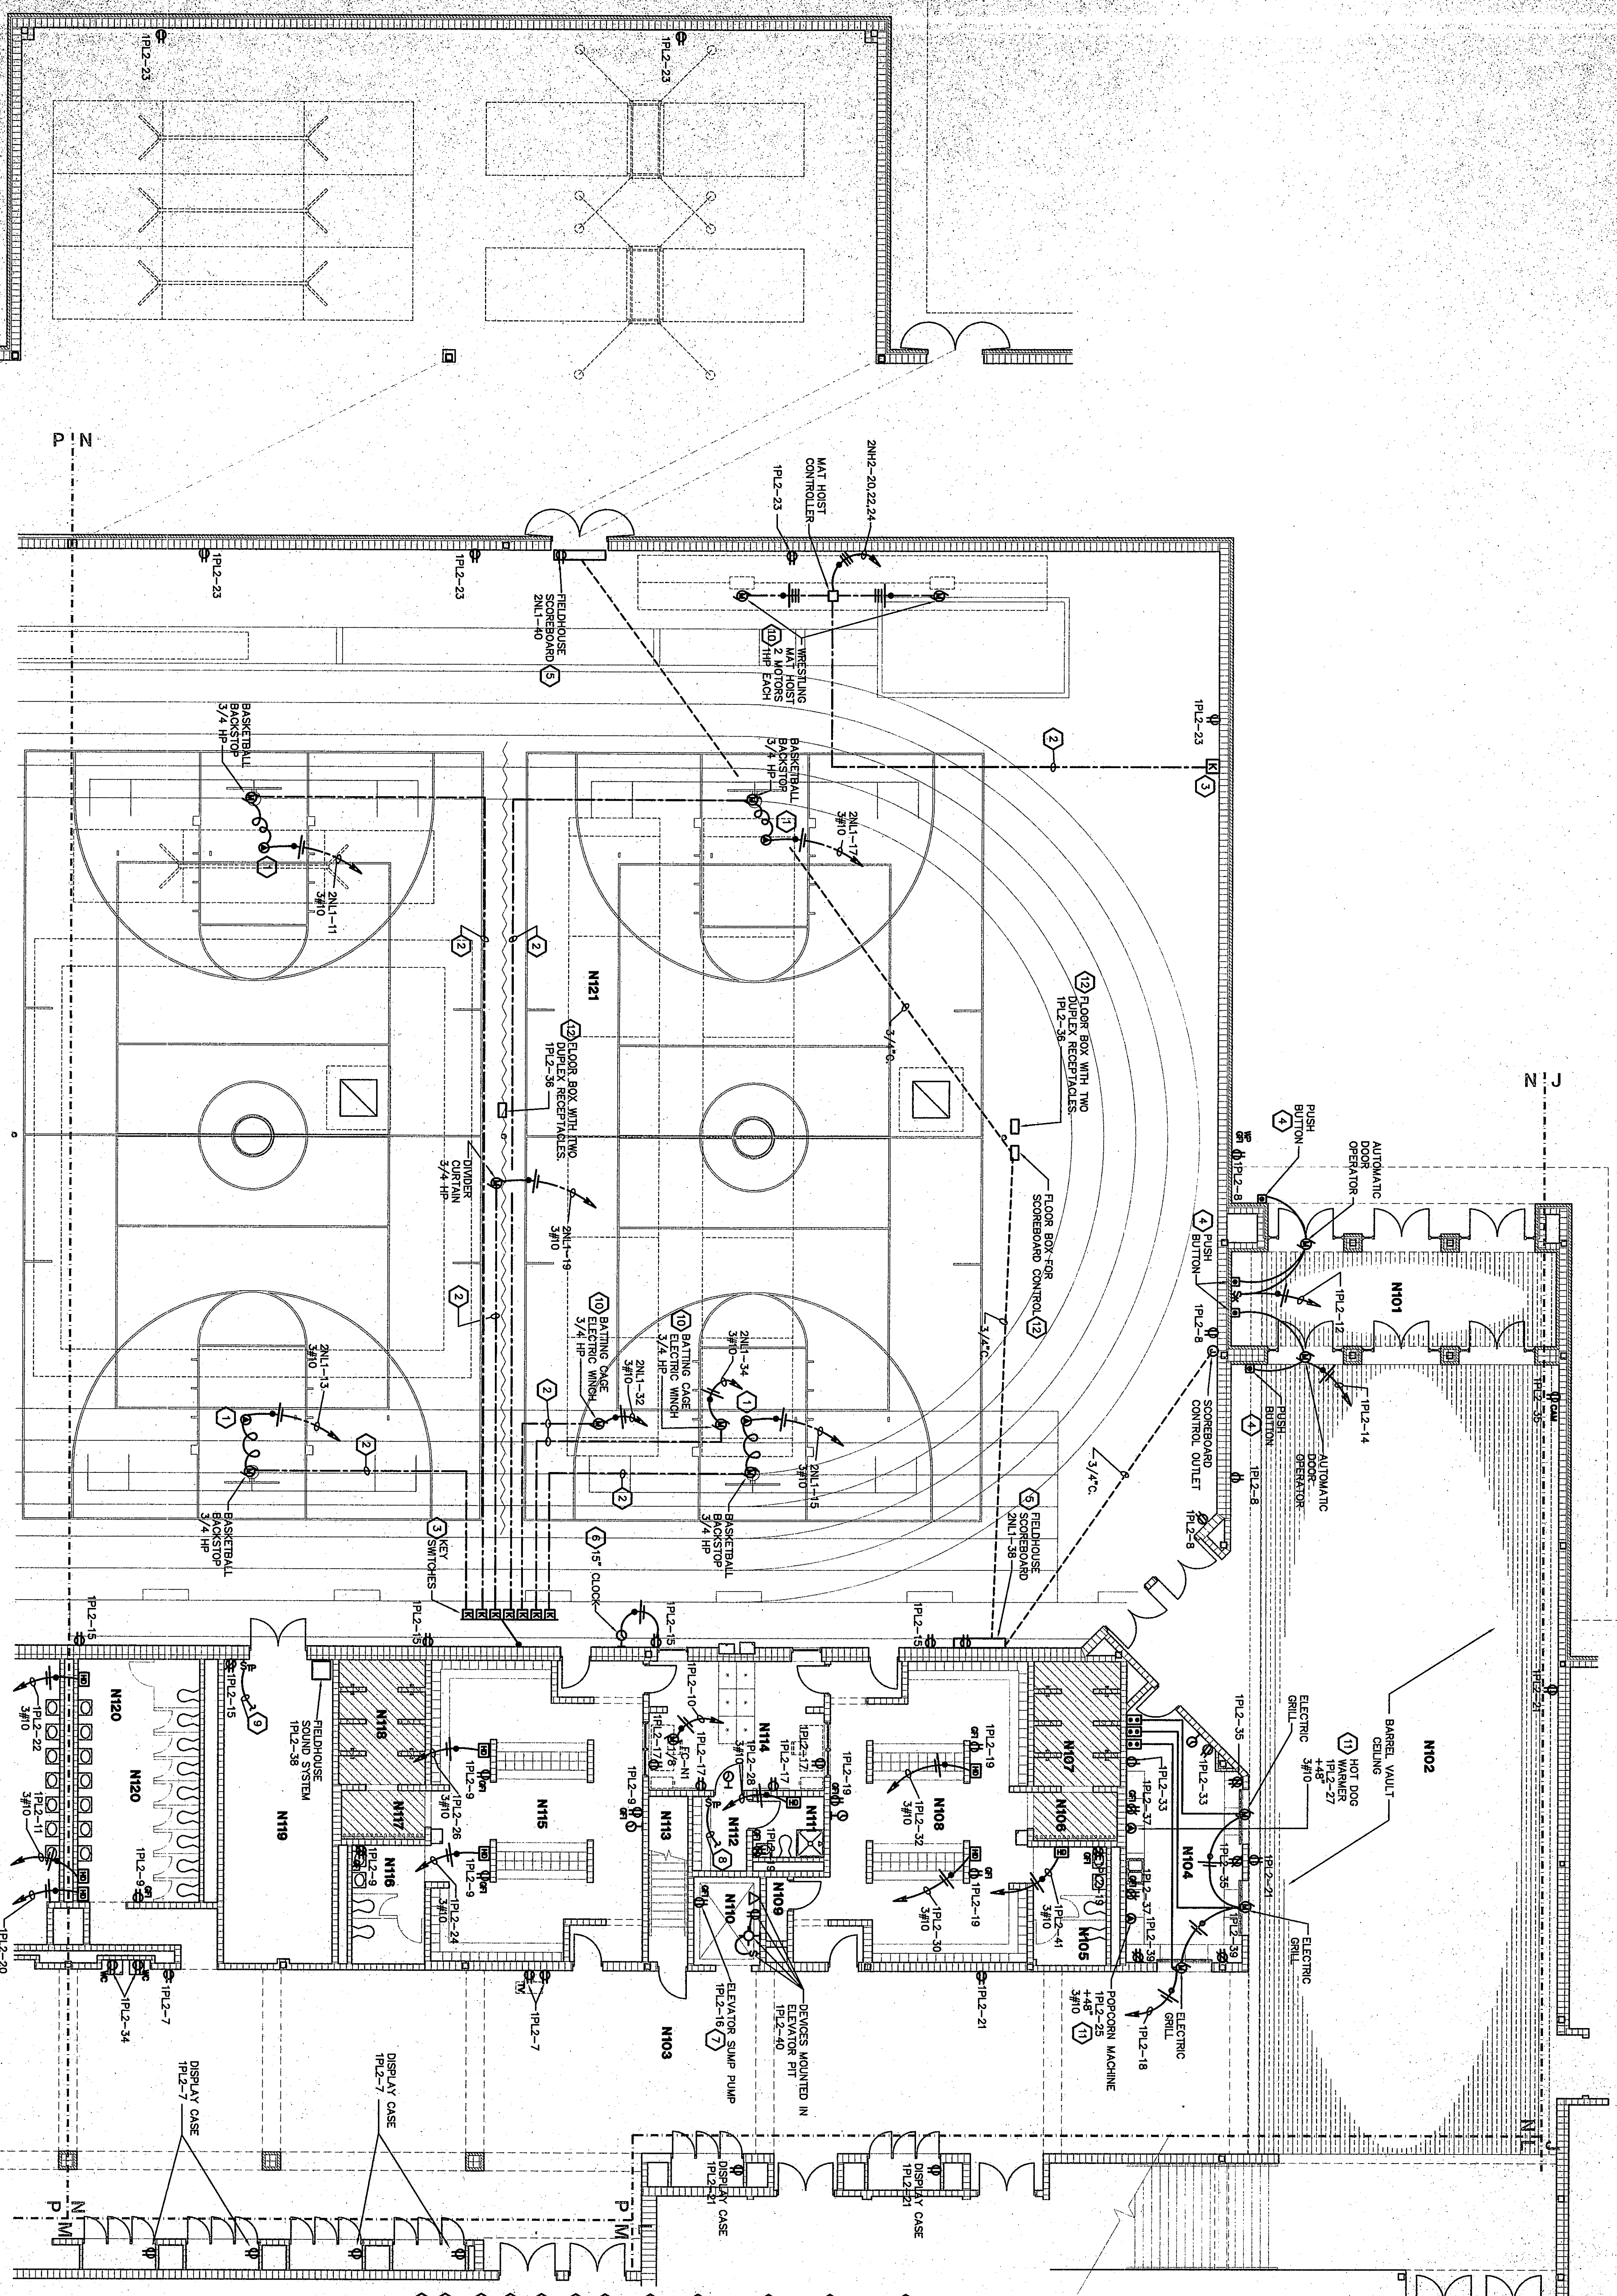


PLAN NOTES:

1. BASKETBALL BACKSTOP SPECIAL PURPOSE RECEPTACLE PROVIDED BY UNIT MANUFACTURER. DIVISION 16 SHALL VERIFY EXACT LOCATION OF BACKSTOP MOTOR AND RECEPTACLE BEFORE ROUGH-IN.
2. DIVISION 16 SHALL RUN CONTROL WIRE FROM BACKSTOP SWITCHES TO UNIT MANUFACTURER. DIVISION 16 SHALL VERIFY EXACT LOCATION OF BACKSTOP MOTOR AND RECEPTACLE BEFORE ROUGH-IN.
3. KEY SWITCHES FOR BASKETBALL BACKSTOP MAT HOST MANUFACTURER. DIVISION 16 SHALL VERIFY EXACT LOCATION OF BACKSTOP MAT HOST MANUFACTURER AND NUMBER OF CONTROL WIRING WITH MANUFACTURER.
4. DOOR OPERATOR PUSH BUTTON STATIONS BY UNIT MANUFACTURER. DIVISION 16 SHALL VERIFY EXACT LOCATION OF EACH DEVICE.
5. FINISH FLOOR. VERIFY EXACT LOCATION OF RECEPTACLE WITH MANUFACTURER.
6. MOUNT CLOCK AT 11'-0" ABOVE FINISH FLOOR.
7. VERIFY EXACT LOCATION OF SLUMP PUMP WITH DIVISION 15.
8. CONTINUED ABOVE TO E5-N2. SEE SHEET E5.21.
9. CONTINUED ABOVE TO E5-N4. SEE SHEET E5.21.
10. VERIFY EXACT LOCATION OF EACH ELECTRIC WINCH AND HOST MOTOR DEVICE ROOM-N.
11. PROVIDE A NECA 5-30R RECEPTACLE.
12. PROVIDE A DOUBLE GANG HUBBELL FLOOR BOX.


ROOM LEGEND "N"

ROOM	AREA	CEILING	FLOOR
N01	397	10'-0"	10'-0"
N02	3554	10'-0"	10'-0"
N03	3297	10'-0"	10'-0"
N04	104	9'-4"	9'-4"
N05	48	9'-4"	9'-4"
N06	749	9'-4"	9'-4"
N07	18	9'-4"	9'-4"
N08	52	9'-4"	9'-4"
N09	52	9'-4"	9'-4"
N10	272	9'-4"	9'-4"
N11	763	9'-4"	9'-4"
N12	48	9'-4"	9'-4"
N13	150	9'-4"	9'-4"
N14	425	9'-4"	9'-4"
N15	15052	9'-4"	9'-4"

KEY PLAN

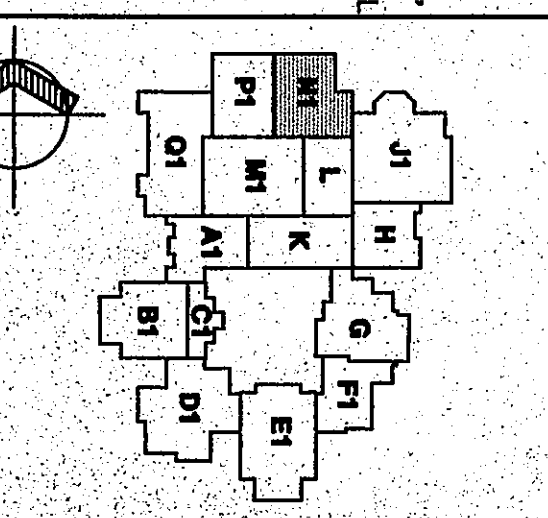

THE NEW
CHESTERTON HIGH SCHOOL
FOR THE
DUNELAND SCHOOL CORPORATION
CHESTERTON, INDIANA

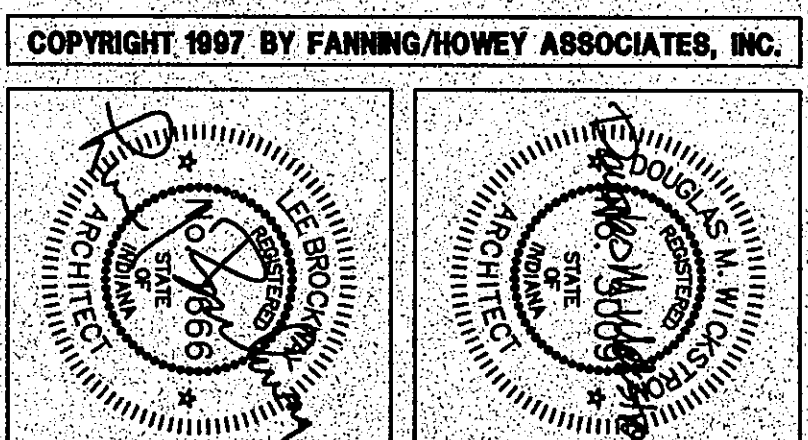

POWER PLAN UNIT N1

DRAWN BY: MRS. COMM. NO.: 95067.00
CHECKED BY: WGH DATE: APRIL 21, 1997

REVISIONS NO. DATE

E5.20

CHESTERTON HIGH SCHOOL
95057.00

Fanning/Howey Associates, Inc.
Architects Engineers Consultants