



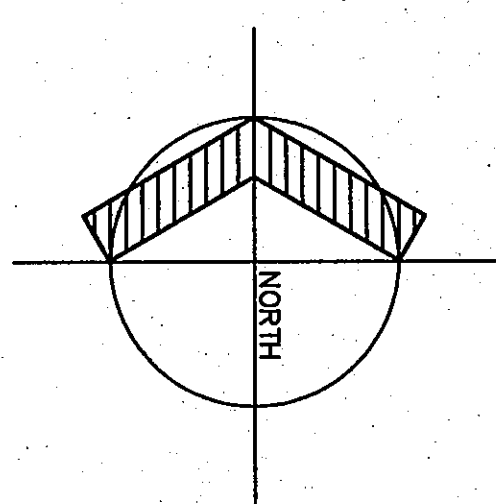

POWER PLAN UNIT N2

SCALE 1/8" = 1'-0"

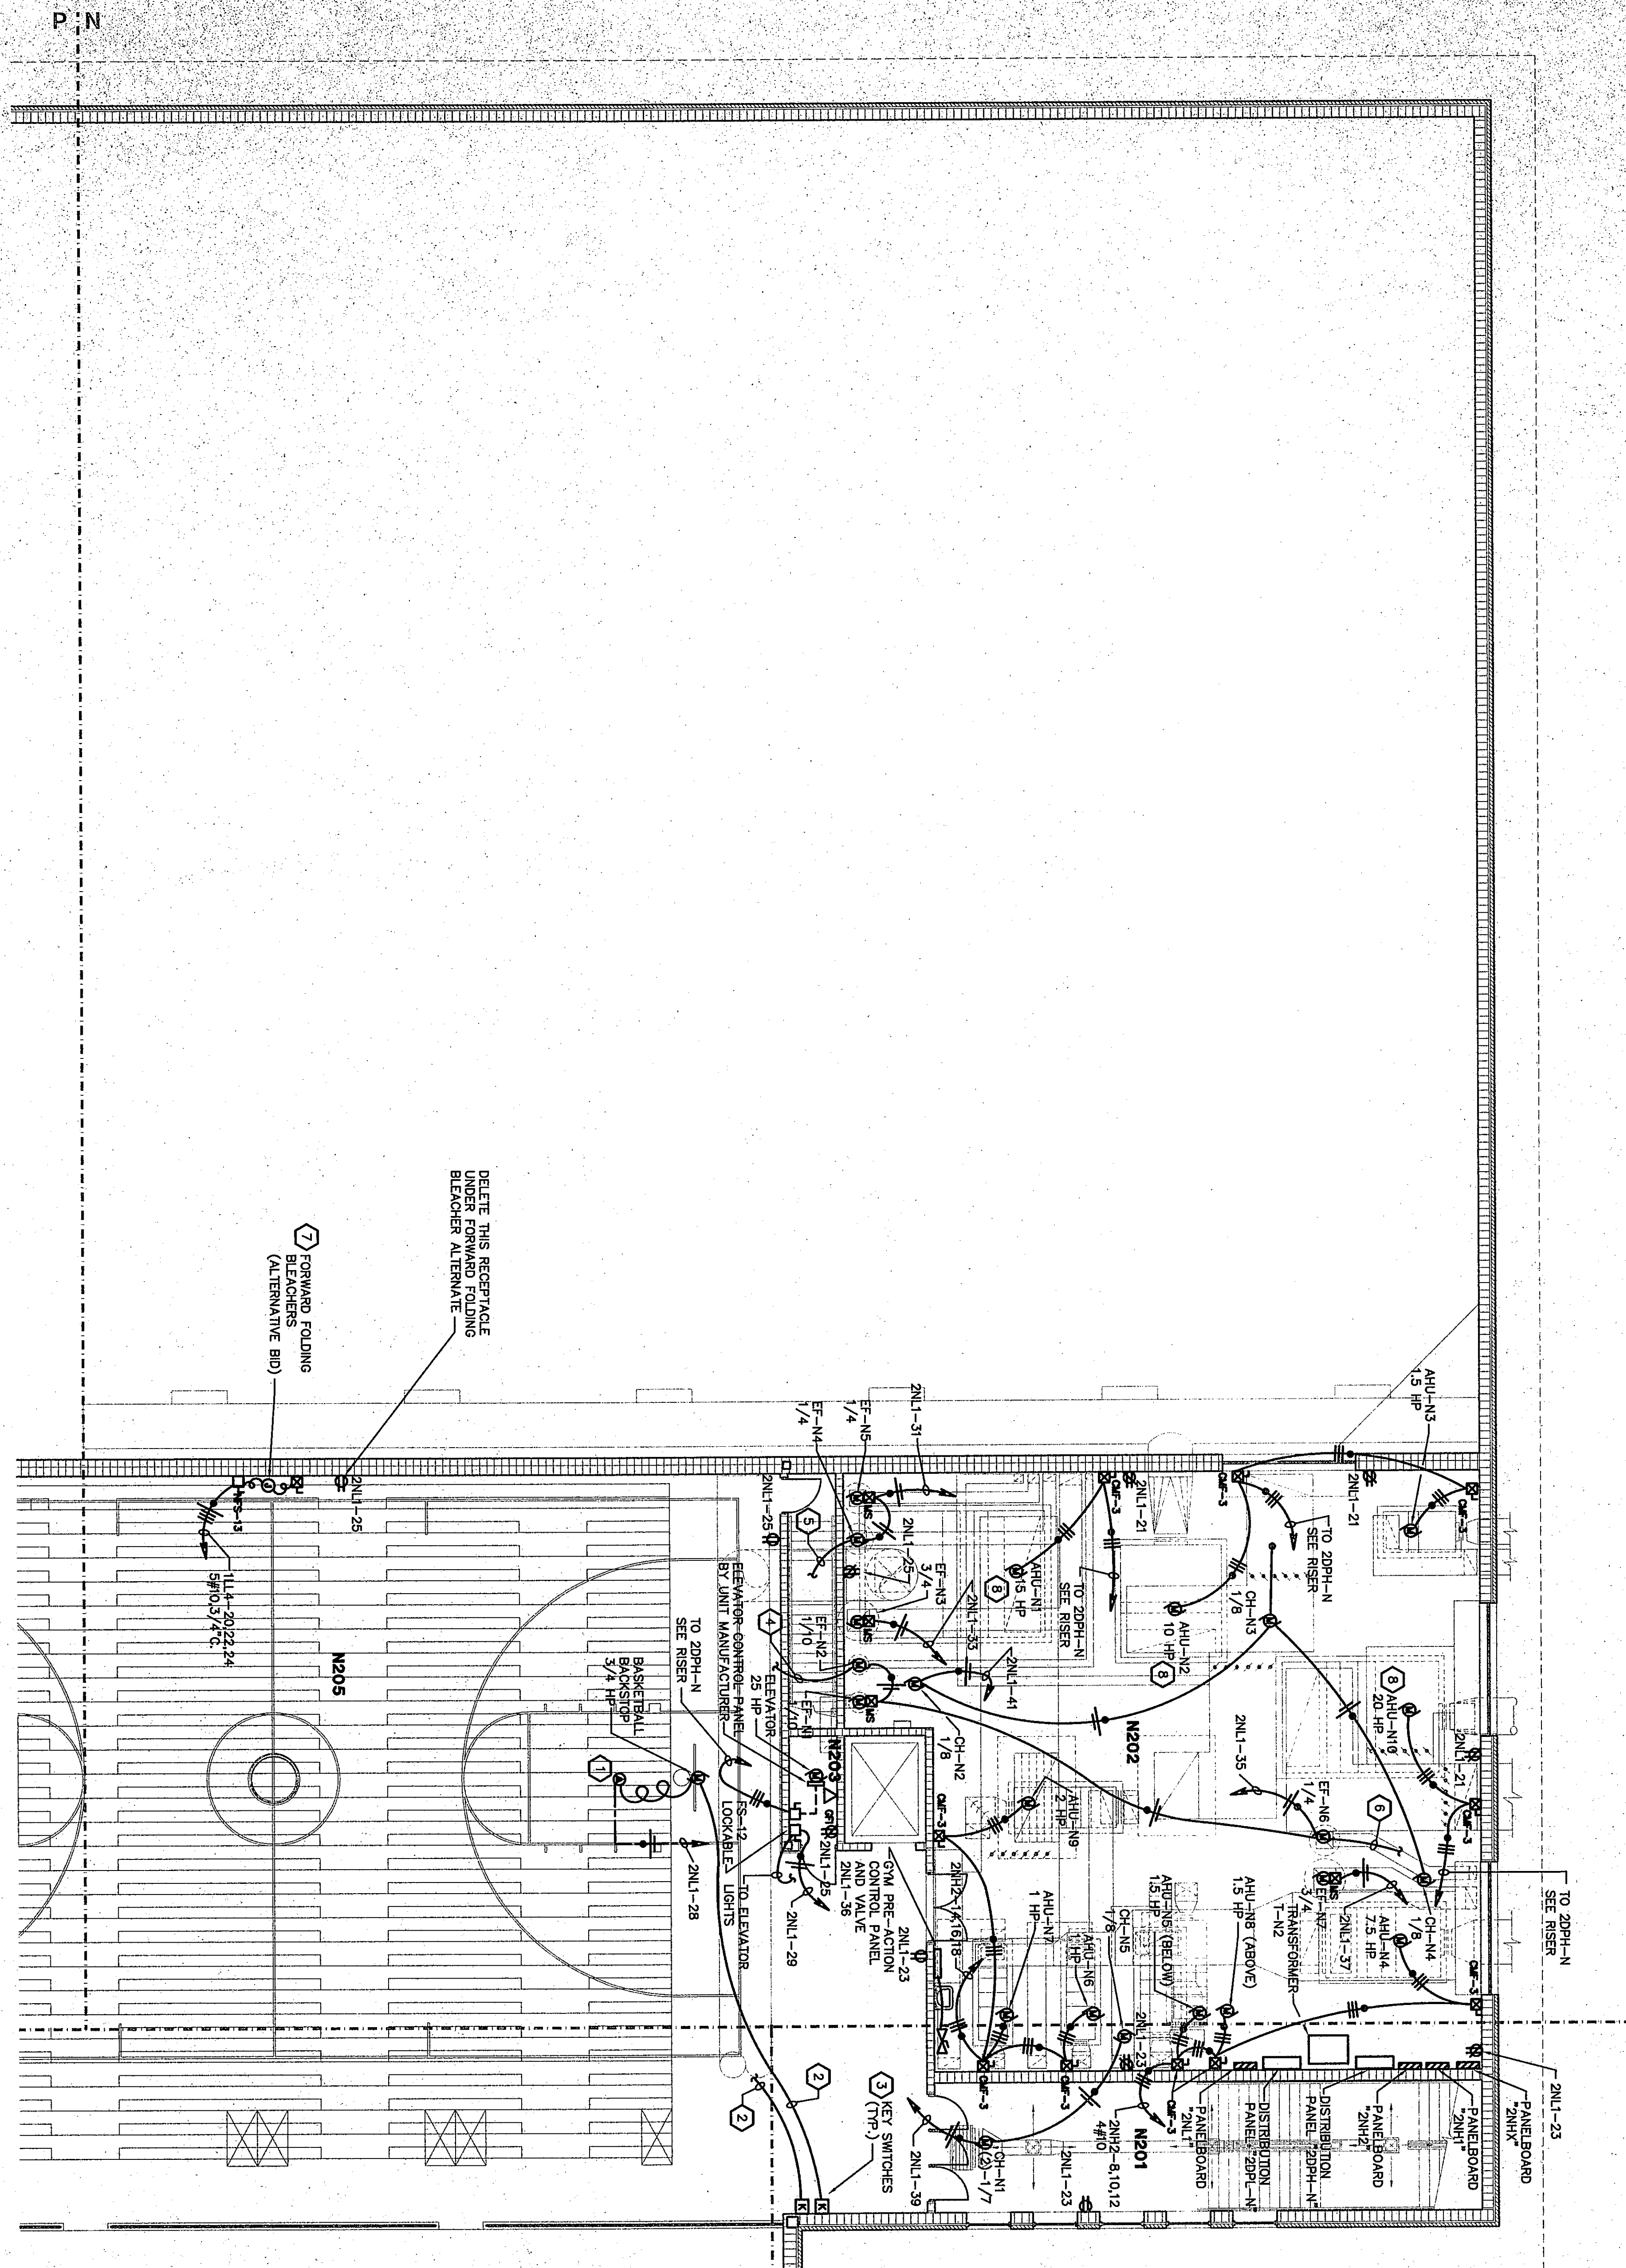


PLAN NOTES:


1. BASKETBALL BACKSTOP SPECIAL PURPOSE RECEPTACLE PROVIDED BY UNIT MANUFACTURER. DIVISION 16 SHALL MOUNT AND WIRE RECEPTACLE. VERIFY EXACT LOCATION OF BACKSTOP MOTOR AND RECEPTACLE BEFORE ROUGH-IN.
2. DIVISION 16 SHALL RUN CONTROL WIRES FROM BACKSTOP TO KEY SWITCHES. SEE THIS SHEET AND SHEET E5.23 FOR LOCATION. VERIFY EXACT NUMBER OF CONTROL WIRES WITH UNIT MANUFACTURER.
3. KEY SWITCHES FOR BASKETBALL BACKSTOPS PROVIDED BY UNIT MANUFACTURER. DIVISION 16 SHALL MOUNT AND WIRE EACH KEY SWITCH. VERIFY BACKBOX SIZE AND NUMBER OF CONTROL WIRES WITH MANUFACTURER.
4. CONTINUED BELOW TO "5" IN ROOM N112. SEE SHEET E5.20.
5. CONTINUED BELOW TO "5" IN ROOM N119. SEE SHEET E5.20.
6. CONTINUED BELOW TO "5" IN ROOM N104. SEE SHEET E5.20.
7. BLEACHER JUNCTION BOX. VERIFY EXACT LOCATION IN FIELD PER BLEACHER MANUFACTURER. REFER TO DETAIL "3" E1.9 FOR ADDITIONAL INFORMATION.
8. PROVIDE PHASE FAILURE RELAY SQUARE D MODEL 9450-015W OR ENGINEER APPROVED EQUAL. PROVIDE PHASE FAILURE RELAY TERMINALS AND CONTROL CIRCUIT OF STARTER TO OPEN STARTER UPON SENSING PHASE LOSS.

ROOM LEGEND "N2"


ROOM	AREA	CEILING
N201	MECA	10'-8"
N202	STAIR	579
N203	MECHANICAL ROOM	2866
N204	ELEVATOR EQUIPMENT	57
N205	BALCONY COURT	4881

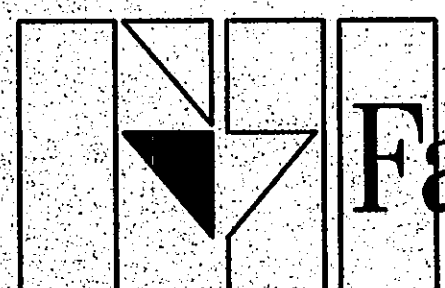

Fanning/Howey Associates, Inc.
Architects Engineers Consultants

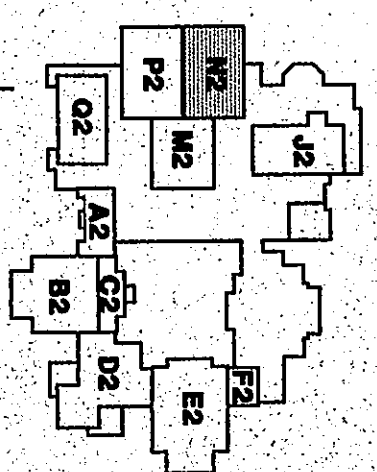

THE NEW
CHESTERTON HIGH SCHOOL
FOR THE
DUNELAND SCHOOL CORPORATION
CHESTERTON, INDIANA

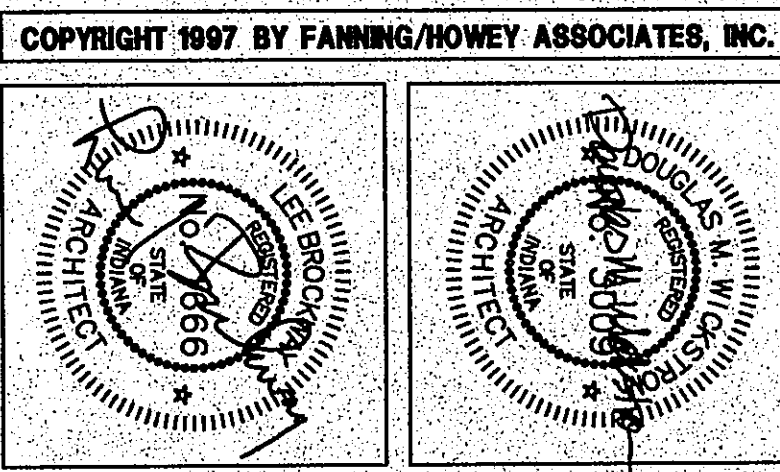

COPYRIGHT 1997 BY FANNING/HOWEY ASSOCIATES, INC.

E5.21

POWER PLAN UNIT N2

DRAWN BY: MRS. COMM. NO.: 95067.00
CHECKED BY: WBH DATE: APRIL 21, 1997

REVISIONS NO. DATE

CHESTERTON HIGH SCHOOL
95067.00