


92

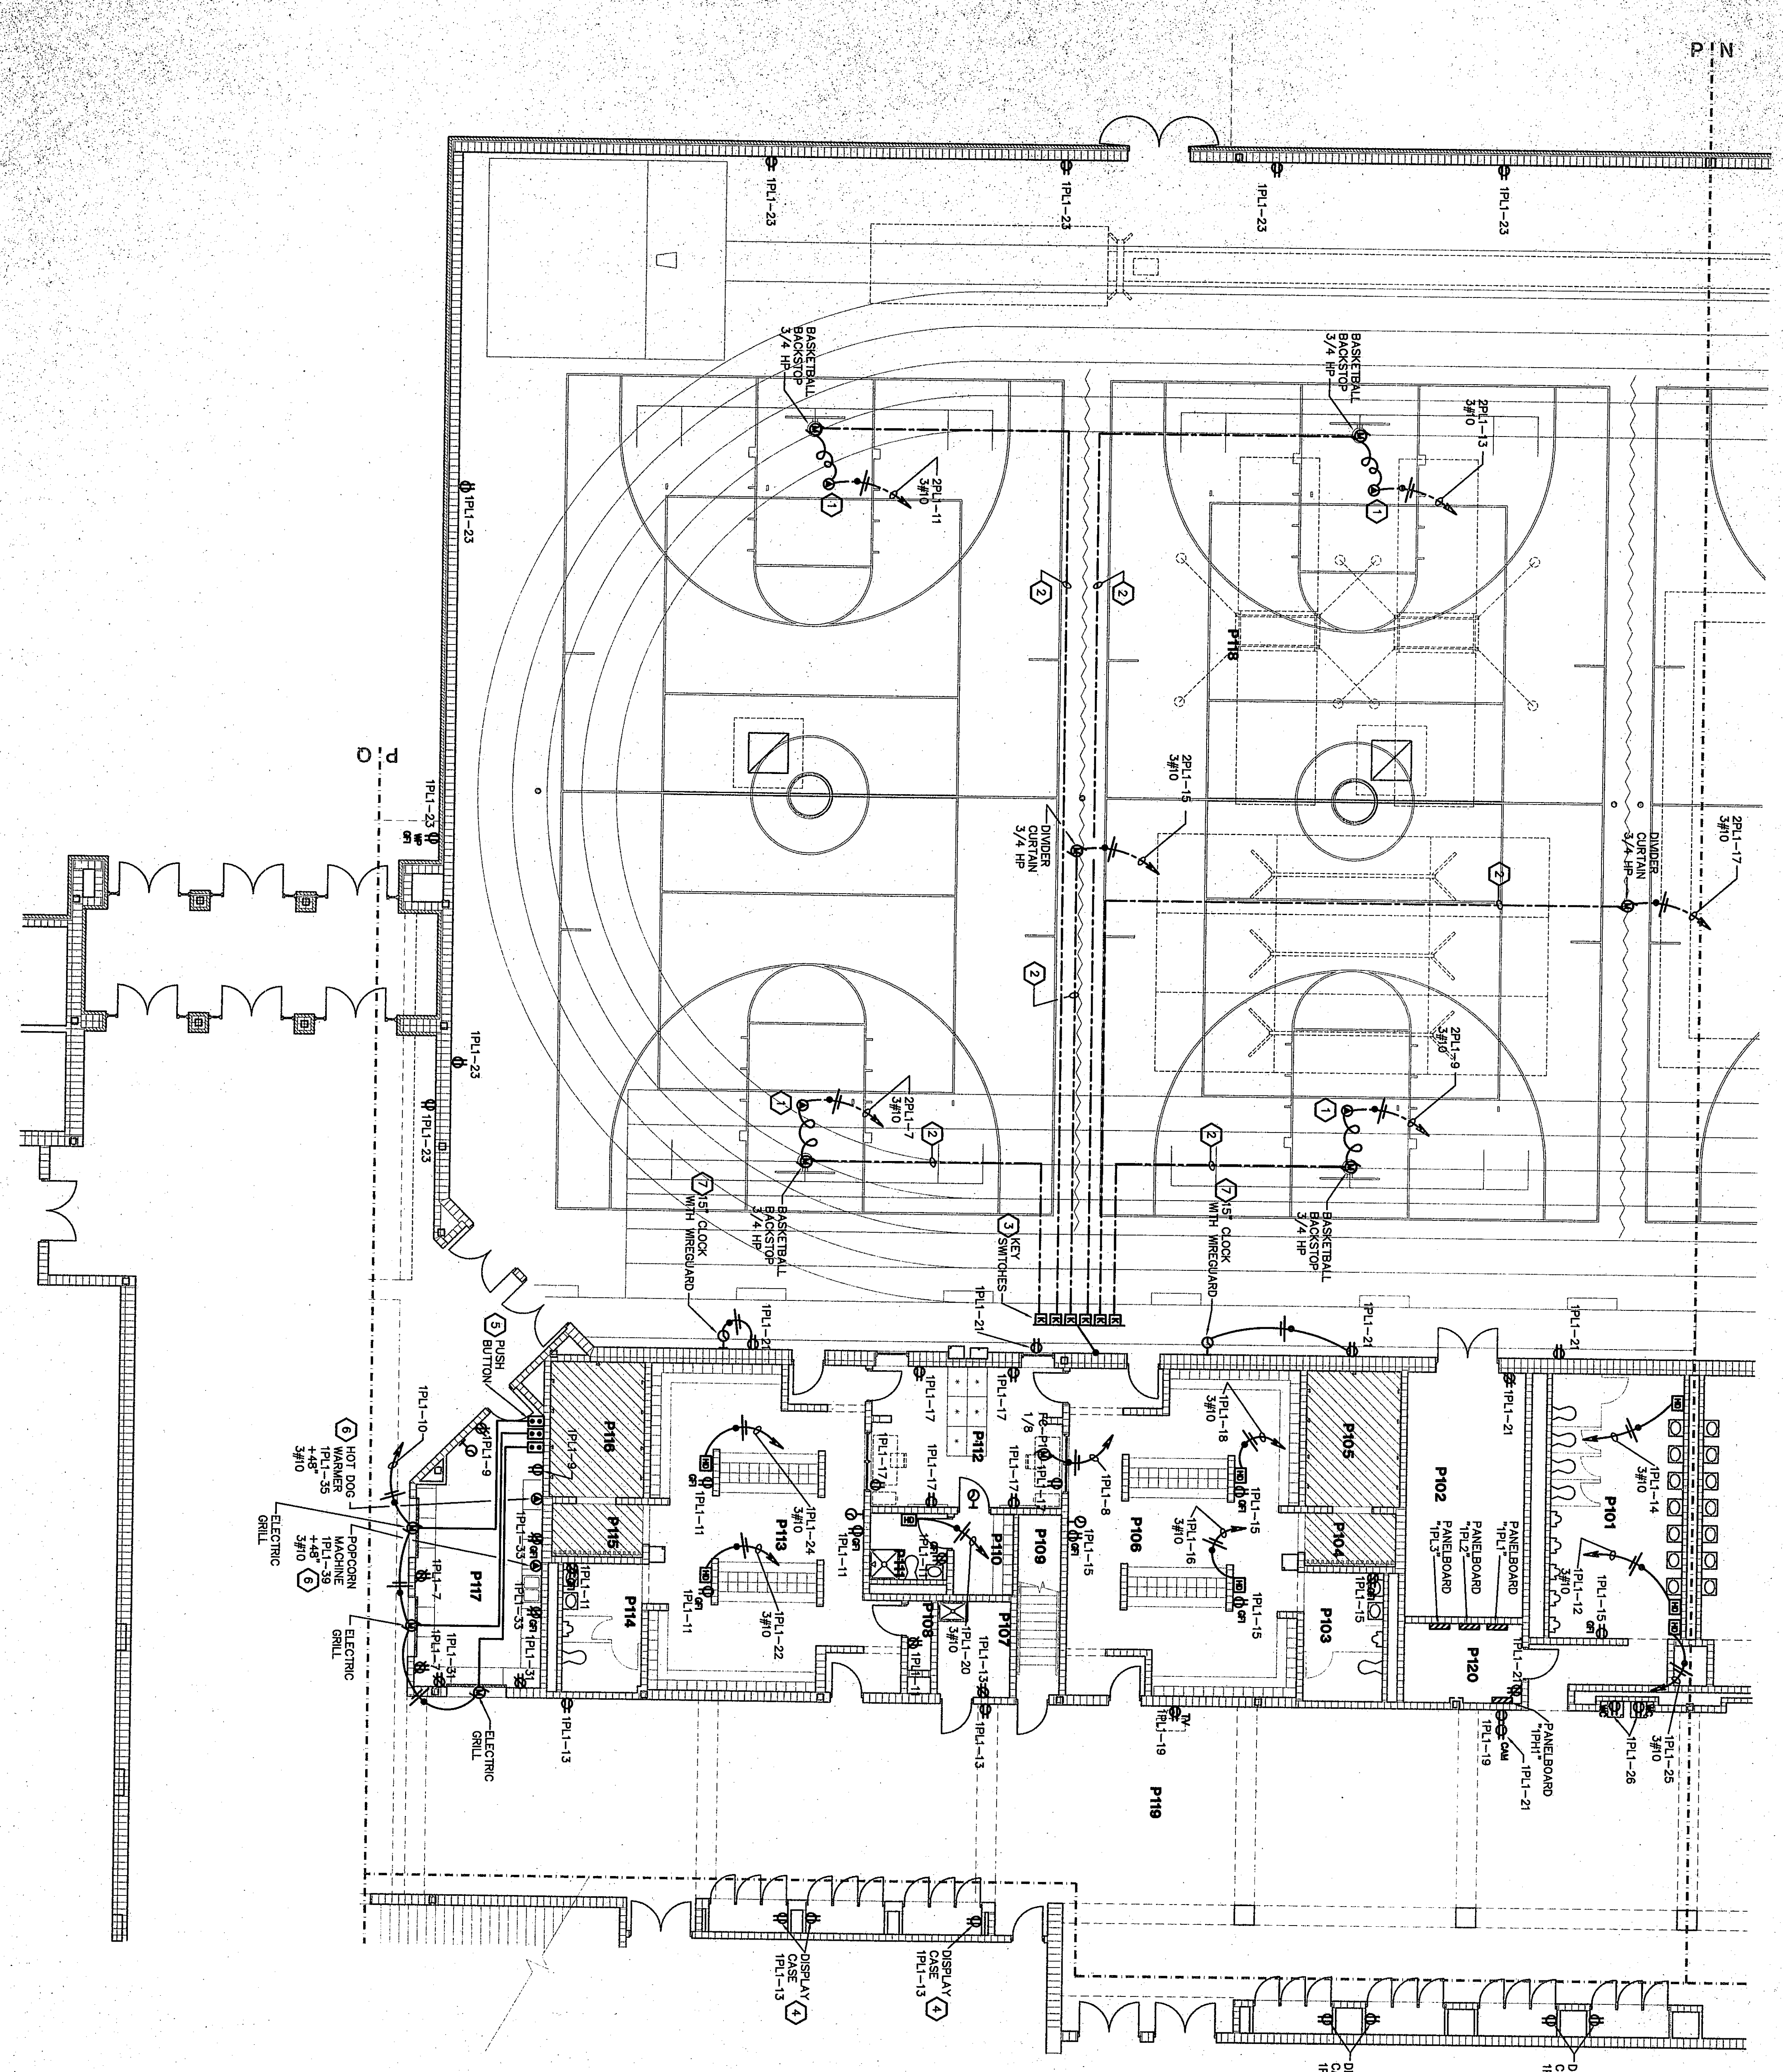

POWER PLAN UNIT P1

SCALE 1/8" = 1'-0"

- PLAN NOTES:**
- 1 BASKETBALL BACKSTOP SPECIAL PURPOSE RECEPTACLE PROVIDED BY UNIT MANUFACTURER. DIVISION 16 SHALL RUN CONTROL WIRE FROM BACKSTOP AND DIVIDER CURTAIN TO KEY SWITCHES. VERIFY EXACT LOCATION OF BACKSTOP.
 - 2 DIVISION 16 SHALL RUN CONTROL WIRE FROM BACKSTOP AND DIVIDER CURTAIN TO KEY SWITCHES. VERIFY EXACT LOCATION OF BACKSTOP.
 - 3 KEY SWITCHES FOR BASKETBALL BACKSTOPS AND DIVIDER CURTAIN PROVIDED BY UNIT MANUFACTURER. DIVISION 16 SHALL RUN CONTROL WIRE FROM BACKSTOP AND DIVIDER CURTAIN TO KEY SWITCHES. VERIFY EXACT LOCATION OF BACKSTOP.
 - 4 SEE DETAIL 1/12 FOR RECEPTACLE MOUNTING LOCATION INSIDE DISPLAY CASE.
 - 5 PUSH BUTTON CONTROLLER BY UNIT MANUFACTURER MOUNTED AND WIRED BY DIVISION 16.
 - 6 PROVIDE A NEMA 5-30R RECEPTACLE.
 - 7 MOUNT CLOCK AT 11'-0" ABOVE FINISH FLOOR.

ROOM LEGEND "P1"

ROOM NO.	ROOM NAME	AREA SQ. FT.	CEILING
P101	MEN'S TOILET	425	9'-4"
P102	ATHLETIC STORAGE	284	9'-4"
P103	DRINKING ROOM	104	9'-4"
P104	SHOWER ROOM	130	9'-4"
P105	LOCKER	751	9'-4"
P106	STORAGE	751	9'-4"
P107	STORAGE	751	9'-4"
P108	STORAGE	751	9'-4"
P109	STORAGE	751	9'-4"
P110	STORAGE	751	9'-4"
P111	STORAGE	751	9'-4"
P112	STORAGE	751	9'-4"
P113	STORAGE	751	9'-4"
P114	STORAGE	751	9'-4"
P115	STORAGE	751	9'-4"
P116	STORAGE	751	9'-4"
P117	STORAGE	751	9'-4"
P118	STORAGE	751	9'-4"
P119	STORAGE	751	9'-4"
P120	STORAGE	751	9'-4"

