



95

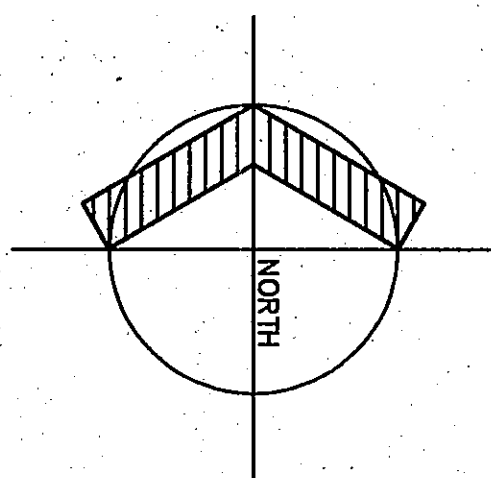

POWER PLAN UNIT Q2

SCALE 1/8" = 1'-0"

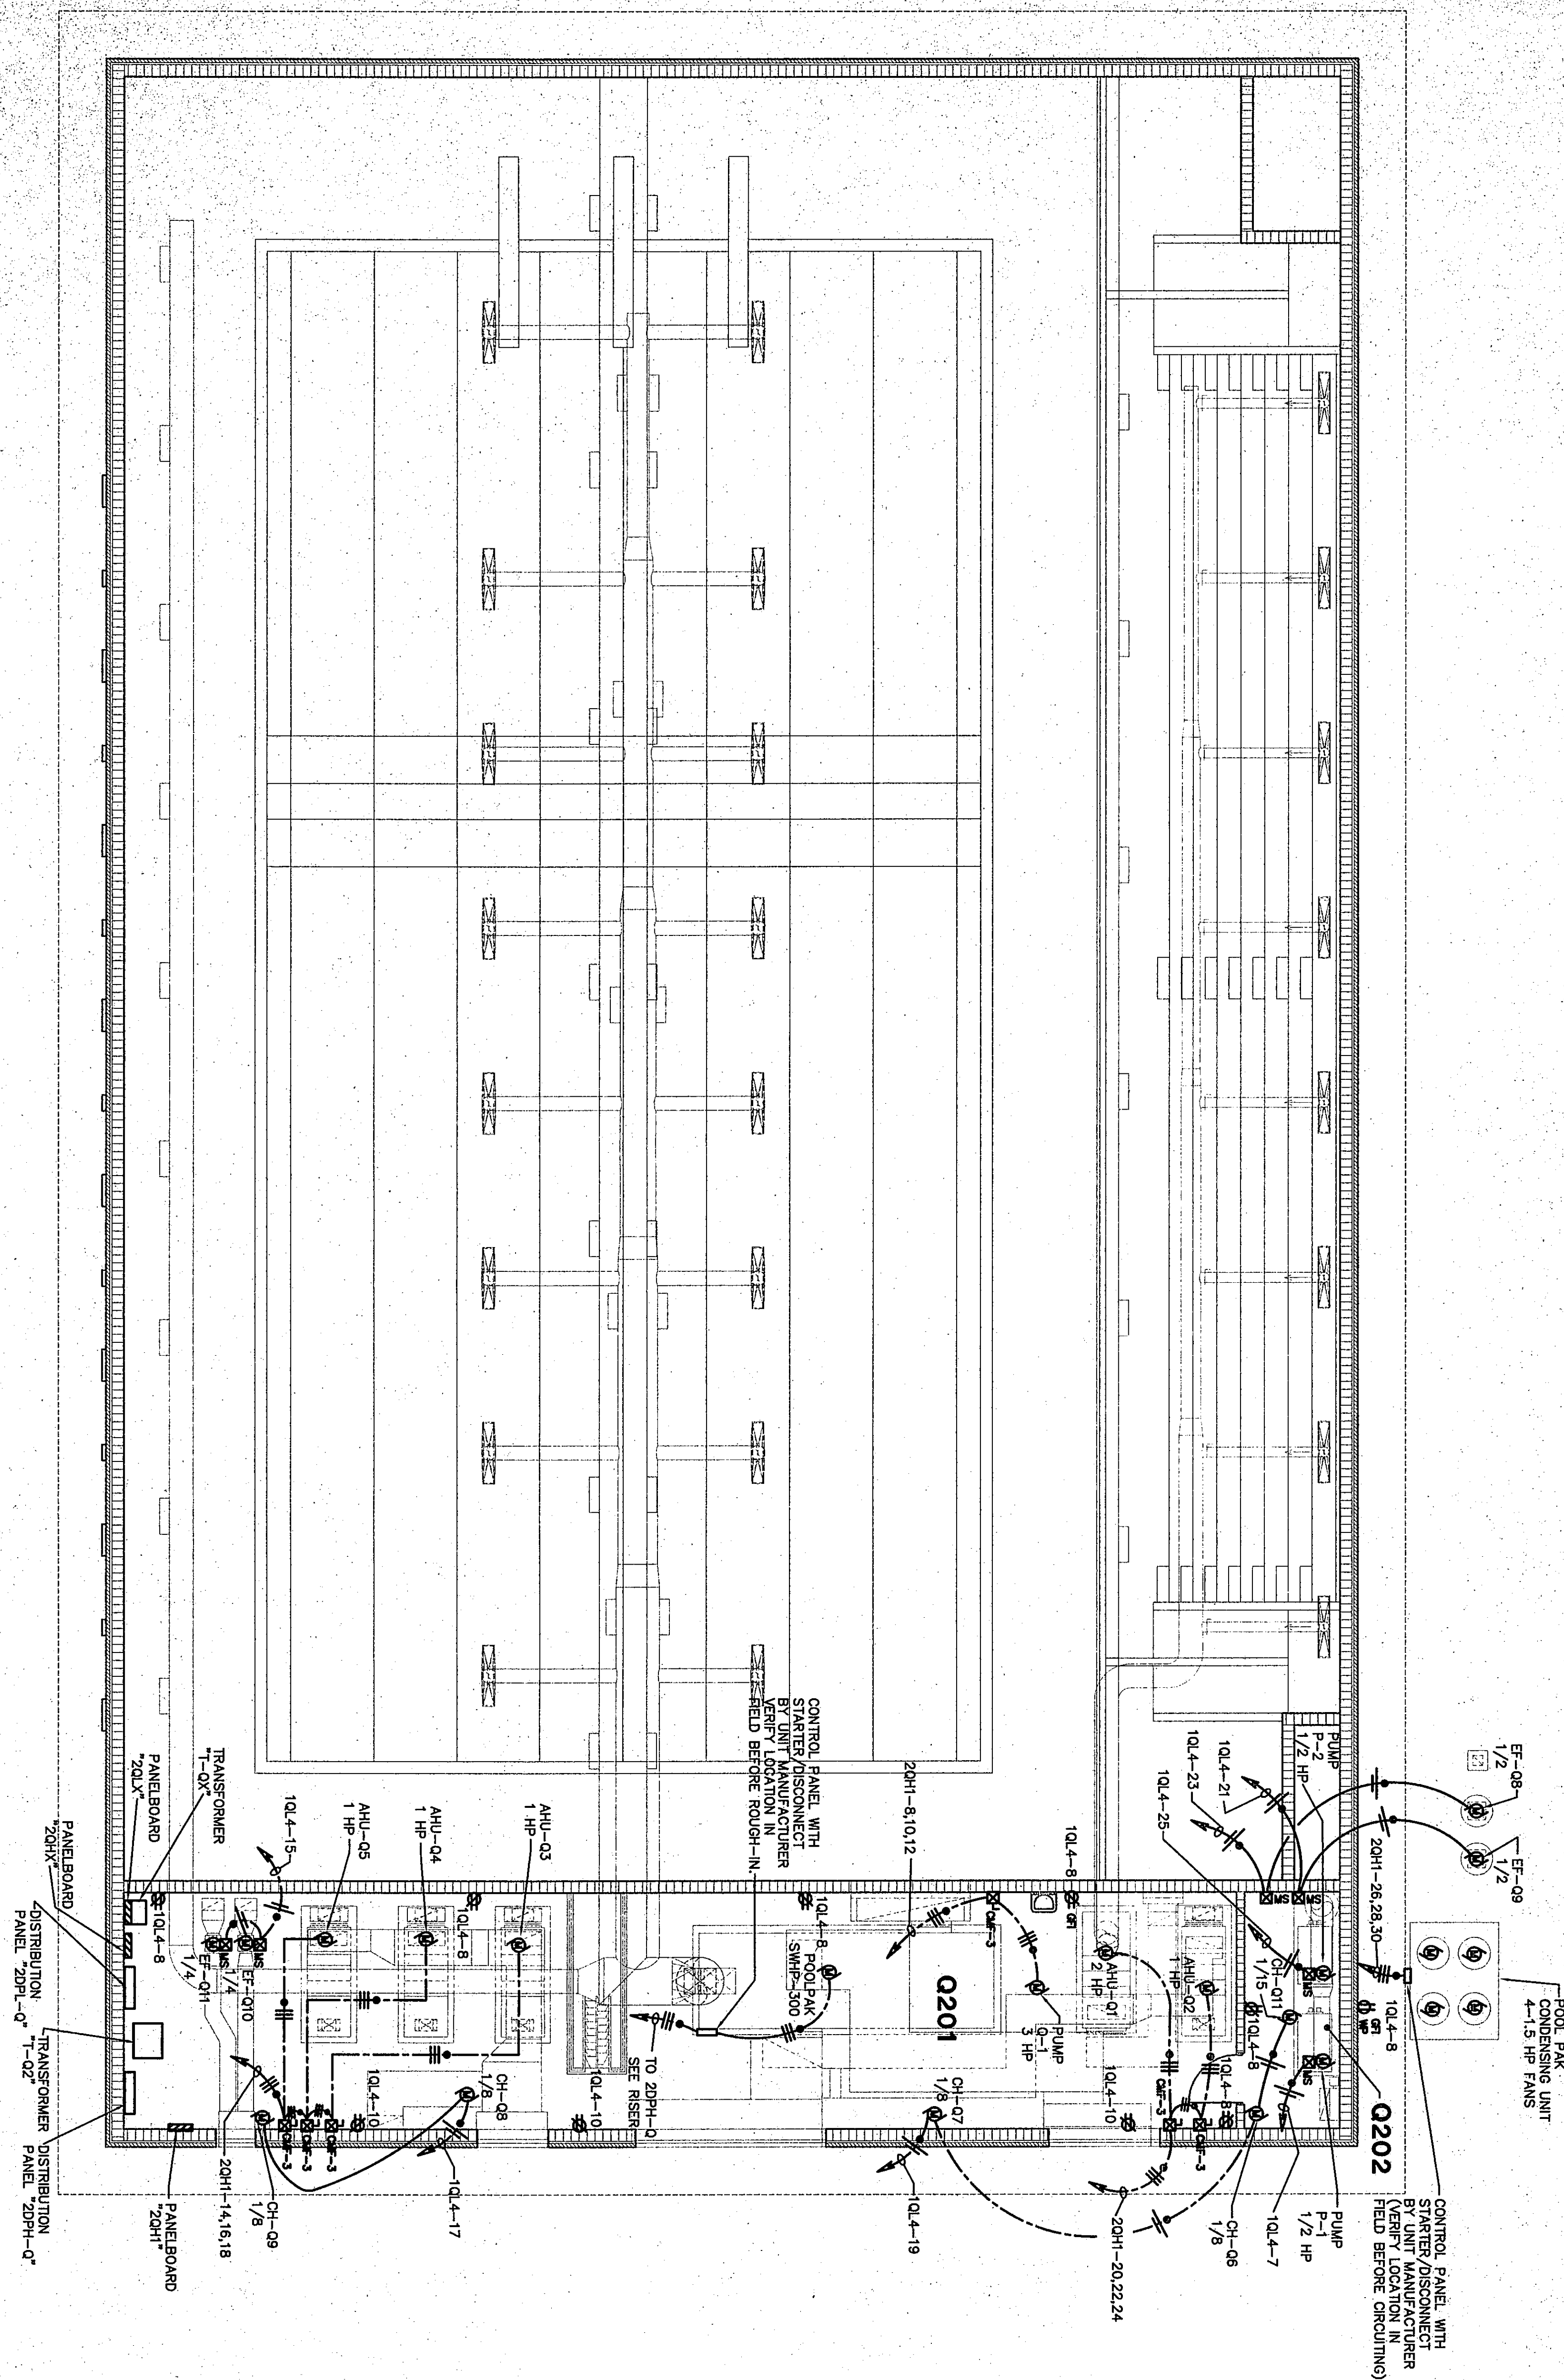

ROOM LEGEND "Q2"			
ROOM NO.	ROOM NAME	AREA	CEILING HEIGHT
Q201	MEZZANINE	2043	15'
Q202	MEZZANINE	159	15'

91-E-93


CHESTERTON HIGH SCHOOL
85067.00

POWER PLAN UNIT Q2


DRAWN BY: MRS. COMM. NO.: 95067.00
CHECKED BY: WBH DATE: APRIL 21, 1997

E5.25

REVISIONS NO. DATE

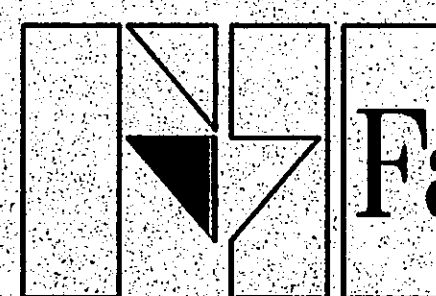

Fanning/Howey
Associates, Inc.
Architects Engineers Consultants

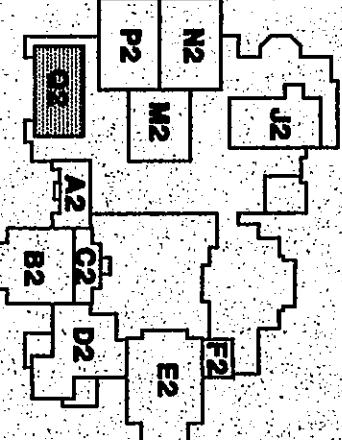

THE NEW
CHESTERTON HIGH SCHOOL
FOR THE
DUNELAND SCHOOL CORPORATION
CHESTERTON, INDIANA

COPYRIGHT 1997 BY FANNING/HOWEY ASSOCIATES, INC.

