



86

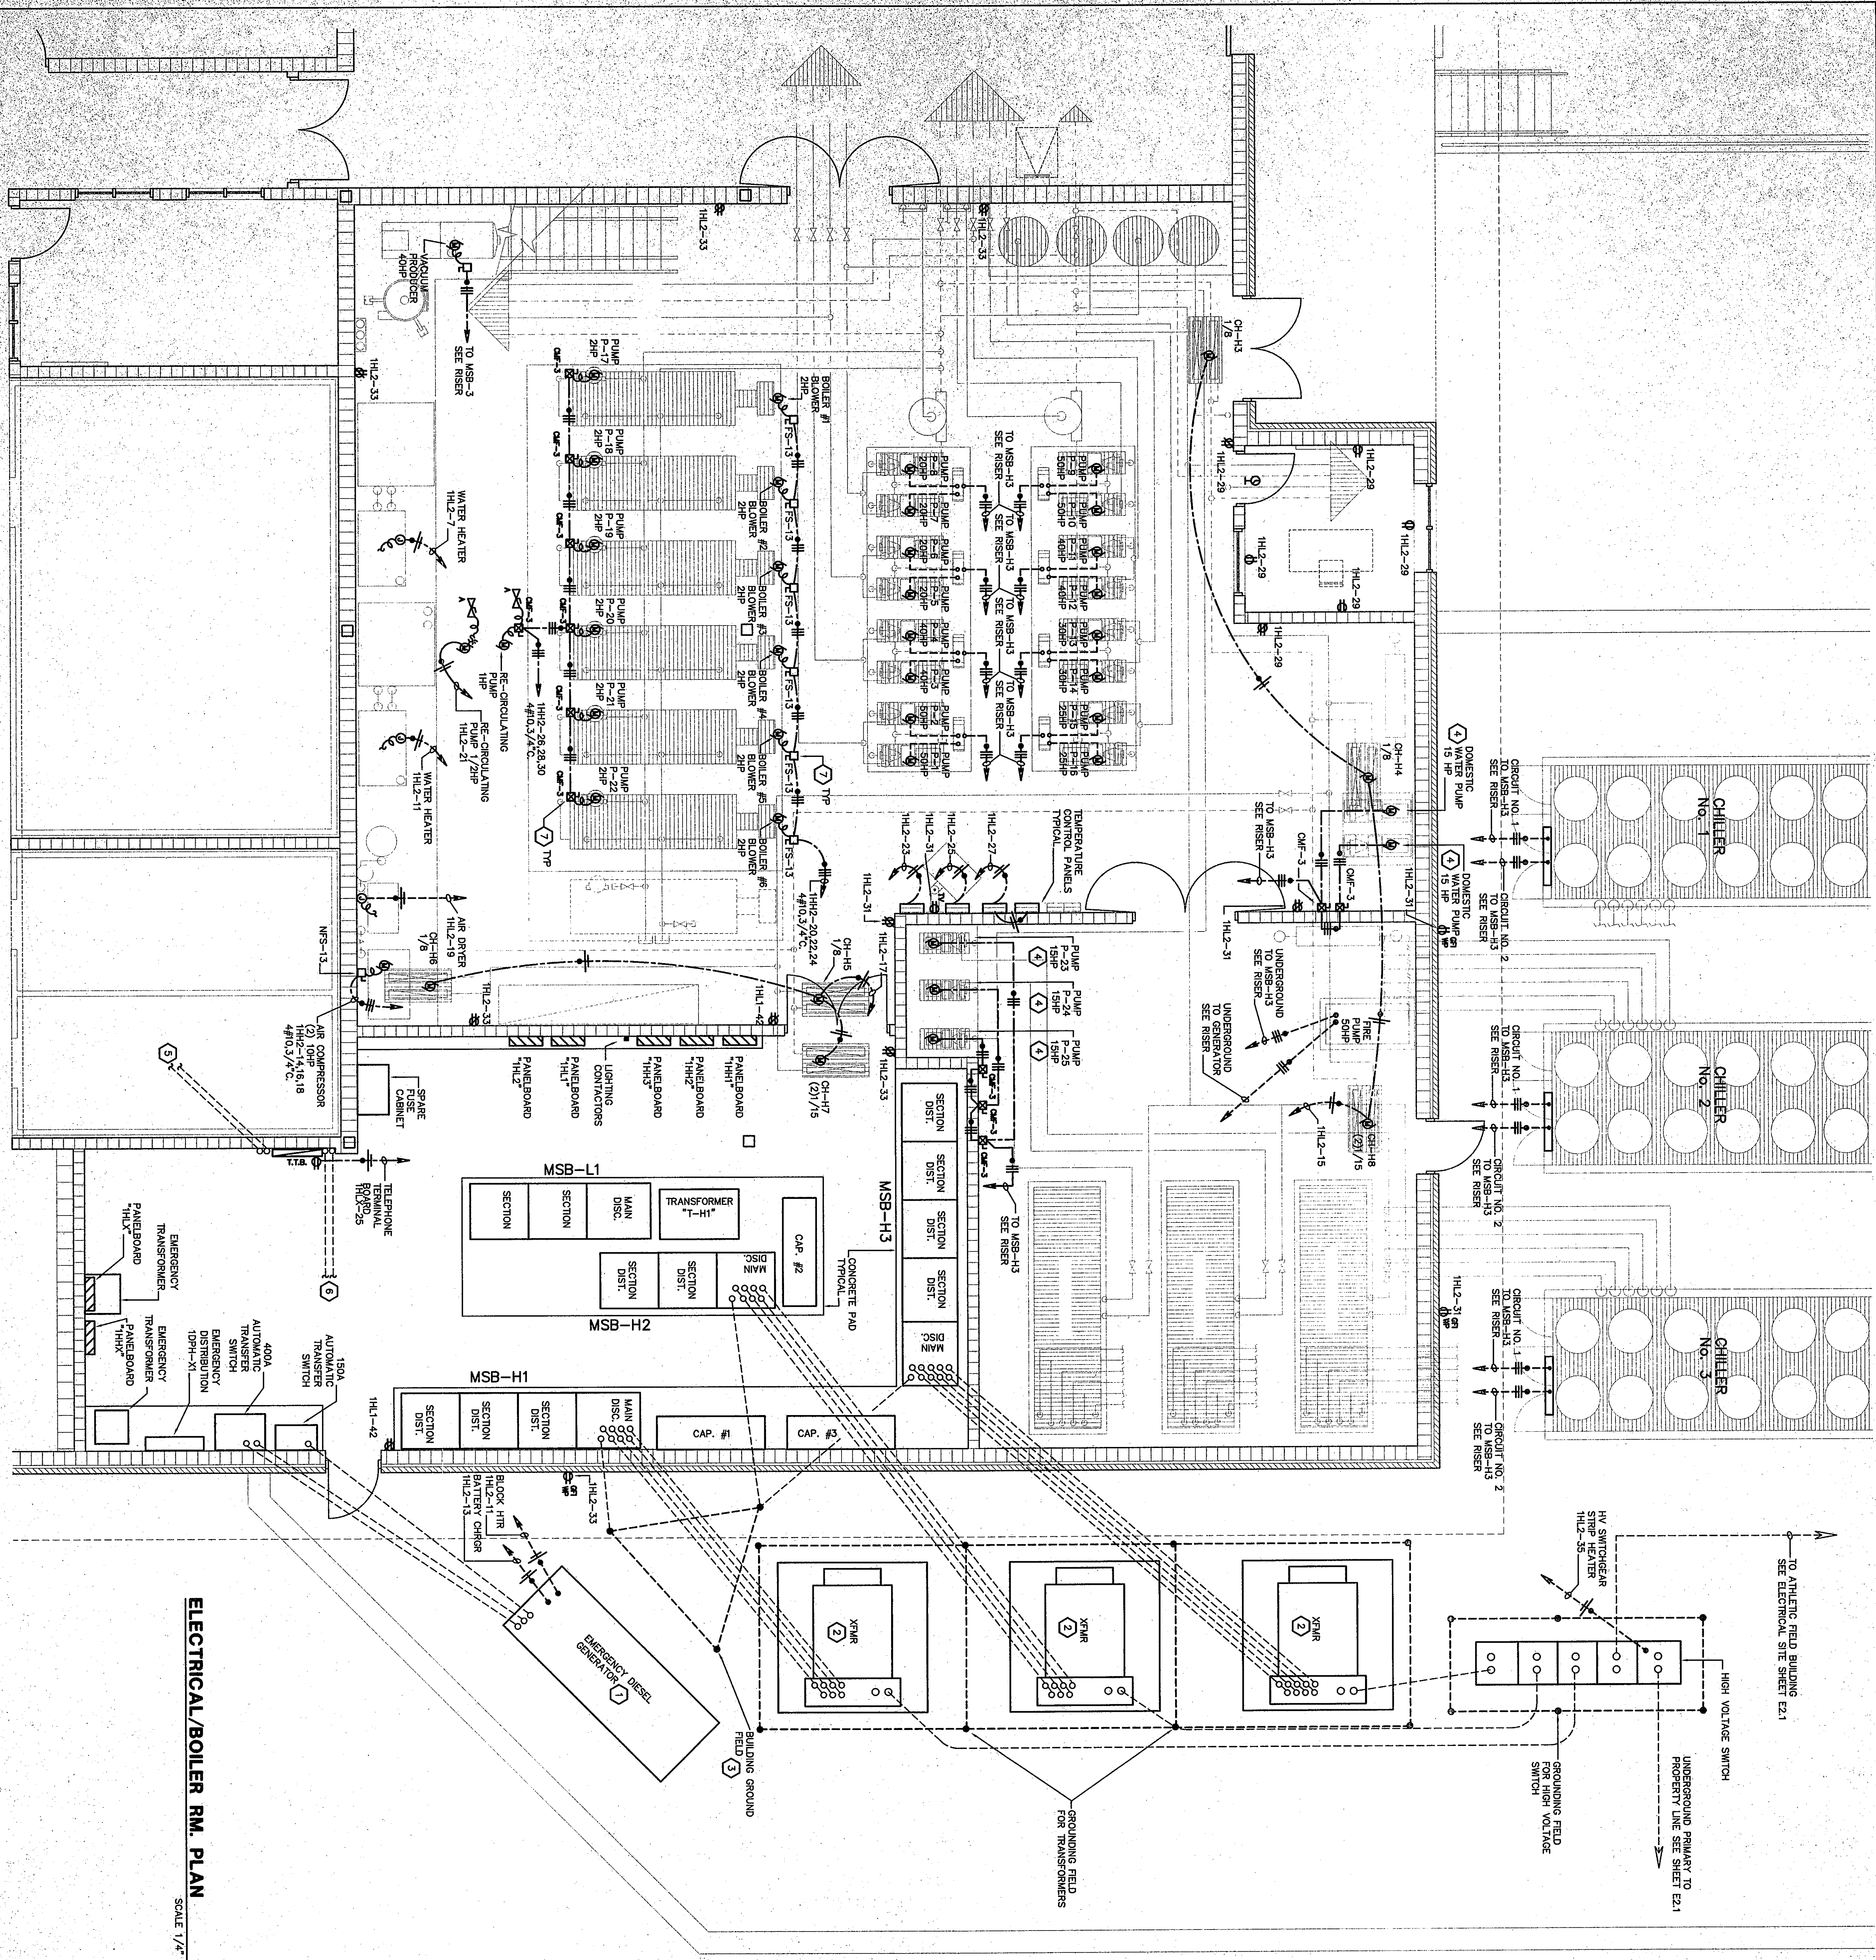


ELECTRICAL/BOILER RM. PLAN

SCALE 1/4" = 1'-0"

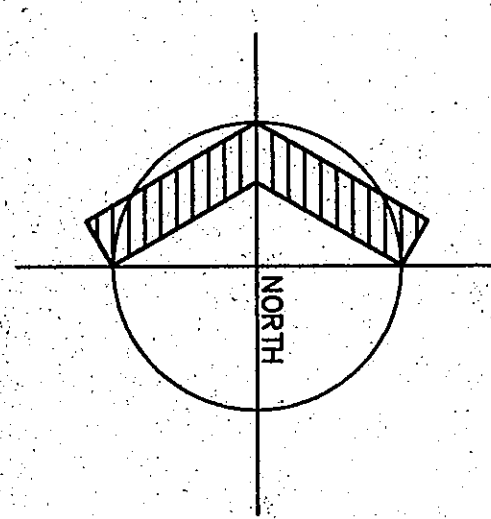


- PLAN NOTES:**
1. REFER TO GENERATOR PAD DETAIL 7/E/1.4 FOR ADDITIONAL INFORMATION.
 2. REFER TO TRANSFORMER DETAIL 9/E/1.4 FOR ADDITIONAL INFORMATION.
 3. REFER TO BUILDING GROUNDING DETAIL 3/E/1.1 FOR ADDITIONAL INFORMATION.
 4. PROVIDE PHASE FAILURE RELAY SQUARE D MODEL B430-045V OR ENGINEER APPROVED EQUAL AND OR OUTLET OF STARTER TO OPEN STARTER UPON SENSING PHASE LOSS.
 5. RUN 2-4" PVC CONDUITS FROM 11B TO ROOM 110B.
 6. TELEPHONE SERVICE CONDUITS, 2-4" PVC. SEE ELECTRICAL SITE PLAN FOR ROUTING.
 7. MOUNT DISCONNECT SWITCH OR COMBINATION MOTOR STARTER ON UNISTRUT FRAME LOCATED ADJACENT TO MOTOR.

Fanning/Howey Associates, Inc.
Architects Engineers Consultants

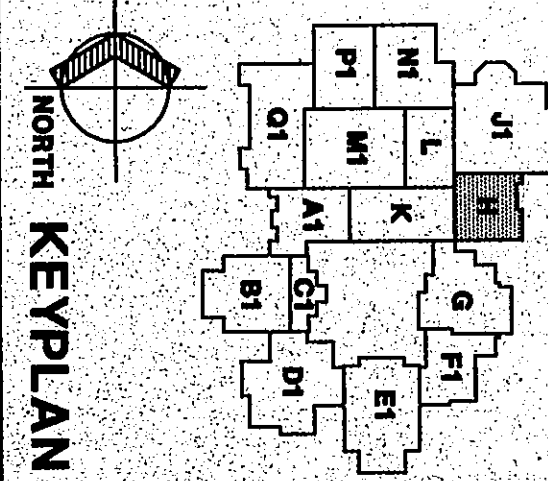

THE NEW
CHESTERTON HIGH SCHOOL
FOR THE
DUNELAND SCHOOL CORPORATION
CHESTERTON, INDIANA

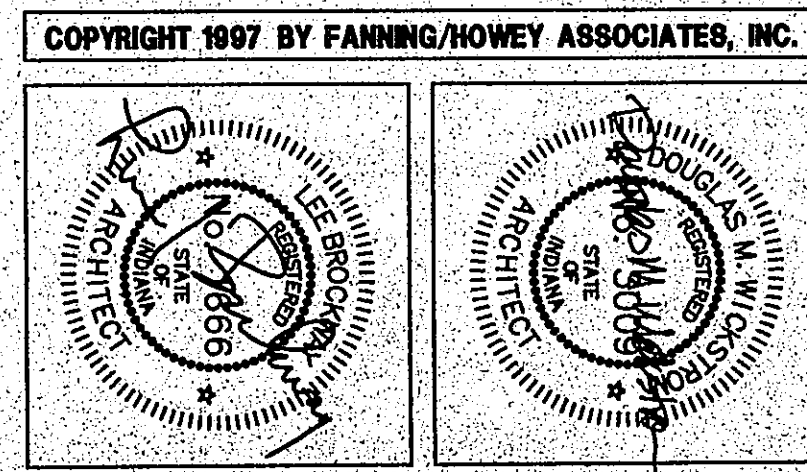

ELECTRICAL/BOILER RM. PLAN	
DRAWN BY: WSH	COMM. NO.: 95067.00
CHECKED BY: WSH	DATE: APRIL 21, 1997
E6.3	REVISIONS NO. DATE

02-E-96