



FIRE PUMP AND RISER FLOOR PLAN

SCALE: 1/2" = 1'-0"

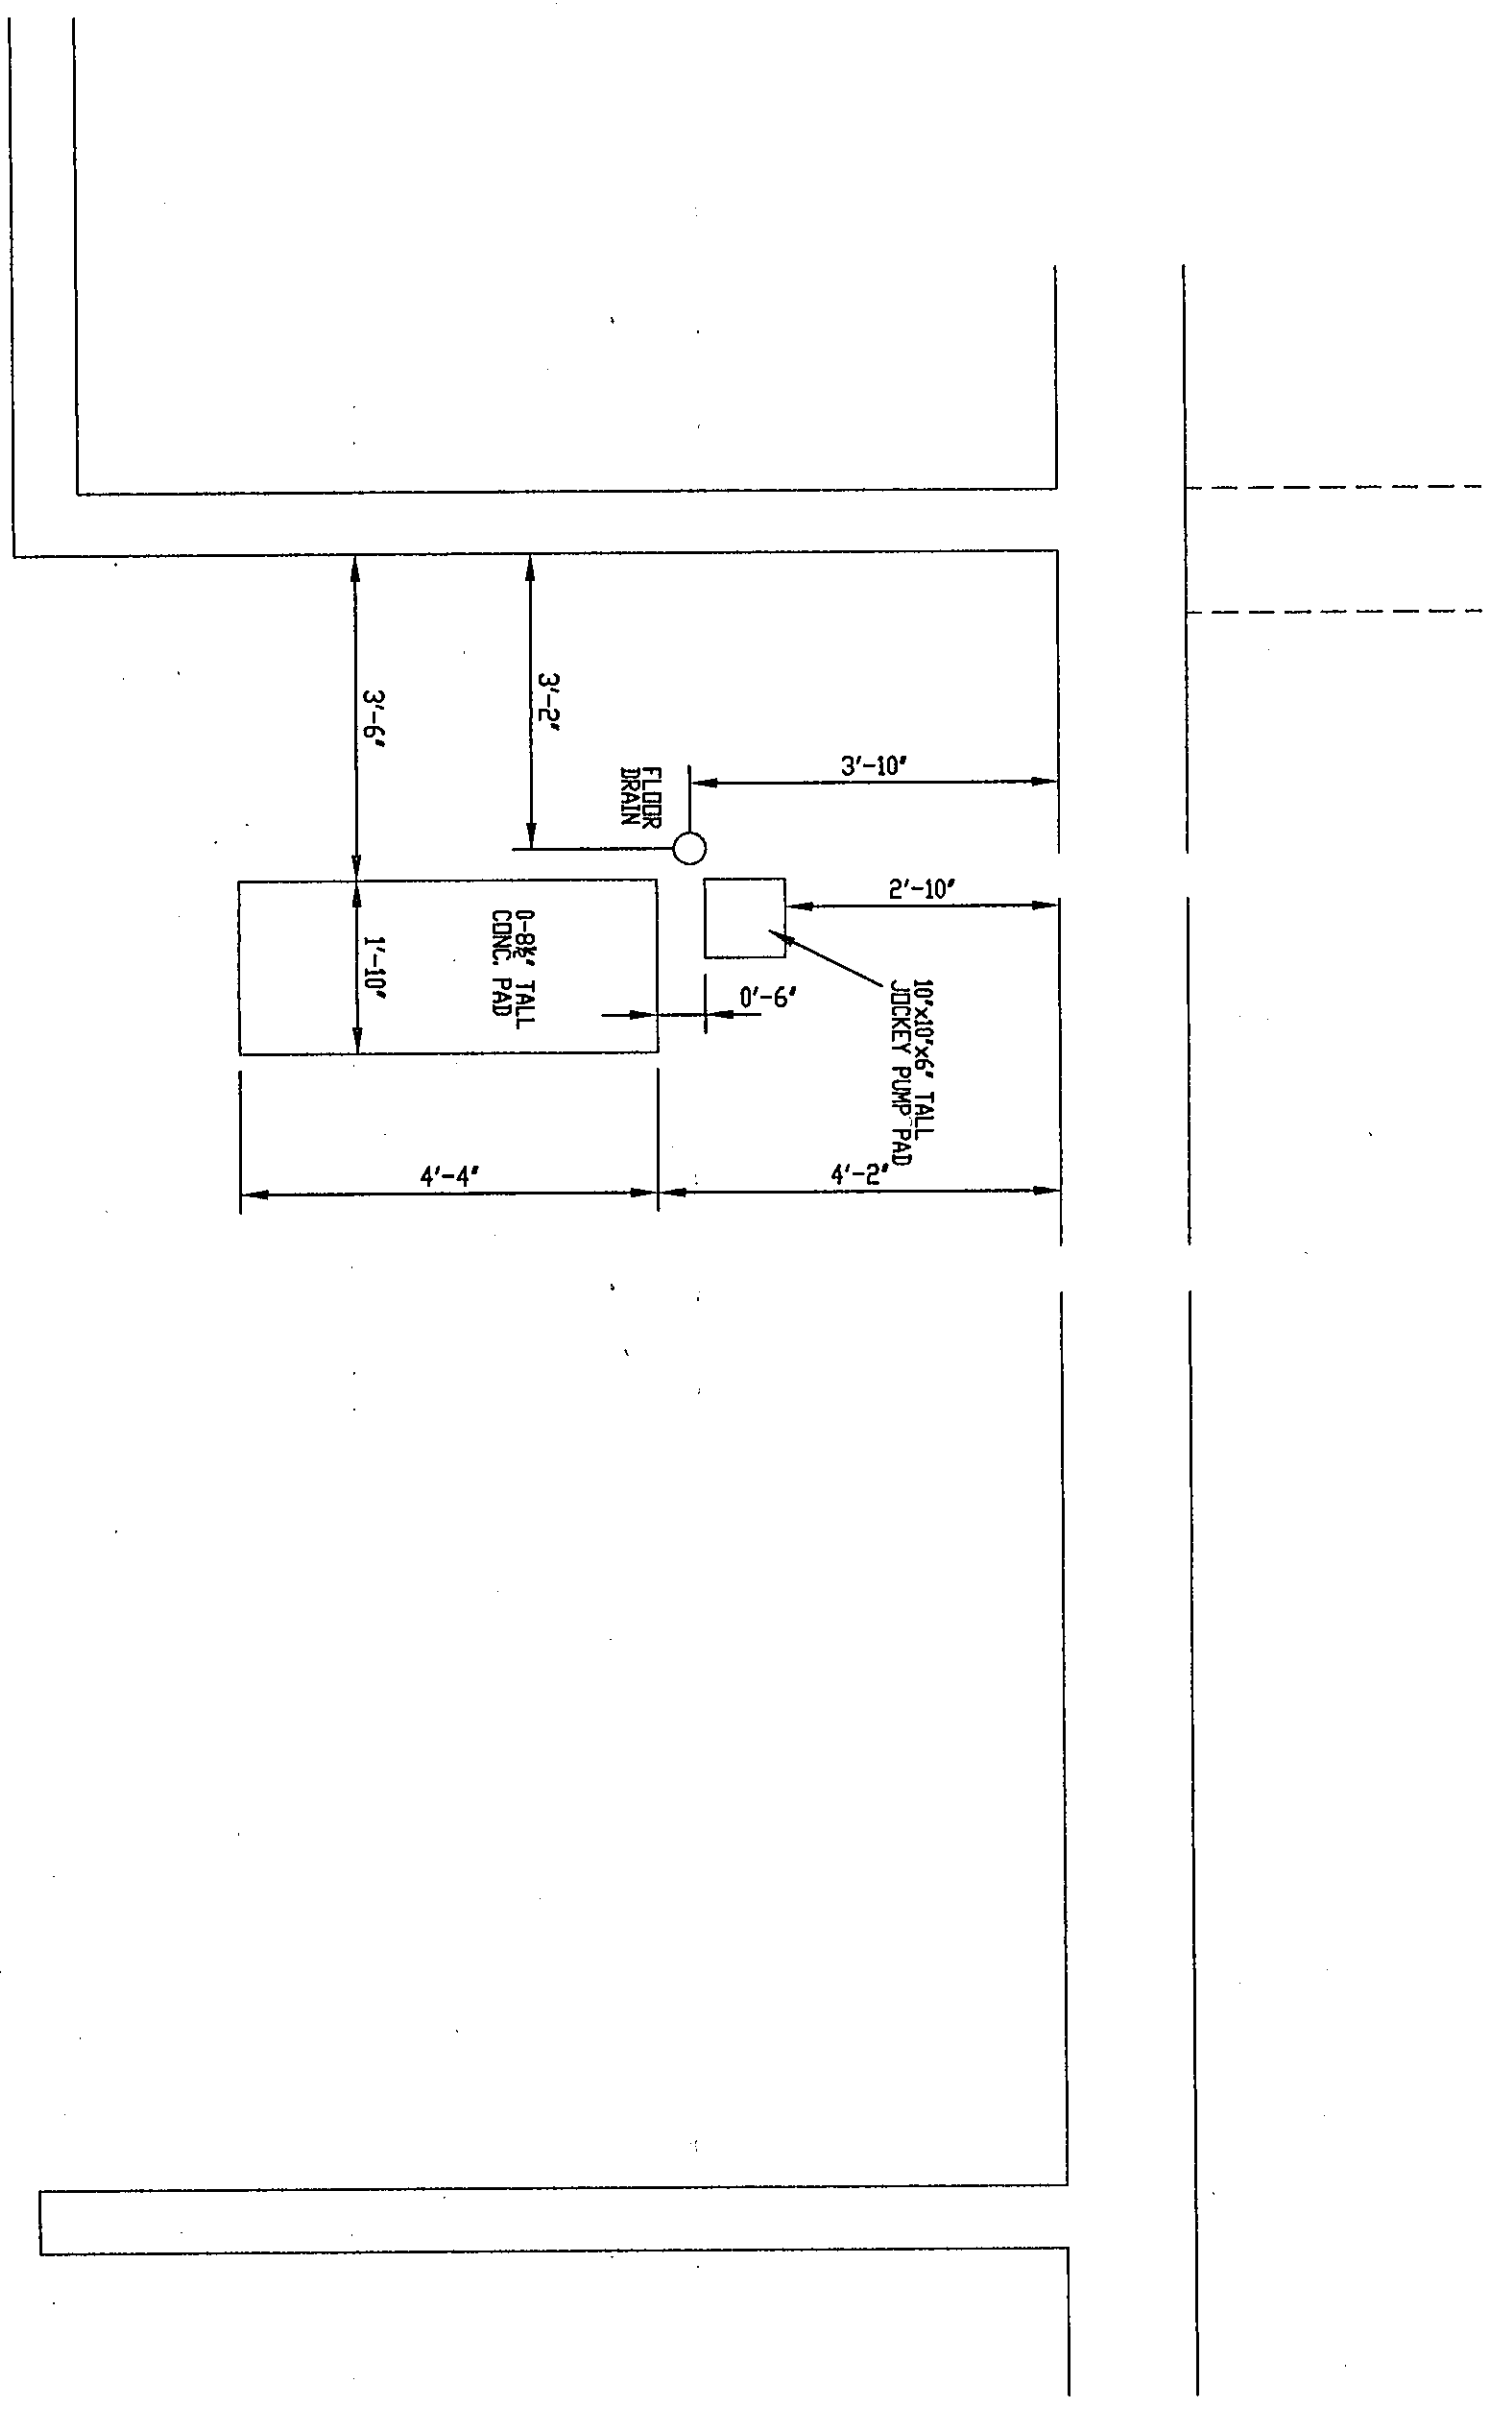


CONCRETE PAD LAYOUT FOR PUMPS

SCALE: 1/2" = 1'-0"

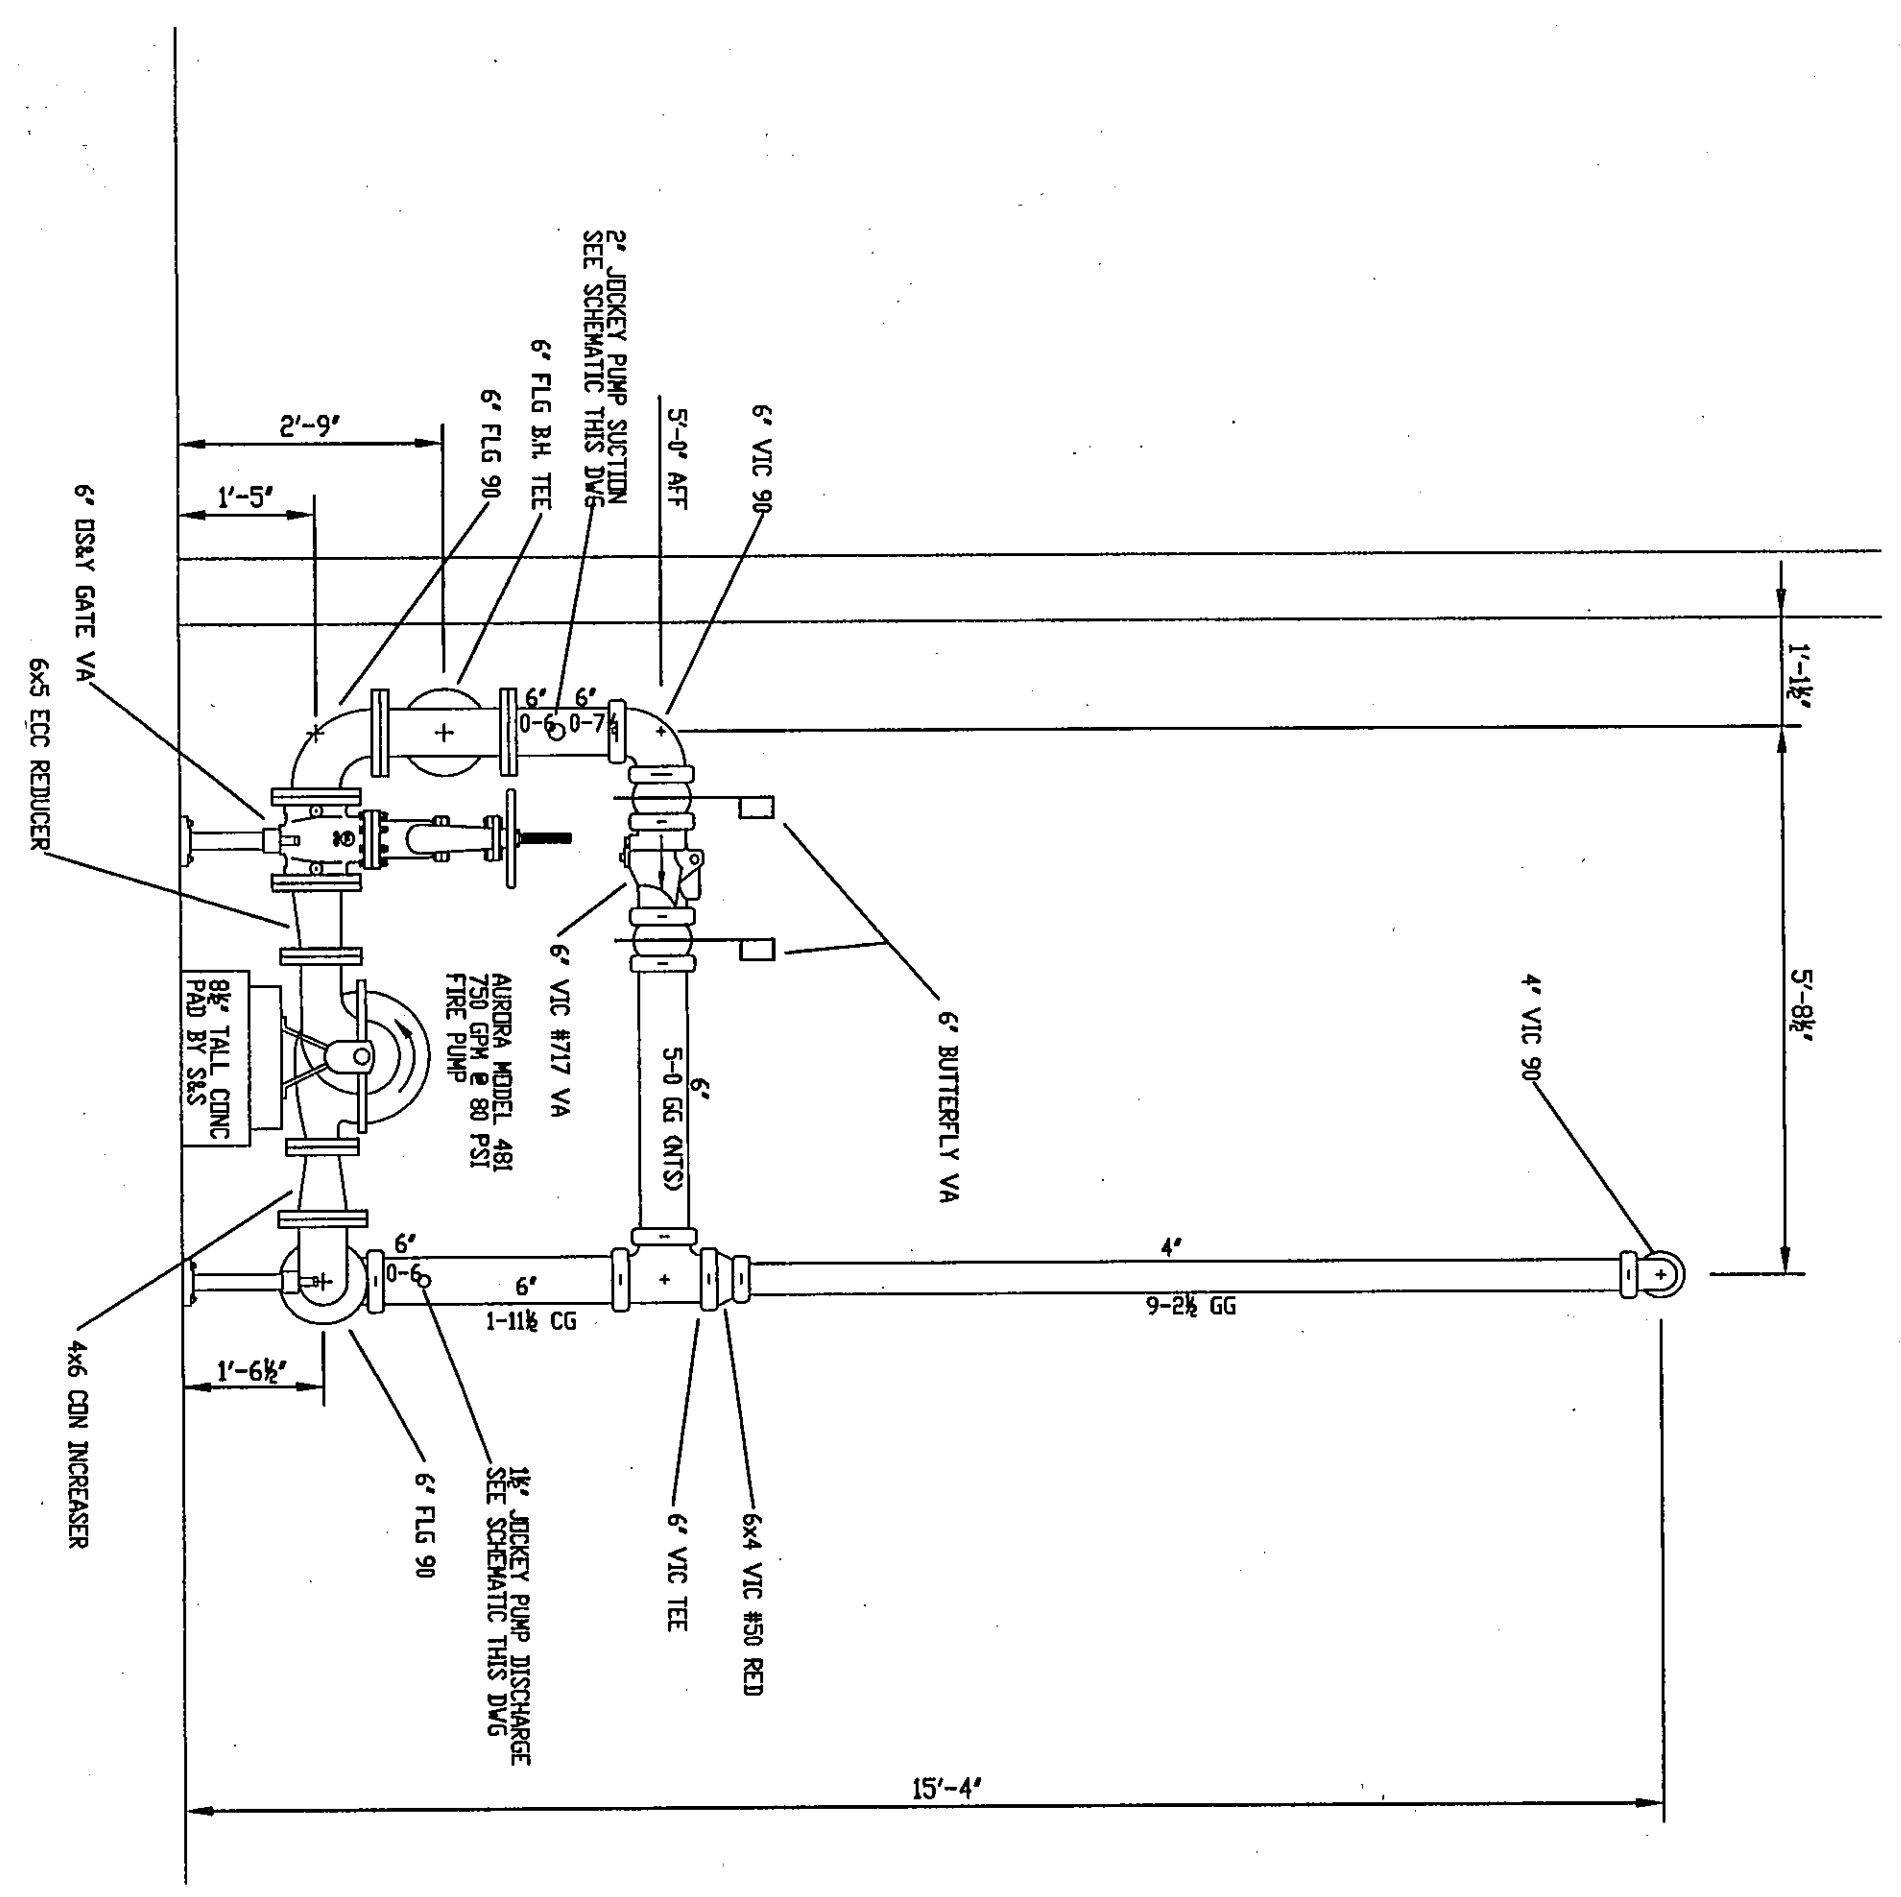


FIRE PUMP ELEVATION

SCALE: 1/2" = 1'-0"

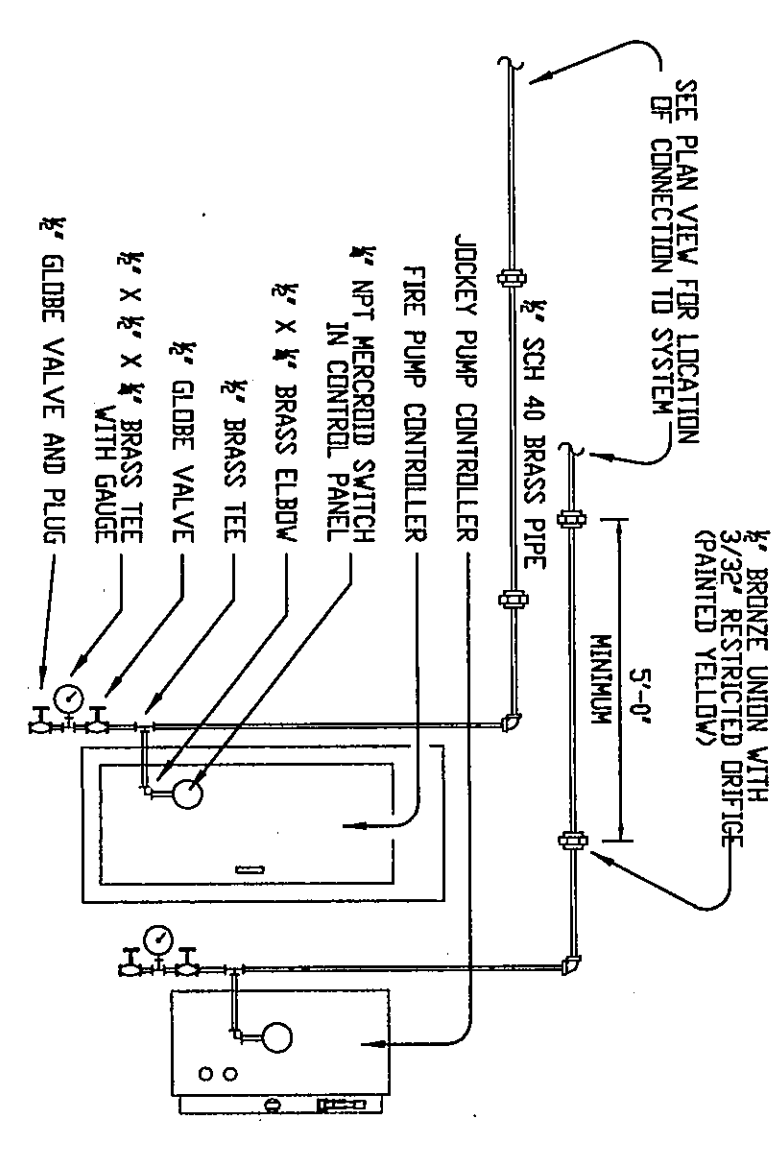


SENSING LINE SCHEMATIC

NO SCALE

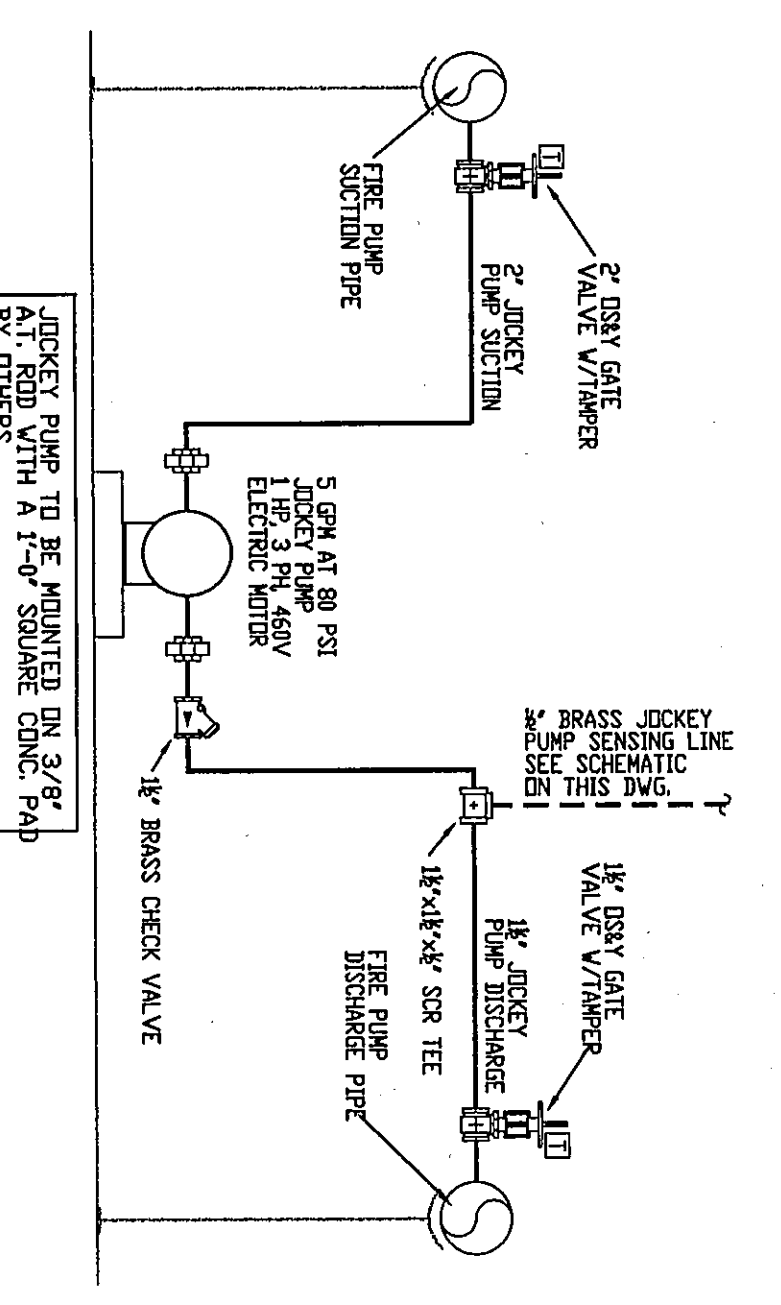

JOCKEY PUMP SCHEMATIC

NO SCALE

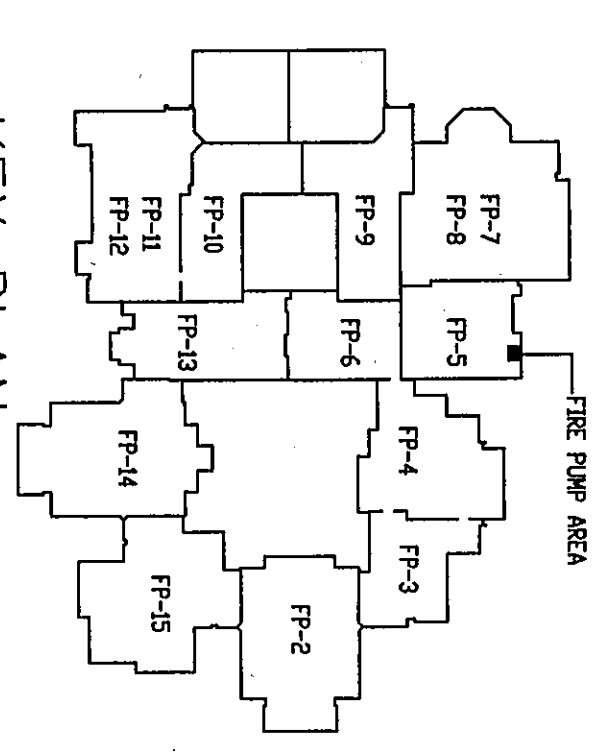

KEY PLAN

NO SCALE

DESIGNED BY: S&S
 DRAWN BY: S&S
 CHECKED BY: S&S
 APPROVED BY: S&S
 DATE: 10-1-97
 PROJECT NO: 240902
 SHEET NO: FP-26



Chesterton High School

2125 South Eleventh St.
 Chesterton, IN 46304

NO.	DATE	REVISION	BY
1	10-1-97	ISSUED FOR PERMIT	SM
2	10-1-97	REVISED DRAWING	SM
3	10-1-97	REVISED DRAWING	SM
4	10-1-97	REVISED DRAWING	SM
5	10-1-97	REVISED DRAWING	SM
6	10-1-97	REVISED DRAWING	SM

PROJECT NAME:
 Chesterton High School
 2125 South Eleventh St.
 Chesterton, IN 46304
 DRAWN BY: S&S
 CHECKED BY: S&S
 APPROVED BY: S&S
 DATE: 10-1-97
 PROJECT NO: 240902
 SHEET NO: FP-26