


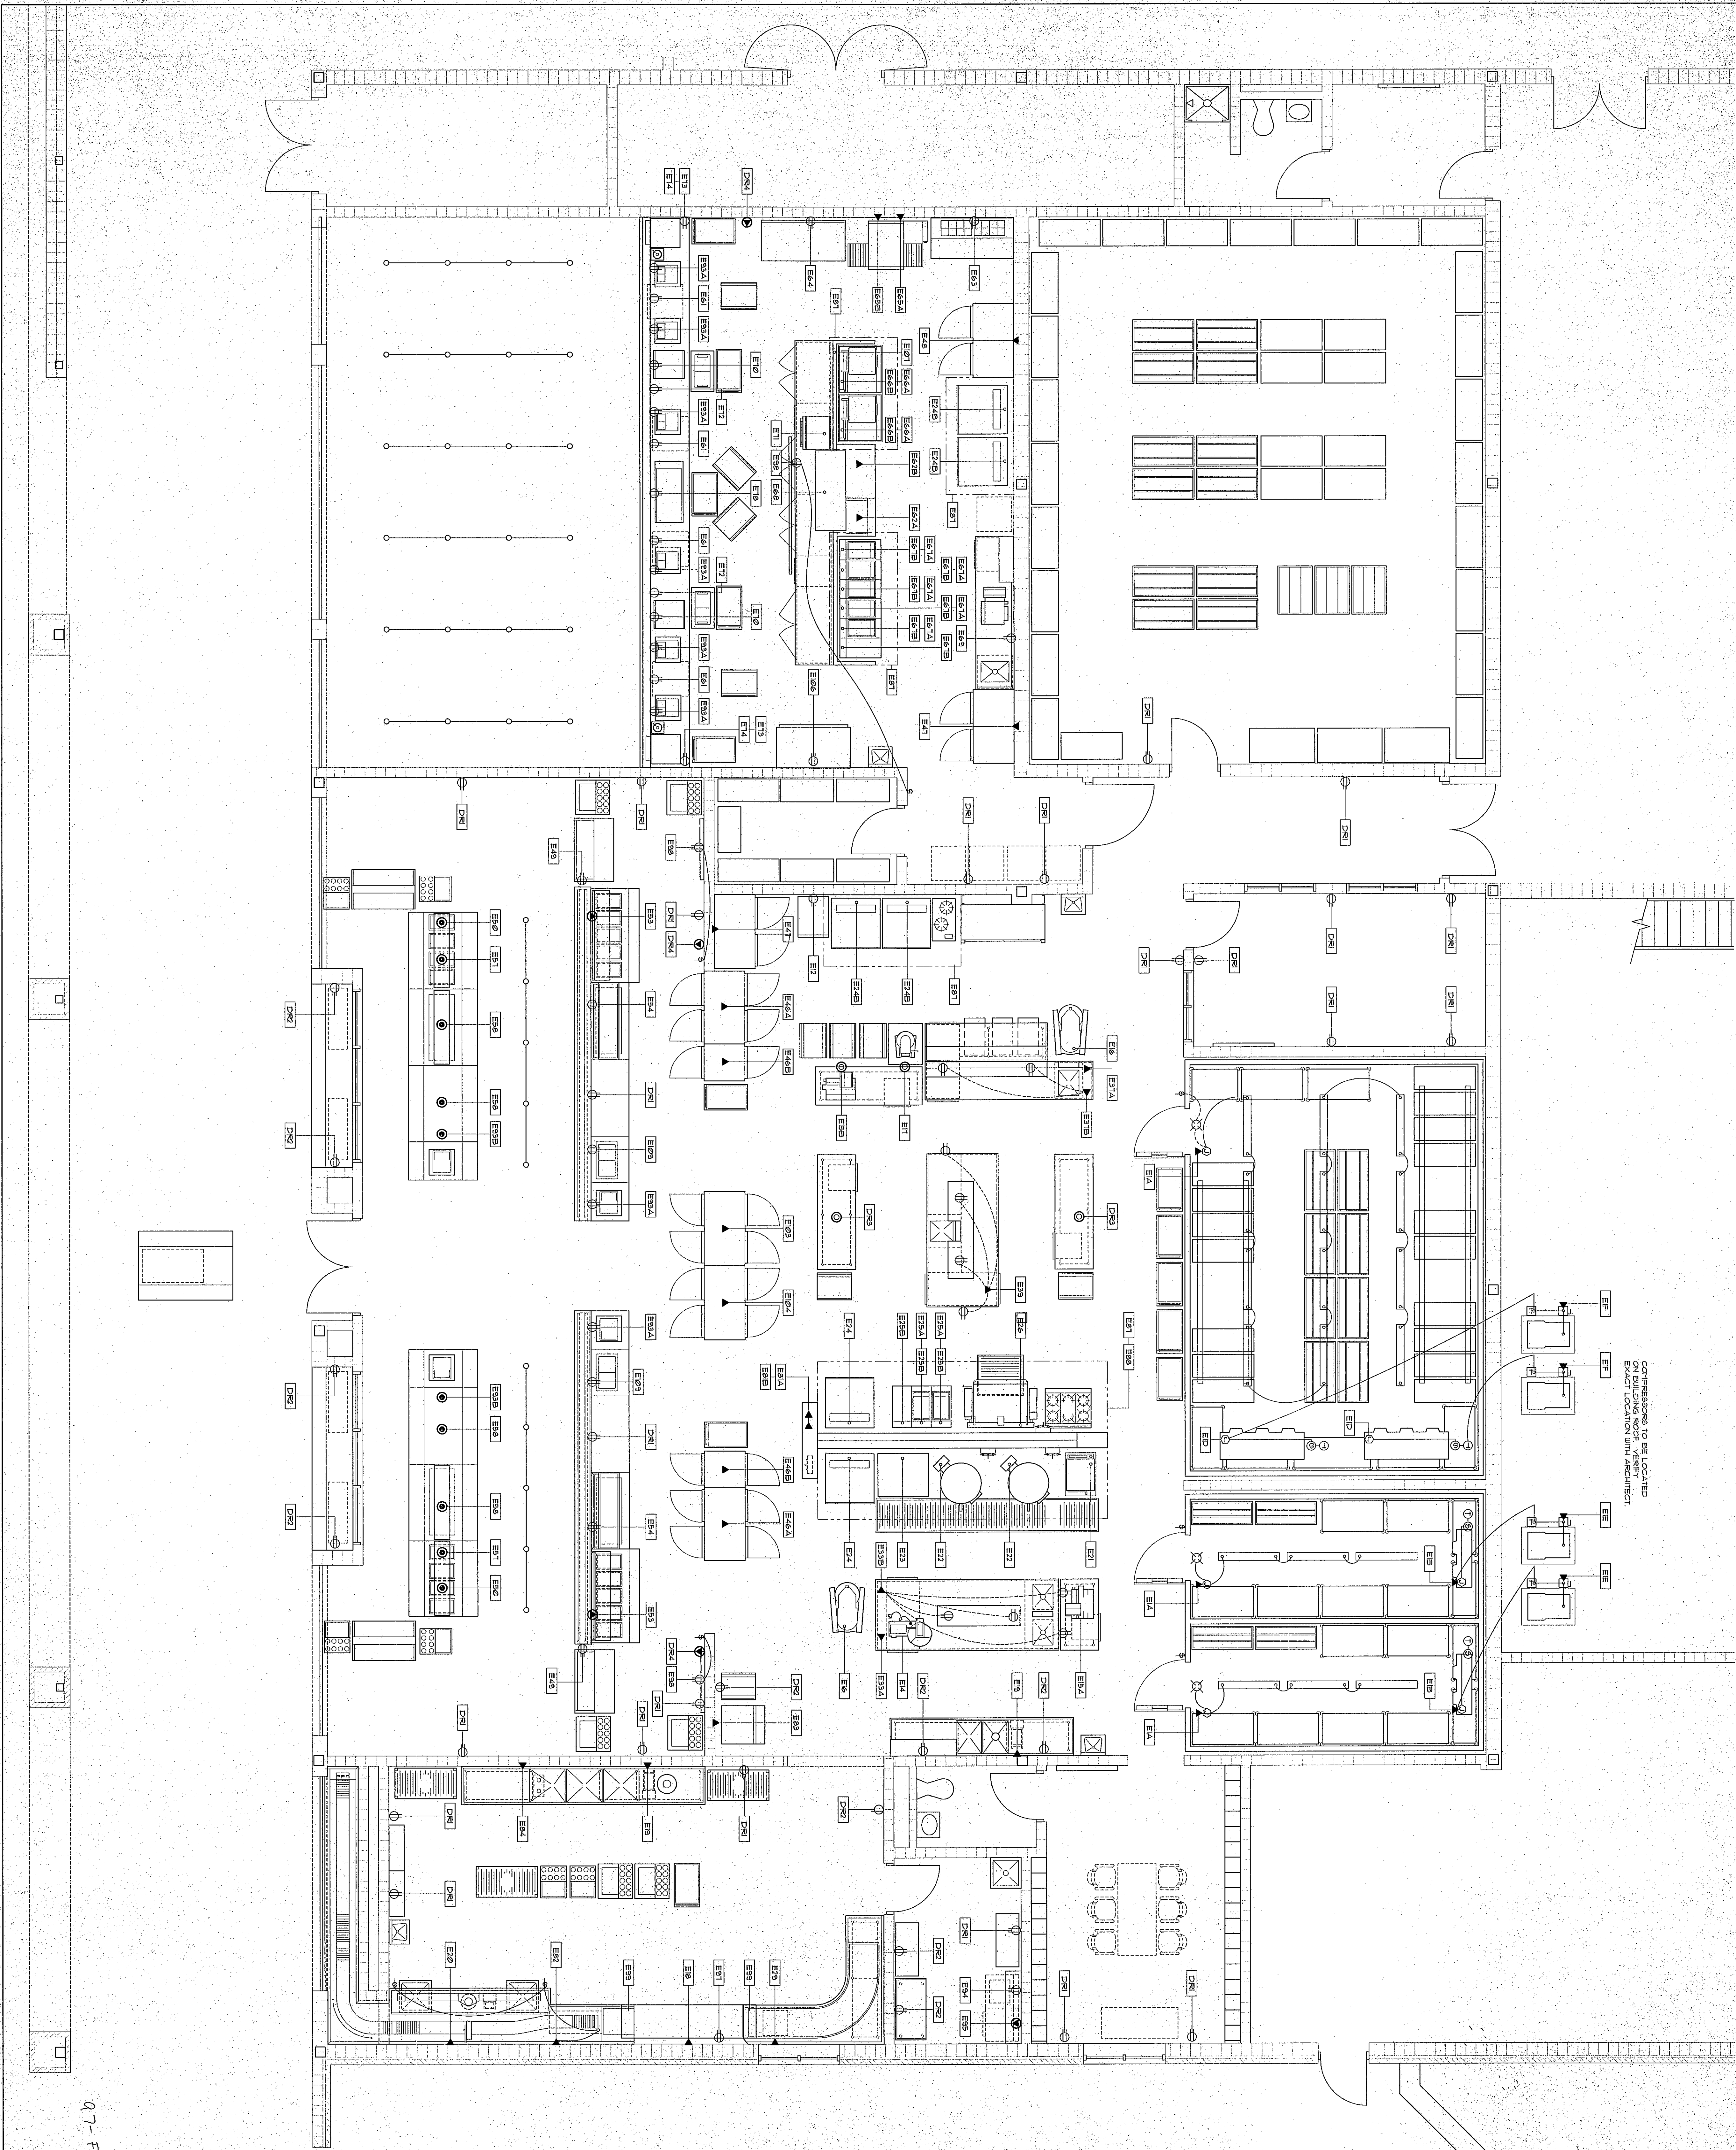

COMPRESSORS TO BE LOCATED
ON BUILDING ROOF. VERIFY
EXACT LOCATION WITH ARCHITECT.

97-FS-05


CHESTERTON HIGH SCHOOL
95067.00

KITCHEN ELECTRICAL PLAN


DRAWN BY: D.J.W. COMM. NO.: 95067.00
CHECKED BY: P.T.V. DATE: APRIL 21, 1997

FS.5

REVISIONS NO. DATE

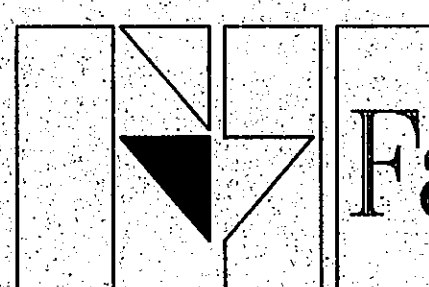

**Fanning/Howey
Associates, Inc.**
Architects Engineers Consultants

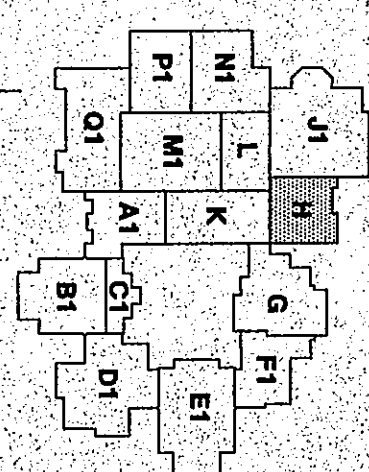

THE NEW
CHESTERTON HIGH SCHOOL
FOR THE
DUNELAND SCHOOL CORPORATION
CHESTERTON, INDIANA

COPYRIGHT 1997 BY FANNING/HOWEY ASSOCIATES, INC.

