



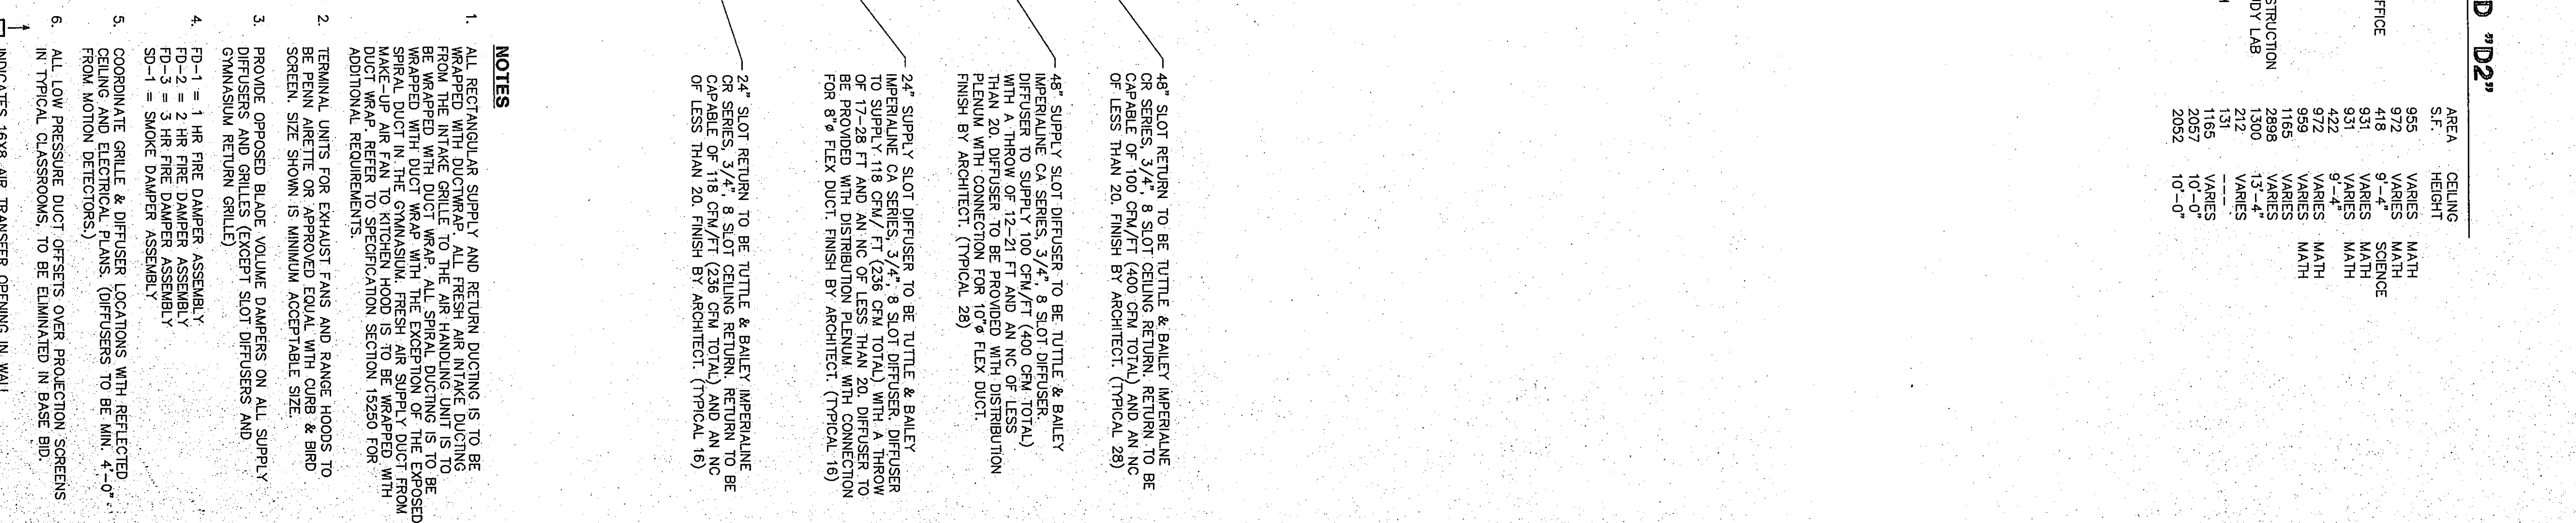


ROOM LEGEND "D2"			AREA	CEILING
ROOM	NAME	HEIGHT	S.F.	
D201	CLASSROOM	9'5"	955	VARIABLES
D202	CLASSROOM	9'5"	955	VARIABLES
D203	DEPARTMENTAL OFFICE	8'4"	418	VARIABLES
D204	CLASSROOM	9'5"	831	VARIABLES
D205	CLASSROOM	9'5"	831	VARIABLES
D206	CLASSROOM	9'5"	831	VARIABLES
D207	CLASSROOM	9'5"	972	VARIABLES
D208	CLASSROOM	9'5"	956	VARIABLES
D209	CLASSROOM	9'5"	956	VARIABLES
D210	LARGE GROUP INSTRUCTION	13'4"	2889	VARIABLES
D211	INTERGRATED STUDY LAB	13'4"	1300	VARIABLES
D212	RAMPA ROOM	17'2"	172	VARIABLES
D213	COMPUTER LAB	11'6"	1165	VARIABLES
D214	COMPUTER LAB	10'0"	2057	VARIABLES
D215	CORRIDOR	10'0"	1000	VARIABLES
D216	CORRIDOR	10'0"	2057	VARIABLES

COPYRIGHT 1997 BY FANNING/HOWEY ASSOCIATES, INC.

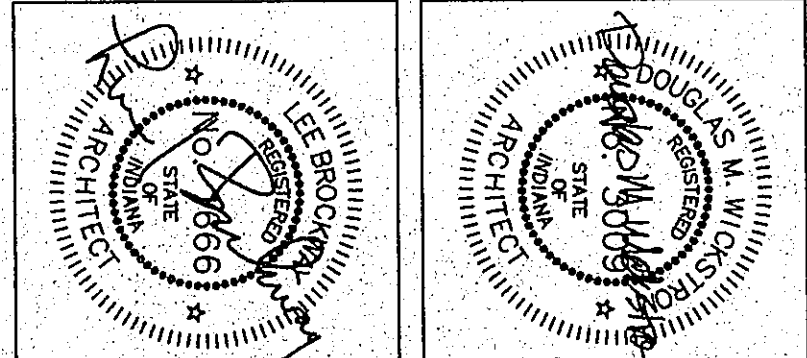

THE NEW
CHESTERTON HIGH SCHOOL
FOR THE
DUNELAND SCHOOL CORPORATION
CHESTERTON, INDIANA

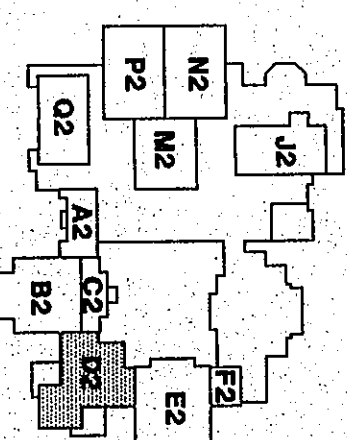

**Fanning/Howey
Associates, Inc.**
Architects Engineers Consultants

VENTILATION PLAN UNIT "D2"	
DRAWN BY: SCB	COMM. NO.: 95067.00
CHECKED BY: CAM	DATE: APRIL 21, 1997
M2.8	REVISIONS NO. DATE