



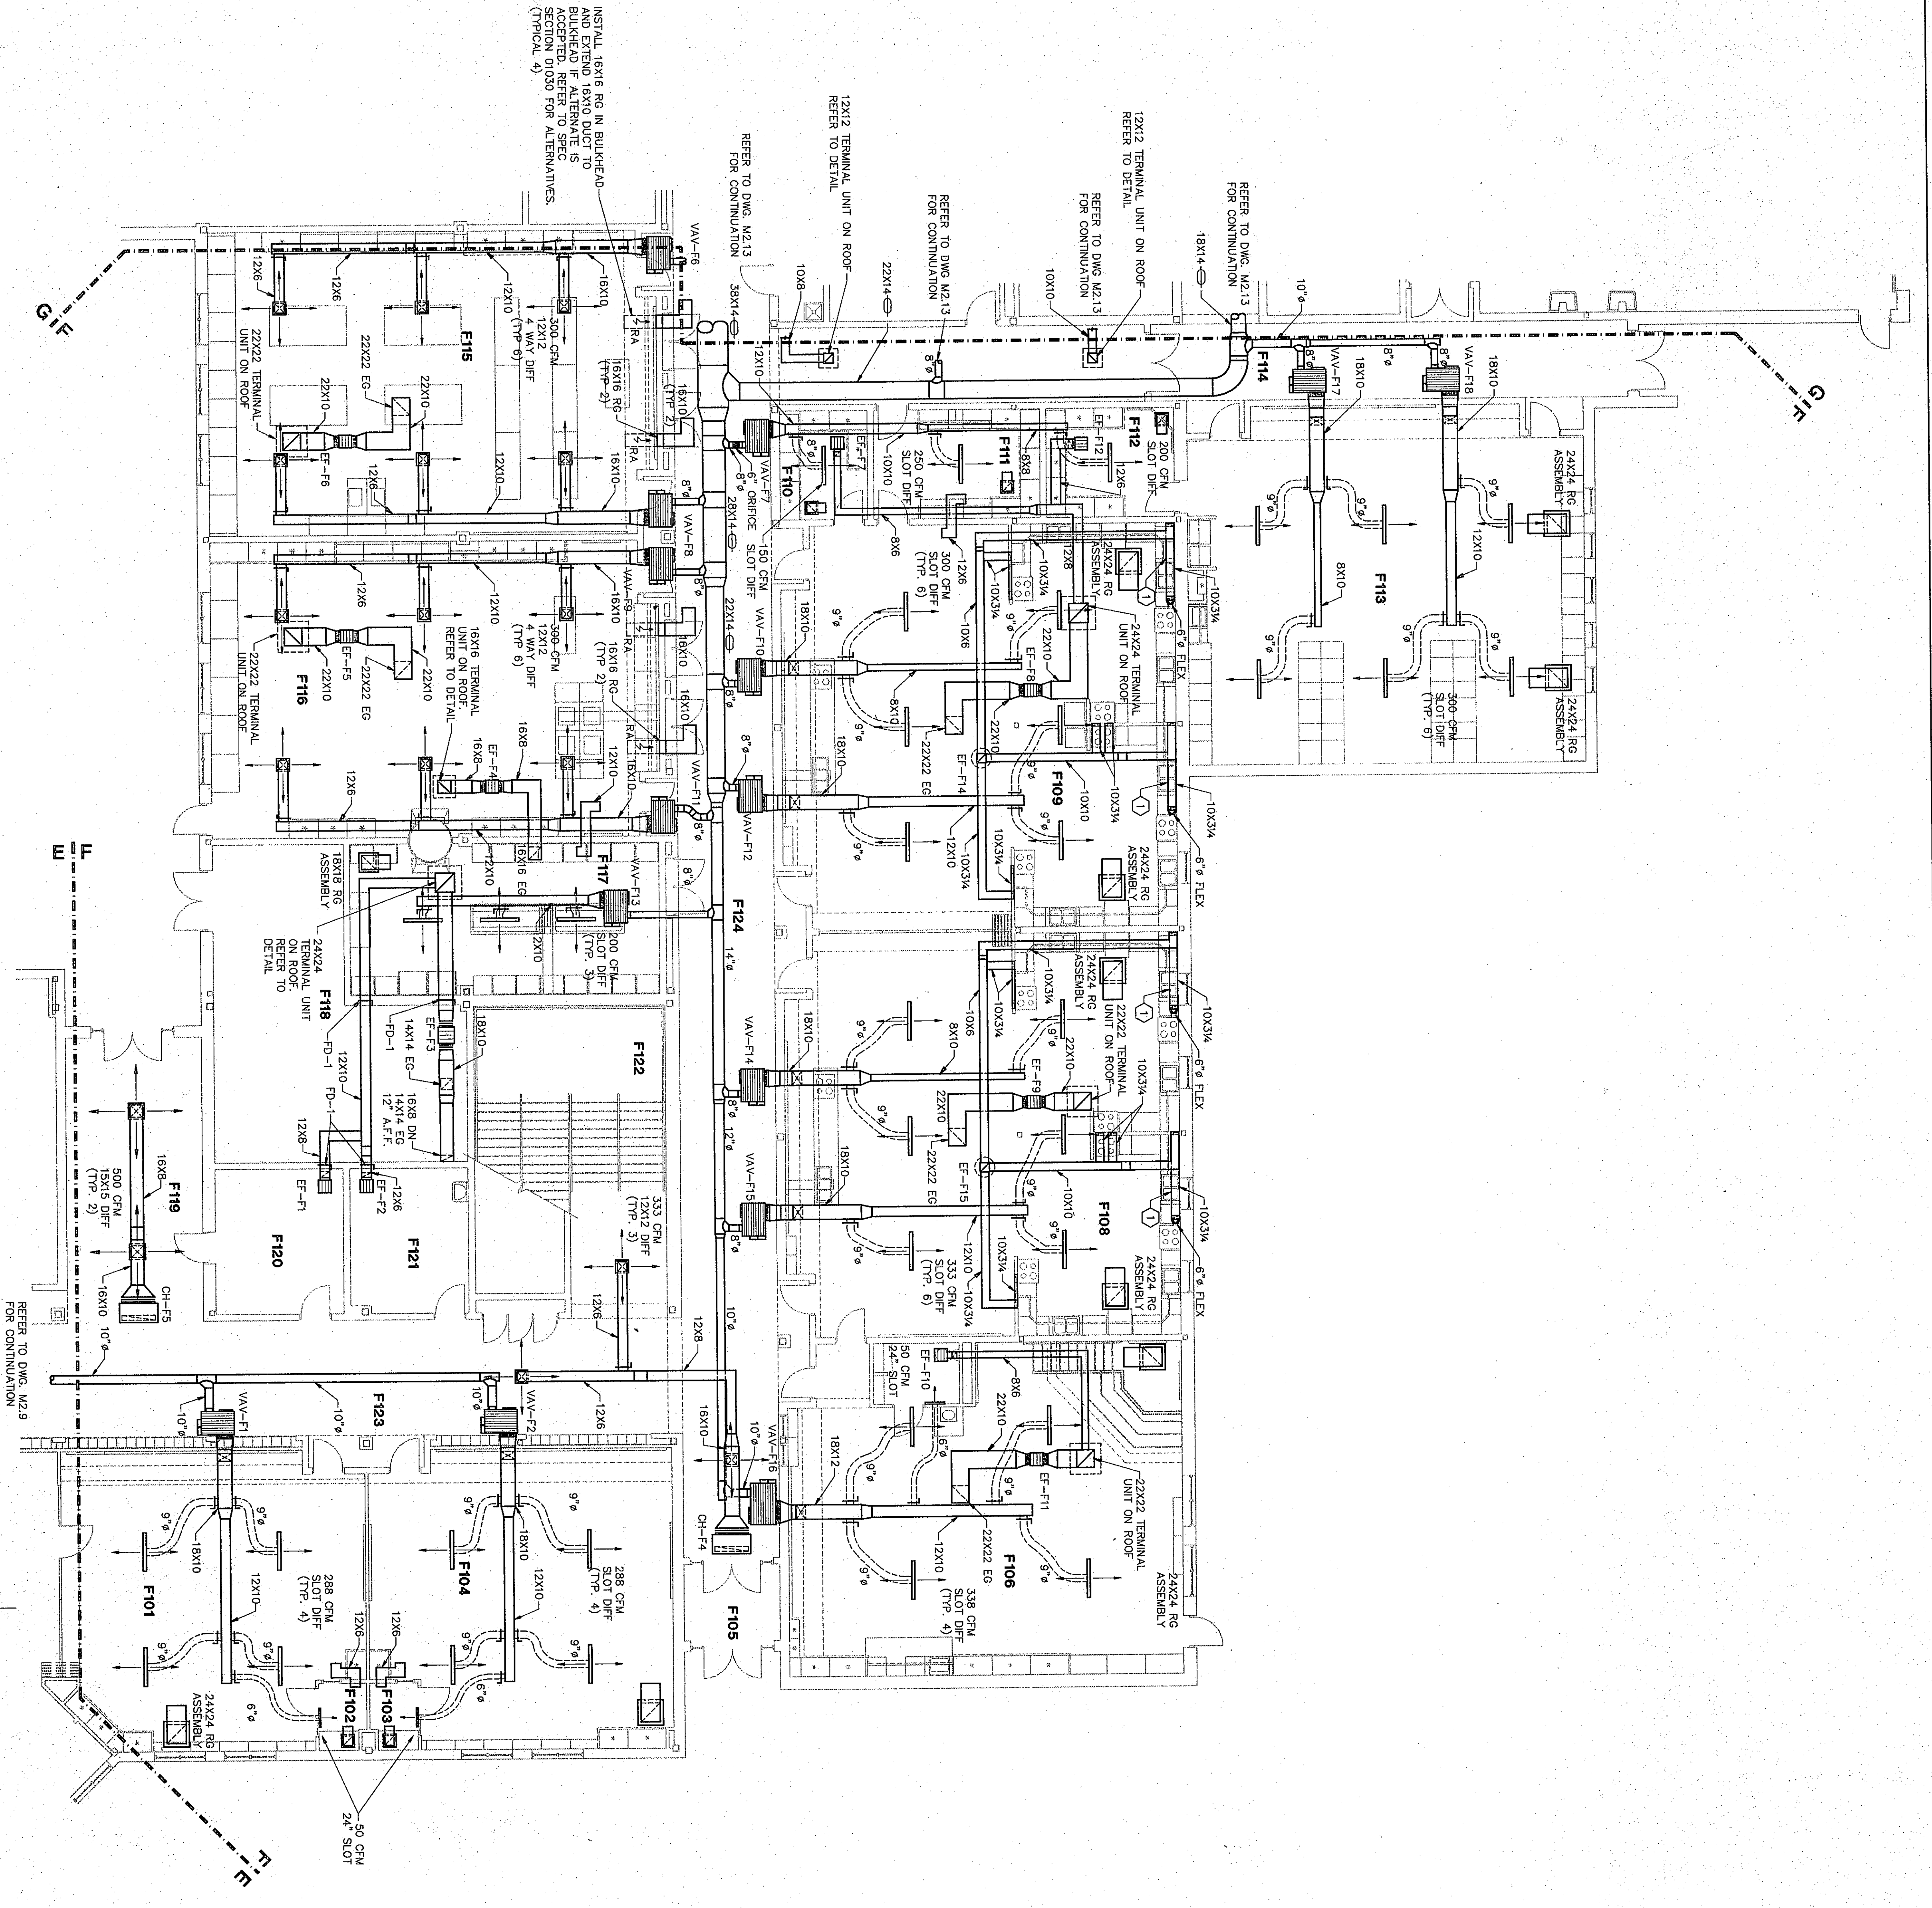

FLOOR PLAN UNIT "F"

1/8"=1'-0"

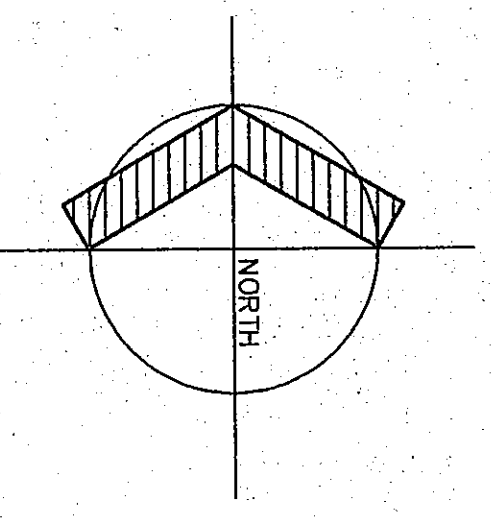

ROOM LEGEND "F"

ROOM NO.	ROOM NAME	AREA S.F.	CEILING HEIGHT	FOR/LANG.
F101	CLASSROOM	923	9'-4"	FOR/LANG.
F102	RECORDING	333	9'-4"	FOR/LANG.
F103	CLASSROOM	333	9'-4"	FOR/LANG.
F104	CLASSROOM	333	9'-4"	FOR/LANG.
F105	CLASSROOM	333	9'-4"	FOR/LANG.
F106	TOILET	57	9'-4"	FOR/LANG.
F107	TOILET	57	9'-4"	FOR/LANG.
F108	TOILET	57	9'-4"	FOR/LANG.
F109	TOILET	57	9'-4"	FOR/LANG.
F110	TOILET	57	9'-4"	FOR/LANG.
F111	TOILET	57	9'-4"	FOR/LANG.
F112	TOILET	57	9'-4"	FOR/LANG.
F113	TOILET	57	9'-4"	FOR/LANG.
F114	TOILET	57	9'-4"	FOR/LANG.
F115	TOILET	57	9'-4"	FOR/LANG.
F116	TOILET	57	9'-4"	FOR/LANG.
F117	TOILET	57	9'-4"	FOR/LANG.
F118	TOILET	57	9'-4"	FOR/LANG.
F119	TOILET	57	9'-4"	FOR/LANG.
F120	TOILET	57	9'-4"	FOR/LANG.
F121	TOILET	57	9'-4"	FOR/LANG.
F122	TOILET	57	9'-4"	FOR/LANG.
F123	TOILET	57	9'-4"	FOR/LANG.
F124	TOILET	57	9'-4"	FOR/LANG.
F125	TOILET	57	9'-4"	FOR/LANG.
F126	TOILET	57	9'-4"	FOR/LANG.
F127	TOILET	57	9'-4"	FOR/LANG.
F128	TOILET	57	9'-4"	FOR/LANG.
F129	TOILET	57	9'-4"	FOR/LANG.

EQUIPMENT NOTES

1. RUN DUCT TIGHT TO BACK OF TOE SPACE IN BASE CABINETS.

NOTES

1. ALL RECTANGULAR SUPPLY AND RETURN DUCTING IS TO BE WRAPPED WITH DUCTWRAP. ALL FRESH AIR INTAKE DUCTING IS TO BE WRAPPED WITH DUCTWRAP. ALL EXHAUST DUCTING IS TO BE WRAPPED WITH DUCTWRAP. ALL EXHAUST DUCTING IS TO BE WRAPPED WITH DUCTWRAP. ALL EXHAUST DUCTING IS TO BE WRAPPED WITH DUCTWRAP.
2. TERMINAL UNITS FOR EXHAUST FANS AND RANGE HOODS TO BE SPECIFIED BY OWNER. SIZE SHOWN IS MINIMUM ACCEPTABLE SIZE & BRAND.
3. PROVIDE OPERED BLADE VOLUME DAMPERS ON ALL SUPPLY DUCTS. PROVIDE OPERED BLADE VOLUME DAMPERS ON ALL SUPPLY DUCTS. PROVIDE OPERED BLADE VOLUME DAMPERS ON ALL SUPPLY DUCTS.
4. PD-1 = 1 HR FIRE DAMPER ASSEMBLY. PD-2 = 2 HR FIRE DAMPER ASSEMBLY. PD-3 = 3 HR FIRE DAMPER ASSEMBLY. PD-4 = 4 HR FIRE DAMPER ASSEMBLY. PD-5 = 5 HR FIRE DAMPER ASSEMBLY.
5. COMPARTMENT GRILLE & DIFFUSER LOCATIONS WITH REFLECTED CEILING AND ELECTRICAL PLANS. (DIFFUSERS TO BE MIN. 4'-0" FROM MOTION DETECTORS.)
6. ALL LOW PRESSURE DUCT OFFSETS OVER PROJECTION SCREENS IN TYPICAL CLASSROOMS, TO BE ELIMINATED IN BASE BLD.


VENTILATION PLAN UNIT "F"

DRAWN BY: SCB COMM. NO.: 95067.00
 CHECKED BY: CAM DATE: APRIL 21, 1997

M2.11

REVISIONS NO. DATE

Fanning/Howey Associates, Inc.
 Architects Engineers Consultants

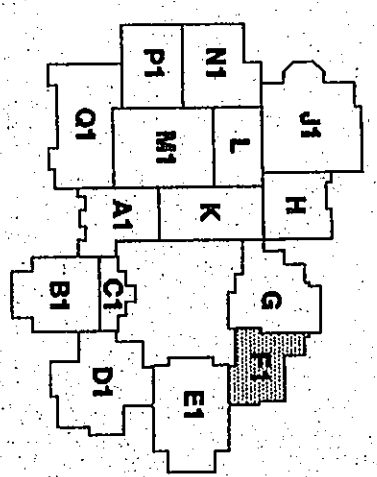

THE NEW
CHESTERTON HIGH SCHOOL
 FOR THE
 DUNELAND SCHOOL CORPORATION
 CHESTERTON, INDIANA

Copyright 1997 by Fanning/Howey Associates, Inc.