


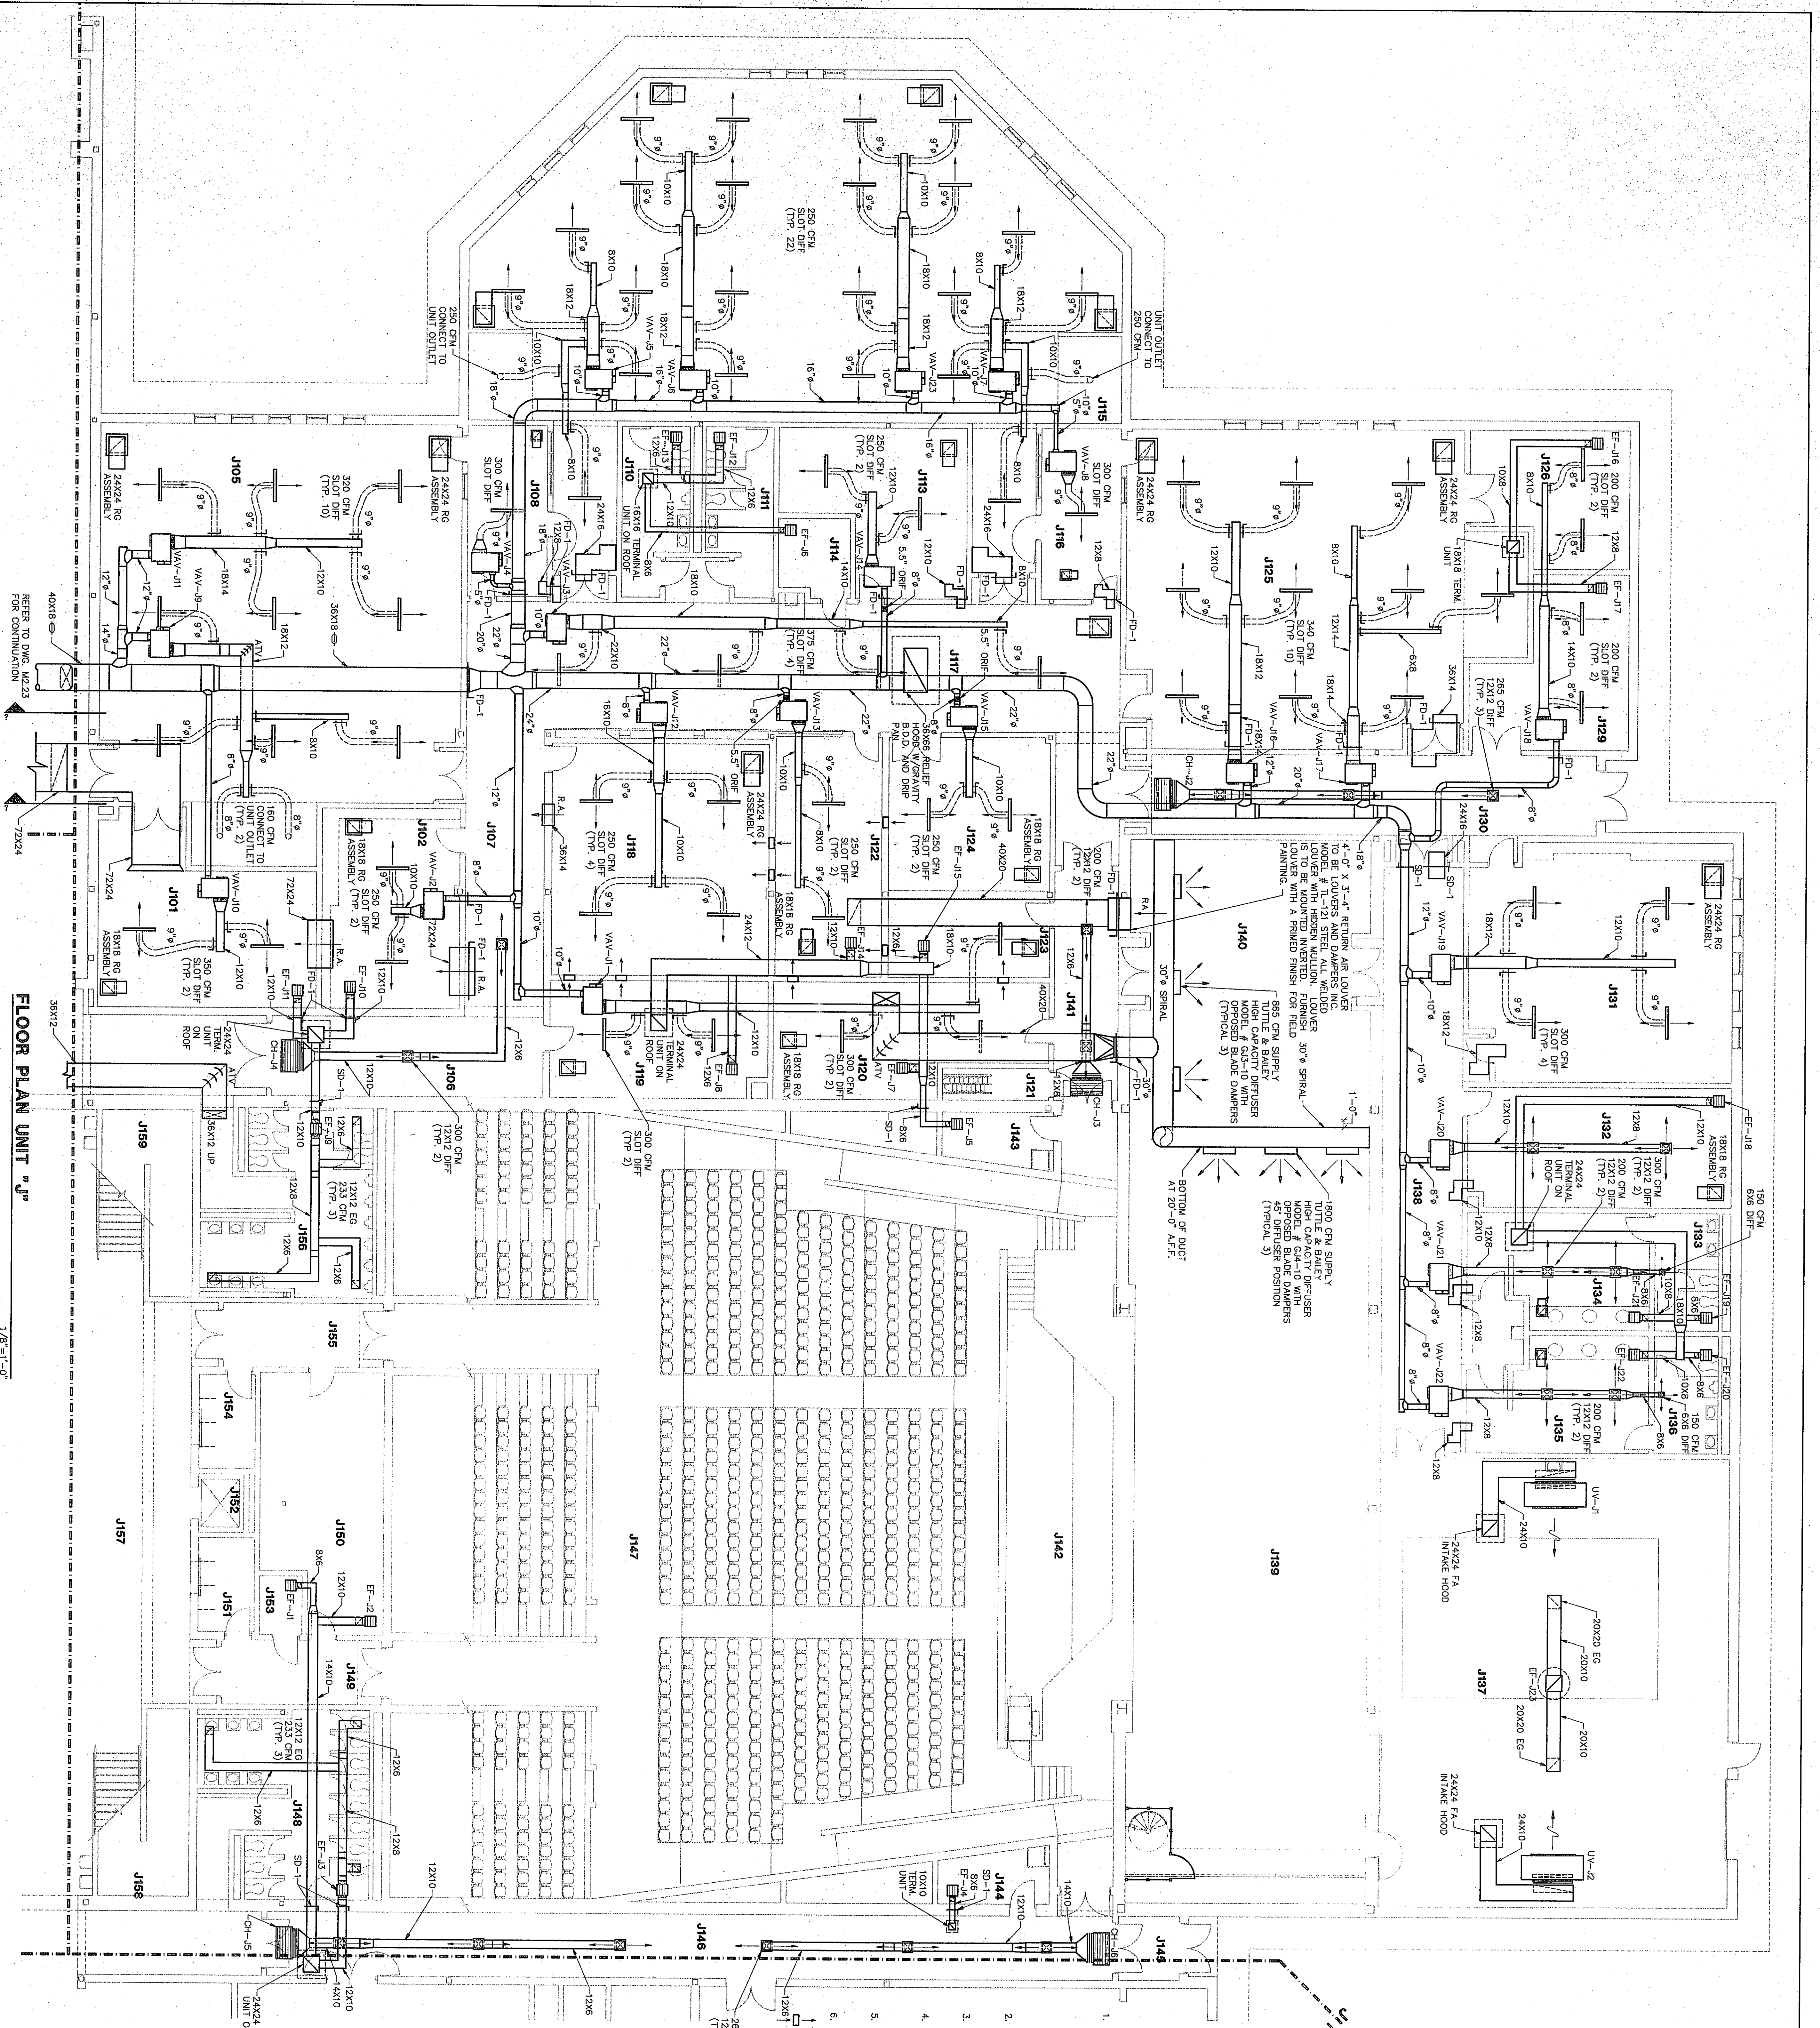


FLOOR PLAN UNIT "J"

1/8"=1'-0"

REFER TO DWG. NO. 23 FOR CONTINUATION

ROOM LEGEND "J"			
ROOM NO.	ROOM NAME	AREA	CEILING HEIGHT
J101	PRECISION STORAGE	555	9'-4"
J102	PRACTICE ROOM	63	9'-4"
J103	PRACTICE ROOM	63	9'-4"
J104	PRACTICE ROOM	63	9'-4"
J200	PRACTICE ROOM	63	9'-4"

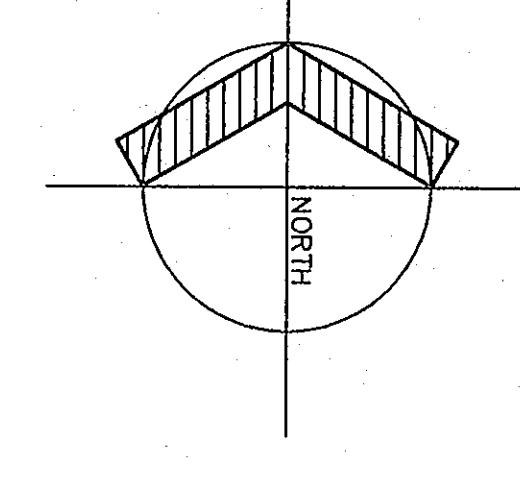


VENTILATION PLAN UNIT "J"

DRAWN BY: SCB COMM. NO.: 95067.00
CHECKED BY: CAM DATE: APRIL 21, 1997

M2.16

REVISIONS NO. DATE

Fanning/Howey Associates, Inc.
Architects Engineers Consultants

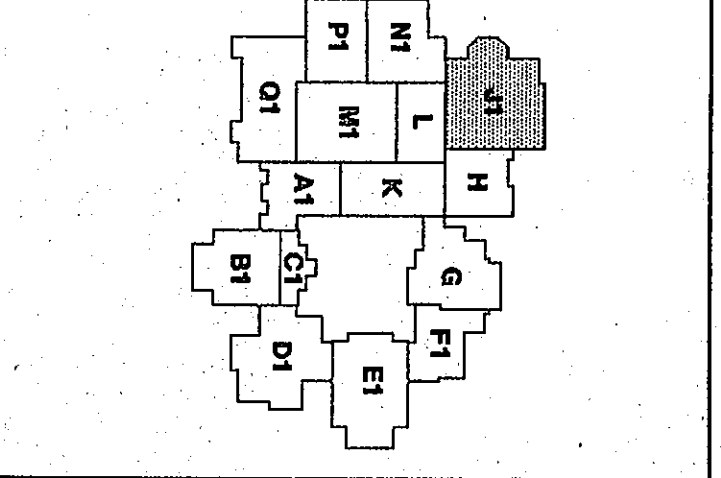

THE NEW
CHESTERTON HIGH SCHOOL
FOR THE
DUNELAND SCHOOL CORPORATION
CHESTERTON, INDIANA

Copyright 1997 by Fanning/Howey Associates, Inc.