


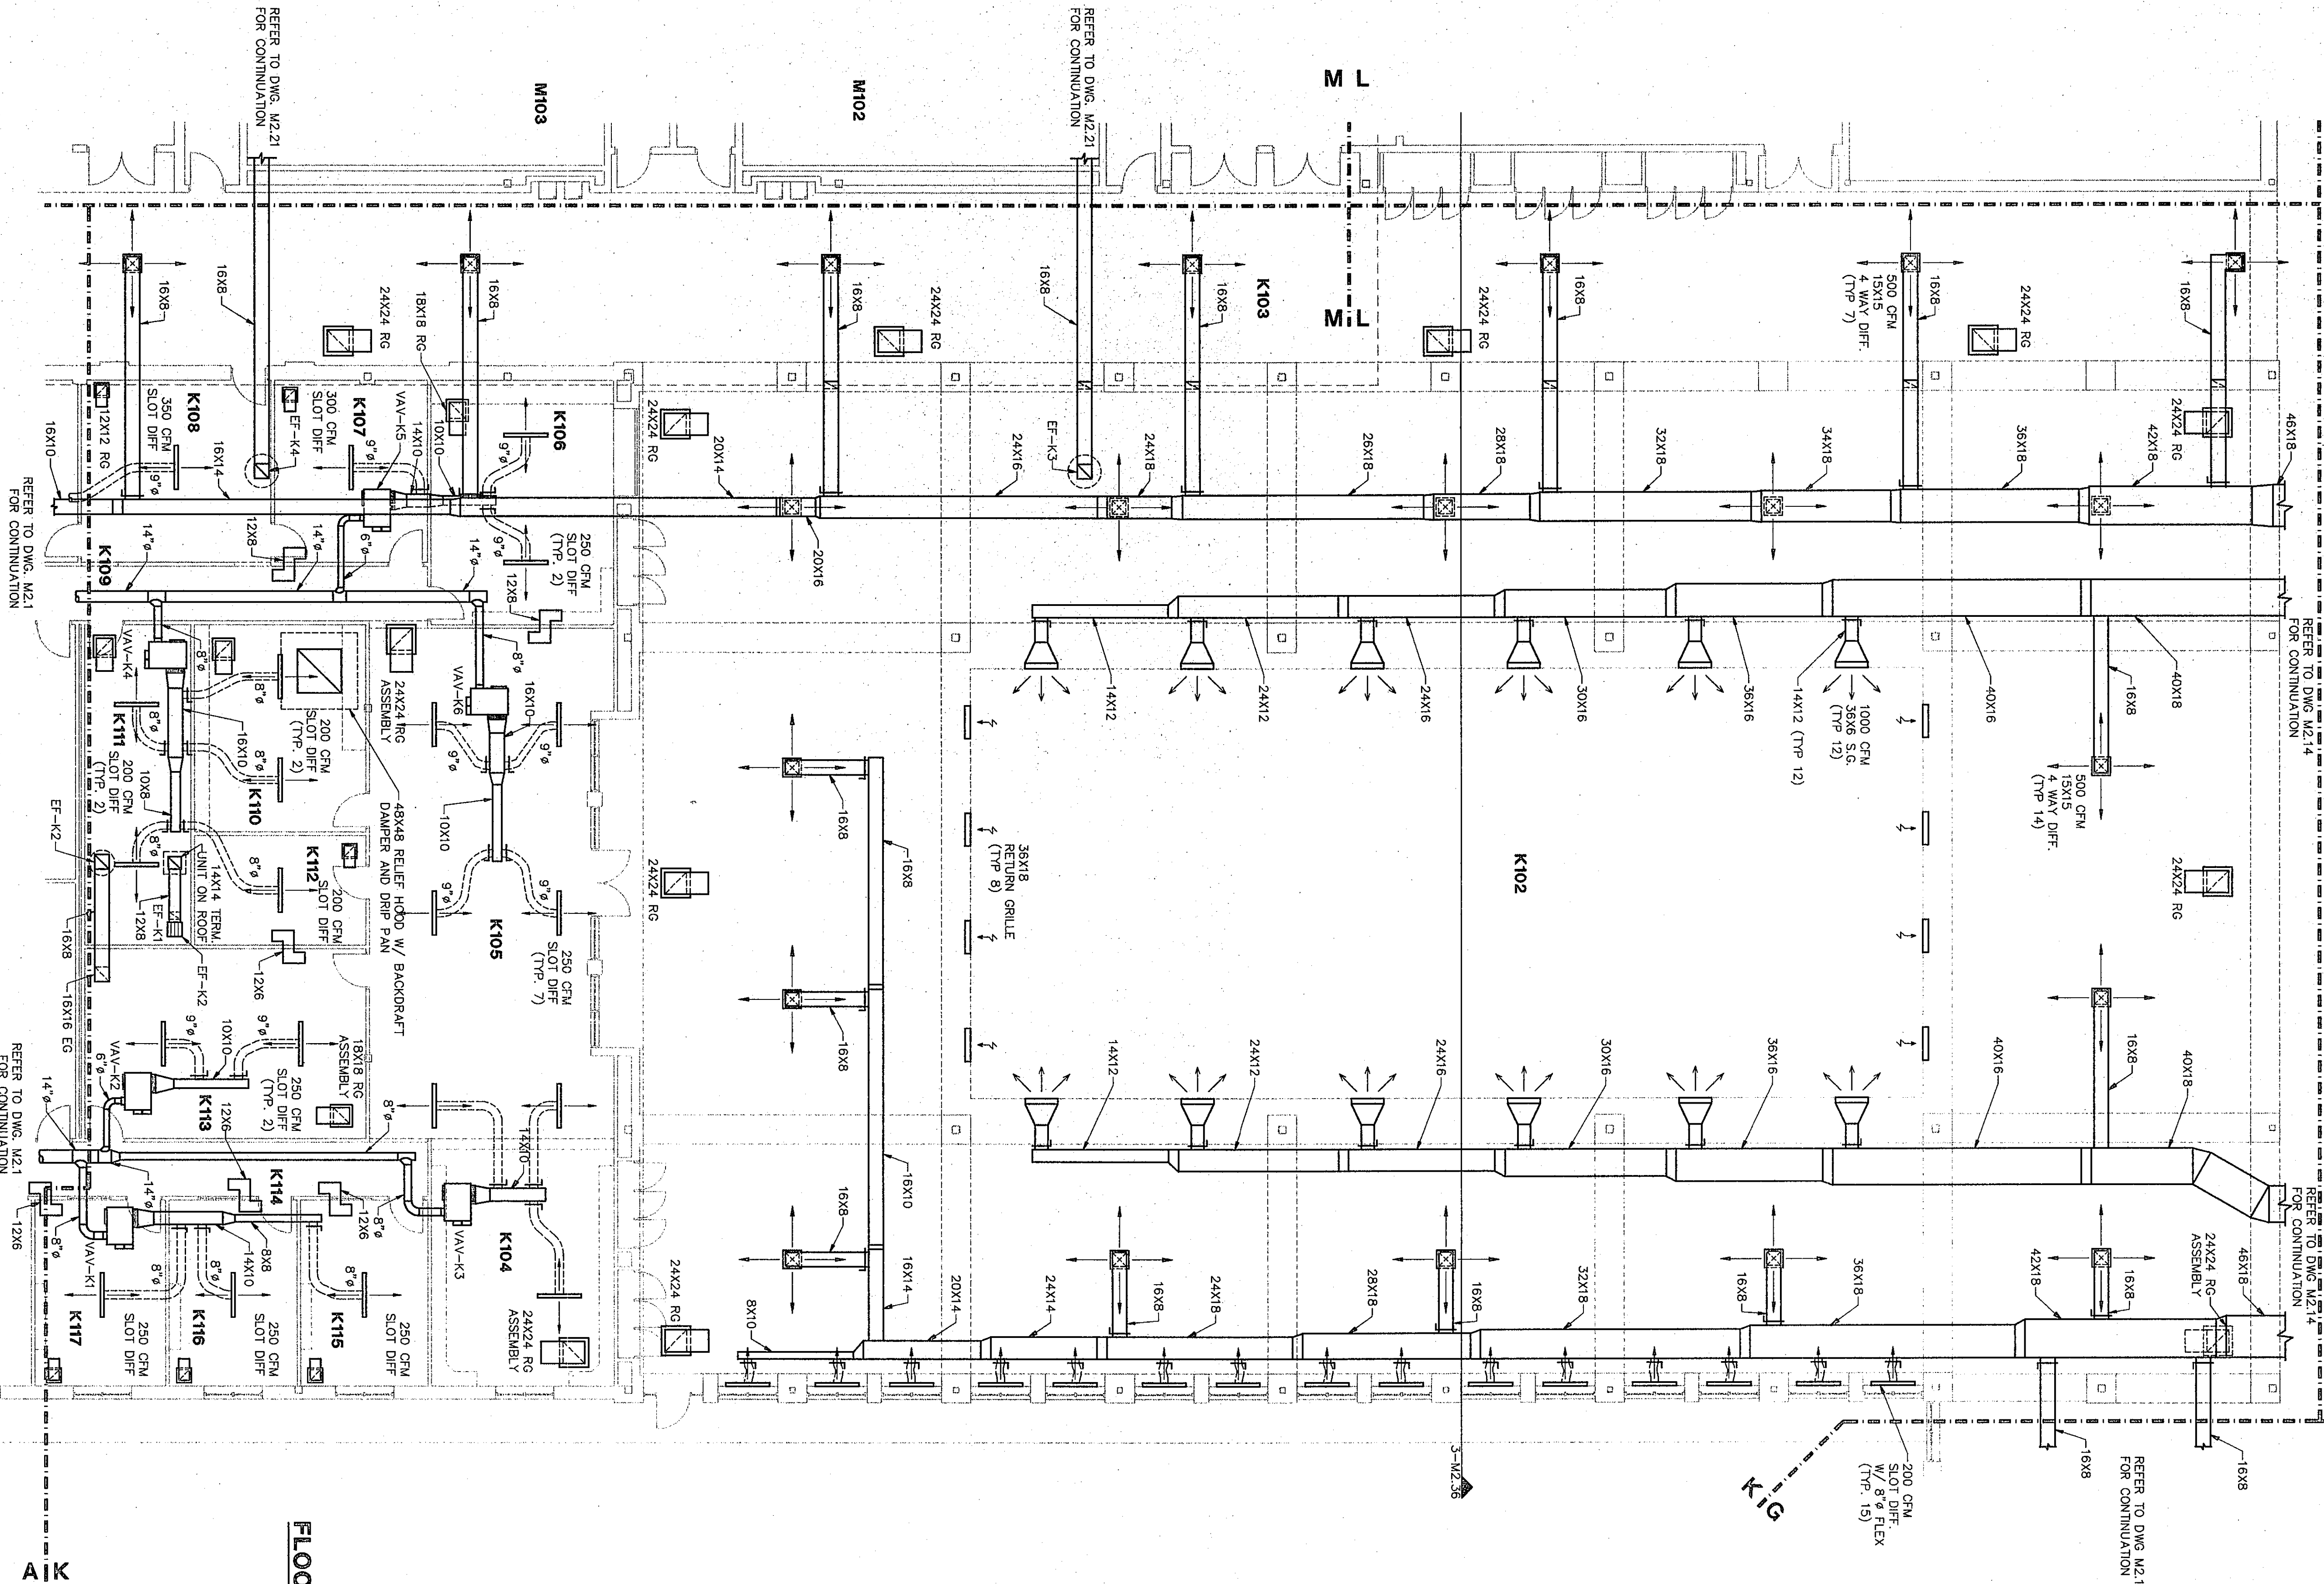

ROOM LEGEND "K"



ROOM NO.	ROOM NAME	AREA S.F.	CEILING HEIGHT
K101	NOT USED	1346	11'-0"
K102	STUDENT DINING	378	9'-0"
K103	STUDENT DINING	378	9'-0"
K104	RESOURCE/CAREER CENTER	981	9'-0"
K105	RECEPTIONIST	233	9'-0"
K106	CONFERENCE	281	9'-0"
K107	SECRETARY	281	9'-0"
K108	SECRETARY	281	9'-0"
K109	SECRETARY	281	9'-0"
K110	WORKROOM	281	9'-0"
K111	STORAGE	281	9'-0"
K112	STORAGE	281	9'-0"
K113	CENTRAL STORAGE	188	9'-0"
K114	CORRIDOR OFFICE	188	9'-0"
K115	GUIDANCE OFFICE	188	9'-0"
K116	GUIDANCE OFFICE	188	9'-0"
K117	GUIDANCE OFFICE	204	9'-0"

NOTES


1. ALL RECTANGULAR SUPPLY AND RETURN DUCTING IS TO BE WRAPPED WITH DUCT WRAP. ALL SPIRAL DUCTING IS TO BE WRAPPED WITH DUCT WRAP. ALL SPIRAL DUCTING IS TO BE WRAPPED WITH DUCT WRAP. ALL SPIRAL DUCTING IS TO BE WRAPPED WITH DUCT WRAP.
2. TYPICAL UNITS FOR EXHAUST FANS AND RANGE HOODS TO BE PENN. AERITE OR APPROVED EQUAL WITH CORB & BRD SCREEN. SIZE SHOWN IS MINIMUM ACCEPTABLE SIZE.
3. PROVIDE OPPOSED BLADE VOLUME DAMPERS ON ALL SUPPLY DIFFUSERS AND GRILLES (EXCEPT SLOT DIFFUSERS AND GYMNASIUM RETURN GRILLE).
4. PD-1 = 1 HR FIRE DAMPER ASSEMBLY
PD-2 = 2 HR FIRE DAMPER ASSEMBLY
PD-3 = 3 HR FIRE DAMPER ASSEMBLY
SD-1 = SMOKE DAMPER ASSEMBLY
5. COORDINATE GRILLE & DIFFUSER LOCATIONS WITH REFLECTED LIGHTING FIXTURES.
6. ALL LOW PRESSURE DUCT SYSTEMS OVER PROTECTION SCREENS IN TYPICAL CLASSROOMS, TO BE ELIMINATED IN BASE BID.

FLOOR PLAN UNIT "K"

1/8"=1'-0"

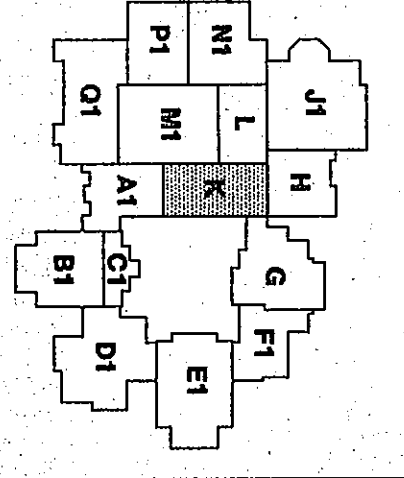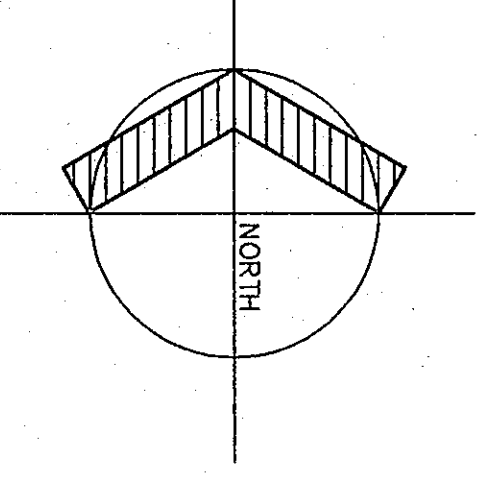

THE NEW
CHESTERTON HIGH SCHOOL
FOR THE
DUNELAND SCHOOL CORPORATION
CHESTERTON, INDIANA

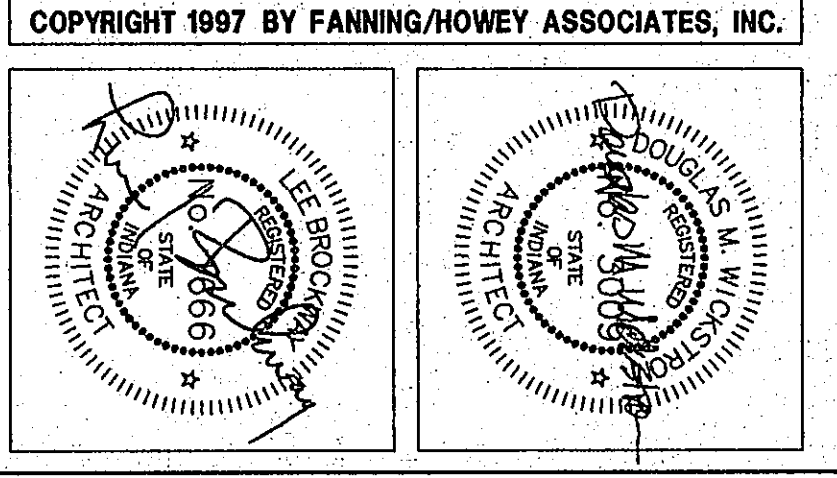

VENTILATION PLAN UNIT "K"

DRAWN BY: SCB COMM. NO.: 95067.00
CHECKED BY: CAM DATE: APRIL 21, 1997

M2.18

REVISIONS NO. DATE

Fanning/Howey Associates, Inc.
Architects Engineers Consultants