




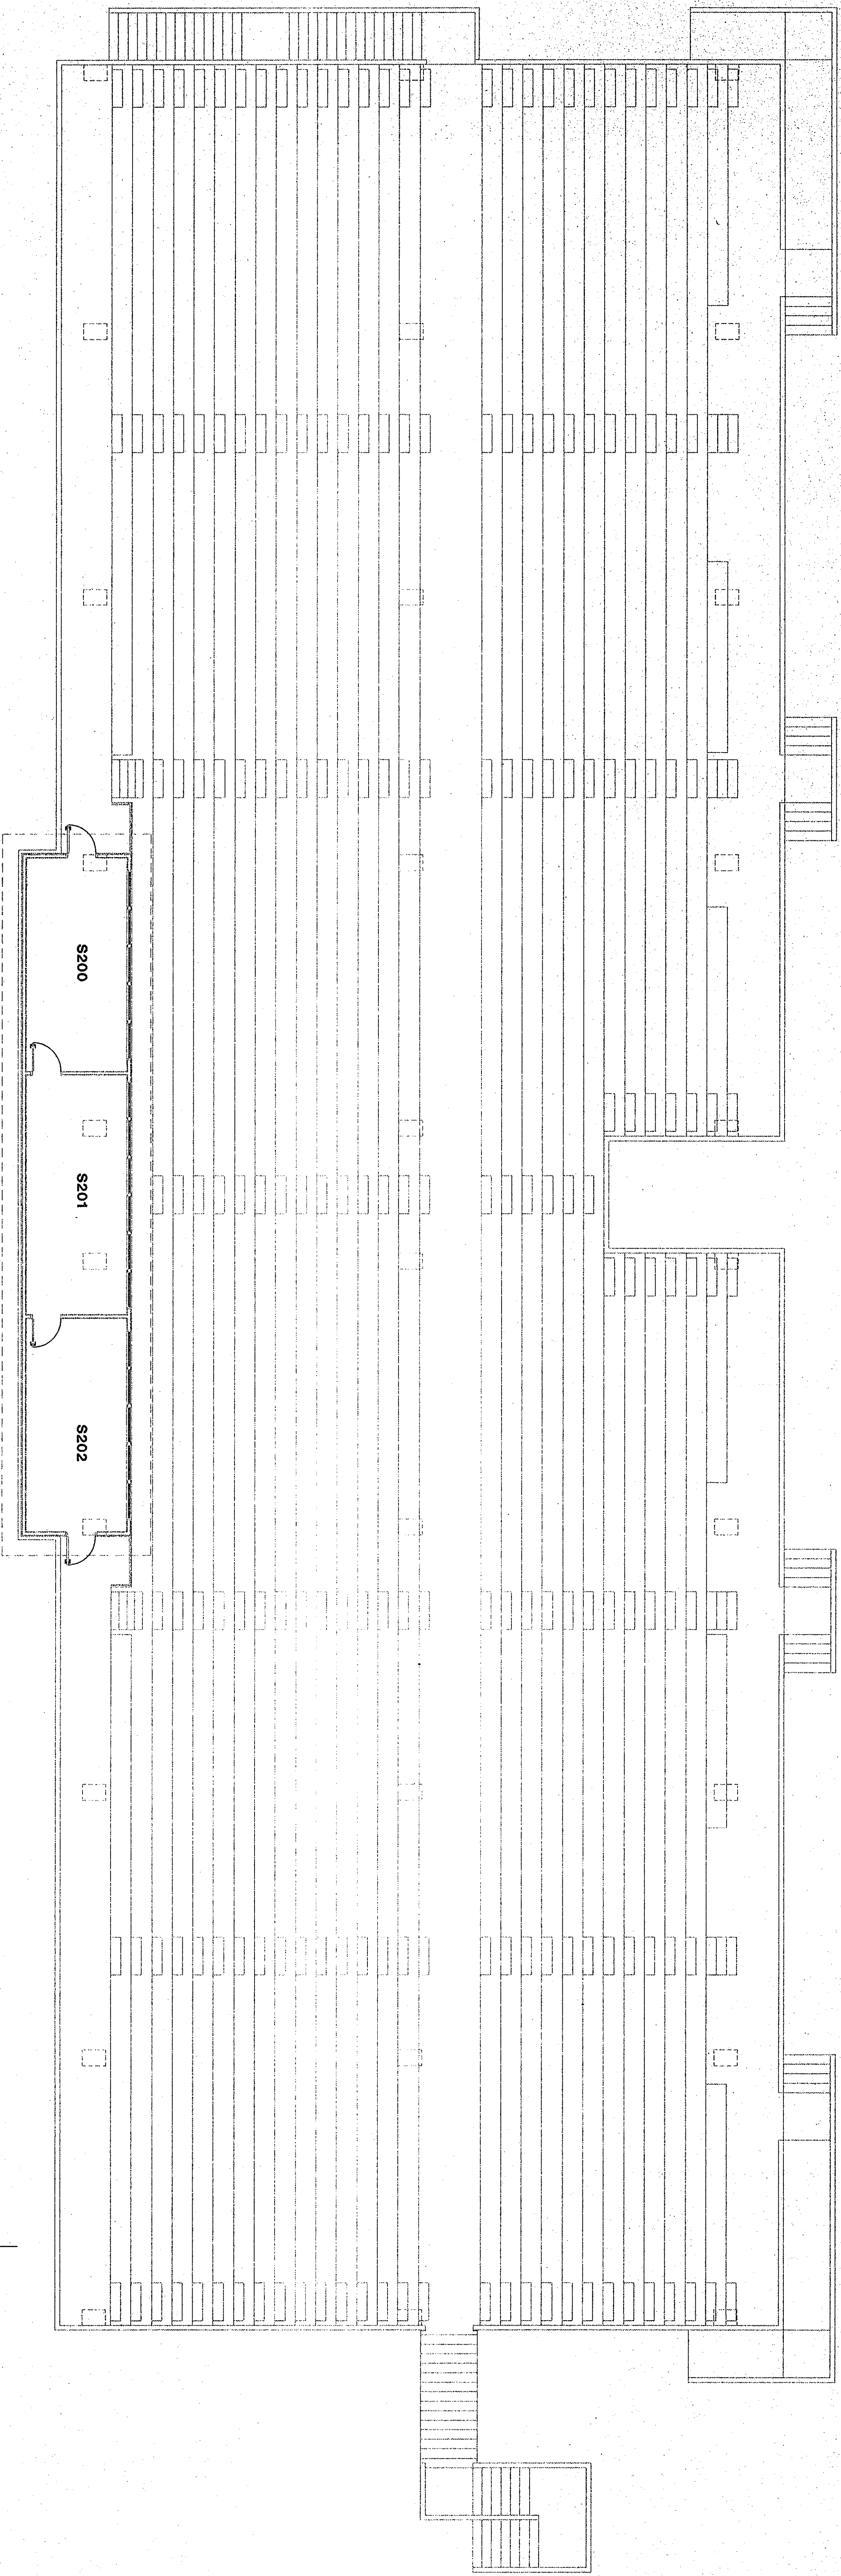


FLOOR PLAN UNIT "S2"
(ALTERNATE, REFER TO SPECIFICATIONS SECTION 01030)

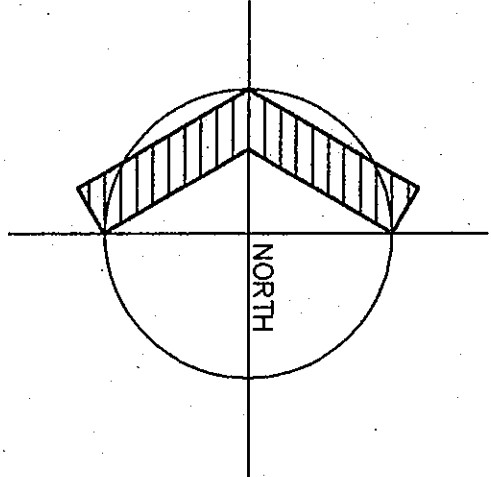

ROOM NO.	ROOM NAME	AREA S.F.	CEILING HEIGHT	ROOM NO.	ROOM NAME	AREA S.F.	CEILING HEIGHT	ROOM NO.	ROOM NAME	AREA S.F.	CEILING HEIGHT
S100	LOOKER ROOM ENTRY	47	---	S109	TOILET	282	9'-4"	S127	CONCESSIONS	626	9'-4"
S101	LOOKER ROOM	1976	9'-4"	S110	SHOWER ROOM	340	9'-4"	S128	STORAGE	132	---
S102	SHOWER	176	9'-4"	S111	LOCKER ROOM	2014	9'-4"	S129	MECHANICAL/ELECTRICAL	380	---
S103	OFFICE	151	9'-4"	S112	STORAGE	2495	9'-4"	S200	PRESS BOX	240	9'-0"
S104	TOILET	53	9'-4"	S113	STORAGE	2495	9'-4"	S201	PRESS BOX	289	9'-0"
S105	TOILET	53	9'-4"	S114	STORAGE	520	9'-4"	S202	PRESS BOX	240	9'-0"
S106	ROOM ENTRY	149	9'-4"	S115	LAUNDRY ROOM	520	9'-4"				
S107	OFFICE	53	9'-4"	S116	TRAINING ROOM	500	9'-4"				
S108	TOILET	53	9'-4"	S117							

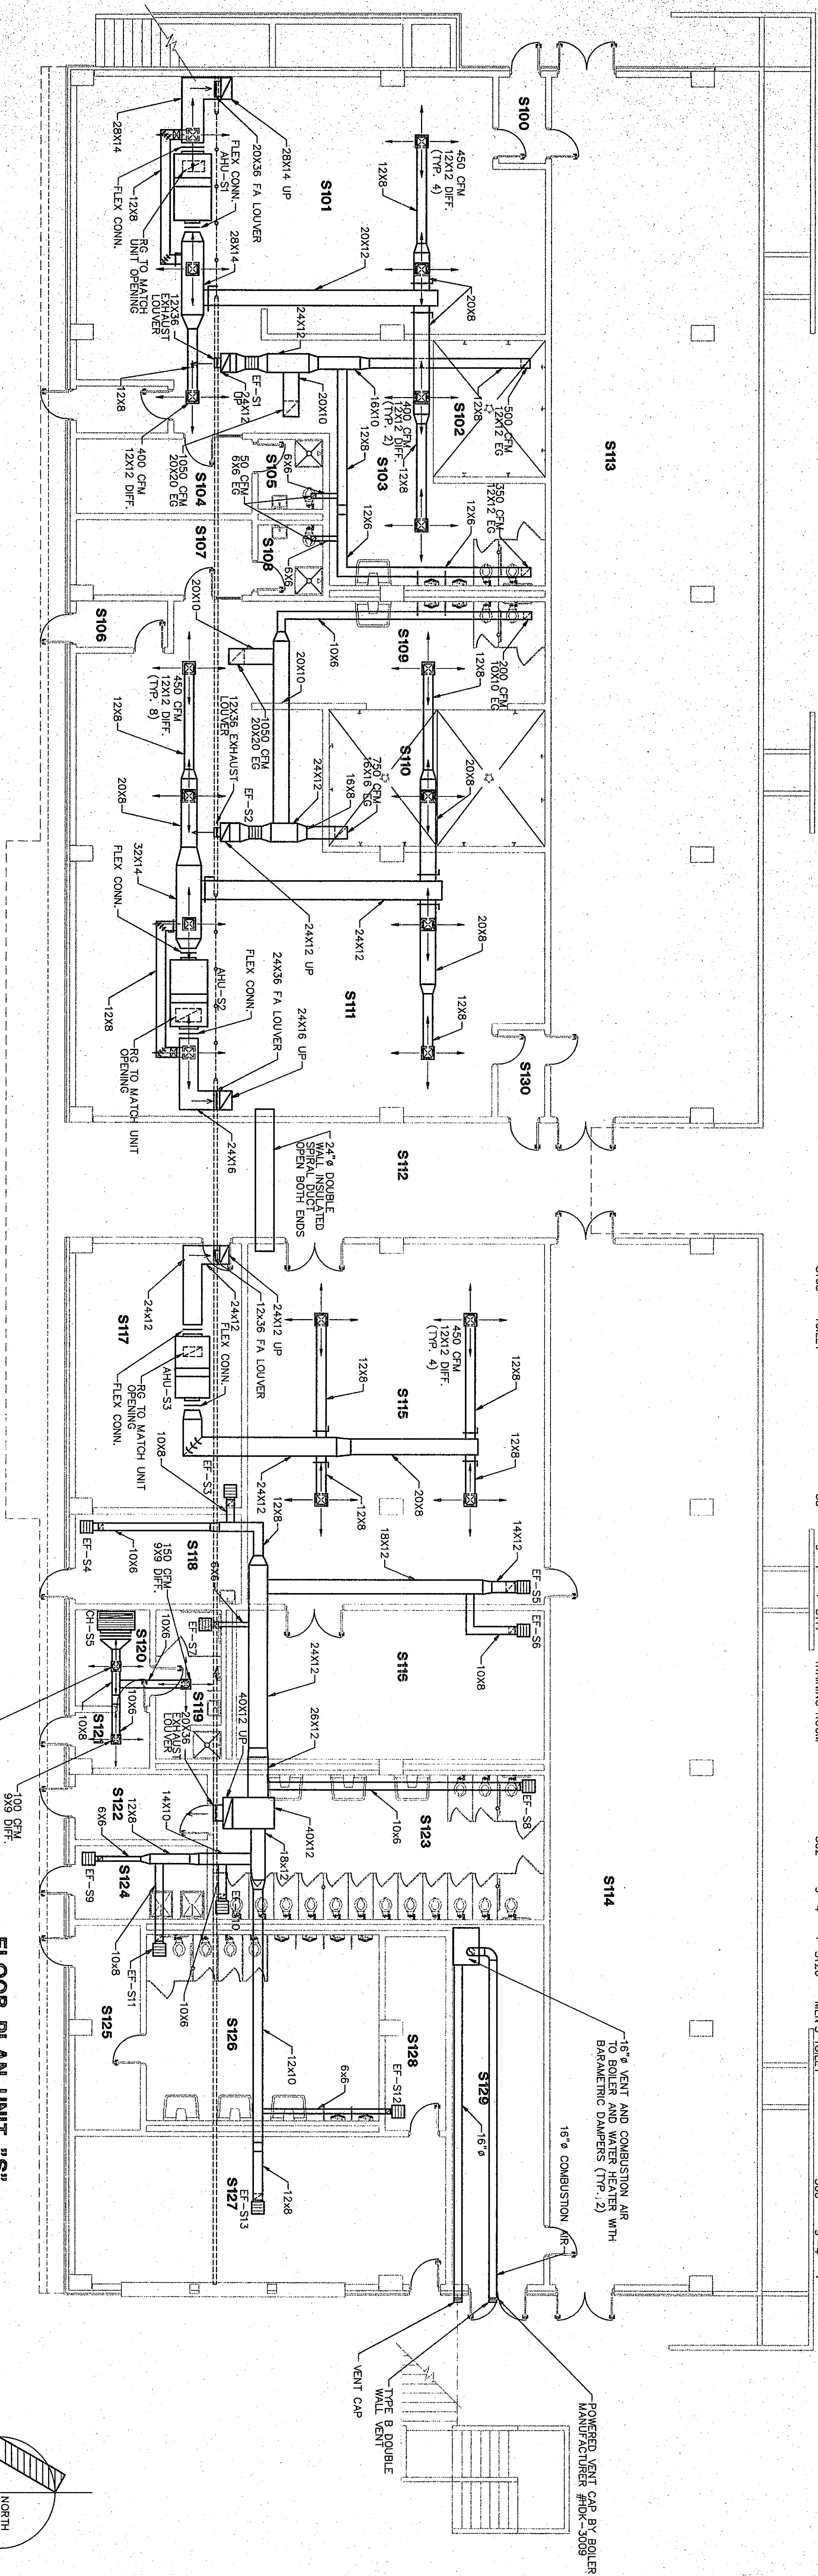


FLOOR PLAN UNIT "S1"
(ALTERNATE, REFER TO SPECIFICATIONS SECTION 01030)

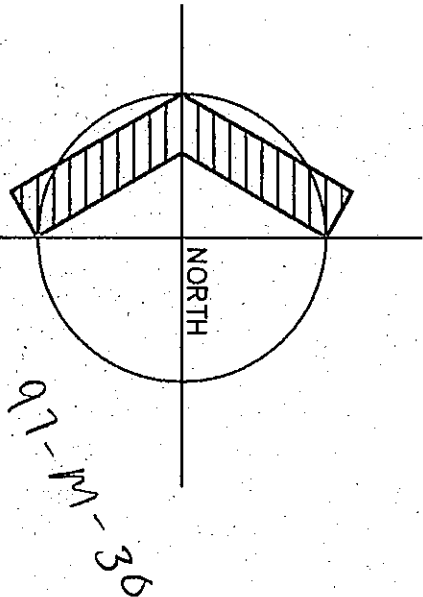

Fanning/Howey Associates, Inc.
Architects Engineers Consultants

THE NEW CHESTERTON HIGH SCHOOL
FOR THE
DUNELAND SCHOOL CORPORATION
CHESTERTON, INDIANA

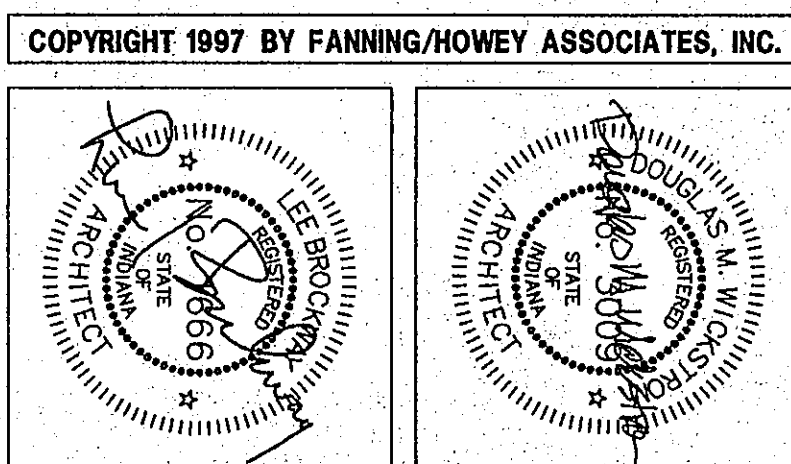

MECHANICAL PLAN	
DRAWN BY: RAH	COMM. NO.: 95067.00
CHECKED BY: CAM	DATE: APRIL 21, 1997
M2.29	
REVISIONS NO. DATE	