

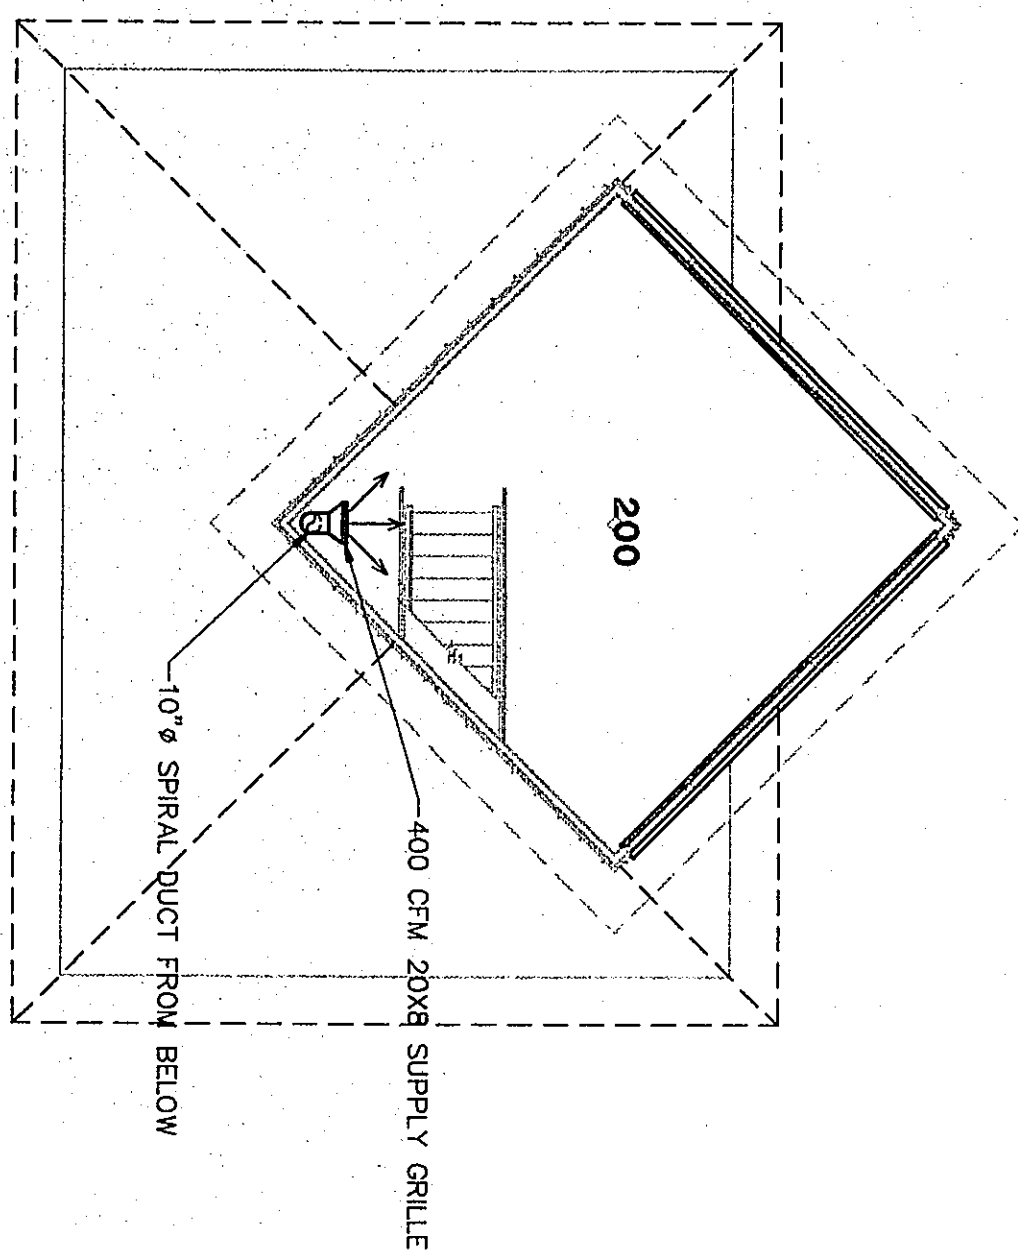
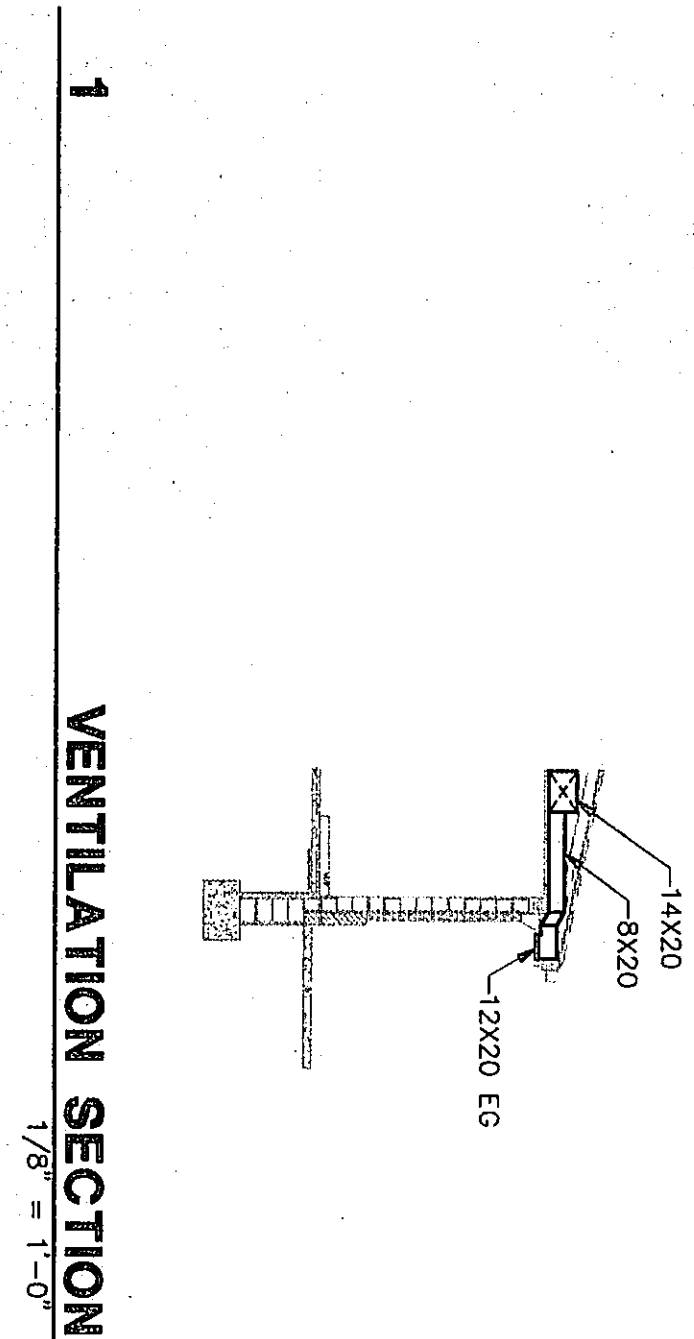



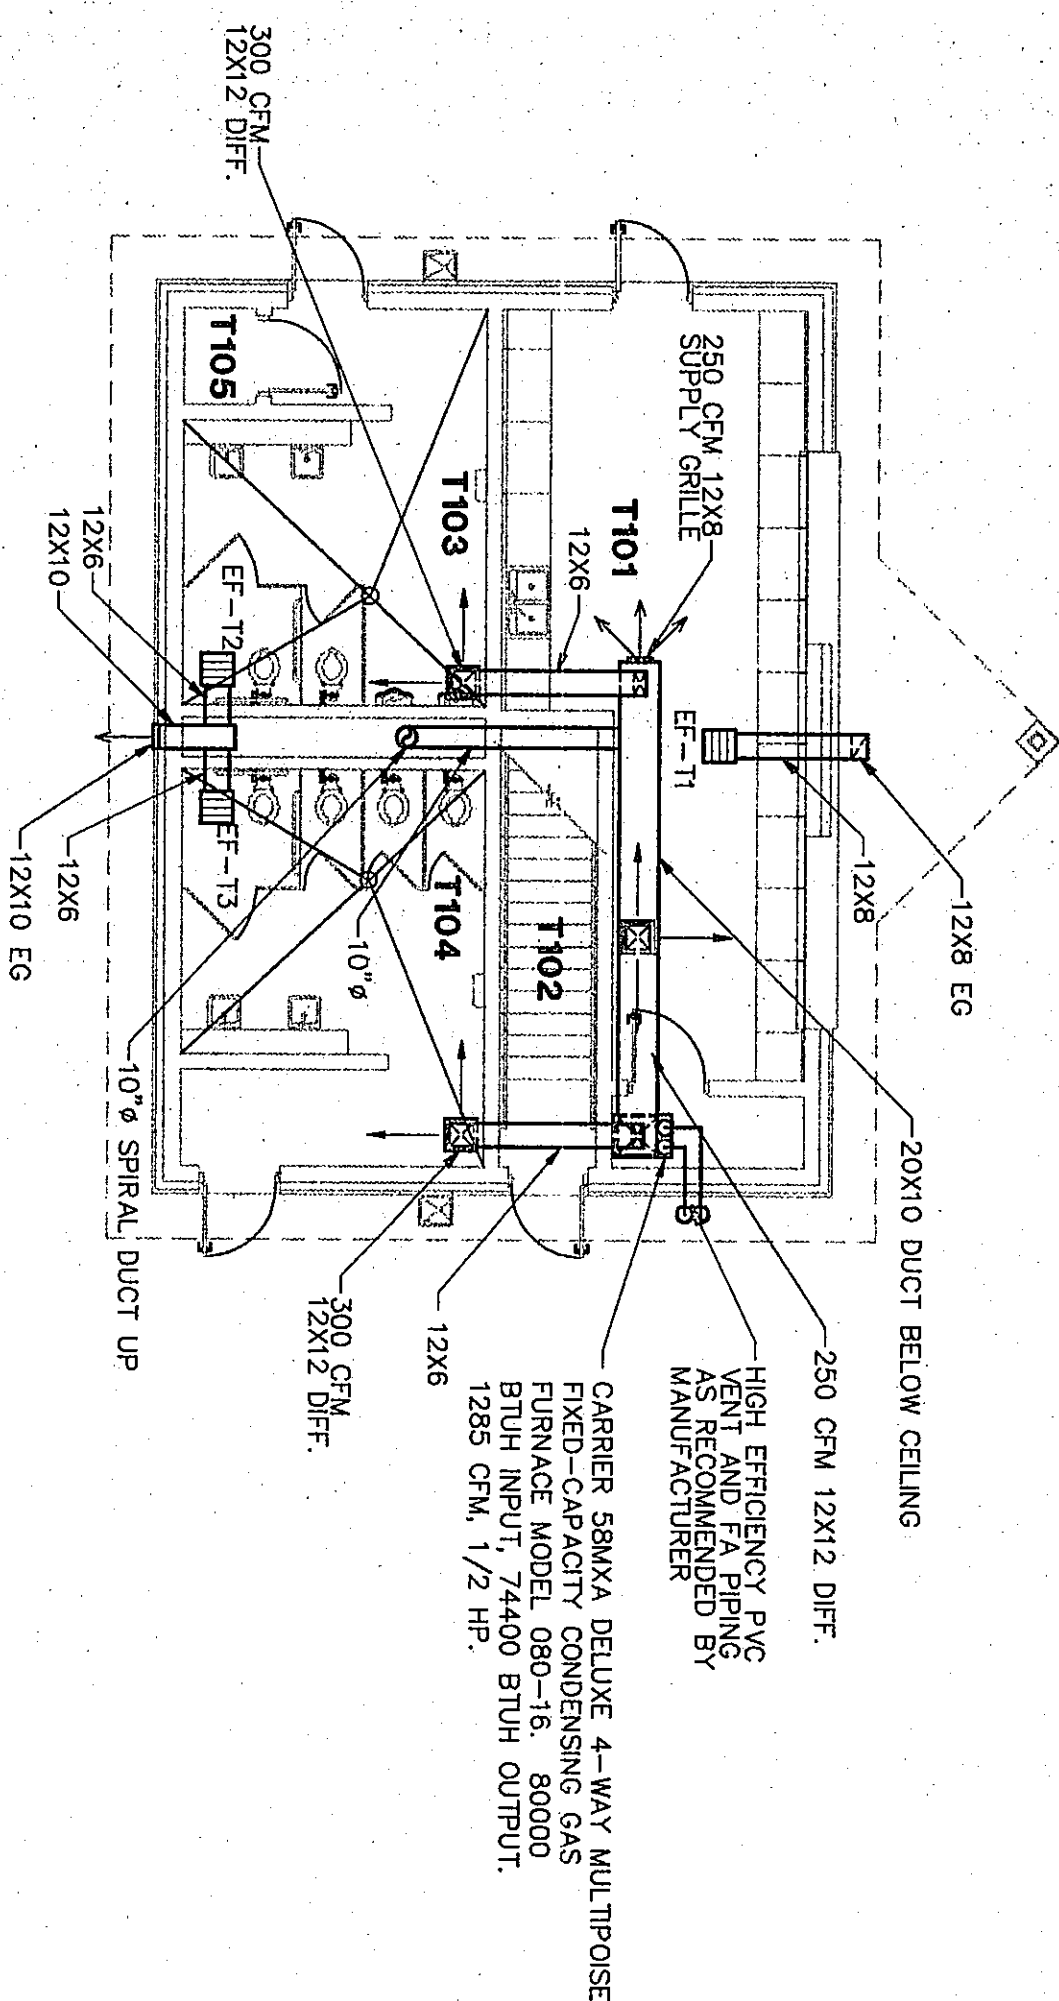


NOTE: 2ND FLOOR WORK TYPICAL FOR UNITS T, U, AND V.

2ND FLOOR PLAN UNITS "T, U & V"


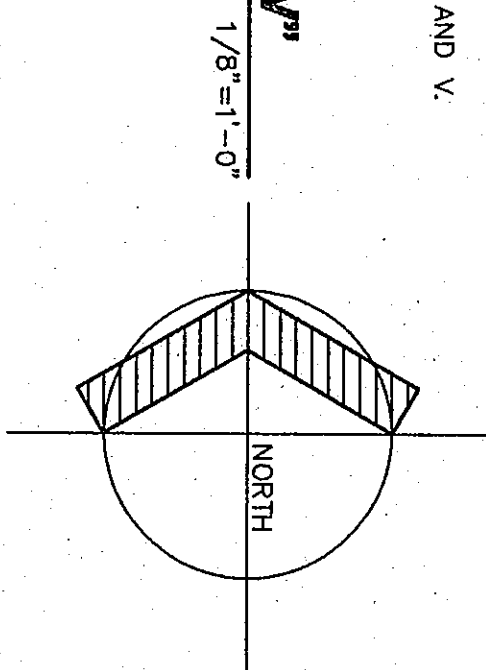


FLOOR PLAN UNIT "T"

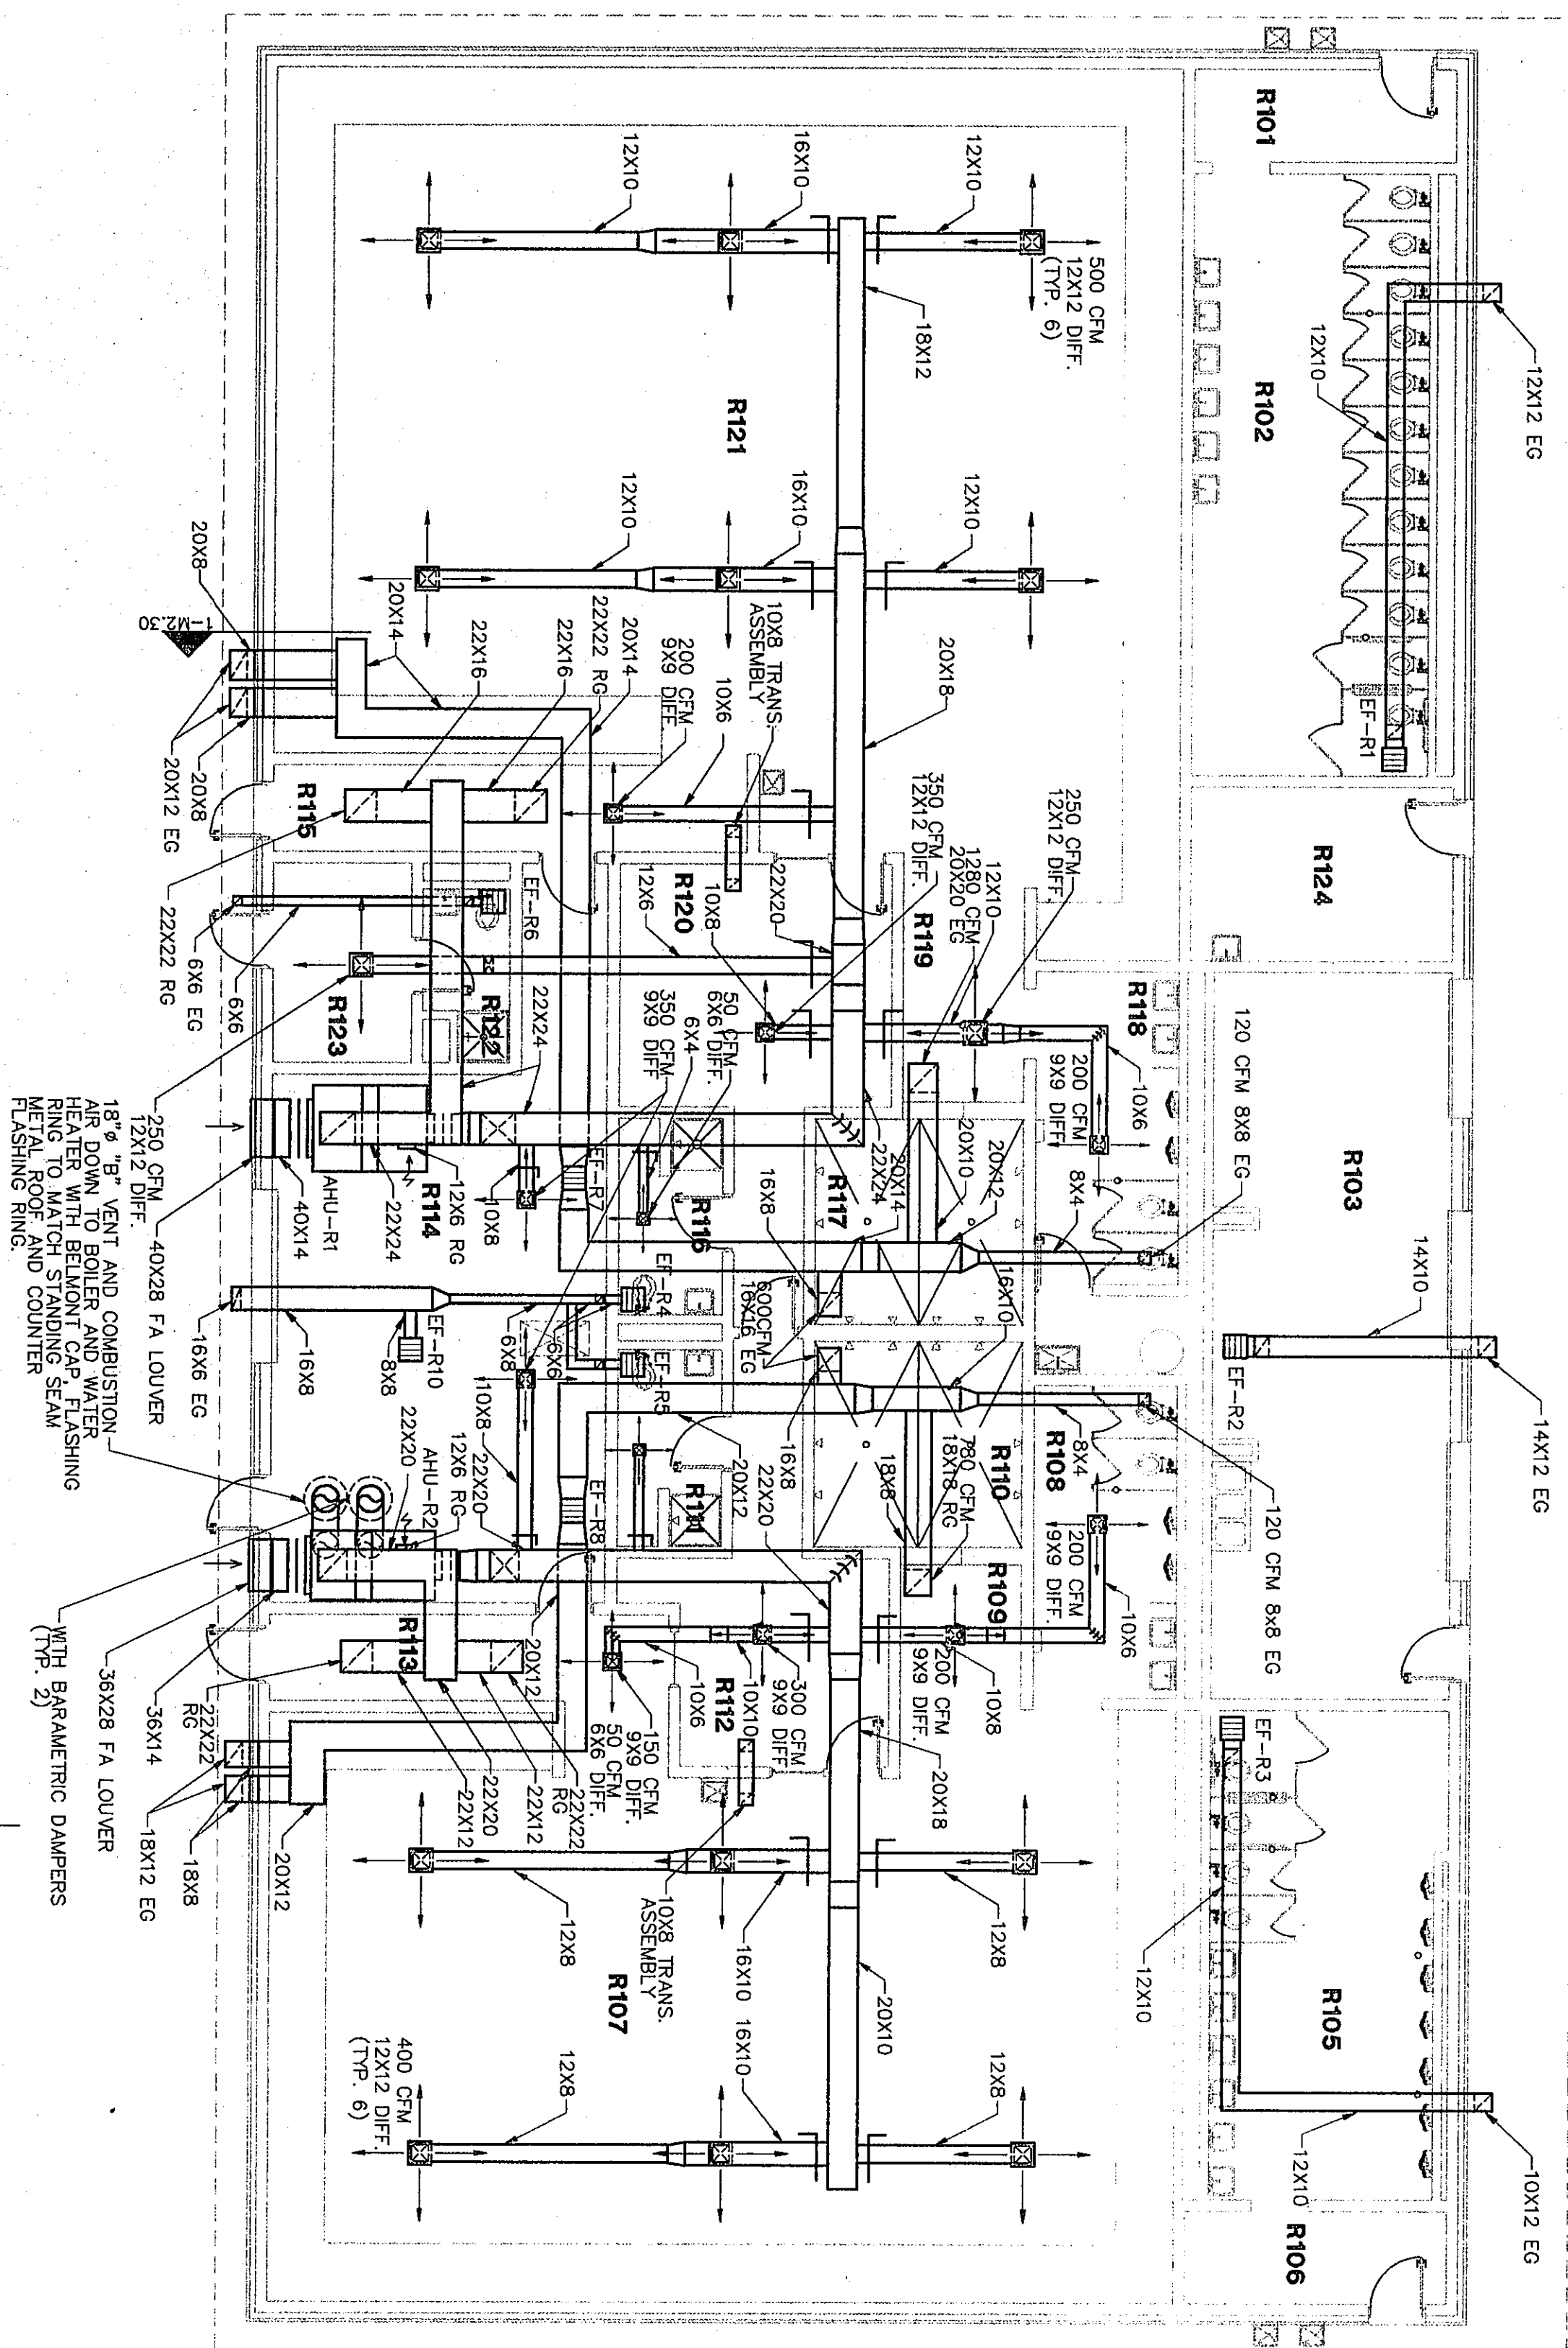
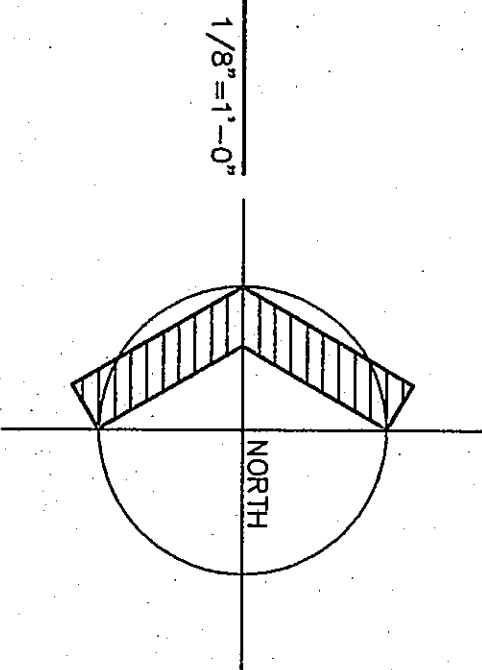


FLOOR PLAN UNIT "R"


(ALTERNATE REFER TO SPECIFICATION SECTION 01020)

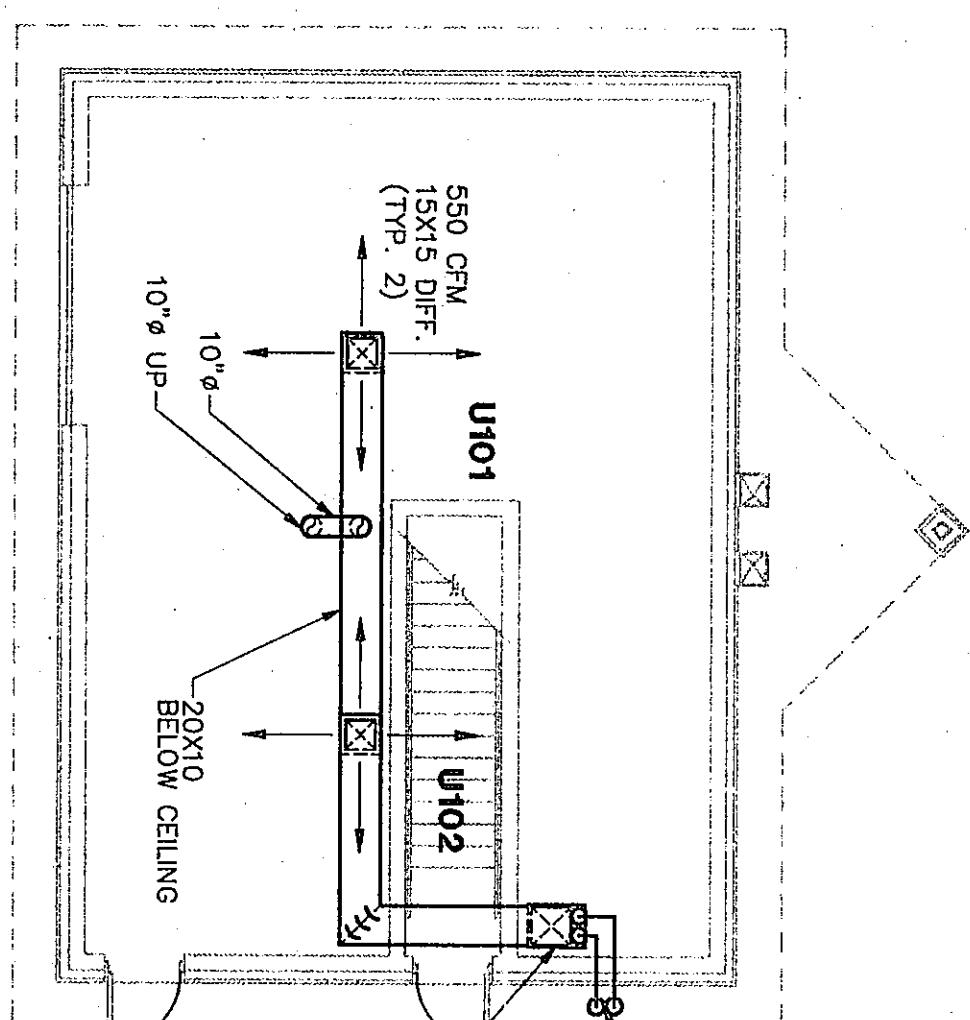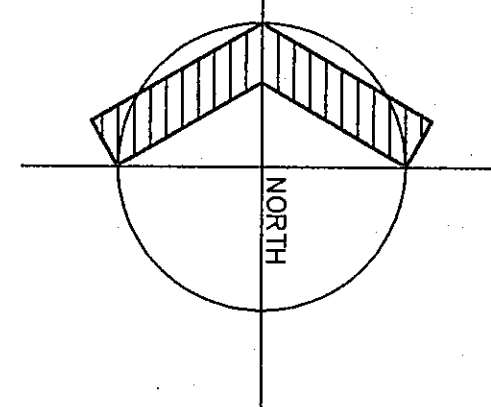

FLOOR PLAN UNIT "U"

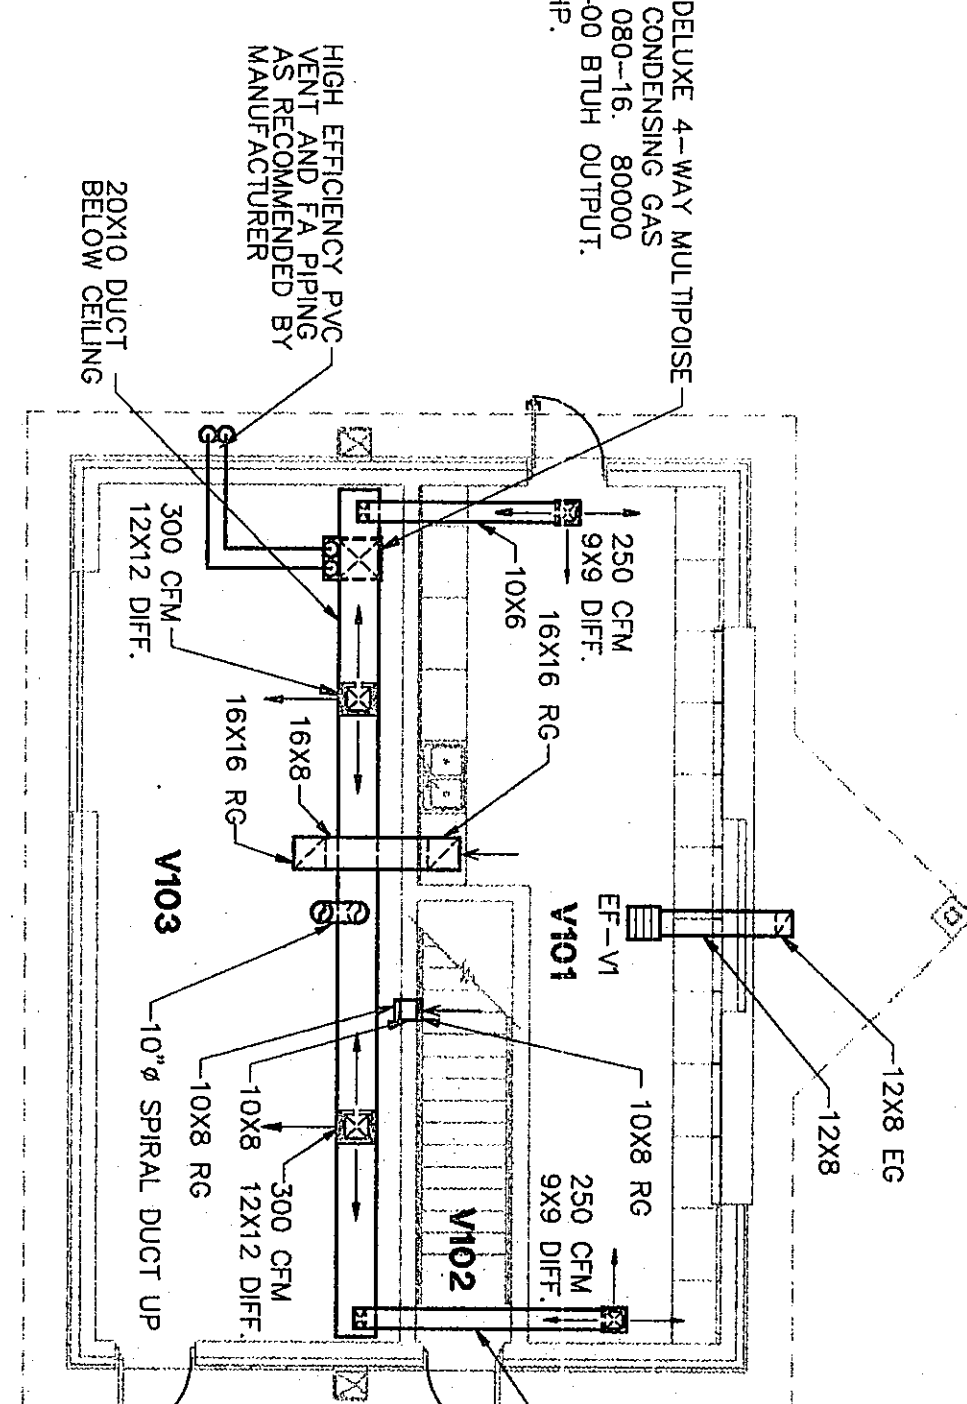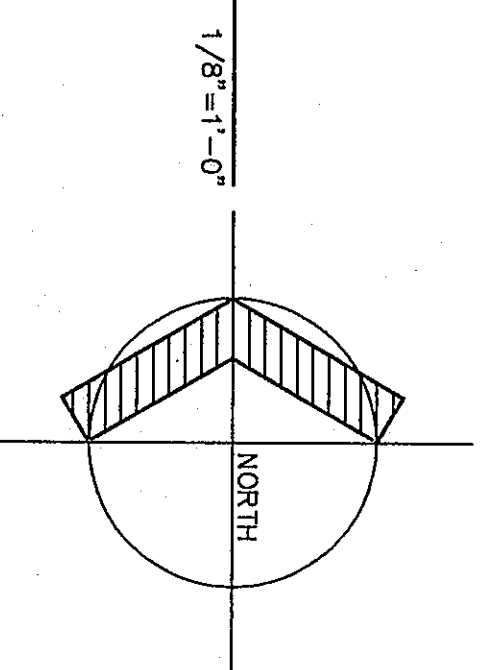

FLOOR PLAN UNIT "V"

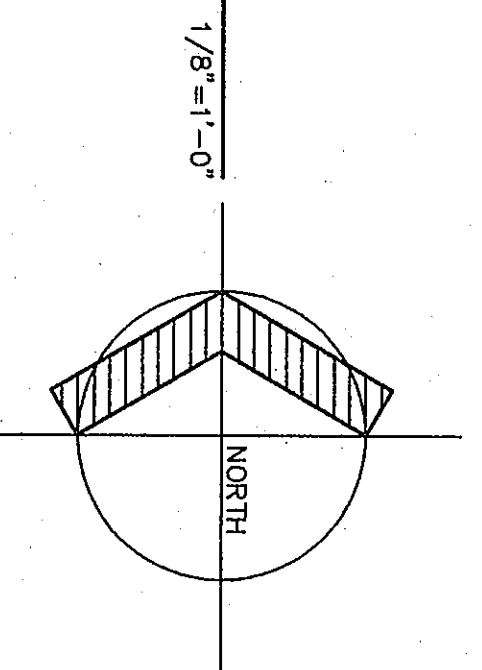

ROOM LEGEND "R"

ROOM NO.	ROOM NAME	AREA S.F.	CEILING HEIGHT
R01	VESTIBULE	80	9'-4"
R02	WOMEN'S TOILET	471	9'-4"
R03	CONCESSIONS	558	9'-4"
R04	WOMEN'S TOILET	571	9'-4"
R05	VESTIBULE	80	9'-4"
R06	LOCKER ROOM	1707	9'-4"
R07	LOCKER ROOM	142	9'-4"
R08	LOCKER ROOM	61	9'-4"
R09	LOCKER ROOM	142	9'-4"
R10	LOCKER ROOM	142	9'-4"
R11	LOCKER ROOM	142	9'-4"
R12	LOCKER ROOM	142	9'-4"
R13	LOCKER ROOM	142	9'-4"
R14	LOCKER ROOM	142	9'-4"
R15	LOCKER ROOM	142	9'-4"
R16	LOCKER ROOM	142	9'-4"
R17	LOCKER ROOM	142	9'-4"
R18	LOCKER ROOM	142	9'-4"
R19	LOCKER ROOM	142	9'-4"
R20	LOCKER ROOM	142	9'-4"
R21	LOCKER ROOM	142	9'-4"
R22	LOCKER ROOM	142	9'-4"
R23	LOCKER ROOM	142	9'-4"
R24	LOCKER ROOM	142	9'-4"
R25	LOCKER ROOM	142	9'-4"

ROOM LEGEND "T"


ROOM NO.	ROOM NAME	AREA S.F.	CEILING HEIGHT
T01	CONCESSIONS	334	8'-8"
T02	STAR	73	8'-8"
T03	STAR	209	8'-8"
T04	STAR	12	8'-8"
T05	STAR	24	8'-8"
T06	STAR	351	8'-8"

ROOM LEGEND "U"


ROOM NO.	ROOM NAME	AREA S.F.	CEILING HEIGHT
U01	STAR	826	8'-8"
U02	STAR	351	8'-8"

ROOM LEGEND "V"

ROOM NO.	ROOM NAME	AREA S.F.	CEILING HEIGHT
V01	CONCESSIONS	353	8'-8"
V02	STAR	452	8'-8"
V03	STAR	351	8'-8"

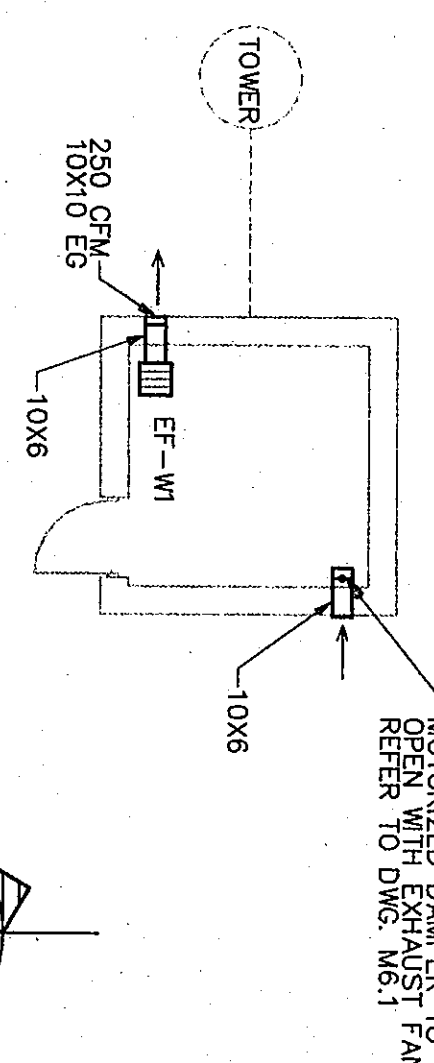

FLOOR PLAN UNIT "W"

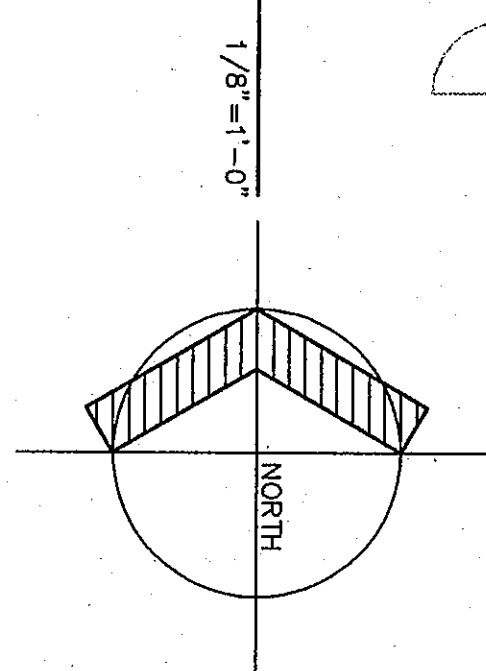

Fanning/Howe Associates, Inc.
Architects Engineers Consultants

THE NEW
CHESTERTON HIGH SCHOOL
FOR THE
DUNELAND SCHOOL CORPORATION
CHESTERTON, INDIANA

Copyright 1997 by Fanning/Howe Associates, Inc.

VENT. PLAN UNITS R,T,U,V

DRAWN BY: SCB COMM. NO.: 95067.00
CHECKED BY: CAM DATE: APRIL 21, 1997

REVISIONS NO. DATE

M2.30

CHESTERTON HIGH SCHOOL
5/28/97