



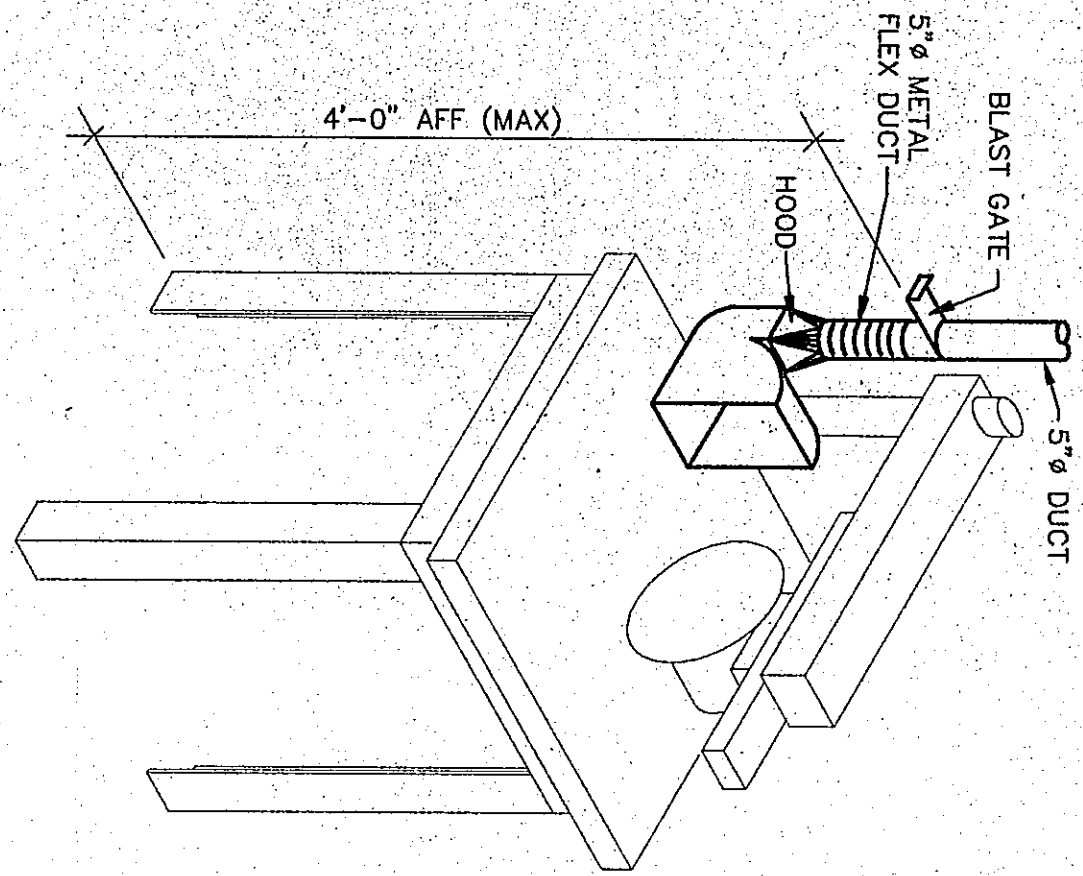


**RADIAL ARM SAW DUST COLLECTION**  
NOT TO SCALE

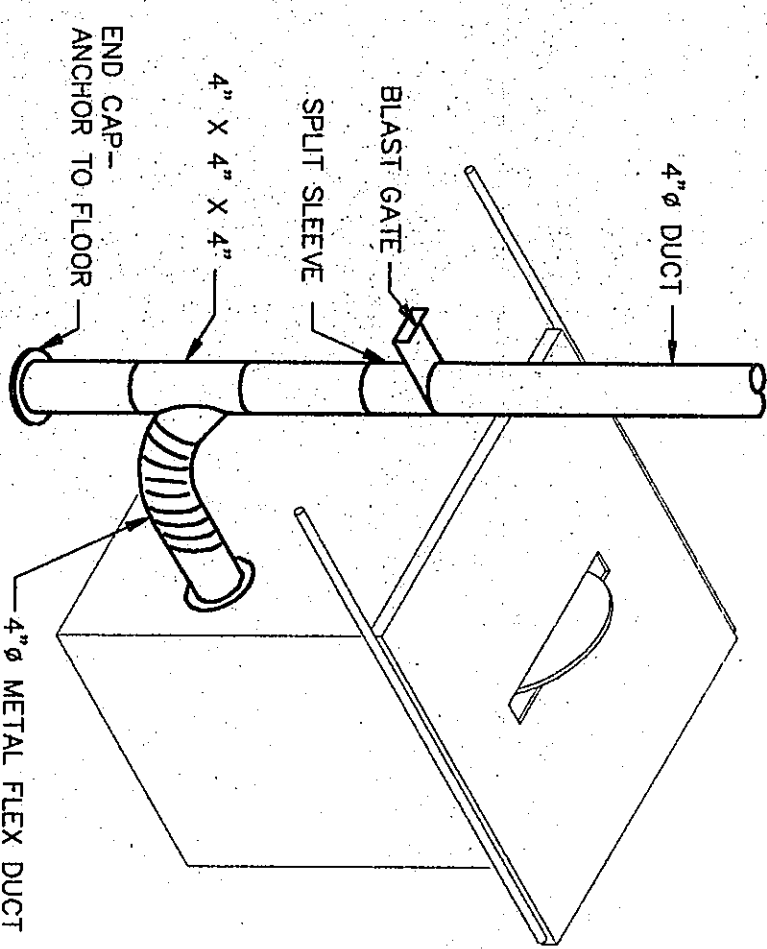


**NOTE:**  
CUT 4" OPENING IN CABINET BASE (LOCATE OPENING AS LOW AS POSSIBLE TO AVOID STRUCTURAL SEAMS)

**TABLE SAW DUST COLLECTION DETAIL**  
NOT TO SCALE

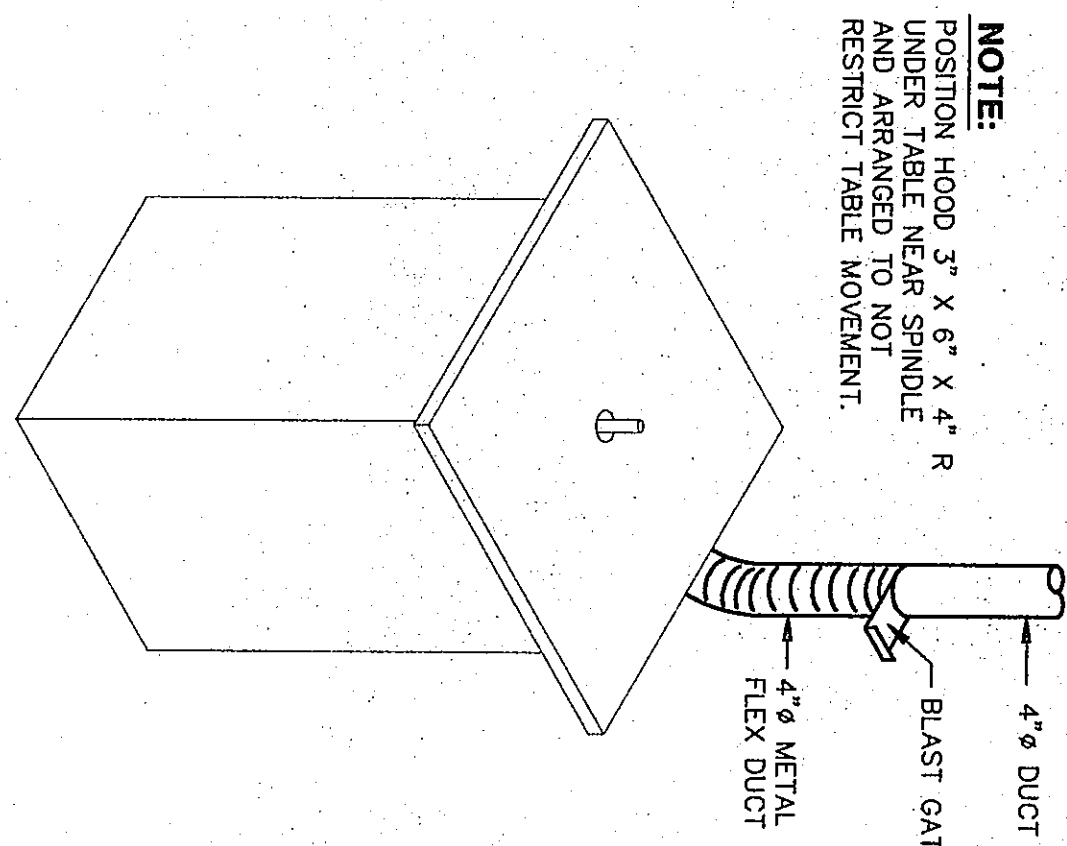


**NOTE:**  
POSITION HOOD 37" X 67" X 47" R UNDER TABLE NEAR SPINDLE AND ARRANGED TO NOT RESTRICT TABLE MOVEMENT.


**SPINDLE SANDER DUST COLLECTION**  
NOT TO SCALE

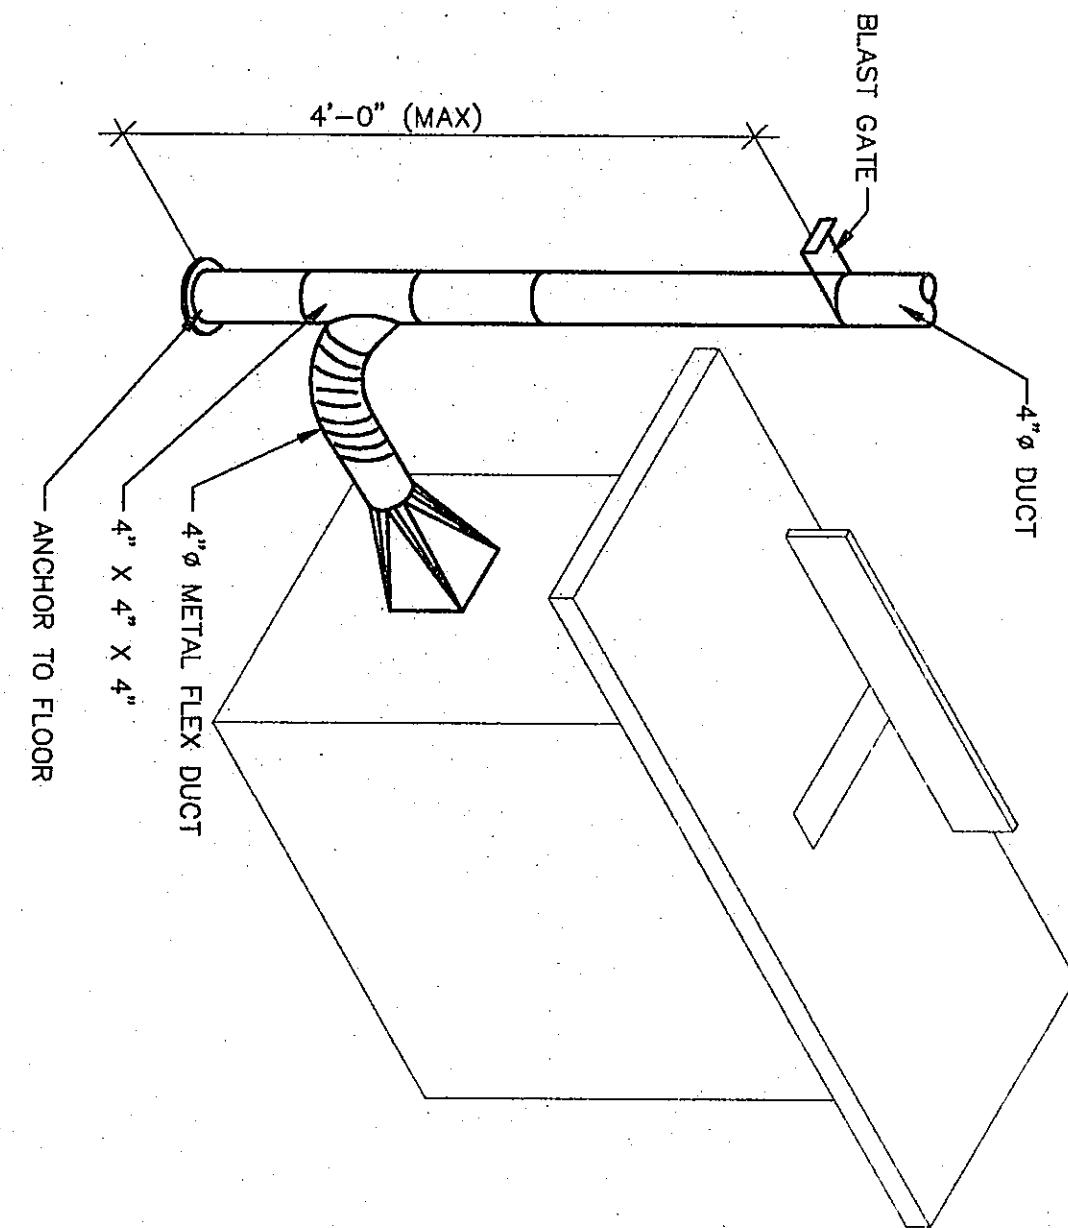


**JOINTER DUST COLLECTION DETAIL**  
NOT TO SCALE

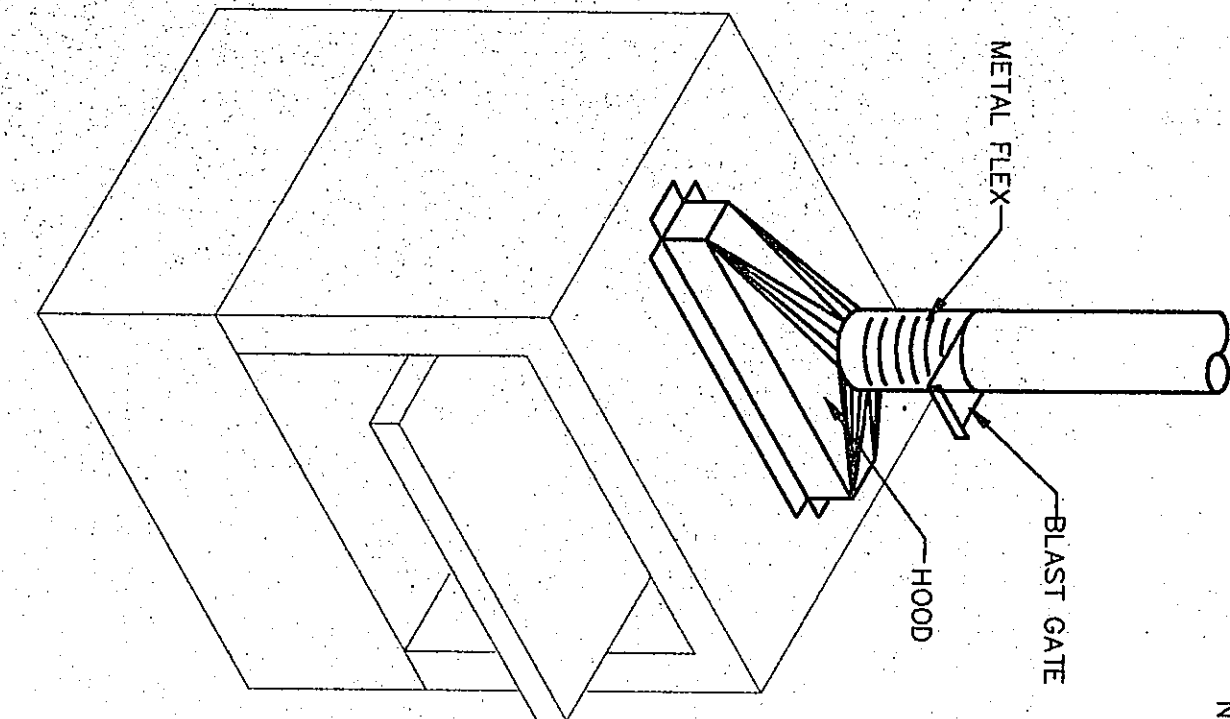


**PLANER DUST COLLECTION DETAIL**  
NOT TO SCALE

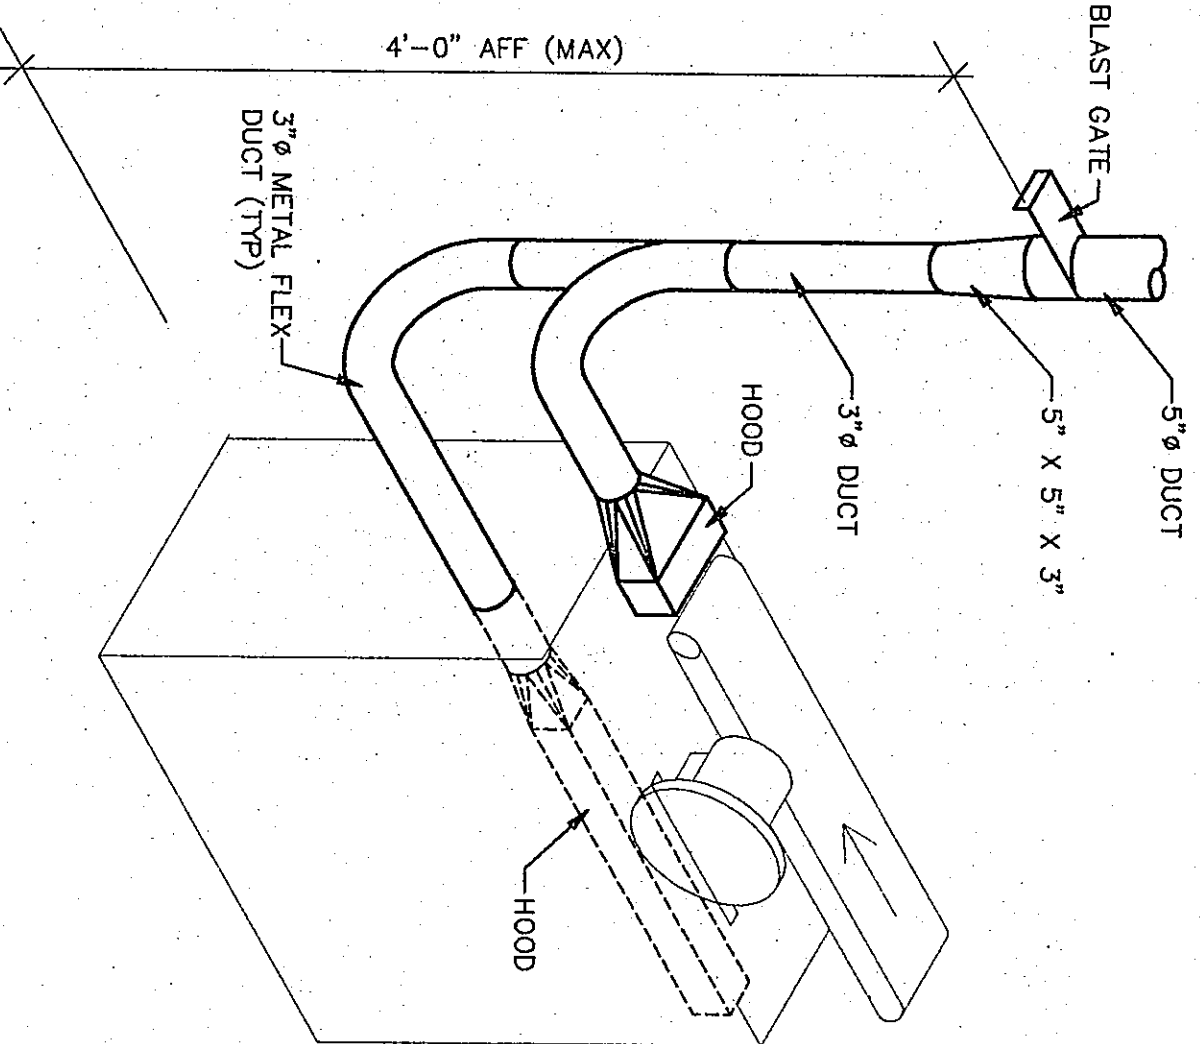


**BELT/DISK SANDER DUST COLLECTION**  
NOT TO SCALE

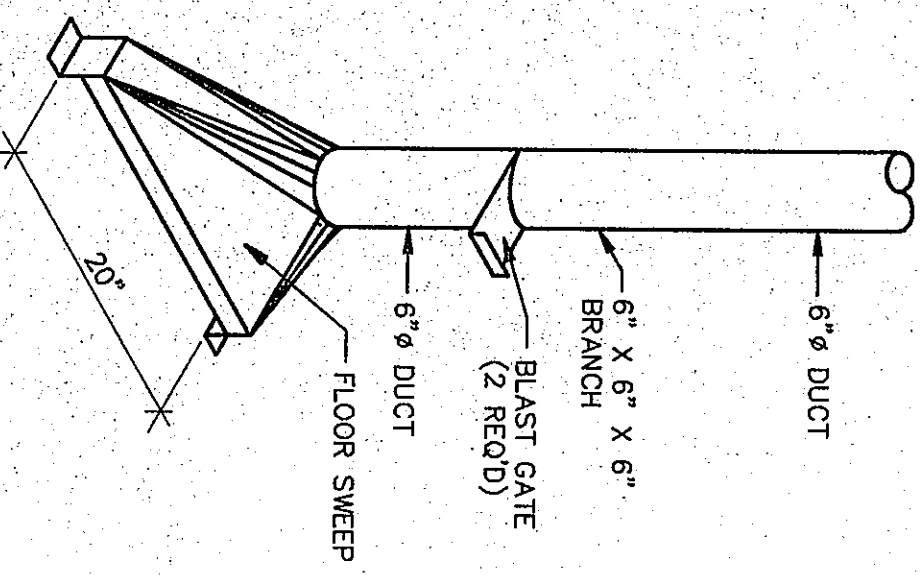


**FLOOR SWEEP AND DOWN-DRAFT TABLE**  
NOT TO SCALE

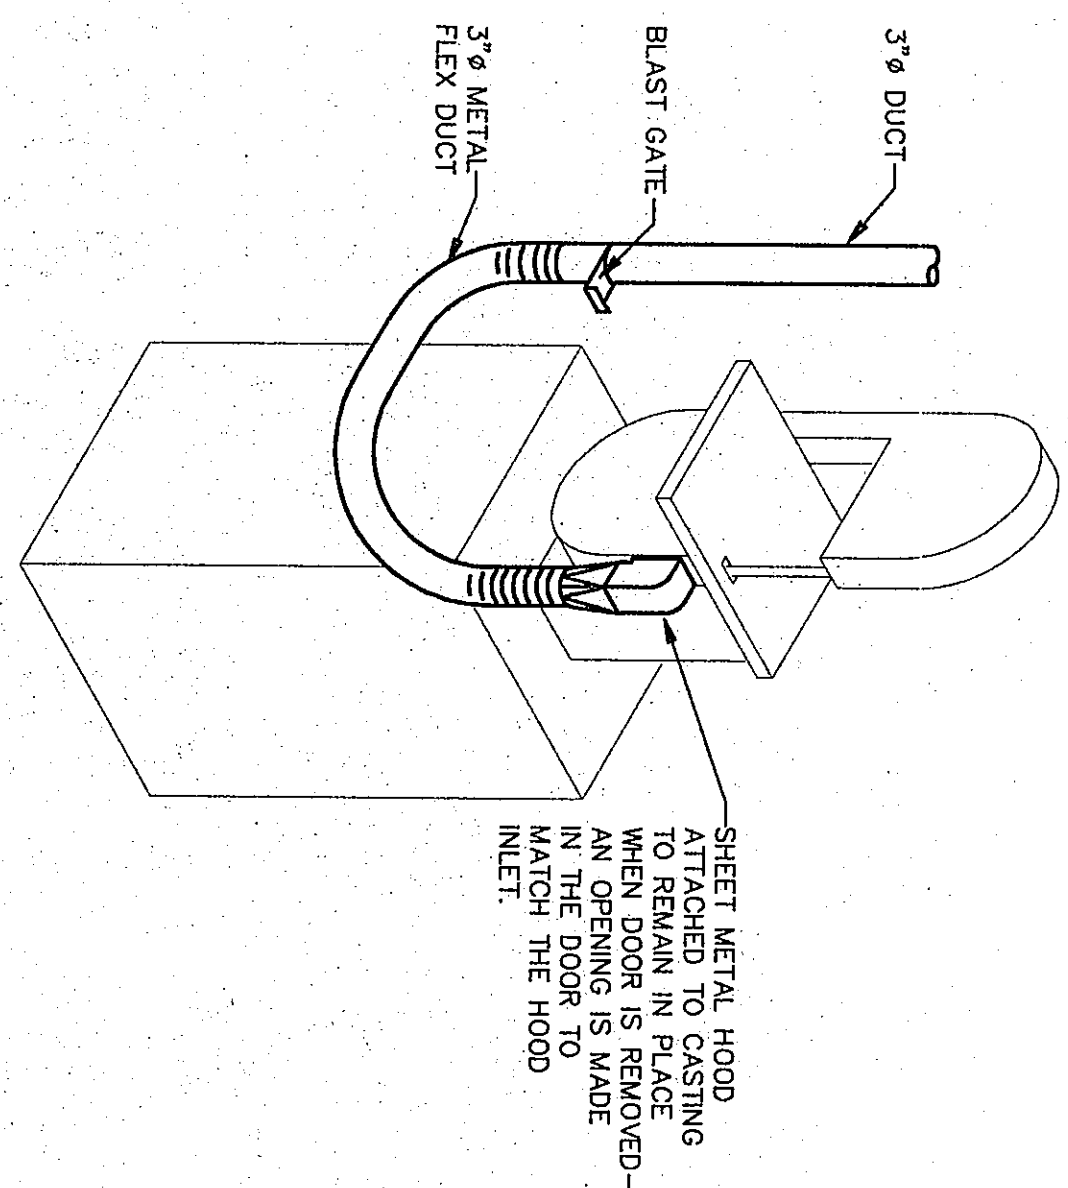

**BAND SAW DUST COLLECTION DETAIL**  
NOT TO SCALE

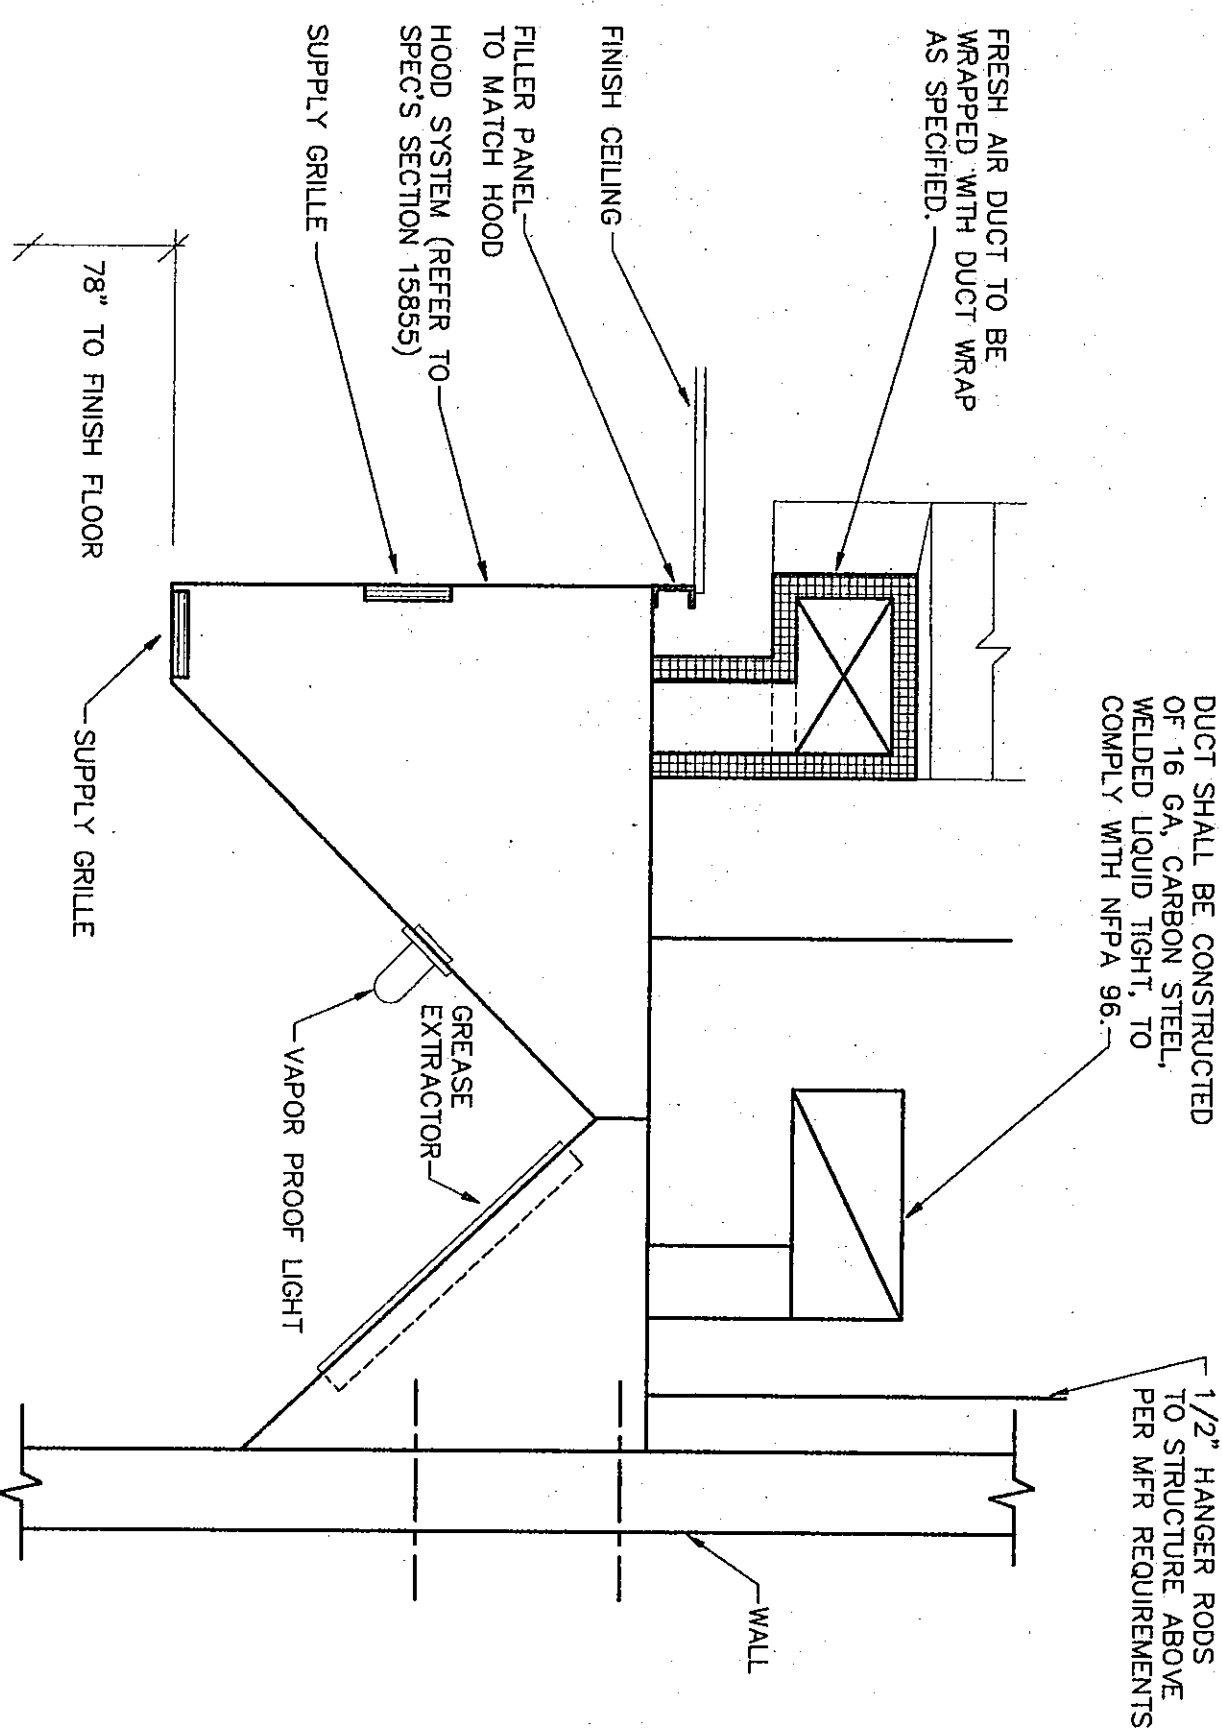


**KITCHEN HOOD DETAIL**  
NOT TO SCALE

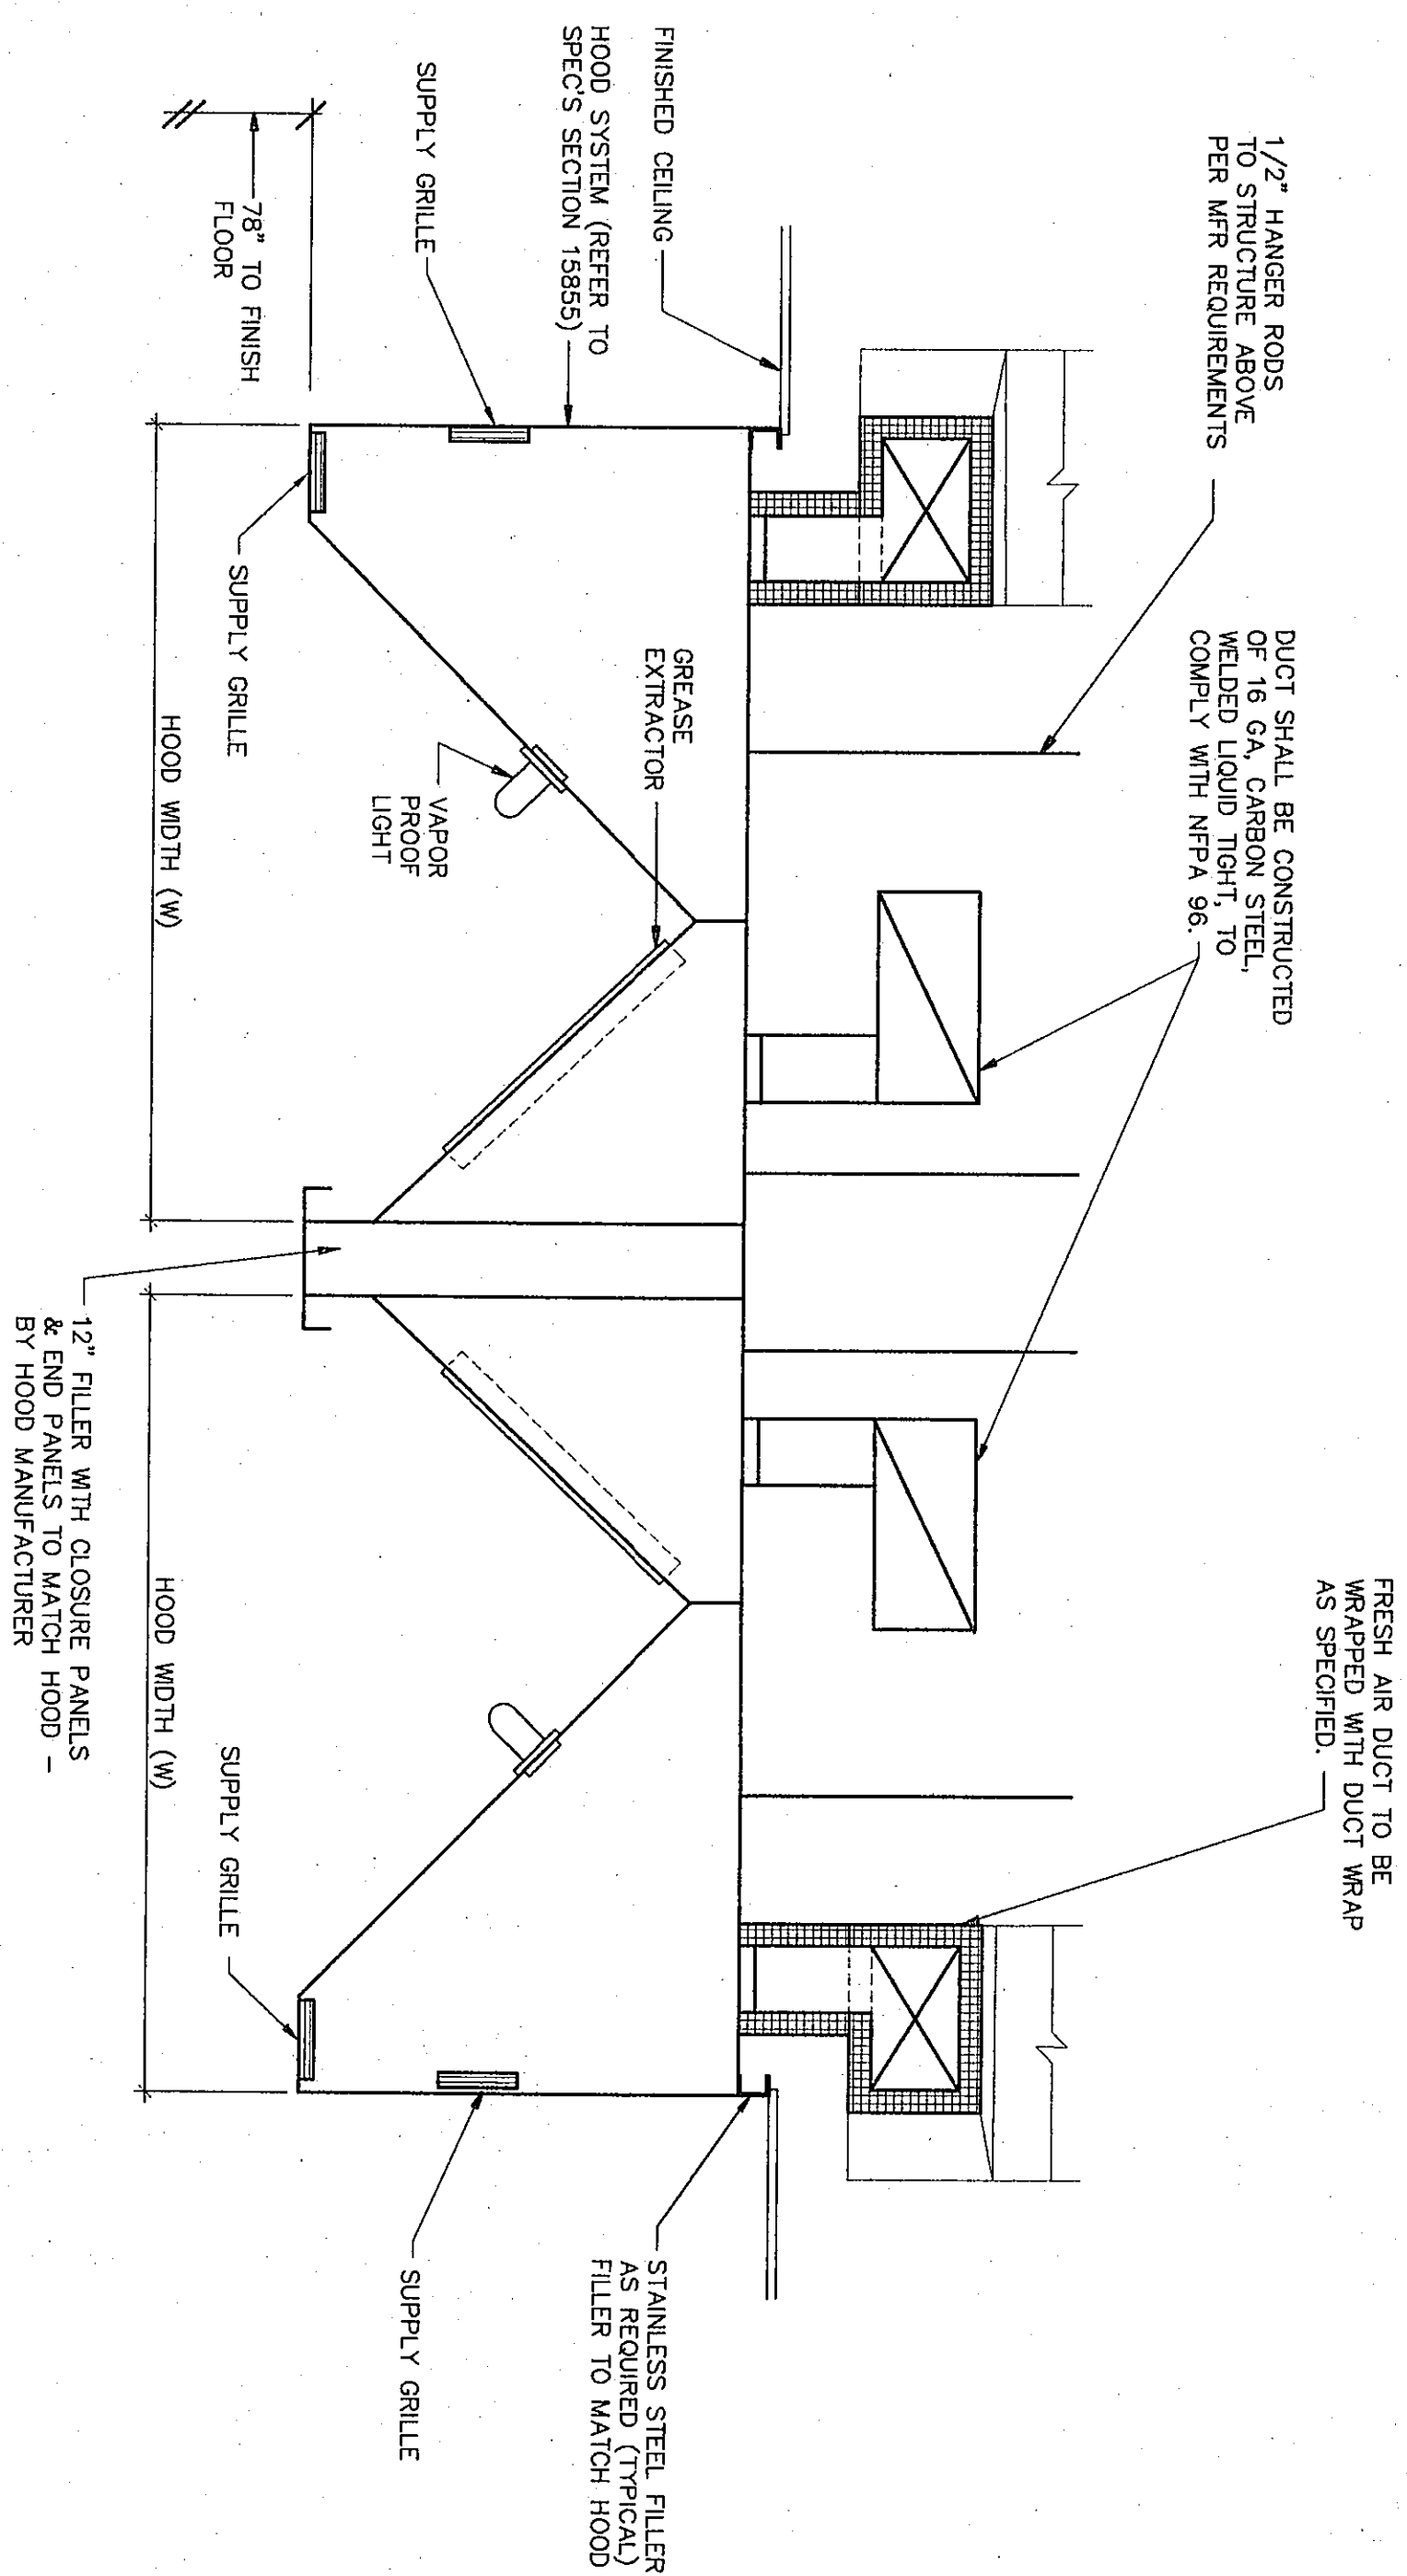

**ISLAND KITCHEN HOOD DETAIL**  
NOT TO SCALE

COPYRIGHT 1997 BY FANNING/HOWEY ASSOCIATES, INC.

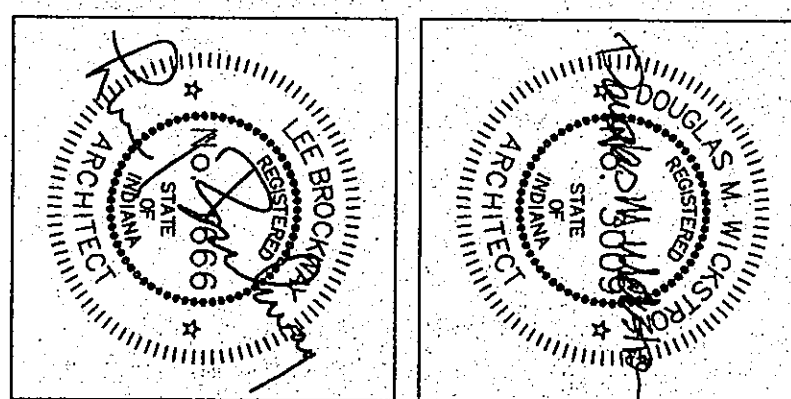

THE NEW  
**CHESTERTON HIGH SCHOOL**  
FOR THE  
DUNELAND SCHOOL CORPORATION  
CHESTERTON, INDIANA

**Fanning/Howey Associates, Inc.**  
Architects Engineers Consultants

| VENTILATION DETAILS |                      |
|---------------------|----------------------|
| DRAWN BY: JJD       | COMM. NO.: 95067.00  |
| CHECKED BY: CAM     | DATE: APRIL 21, 1997 |
| <b>M2.33</b>        | REVISIONS NO. DATE   |

CHESTERTON HIGH SCHOOL  
95067.00

97-M2-34