


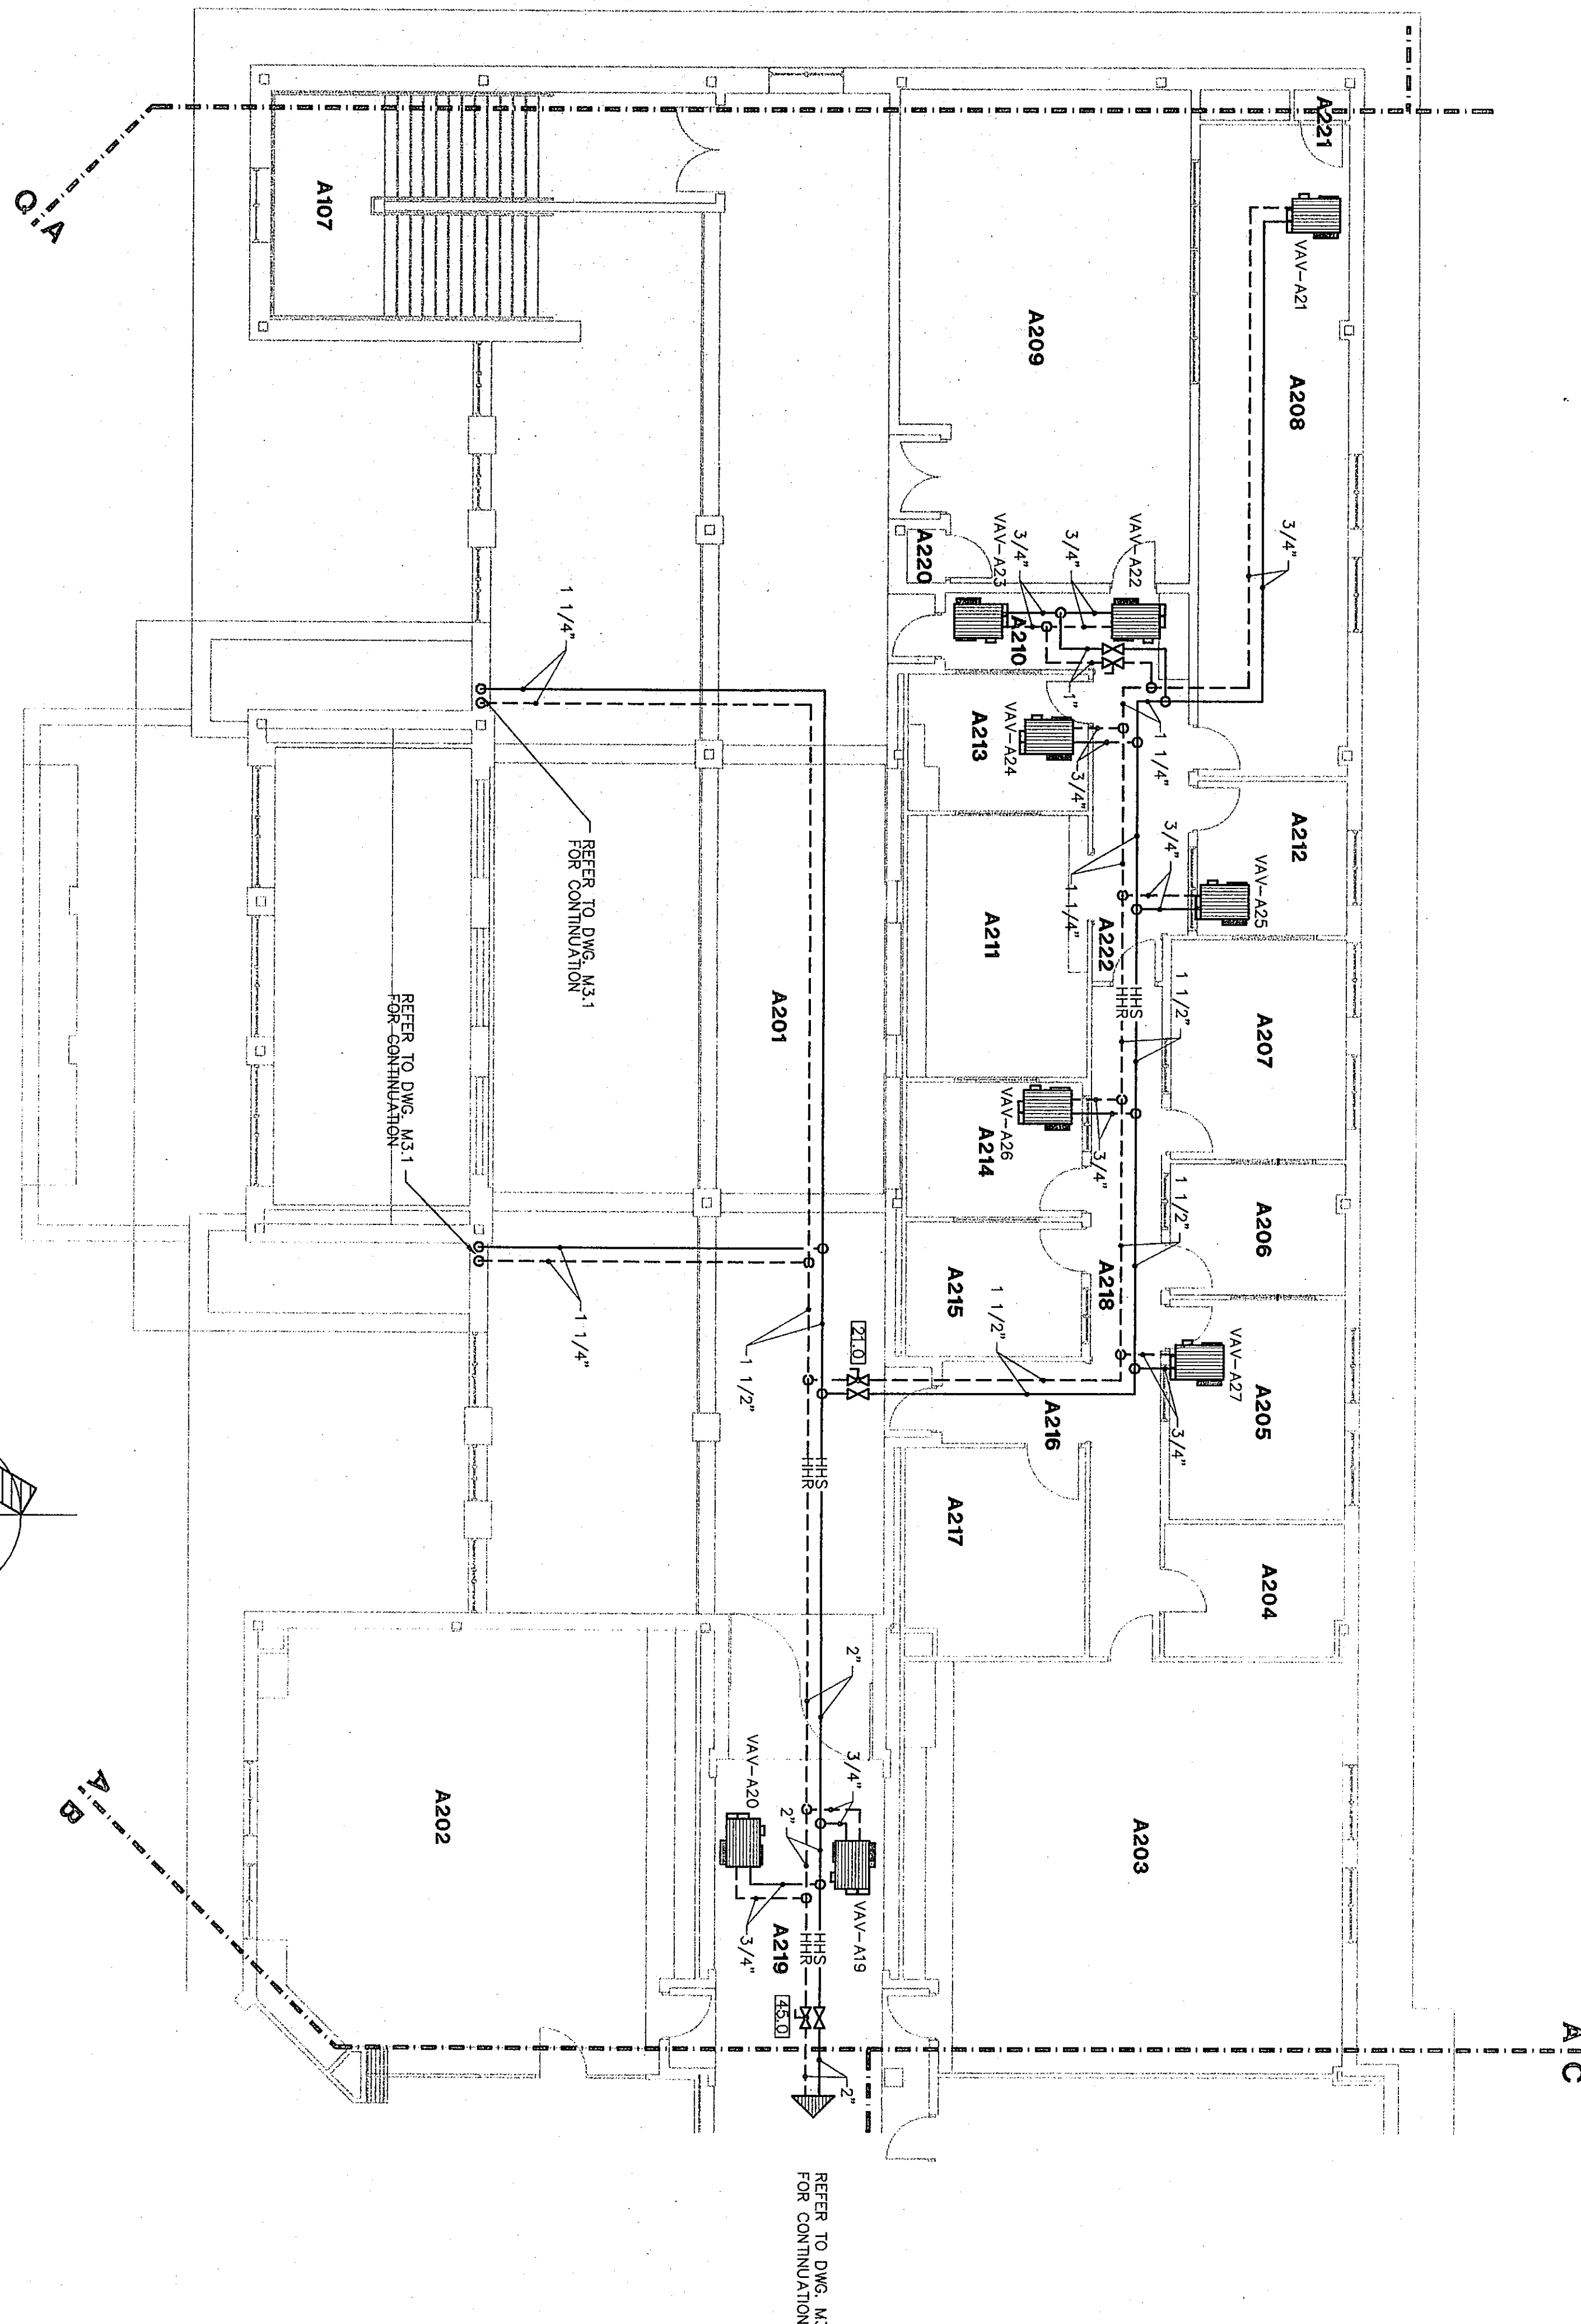

ROOM LEGEND "A2"				
ROOM NO.	ROOM NAME	AREA S.F.	CEILING HEIGHT	VARIABLES
A201	CORRIDOR	1552	9'-4"	VARIES
A202	CLASSROOM	802	9'-4"	VARIES
A203	CLASSROOM	802	9'-4"	VARIES
A204	LIBRARY	120	9'-4"	VARIES
A205	LIBRARY	120	9'-4"	VARIES
A206	LIBRARY	120	9'-4"	VARIES
A207	LIBRARY	120	9'-4"	VARIES
A208	LIBRARY	120	9'-4"	VARIES
A209	LIBRARY	120	9'-4"	VARIES
A210	LIBRARY	120	9'-4"	VARIES
A211	LIBRARY	120	9'-4"	VARIES
A212	LIBRARY	120	9'-4"	VARIES
A213	LIBRARY	120	9'-4"	VARIES
A214	LIBRARY	120	9'-4"	VARIES
A215	LIBRARY	120	9'-4"	VARIES
A216	LIBRARY	120	9'-4"	VARIES
A217	LIBRARY	120	9'-4"	VARIES
A218	LIBRARY	120	9'-4"	VARIES
A219	LIBRARY	120	9'-4"	VARIES
A220	LIBRARY	120	9'-4"	VARIES
A221	LIBRARY	120	9'-4"	VARIES
A222	LIBRARY	120	9'-4"	VARIES

HEATING PLAN UNIT "A2"

DRAWN BY: SCB


COMM. NO.: 95067.00

CHECKED BY: CAM

DATE: APRIL 21, 1997

M3.2


REVISIONS NO. DATE

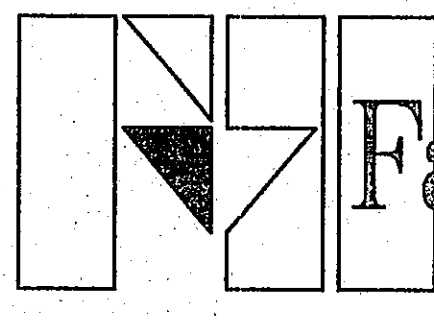

Fanning/Howey

Associates, Inc.

Architects Engineers Consultants

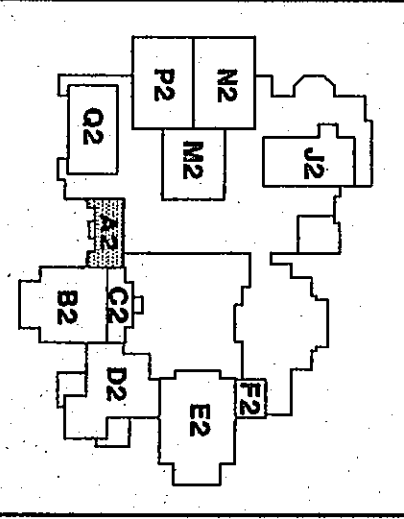

THE NEW
CHESTERTON HIGH SCHOOL
FOR THE
DUNELAND SCHOOL CORPORATION
CHESTERTON, INDIANA

COPYRIGHT 1997 BY FANNING/HOWEY ASSOCIATES, INC.

