



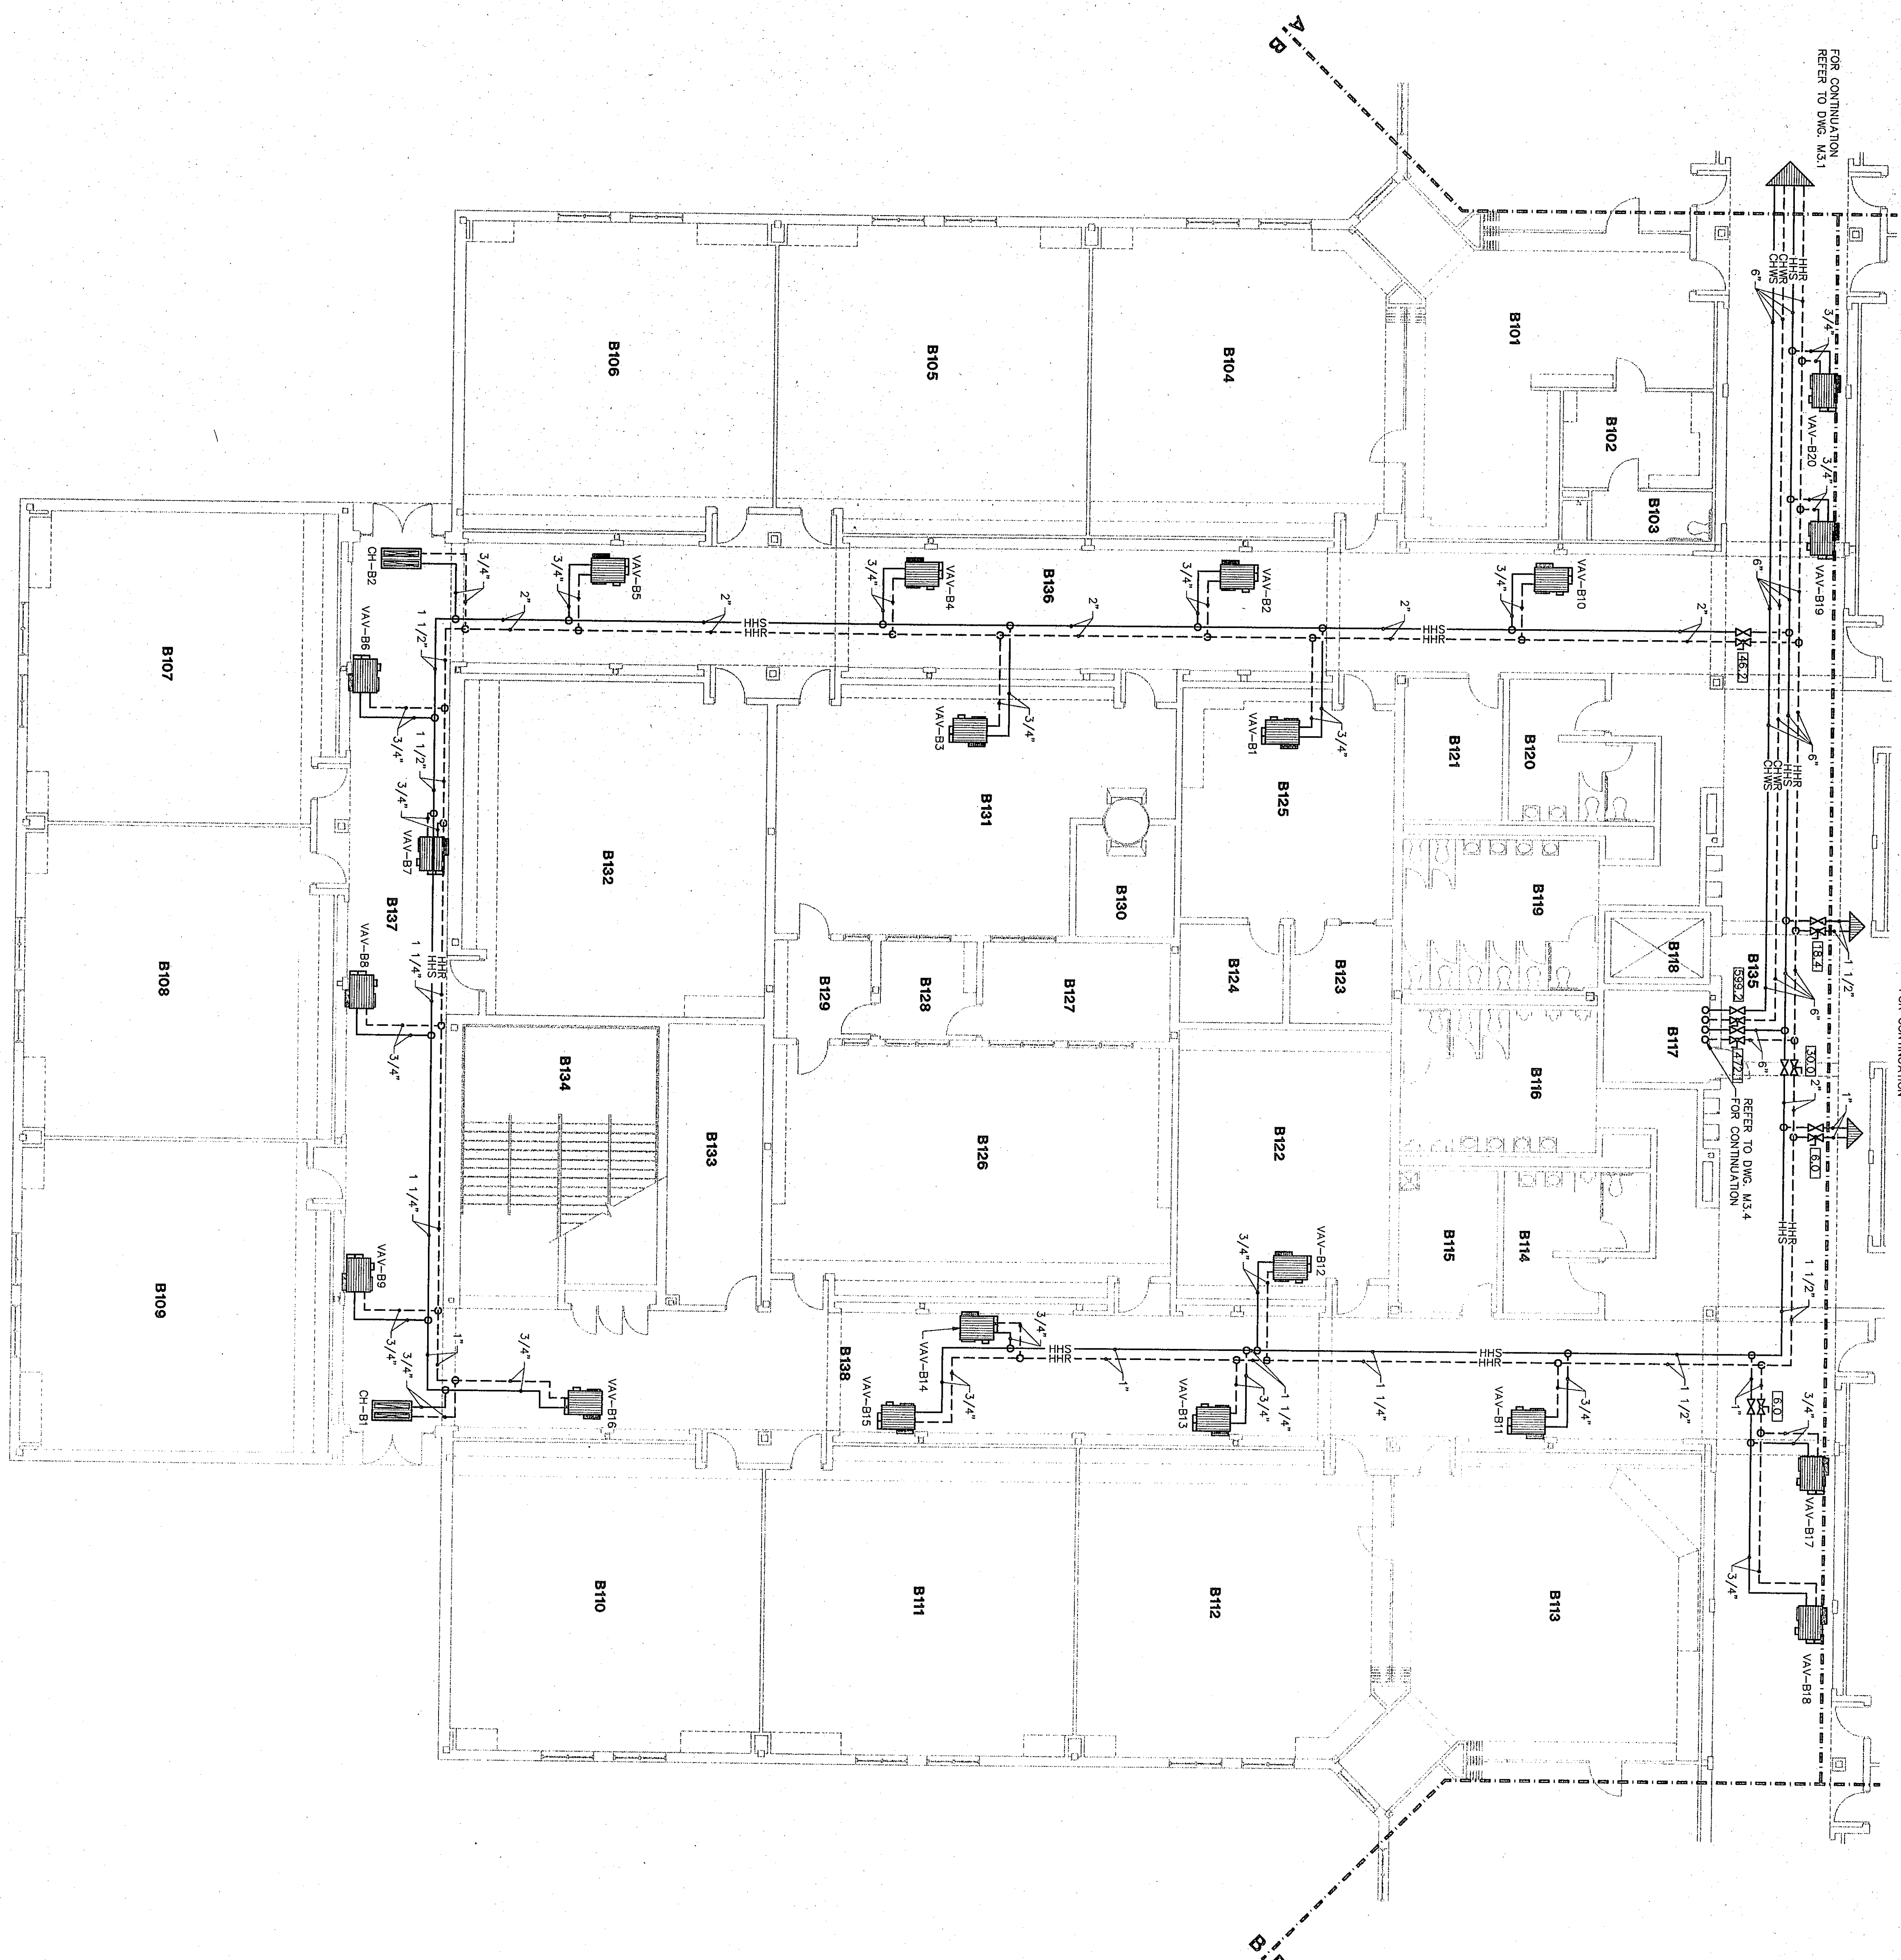

FLOOR PLAN UNIT "B"

1/8"=1'-0"


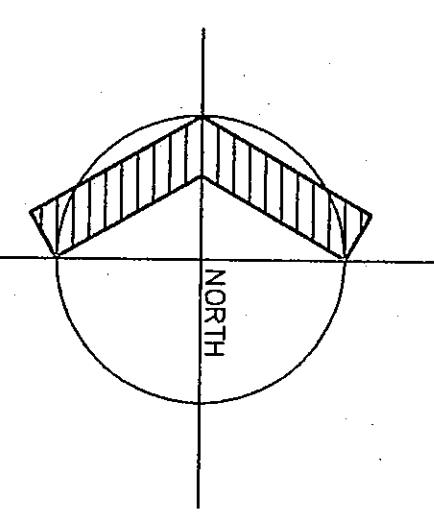


ROOM LEGEND "B"

ROOM NO.	ROOM NAME	AREA S.F.	CEILING HEIGHT	SP. ED.
B101	LIFE SKILLS	733	9'-4"	SP. ED.
B102	HEALTH TOLLET	749	9'-4"	SP. ED.
B103	CLASSROOM	959	9'-4"	SP. ED.
B104	CLASSROOM	972	9'-4"	SP. ED.
B105	CLASSROOM	967	9'-4"	SP. ED.
B106	CLASSROOM	972	9'-4"	SP. ED.
B107	CLASSROOM	967	9'-4"	SP. ED.
B108	CLASSROOM	972	9'-4"	SP. ED.
B109	CLASSROOM	967	9'-4"	SP. ED.
B110	CLASSROOM	972	9'-4"	SP. ED.
B111	CLASSROOM	967	9'-4"	SP. ED.
B112	CLASSROOM	972	9'-4"	SP. ED.
B113	CLASSROOM	967	9'-4"	SP. ED.
B114	CLASSROOM	972	9'-4"	SP. ED.
B115	CLASSROOM	967	9'-4"	SP. ED.
B116	CLASSROOM	972	9'-4"	SP. ED.
B117	CLASSROOM	967	9'-4"	SP. ED.
B118	CLASSROOM	972	9'-4"	SP. ED.
B119	CLASSROOM	967	9'-4"	SP. ED.
B120	CLASSROOM	972	9'-4"	SP. ED.
B121	CLASSROOM	967	9'-4"	SP. ED.
B122	CLASSROOM	972	9'-4"	SP. ED.
B123	CLASSROOM	967	9'-4"	SP. ED.
B124	CLASSROOM	972	9'-4"	SP. ED.
B125	CLASSROOM	967	9'-4"	SP. ED.
B126	CLASSROOM	972	9'-4"	SP. ED.
B127	CLASSROOM	967	9'-4"	SP. ED.
B128	CLASSROOM	972	9'-4"	SP. ED.
B129	CLASSROOM	967	9'-4"	SP. ED.
B130	CLASSROOM	972	9'-4"	SP. ED.
B131	CLASSROOM	967	9'-4"	SP. ED.
B132	CLASSROOM	972	9'-4"	SP. ED.
B133	CLASSROOM	967	9'-4"	SP. ED.
B134	CLASSROOM	972	9'-4"	SP. ED.
B135	CLASSROOM	967	9'-4"	SP. ED.
B136	CLASSROOM	972	9'-4"	SP. ED.
B137	CLASSROOM	967	9'-4"	SP. ED.
B138	CLASSROOM	972	9'-4"	SP. ED.

THE NEW
CHESTERTON HIGH SCHOOL
FOR THE
DUNELAND SCHOOL CORPORATION
CHESTERTON, INDIANA

Fanning/Howey Associates, Inc.
Architects Engineers Consultants

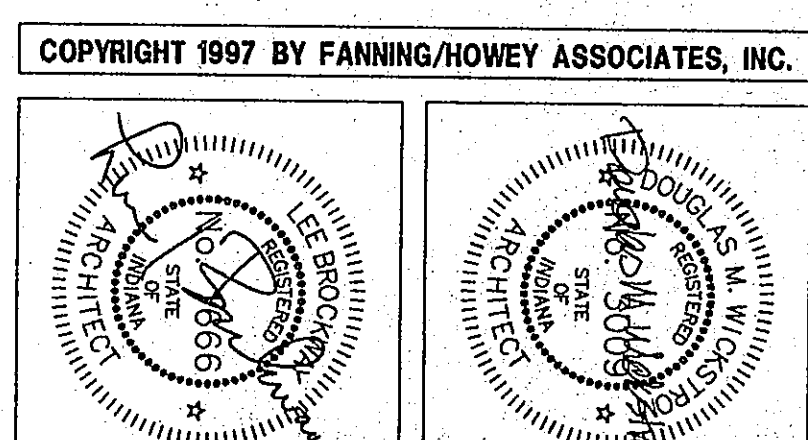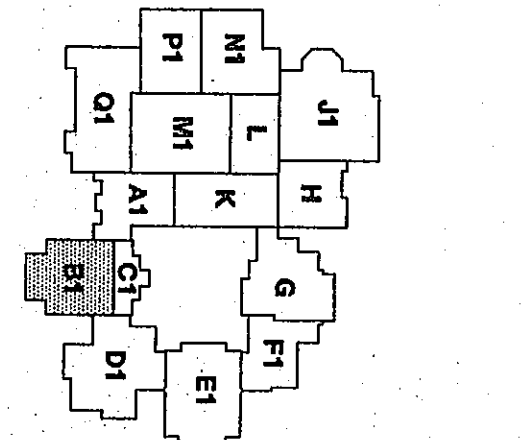

HEATING PLAN UNIT "B"

DRAWN BY: SCB COMM. NO.: 95067.00
CHECKED BY: CAM DATE: APRIL 21, 1997

M3.3

REVISIONS NO. DATE

95067.00