



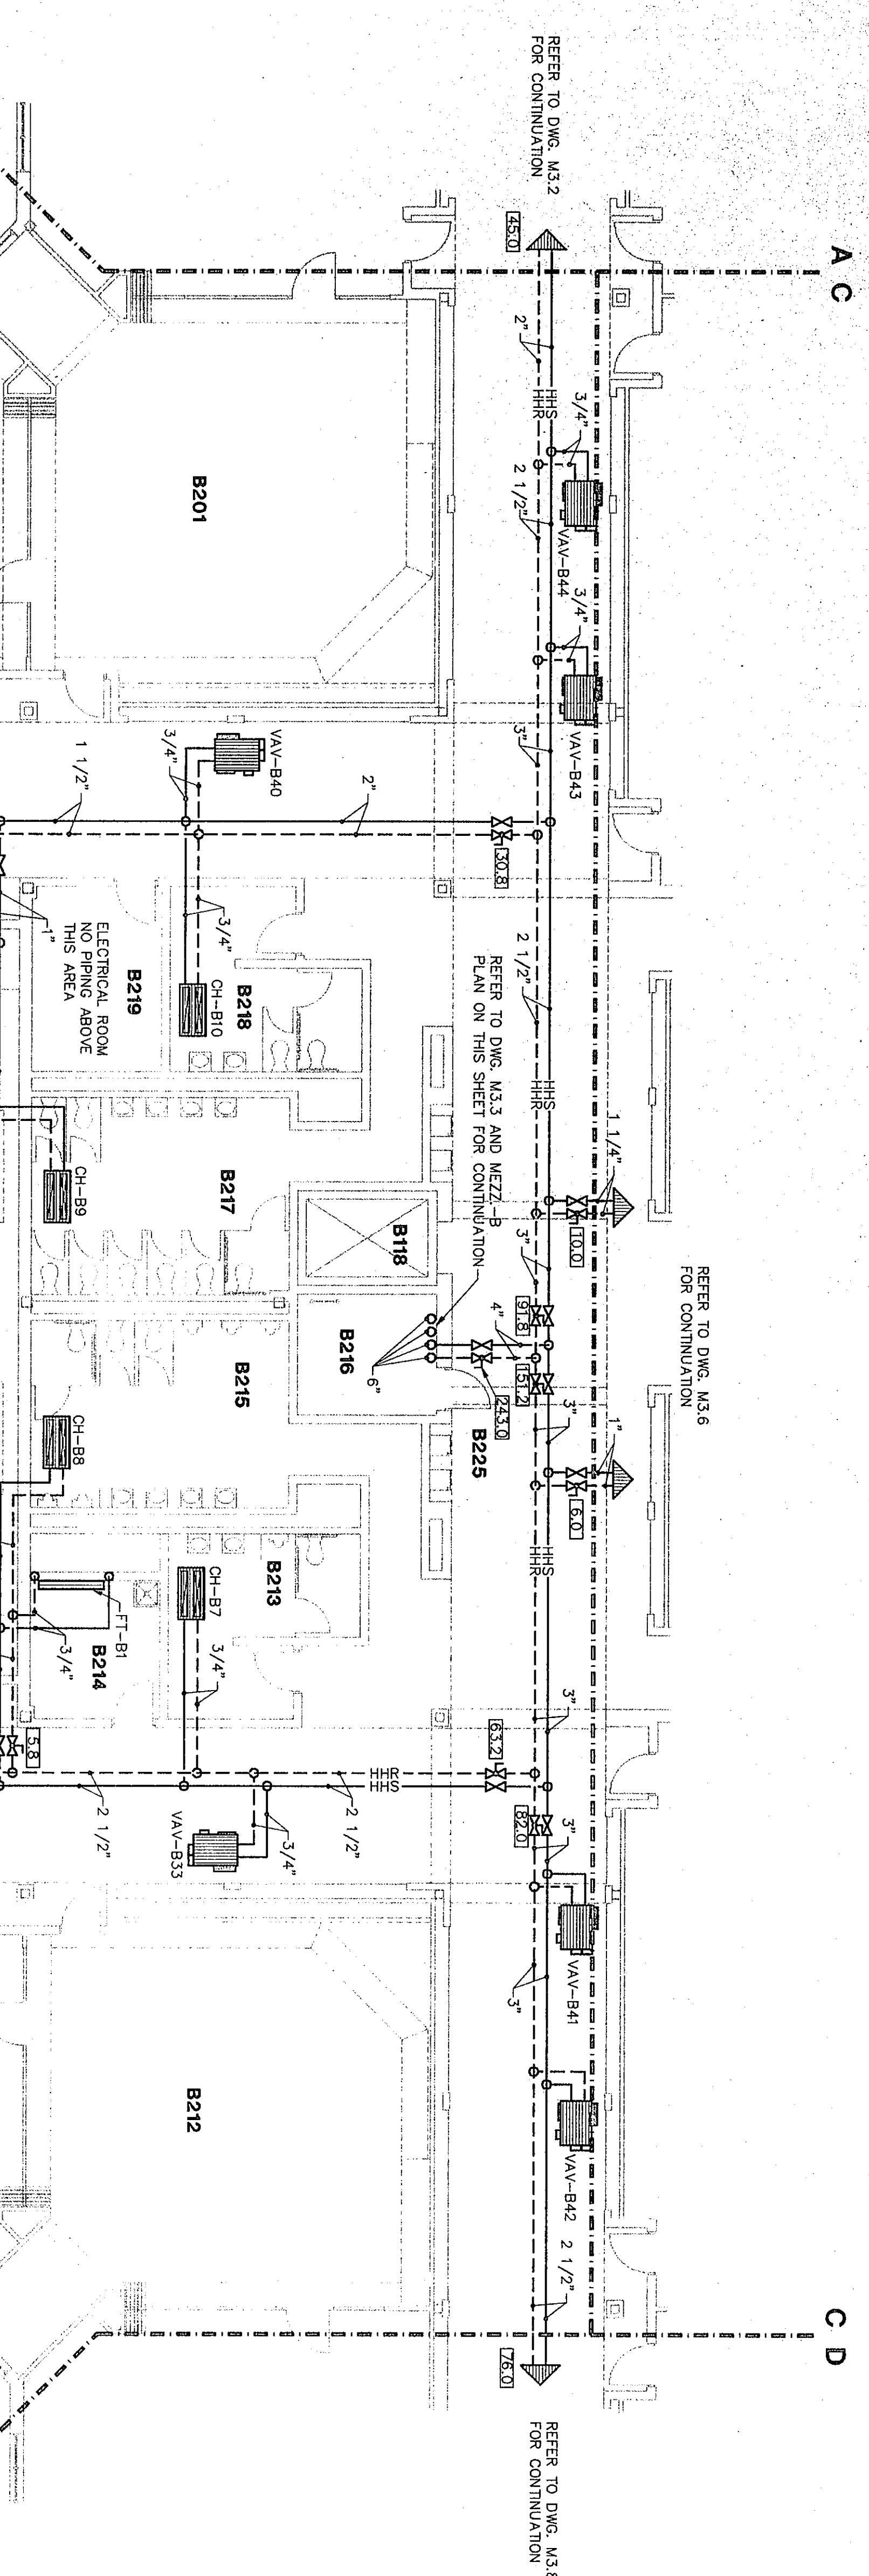

ROOM LEGEND "B2"

ROOM NO.	ROOM NAME	CEILING HEIGHT
B201	CLASSROOM	11'-8"
B202	CLASSROOM	11'-8"
B203	CLASSROOM	11'-8"
B204	CLASSROOM	11'-8"
B205	CLASSROOM	11'-8"
B206	CLASSROOM	11'-8"
B207	CLASSROOM	11'-8"
B208	CLASSROOM	11'-8"
B209	CLASSROOM	11'-8"
B210	CLASSROOM	11'-8"
B211	CLASSROOM	11'-8"
B212	CLASSROOM	11'-8"
B213	CLASSROOM	11'-8"
B214	CLASSROOM	11'-8"
B215	CLASSROOM	11'-8"
B216	CLASSROOM	11'-8"
B217	CLASSROOM	11'-8"
B218	CLASSROOM	11'-8"
B219	CLASSROOM	11'-8"
B220	CLASSROOM	11'-8"
B221	CLASSROOM	11'-8"
B222	CLASSROOM	11'-8"
B223	CLASSROOM	11'-8"
B224	CLASSROOM	11'-8"
B225	CLASSROOM	11'-8"
B226	CLASSROOM	11'-8"
B227	CLASSROOM	11'-8"
B228	CLASSROOM	11'-8"
B229	CLASSROOM	11'-8"

MARK	HEATING	PIPE SIZE	COOLING	PIPE SIZE
AHU-B1	73.2	2 1/2"	208.0	4"
AHU-B2	73.2	2 1/2"	208.0	4"
AHU-B3	67.6	2 1/2"	192.9	4"
AHU-B4	46.1	2"	128.8	4"

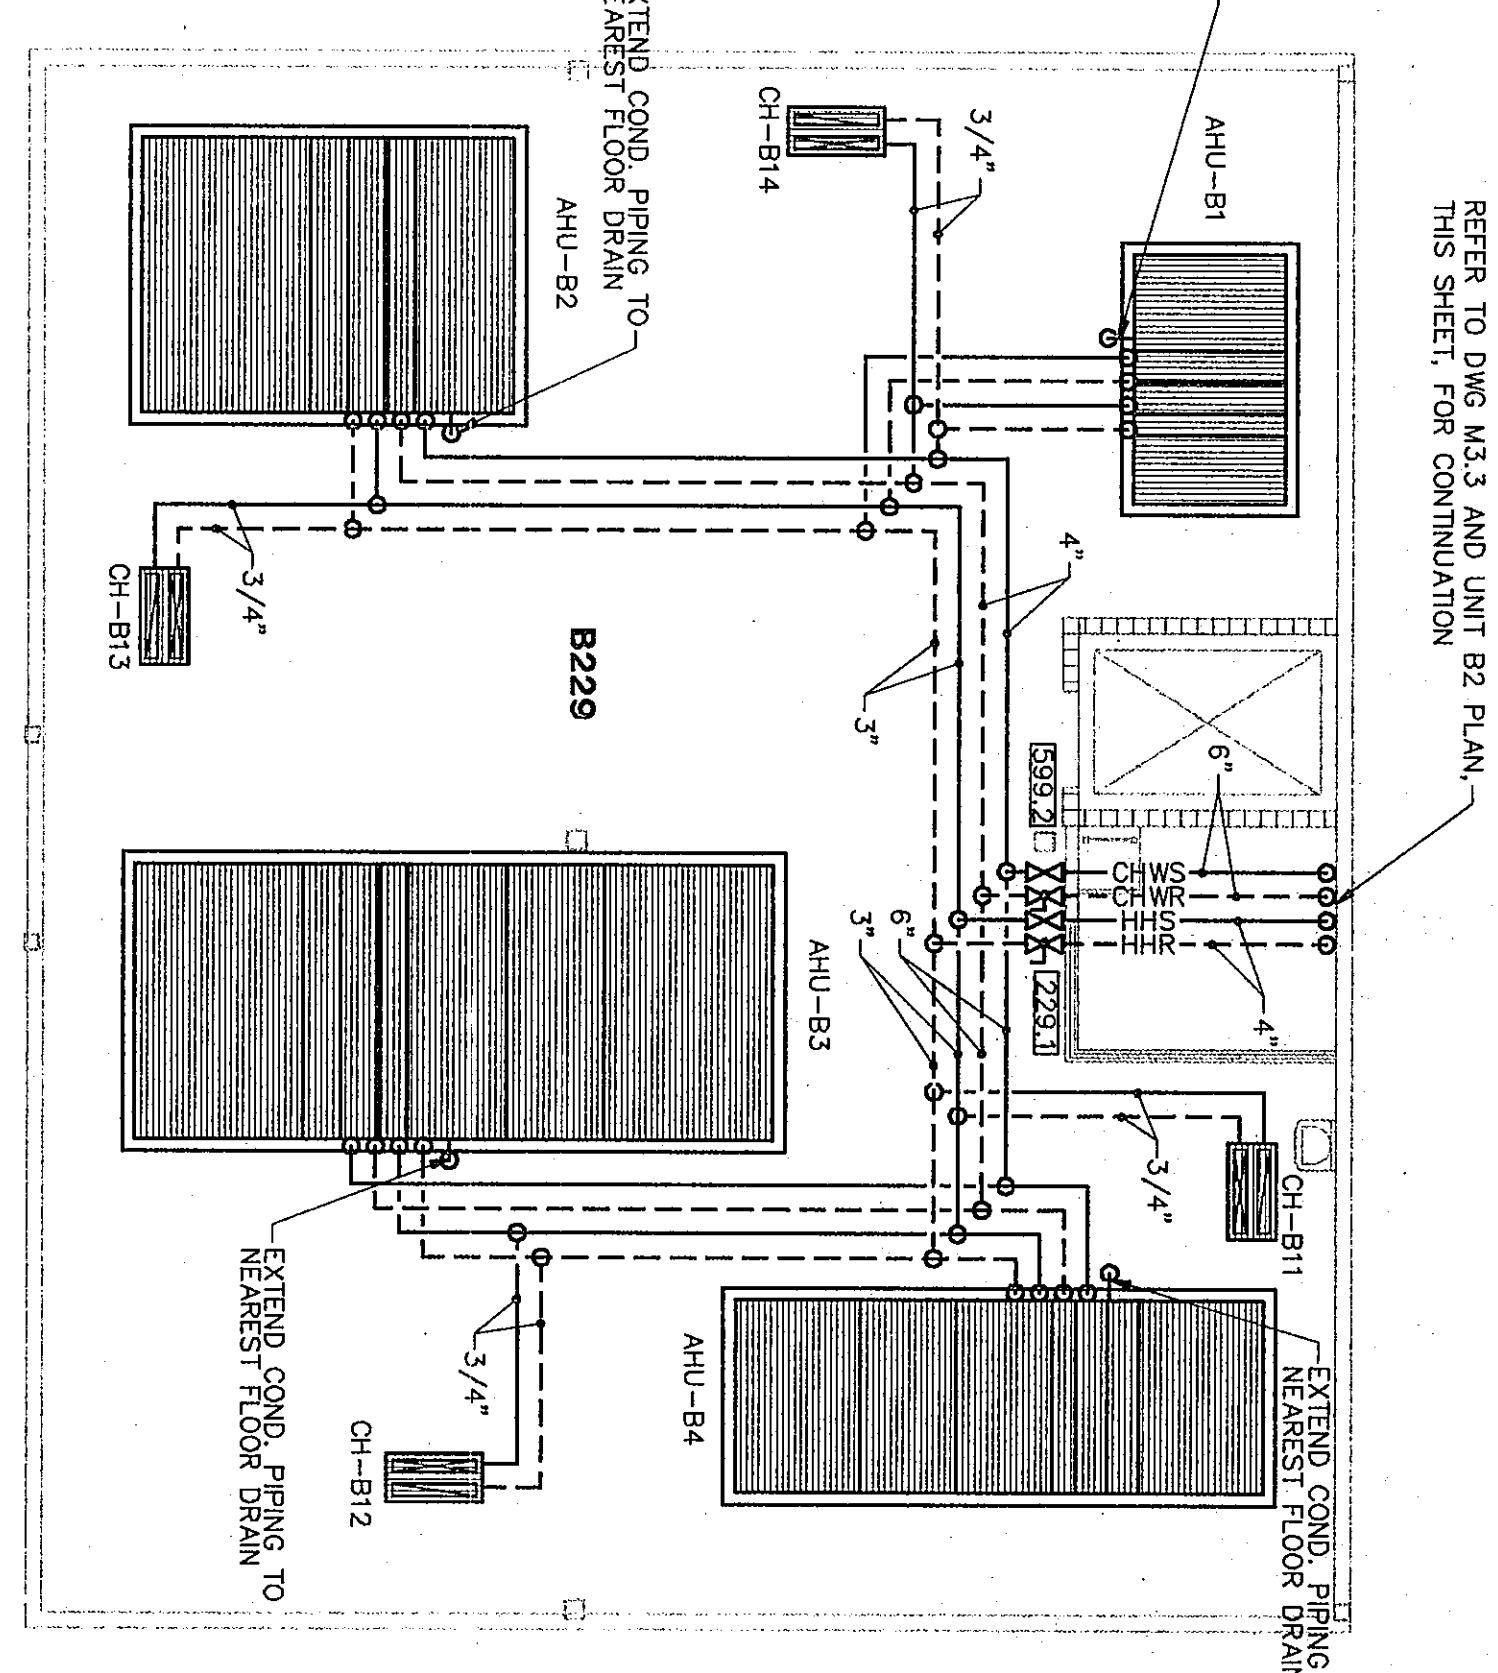

FLOOR PLAN UNIT "B2"

1/8"=1'-0"


MEZZANINE FLOOR PLAN UNIT "B2"

1/8"=1'-0"

Fanning/Howey Associates, Inc.
Architects Engineers Consultants

COMM. NO. 95067.00
DATE: APRIL 21, 1997

REVISIONS NO. DATE

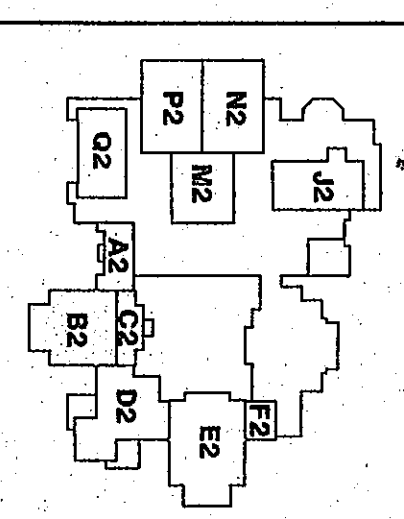

THE NEW
CHESTERTON HIGH SCHOOL
FOR THE
DUNELAND SCHOOL CORPORATION
CHESTERTON, INDIANA

COPYRIGHT 1997 BY FANNING/HOWEY ASSOCIATES, INC.

Professional Engineer Seal for Fanning/Howey Associates, Inc., State of Indiana, License No. 12543.

HEATING PLAN UNIT "B2"

DRAWN BY: SCB
CHECKED BY: CAM

M3.4