



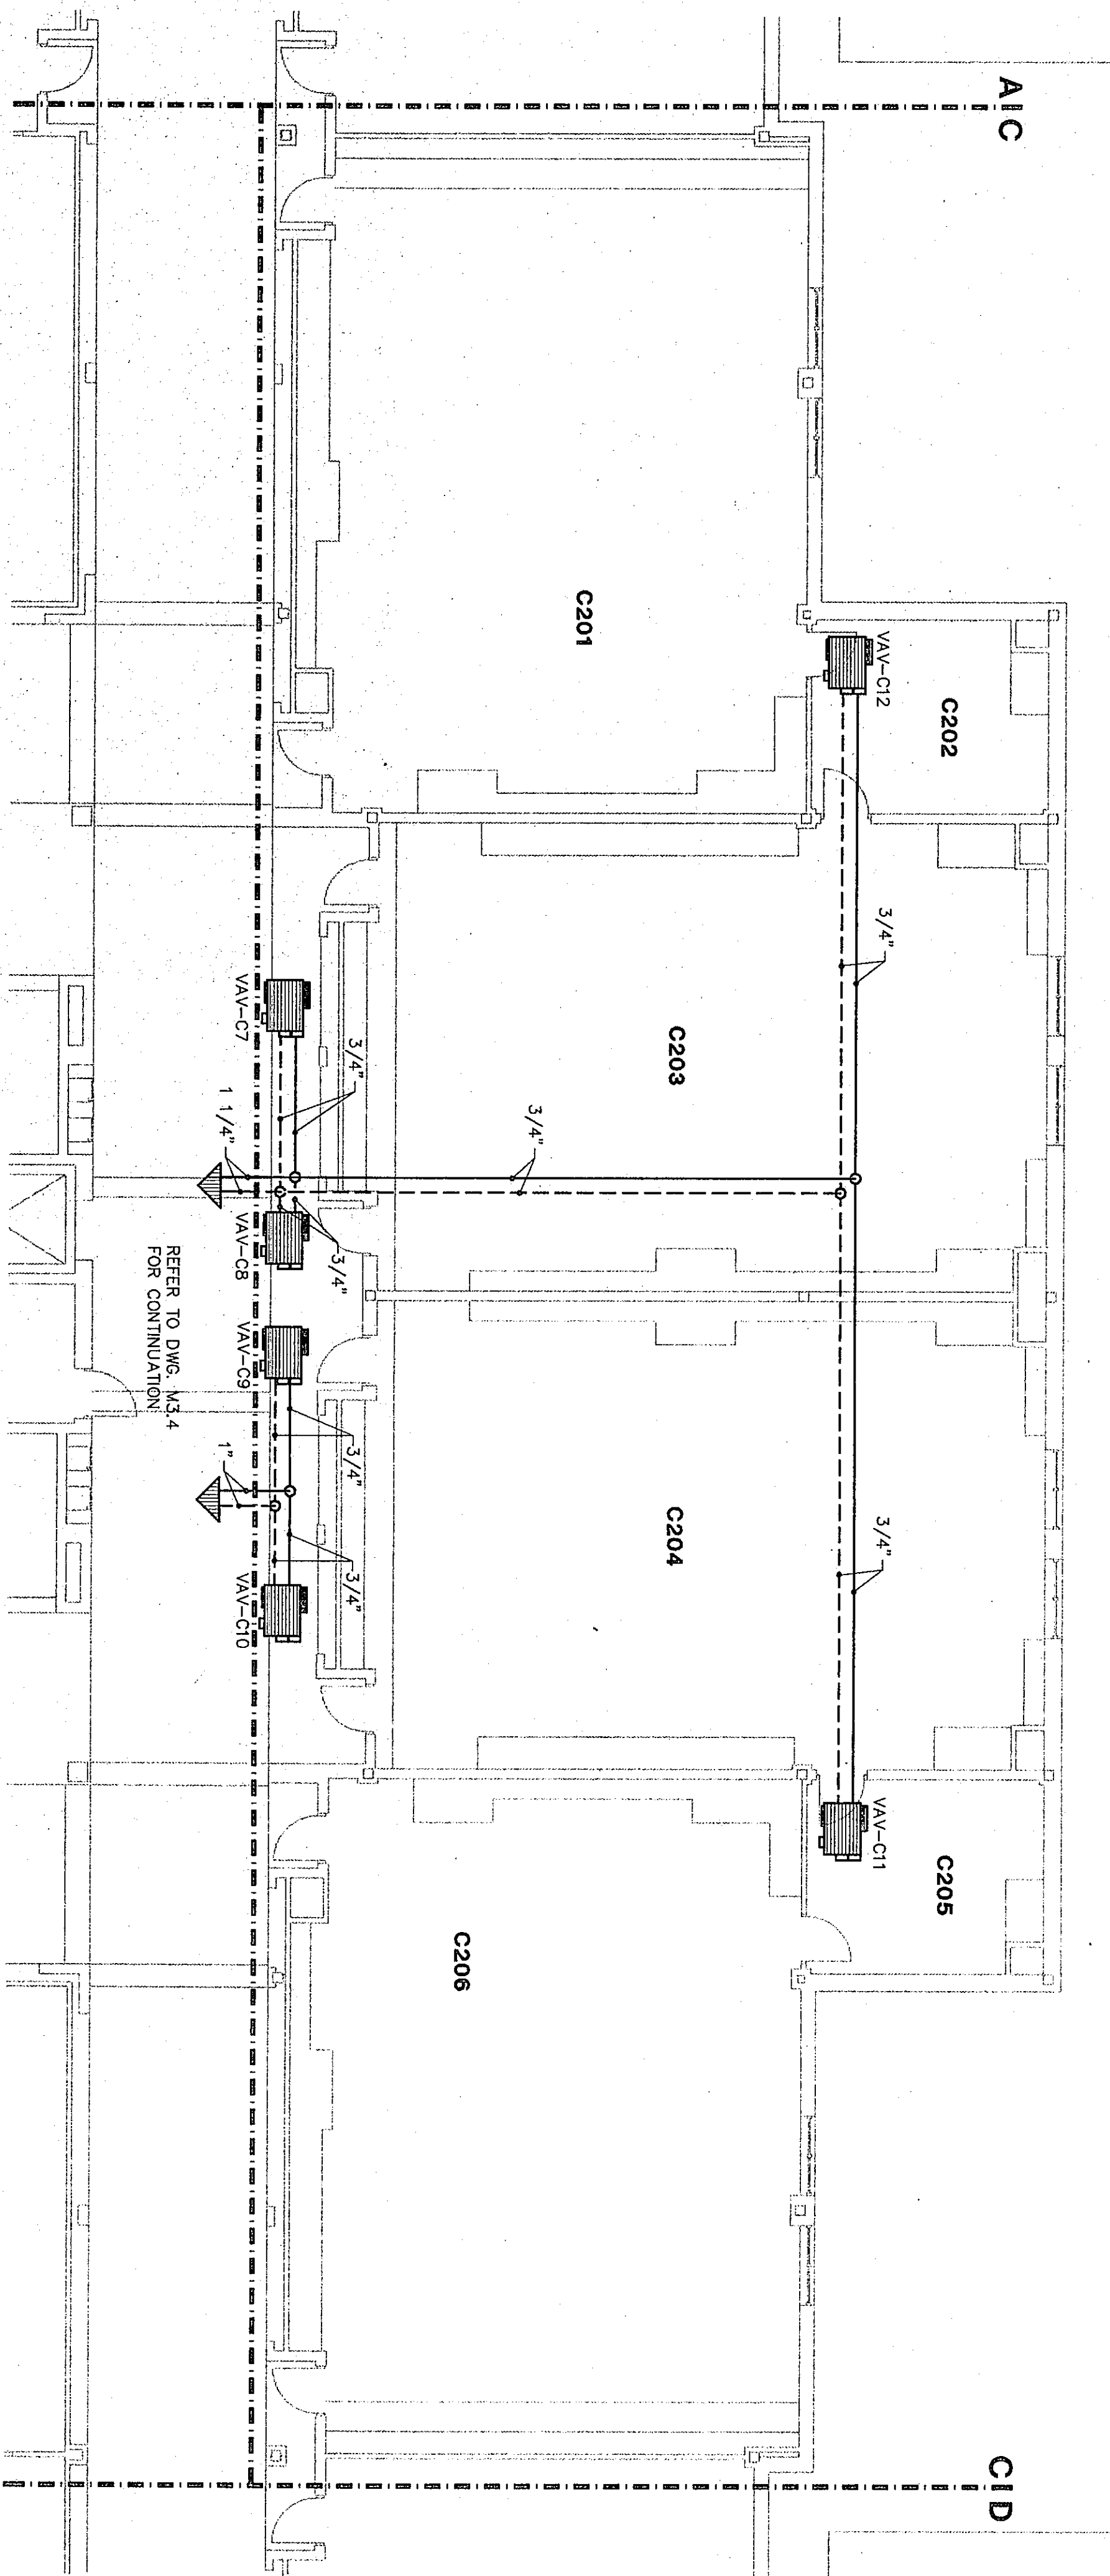

FLOOR PLAN UNIT "C2"

1/8"=1'-0"


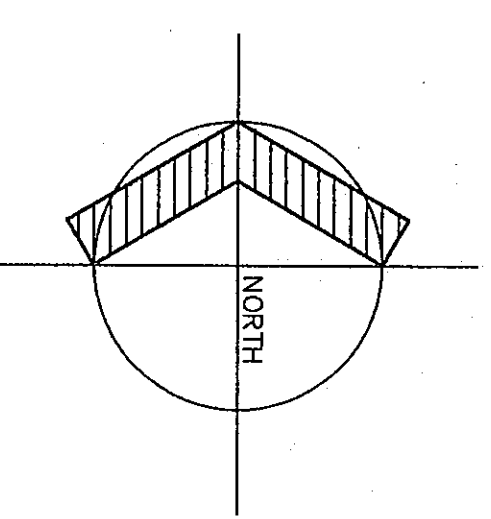


ROOM LEGEND "C2"

ROOM NO.	ROOM NAME	AREA S.F.	CEILING HEIGHT
C201	SCIENCE LAB	1505	VARIES
C202	PREP. ROOM	200	9'-4"
C203	SCIENCE LAB	1436	VARIES
C204	SCIENCE LAB	1436	VARIES
C205	PREP. ROOM	200	9'-4"
C206	SCIENCE LAB	1505	VARIES

THE NEW
CHESTERTON HIGH SCHOOL
FOR THE
DUNELAND SCHOOL CORPORATION
CHESTERTON, INDIANA

COPYRIGHT 1997 BY FANNING/HOWEY ASSOCIATES, INC.

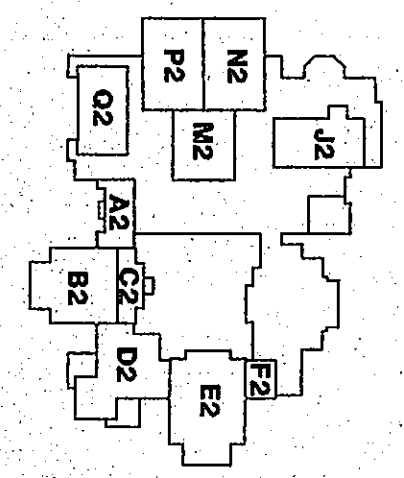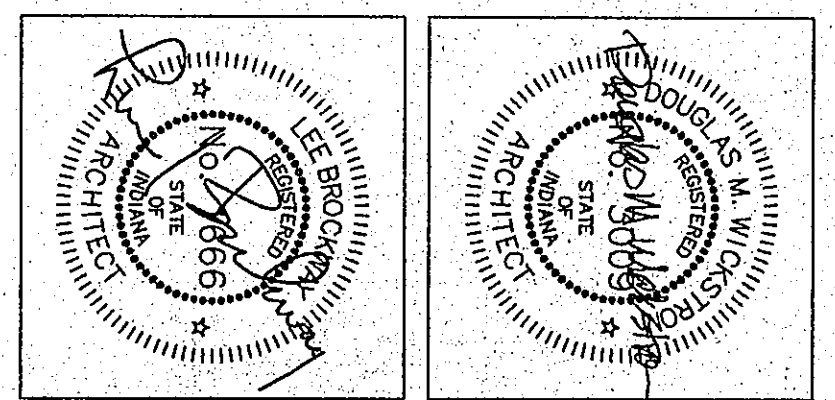

Fanning/Howey Associates, Inc.
Architects Engineers Consultants

HEATING PLAN UNIT "C2"
DRAWN BY: SCB COMM. NO.: 95067.00
CHECKED BY: CAM DATE: APRIL 21, 1997
M3.6

92-M-43