



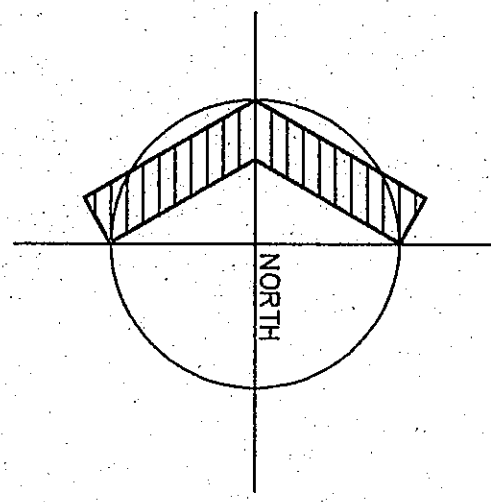


FLOOR PLAN UNIT "D2"

1/8"=1'-0"

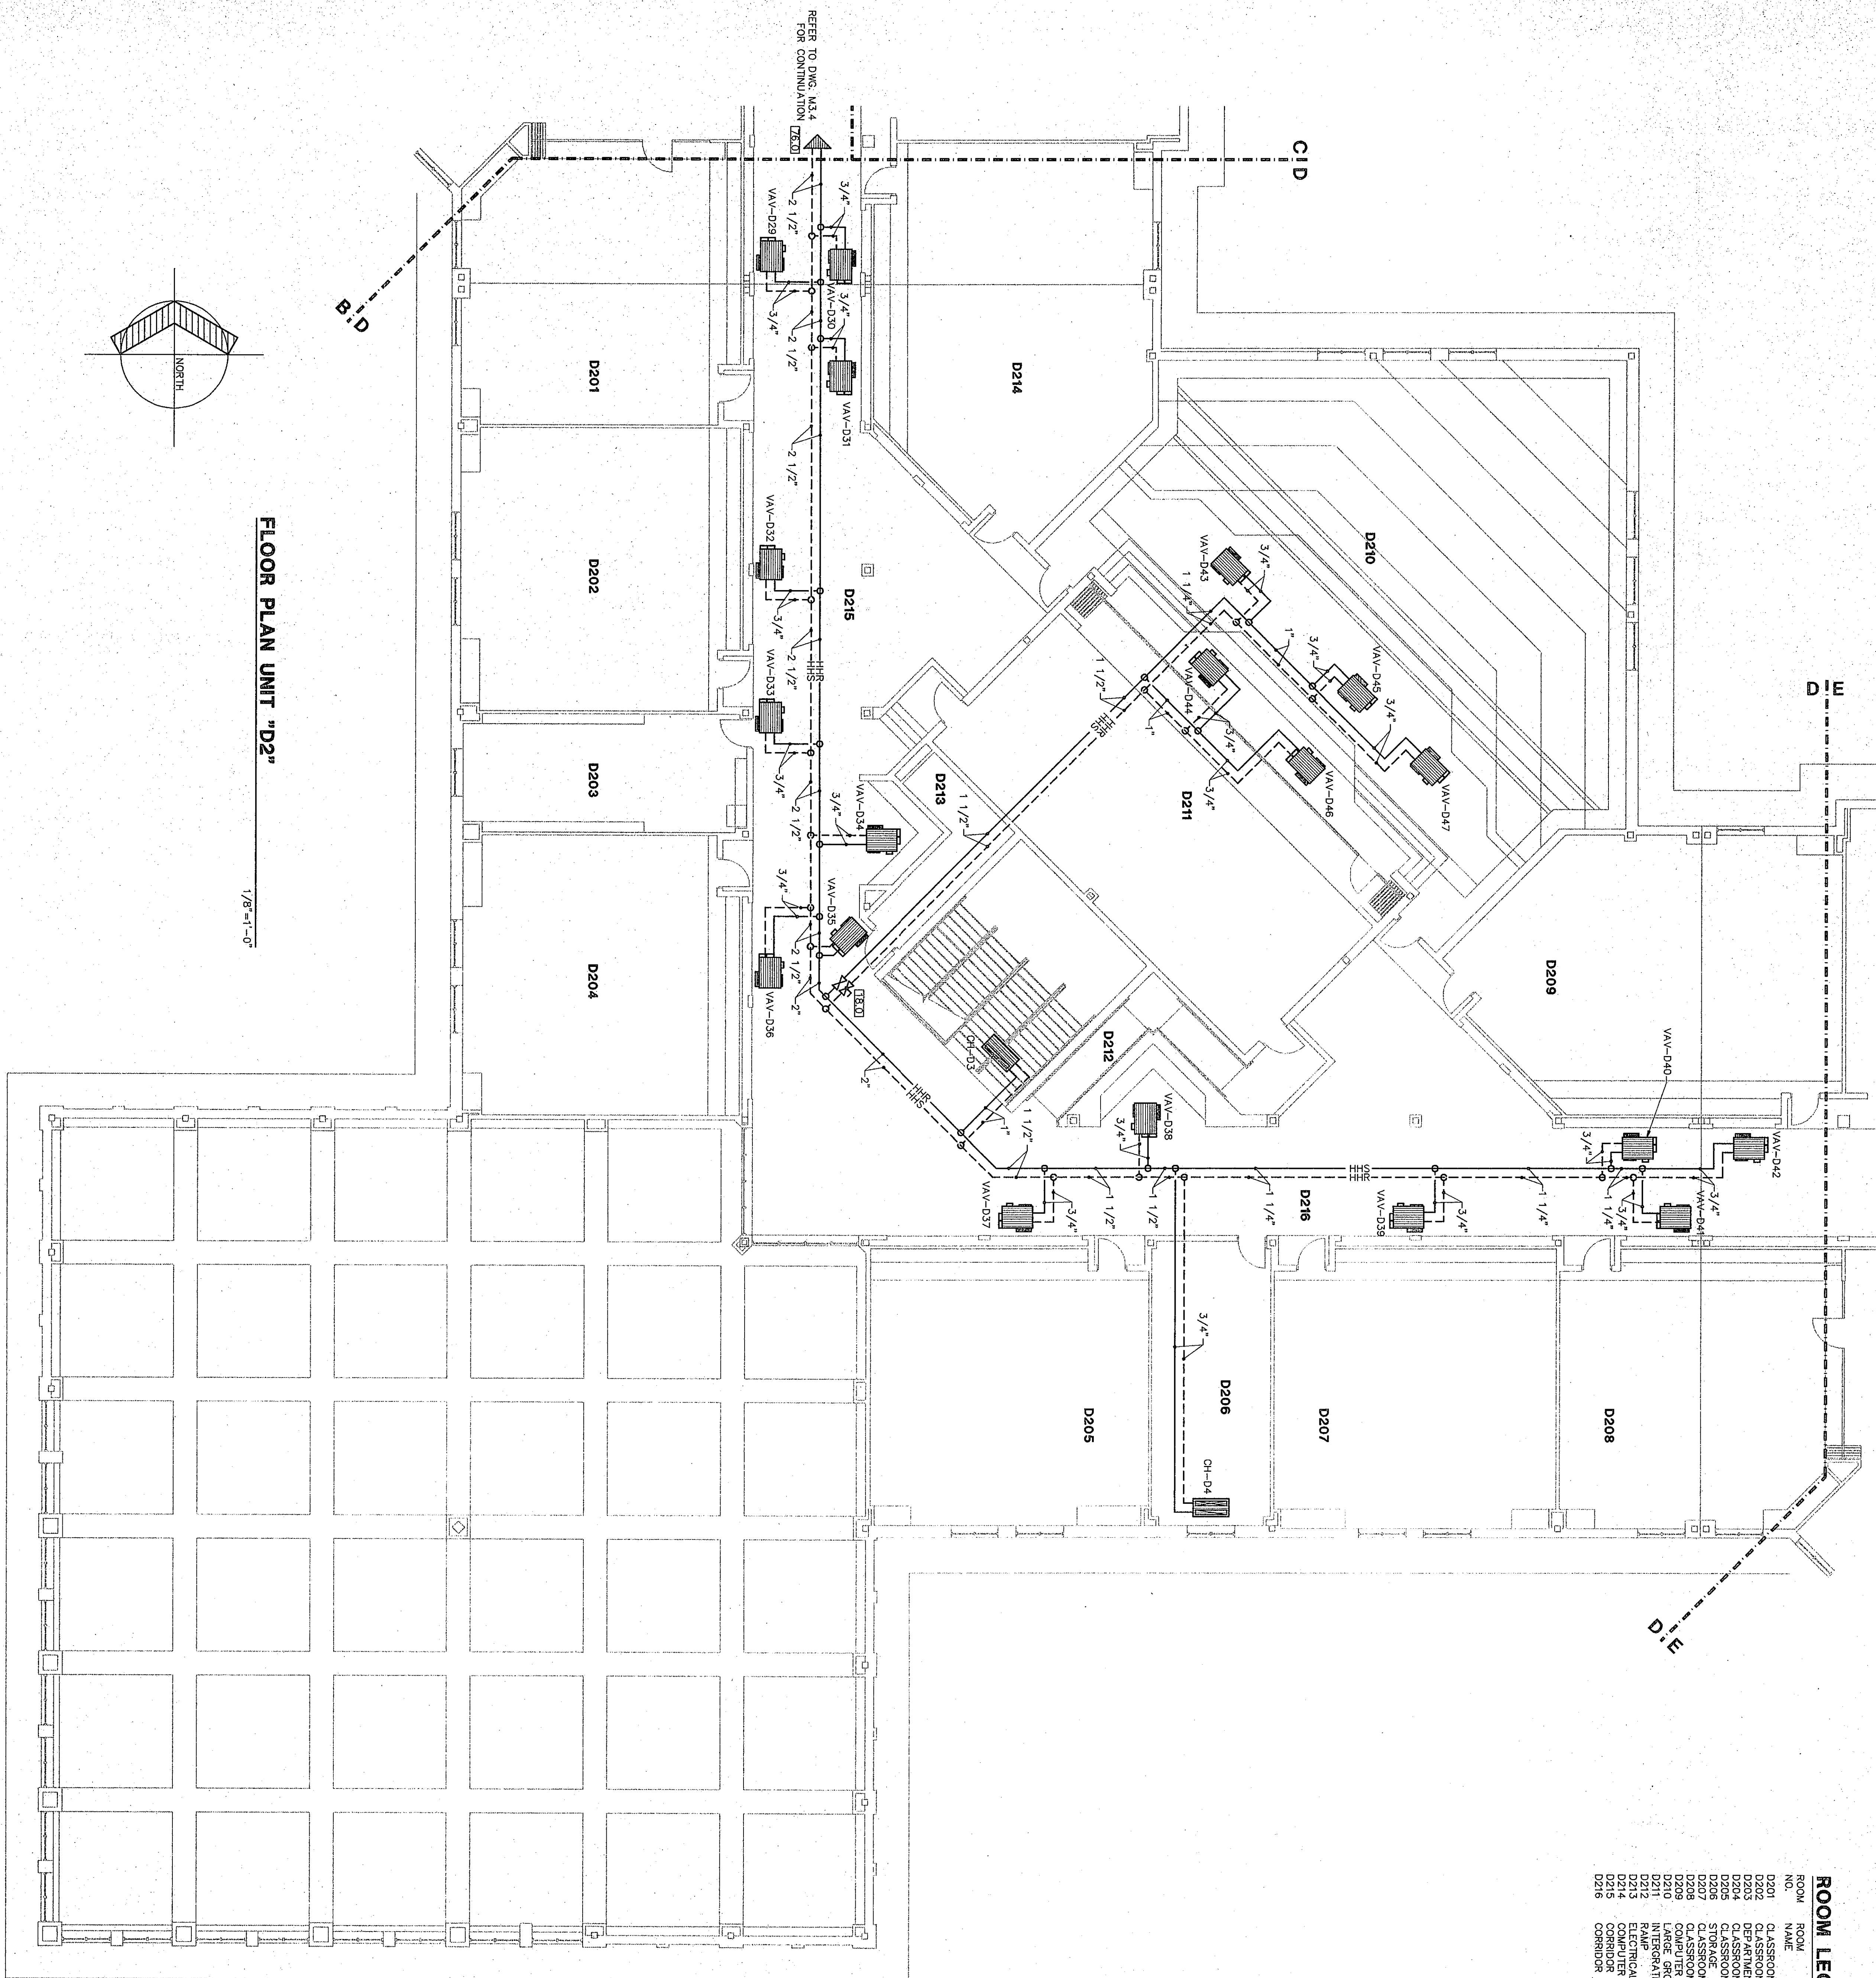


ROOM LEGEND "D2"			
ROOM NO.	ROOM NAME	AREA S.F.	CEILING HEIGHT
D201	CLASSROOM	995	VARIABLE MATH
D202	CLASSROOM	972	VARIABLE MATH
D203	CLASSROOM	972	VARIABLE MATH
D204	CLASSROOM	972	VARIABLE MATH
D205	CLASSROOM	972	VARIABLE MATH
D206	CLASSROOM	972	VARIABLE MATH
D207	CLASSROOM	972	VARIABLE MATH
D208	CLASSROOM	972	VARIABLE MATH
D209	CLASSROOM	972	VARIABLE MATH
D210	CLASSROOM	972	VARIABLE MATH
D211	CLASSROOM	972	VARIABLE MATH
D212	CLASSROOM	972	VARIABLE MATH
D213	CLASSROOM	972	VARIABLE MATH
D214	CLASSROOM	972	VARIABLE MATH
D215	CLASSROOM	972	VARIABLE MATH
D216	CLASSROOM	972	VARIABLE MATH
D208	CLASSROOM	972	VARIABLE MATH
D209	CLASSROOM	972	VARIABLE MATH
D210	CLASSROOM	972	VARIABLE MATH
D211	CLASSROOM	972	VARIABLE MATH
D212	CLASSROOM	972	VARIABLE MATH
D213	CLASSROOM	972	VARIABLE MATH
D214	CLASSROOM	972	VARIABLE MATH
D215	CLASSROOM	972	VARIABLE MATH
D216	CLASSROOM	972	VARIABLE MATH

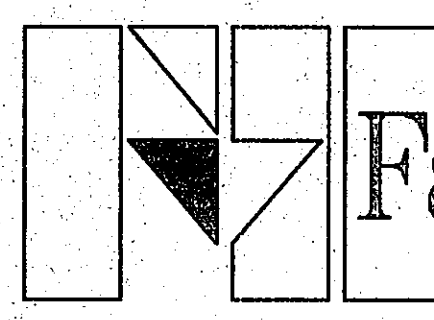

Fanning/Howey



Associates, Inc.

Architects Engineers Consultants

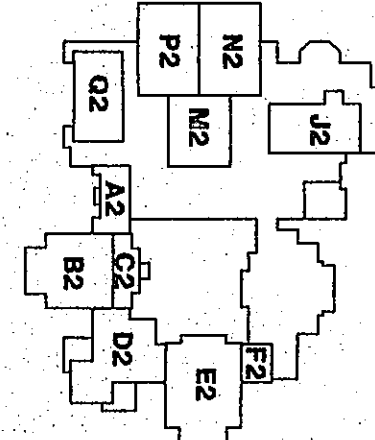

THE NEW
CHESTERTON HIGH SCHOOL
FOR THE
DUNELAND SCHOOL CORPORATION
CHESTERTON, INDIANA

COPYRIGHT 1997 BY FANNING/HOWEY ASSOCIATES, INC.

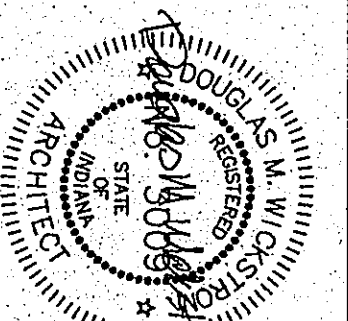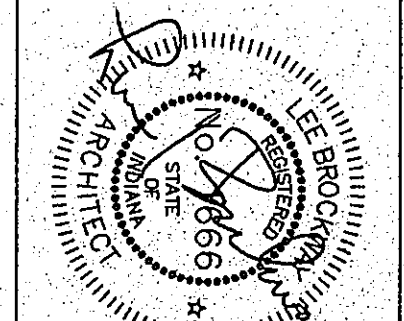

HEATING PLAN UNIT "D2"

DRAWN BY: SCB

CHECKED BY: CAM

COMM. NO.: 95067.00

DATE: APRIL 21, 1997

M3.8

REVISIONS NO. DATE