


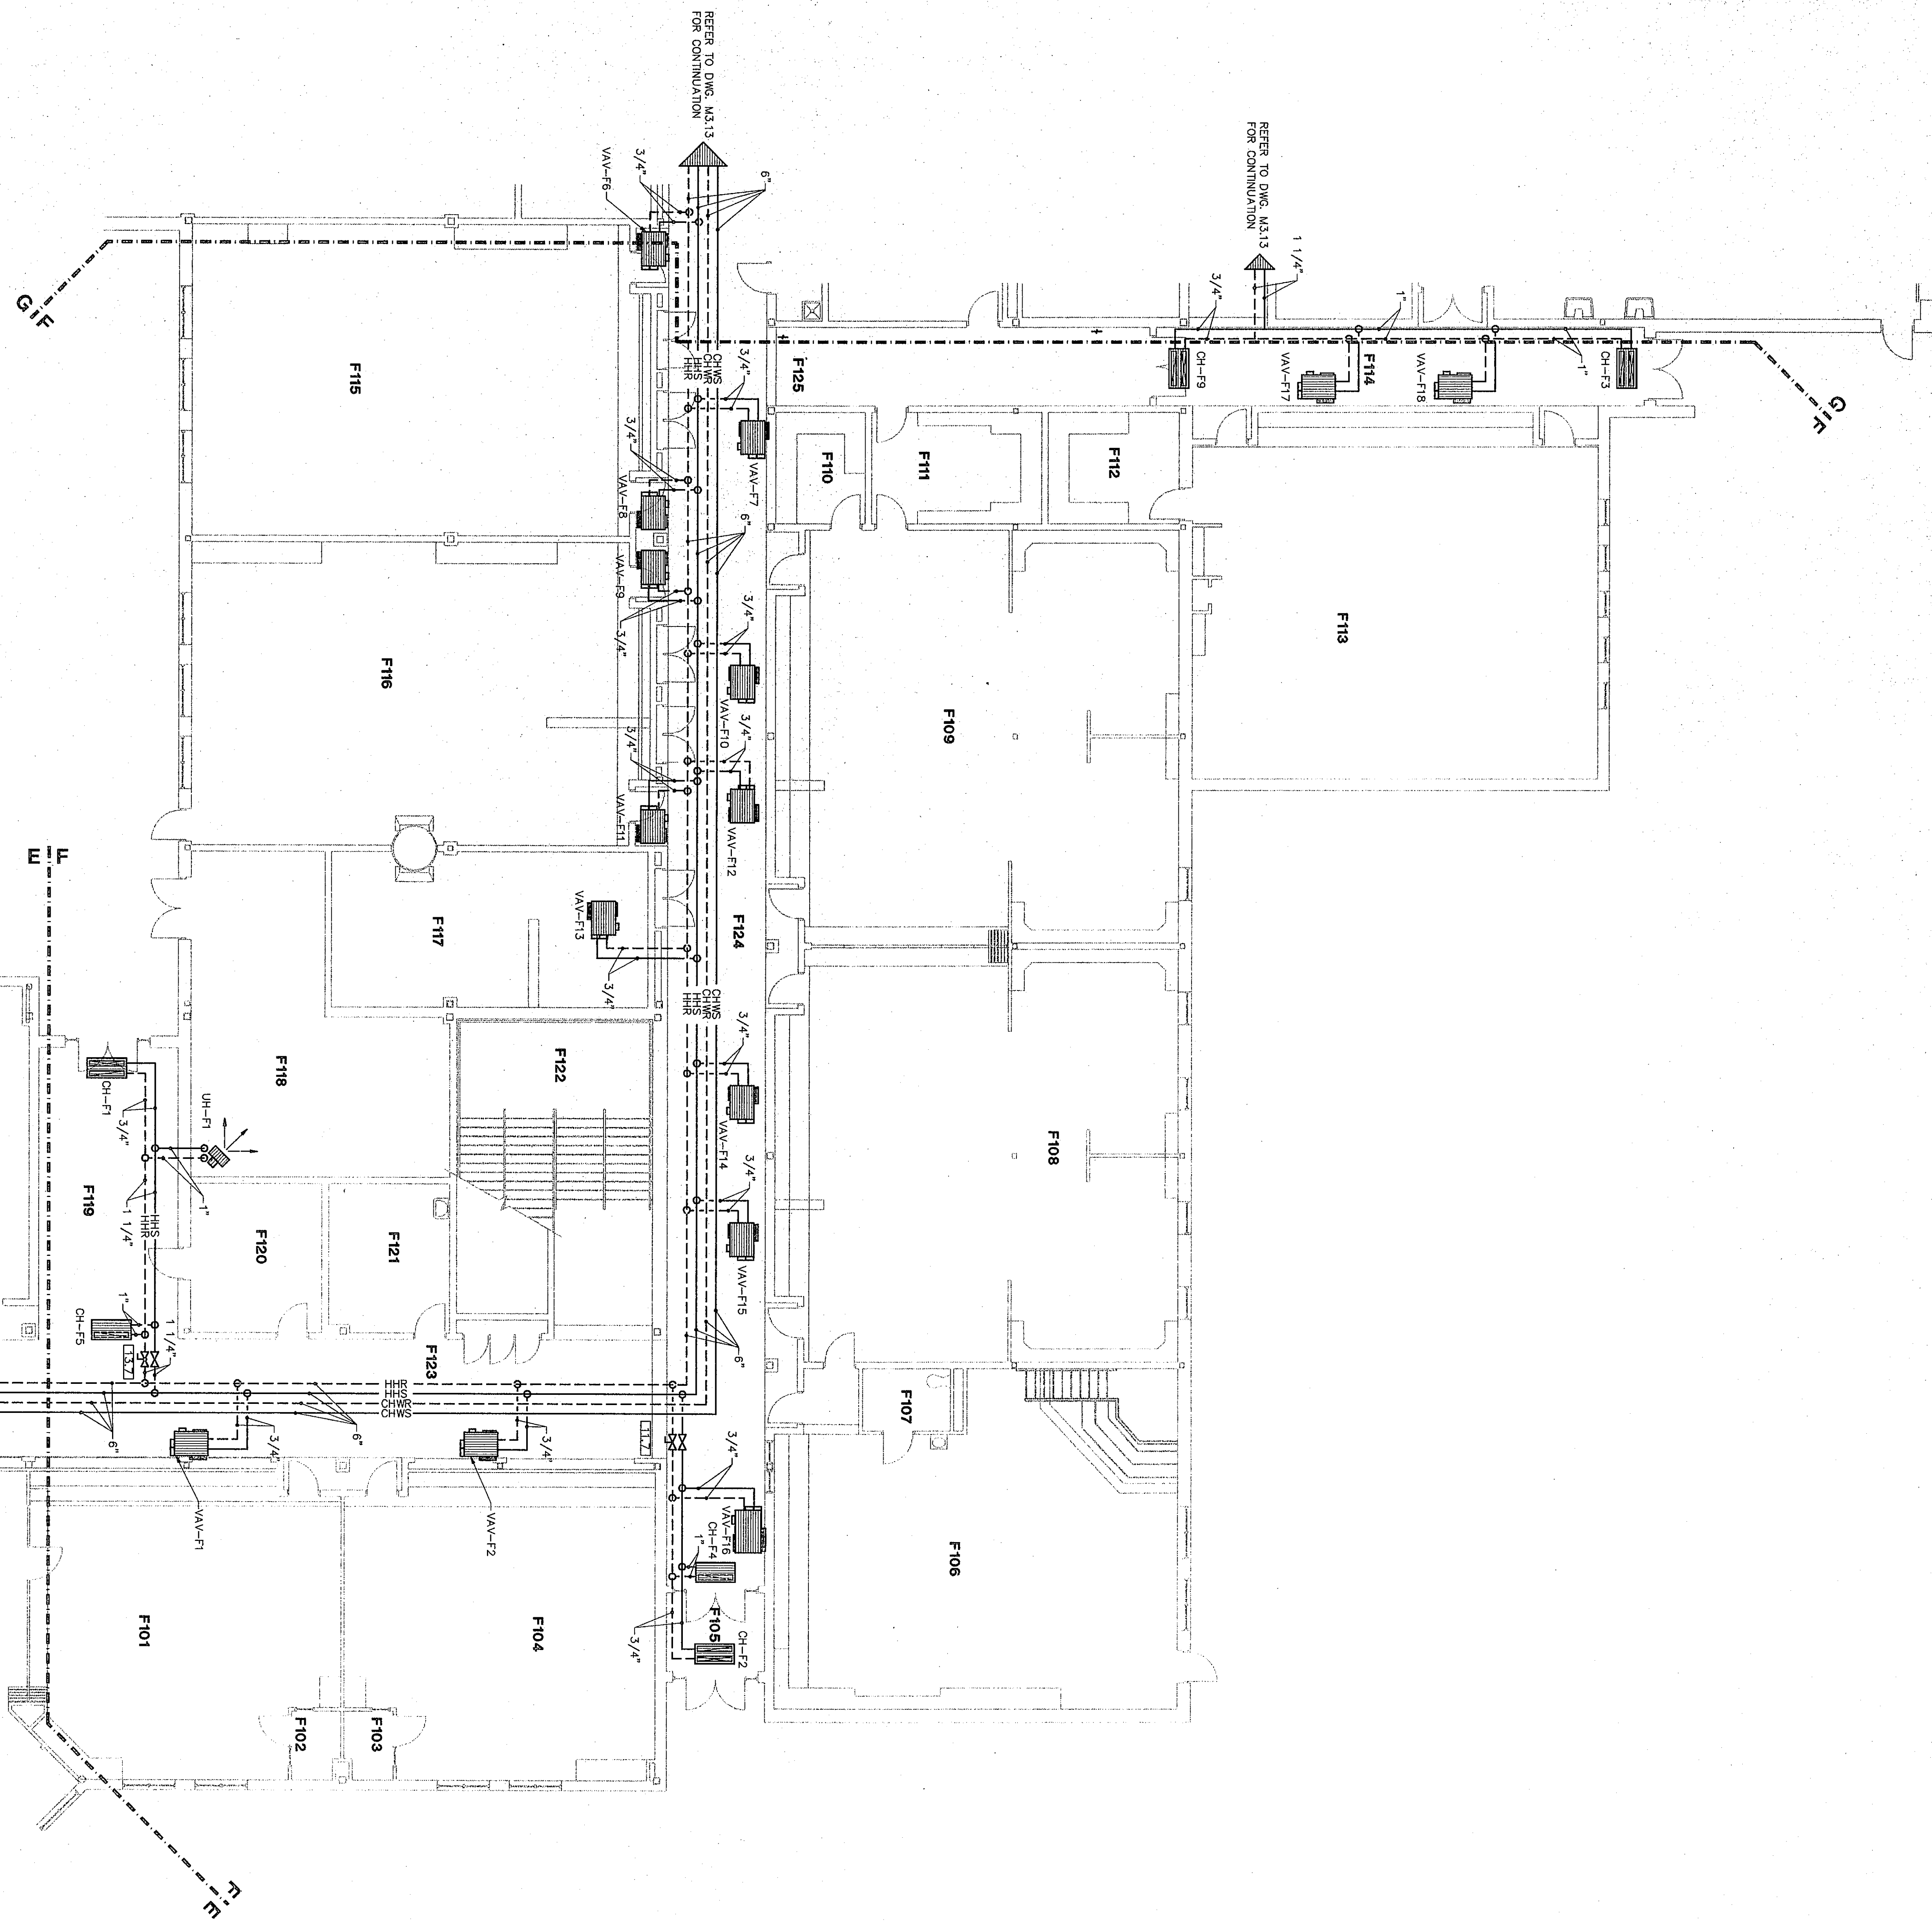

FLOOR PLAN UNIT "F"

1/8"=1'-0"


REFER TO DWG. M3.9 FOR CONTINUATION

REFER TO DWG. M3.13 FOR CONTINUATION

REFER TO DWG. M3.13 FOR CONTINUATION

ROOM LEGEND "F"

ROOM NO.	ROOM NAME	AREA	BEING
F101	CLASSROOM	923	WARES
F102	RECORDING	33	WARES
F103	RECORDING	33	WARES
F104	RECORDING	33	WARES
F200	RECORDING	33	WARES

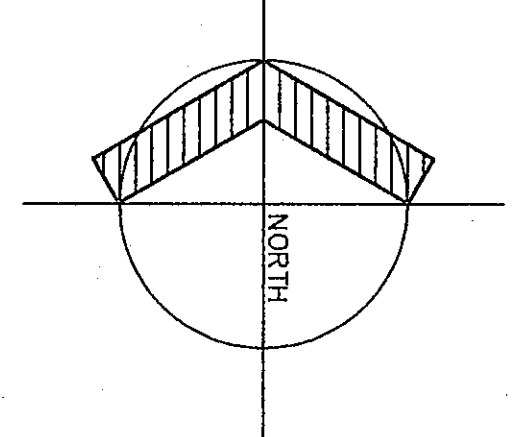


Fanning/Howey Associates, Inc.
Architects Engineers Consultants

HEATING PLAN UNIT "F"

DRAWN BY: SCB COMM. NO.: 95067.00
CHECKED BY: CAM DATE: APRIL 21, 1997

M3.11

REVISIONS NO. DATE

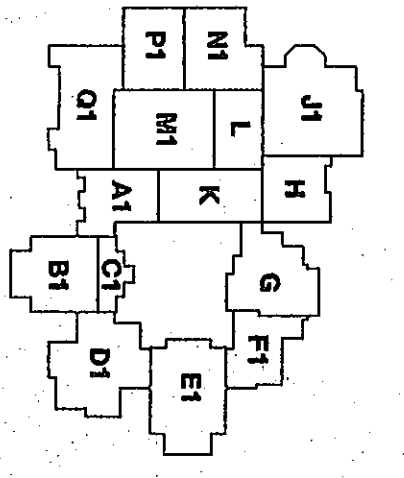

THE NEW
CHESTERTON HIGH SCHOOL
FOR THE
DUNELAND SCHOOL CORPORATION
CHESTERTON, INDIANA

Copyright 1997 by Fanning/Howey Associates, Inc.

Professional Engineer Seal for Fanning/Howey Associates, Inc., State of Indiana, No. 1448, dated 10-10-97.

Professional Engineer Seal for Fanning/Howey Associates, Inc., State of Indiana, No. 1448, dated 10-10-97.

CHESTERTON HIGH SCHOOL
95067.00