



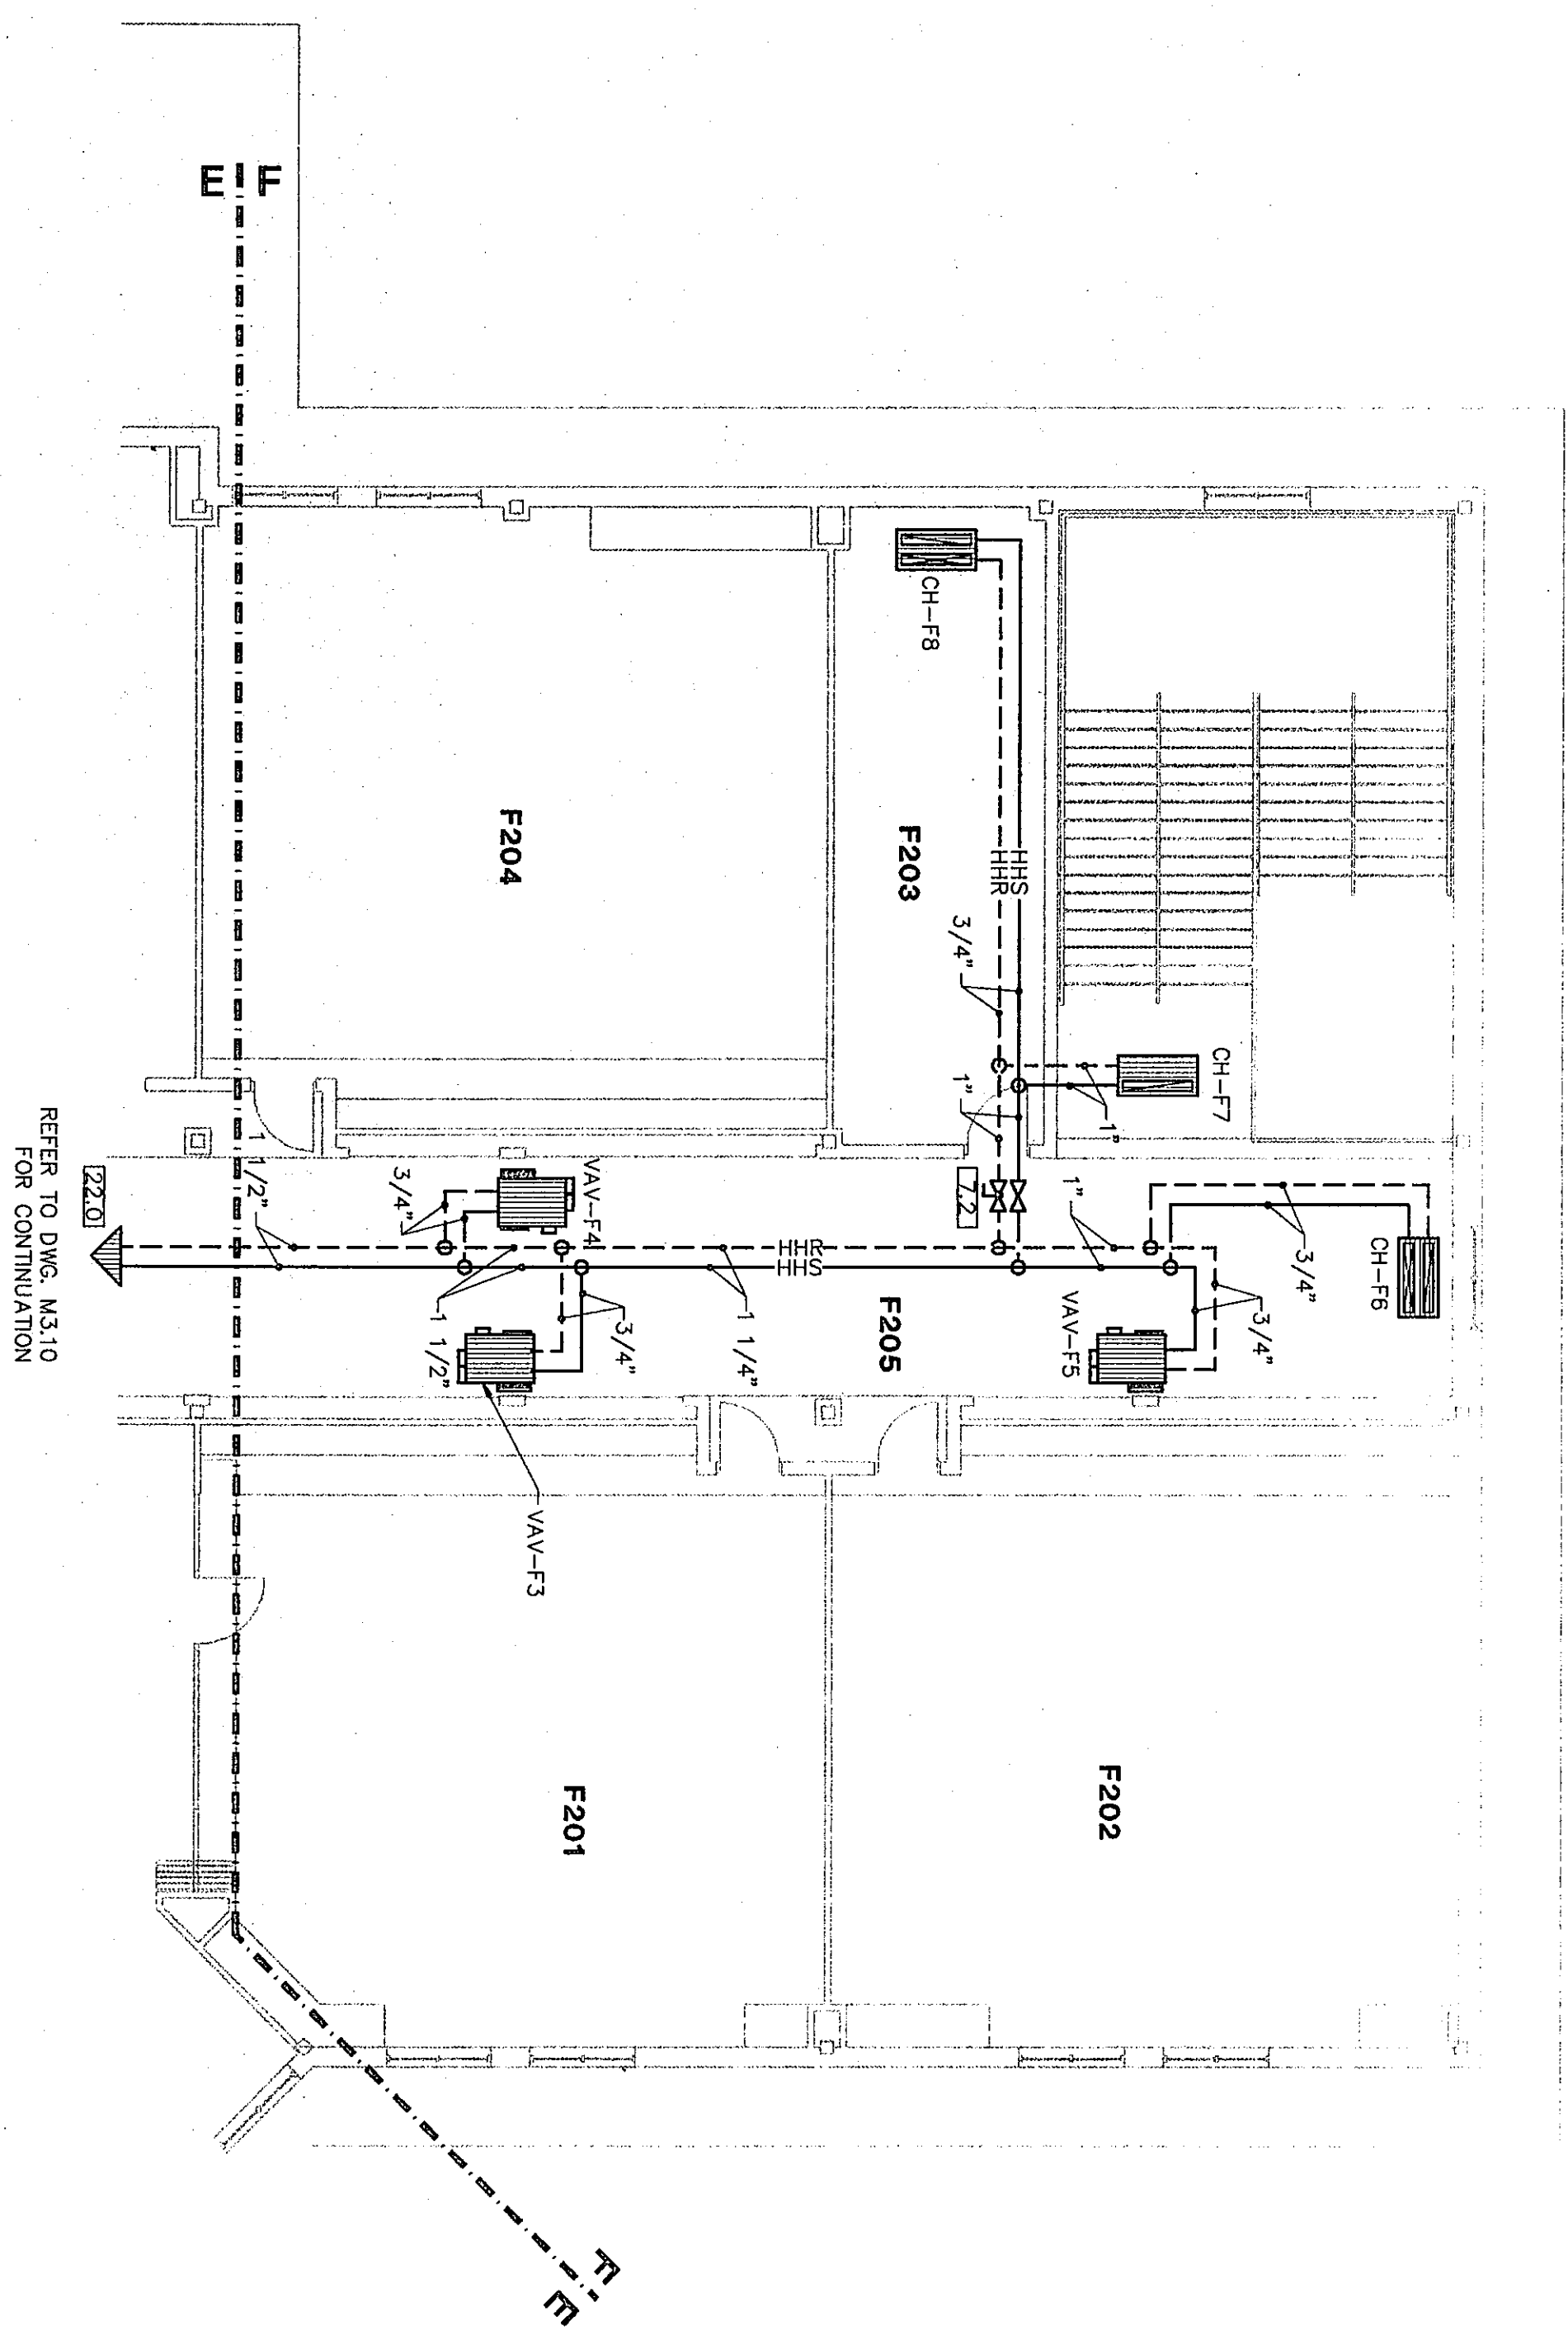

FLOOR PLAN UNIT "F2"


1/8"=1'-0"

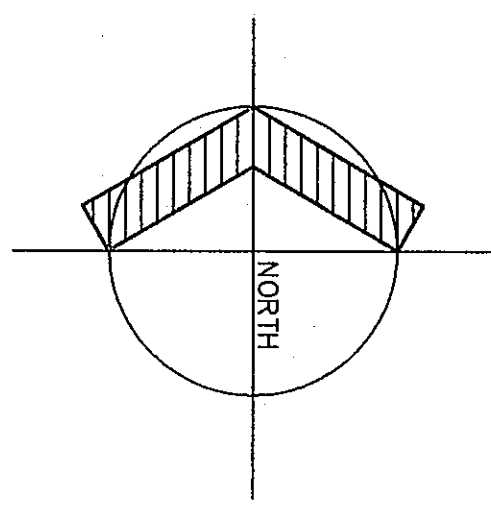


8-11-97

CHESTERTON HIGH SCHOOL
05067.00

HEATING PLAN UNIT "F2"	
DRAWN BY: SCB	COMM. NO.: 95067.00
CHECKED BY: CAM	DATE: APRIL 21, 1997
M3.12	REVISIONS NO. DATE

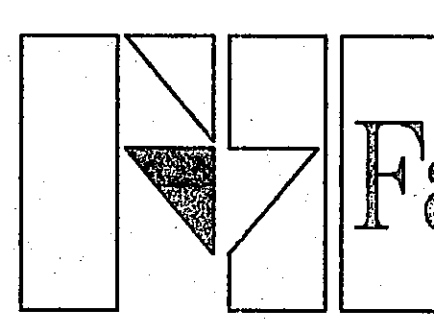

Fanning/Howey
Associates, Inc.
Architects Engineers Consultants

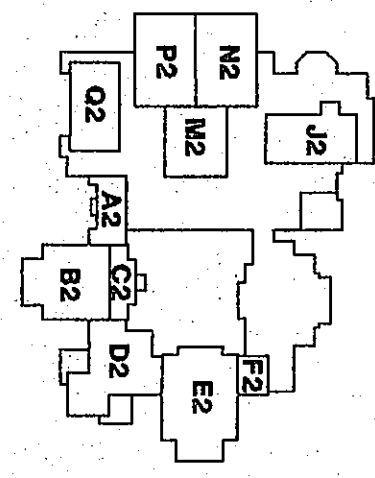

THE NEW
CHESTERTON HIGH SCHOOL
FOR THE
DUNELAND SCHOOL CORPORATION
CHESTERTON, INDIANA

COPYRIGHT 1997 BY FANNING/HOWEY ASSOCIATES, INC.

