



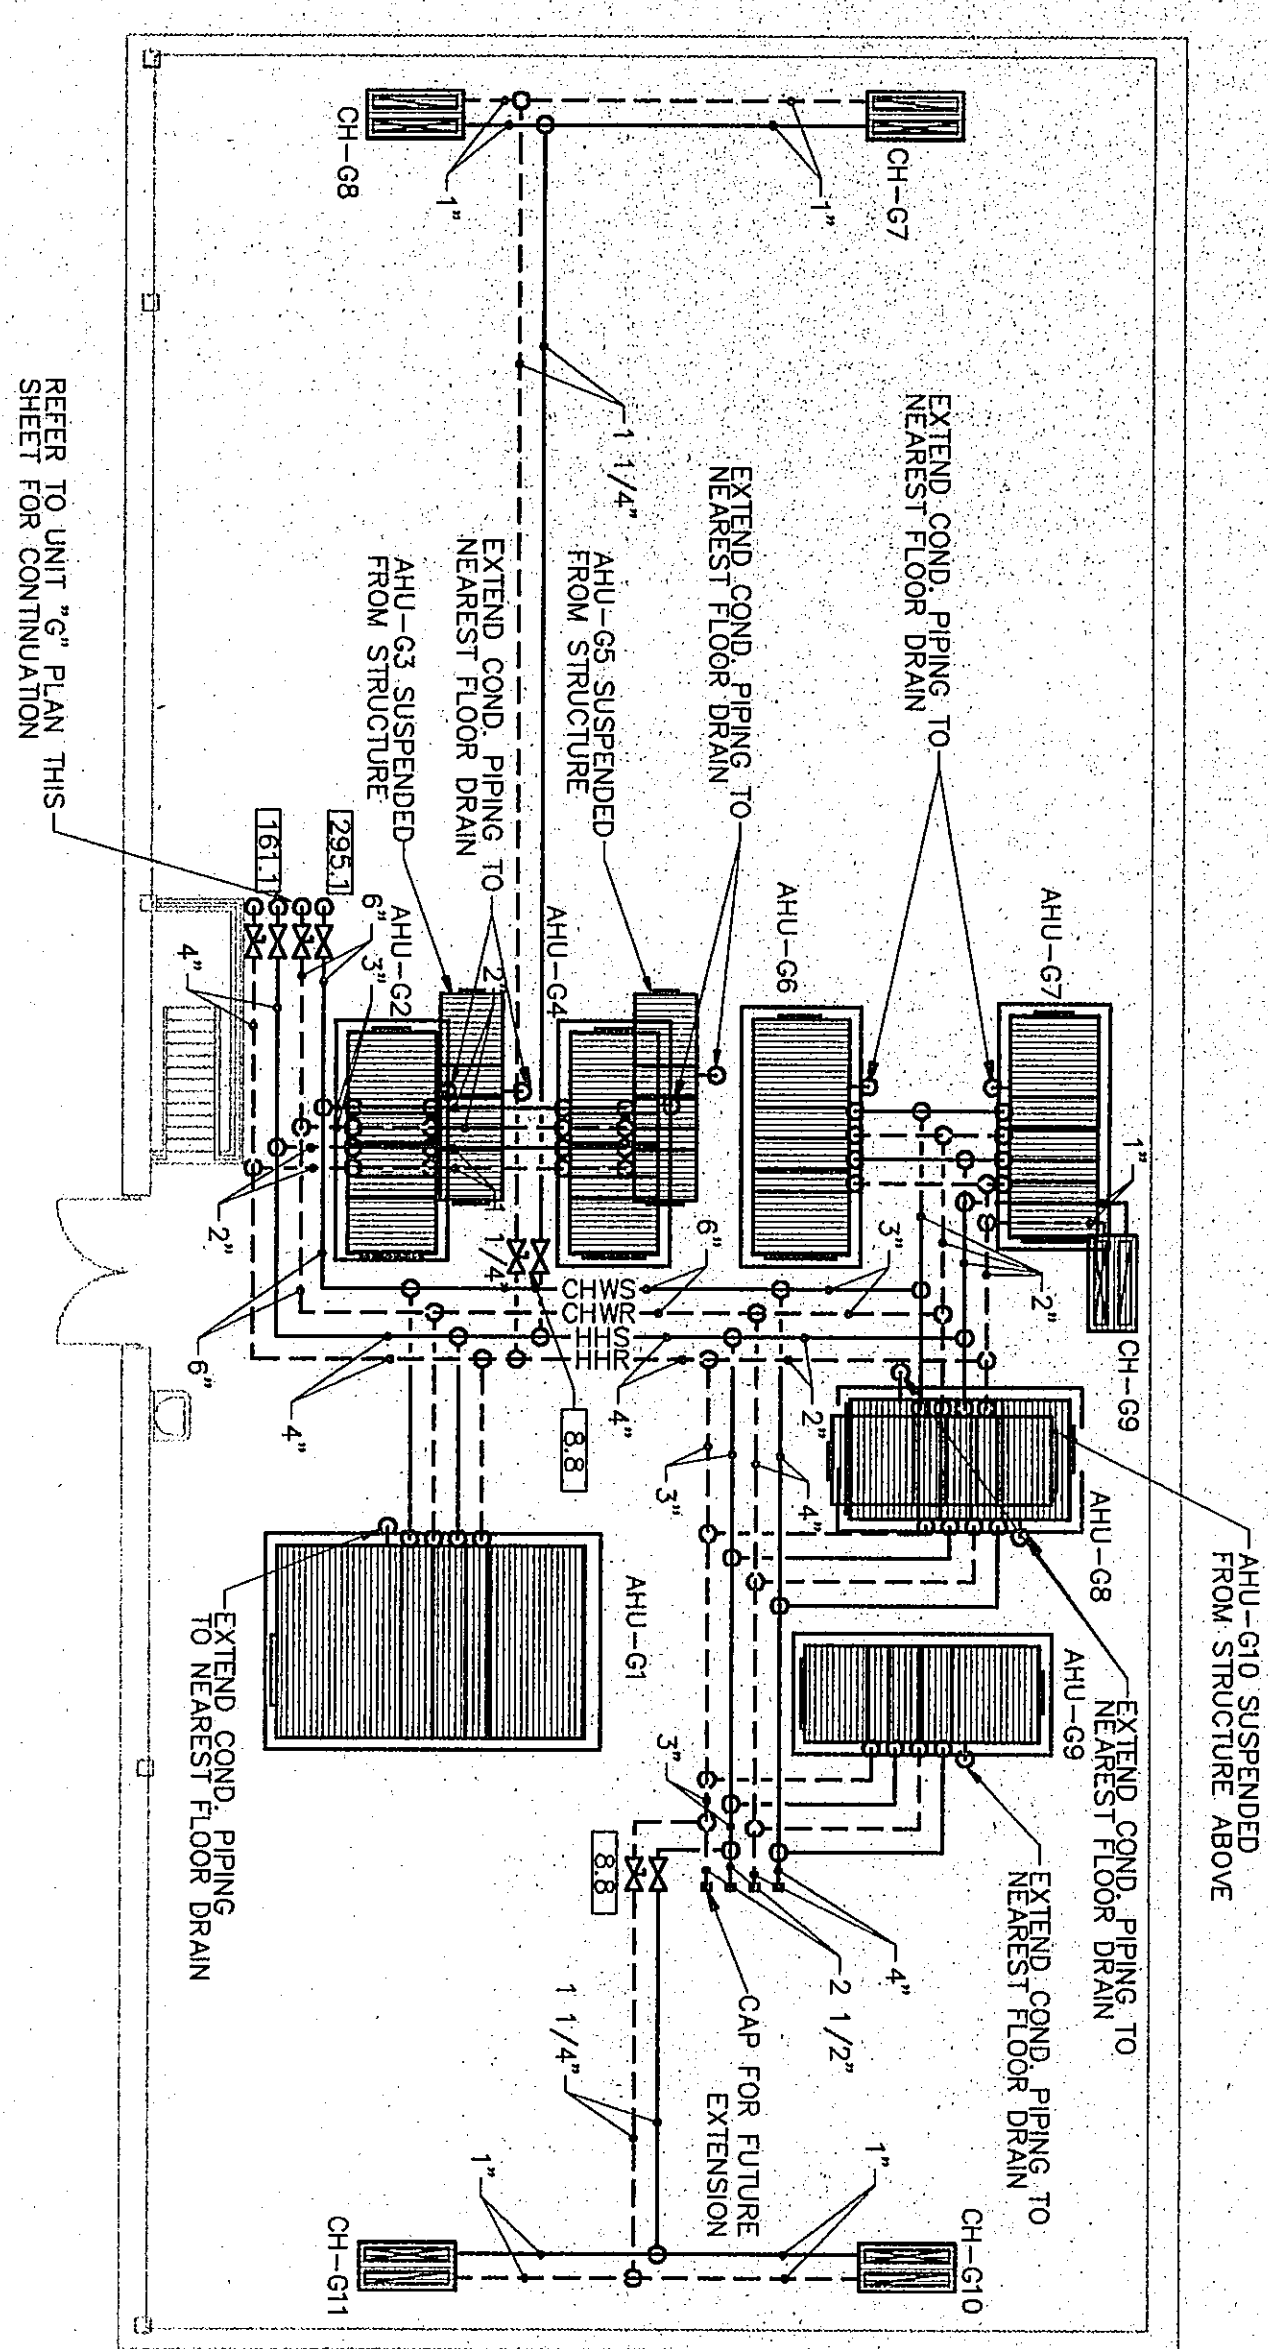

MARK	HEATING	COOLING
AHU-G1	59.6	128.0
AHU-G2	7.9	16.6
AHU-G3	4.3	9.2
AHU-G4	7.6	15.8
AHU-G5	13.0	21.5
AHU-G6	13.0	21.5
AHU-G7	7.2	15.0
AHU-G8	13.7	29.1
AHU-G9	12.5	26.1
AHU-G10	7.9	16.6

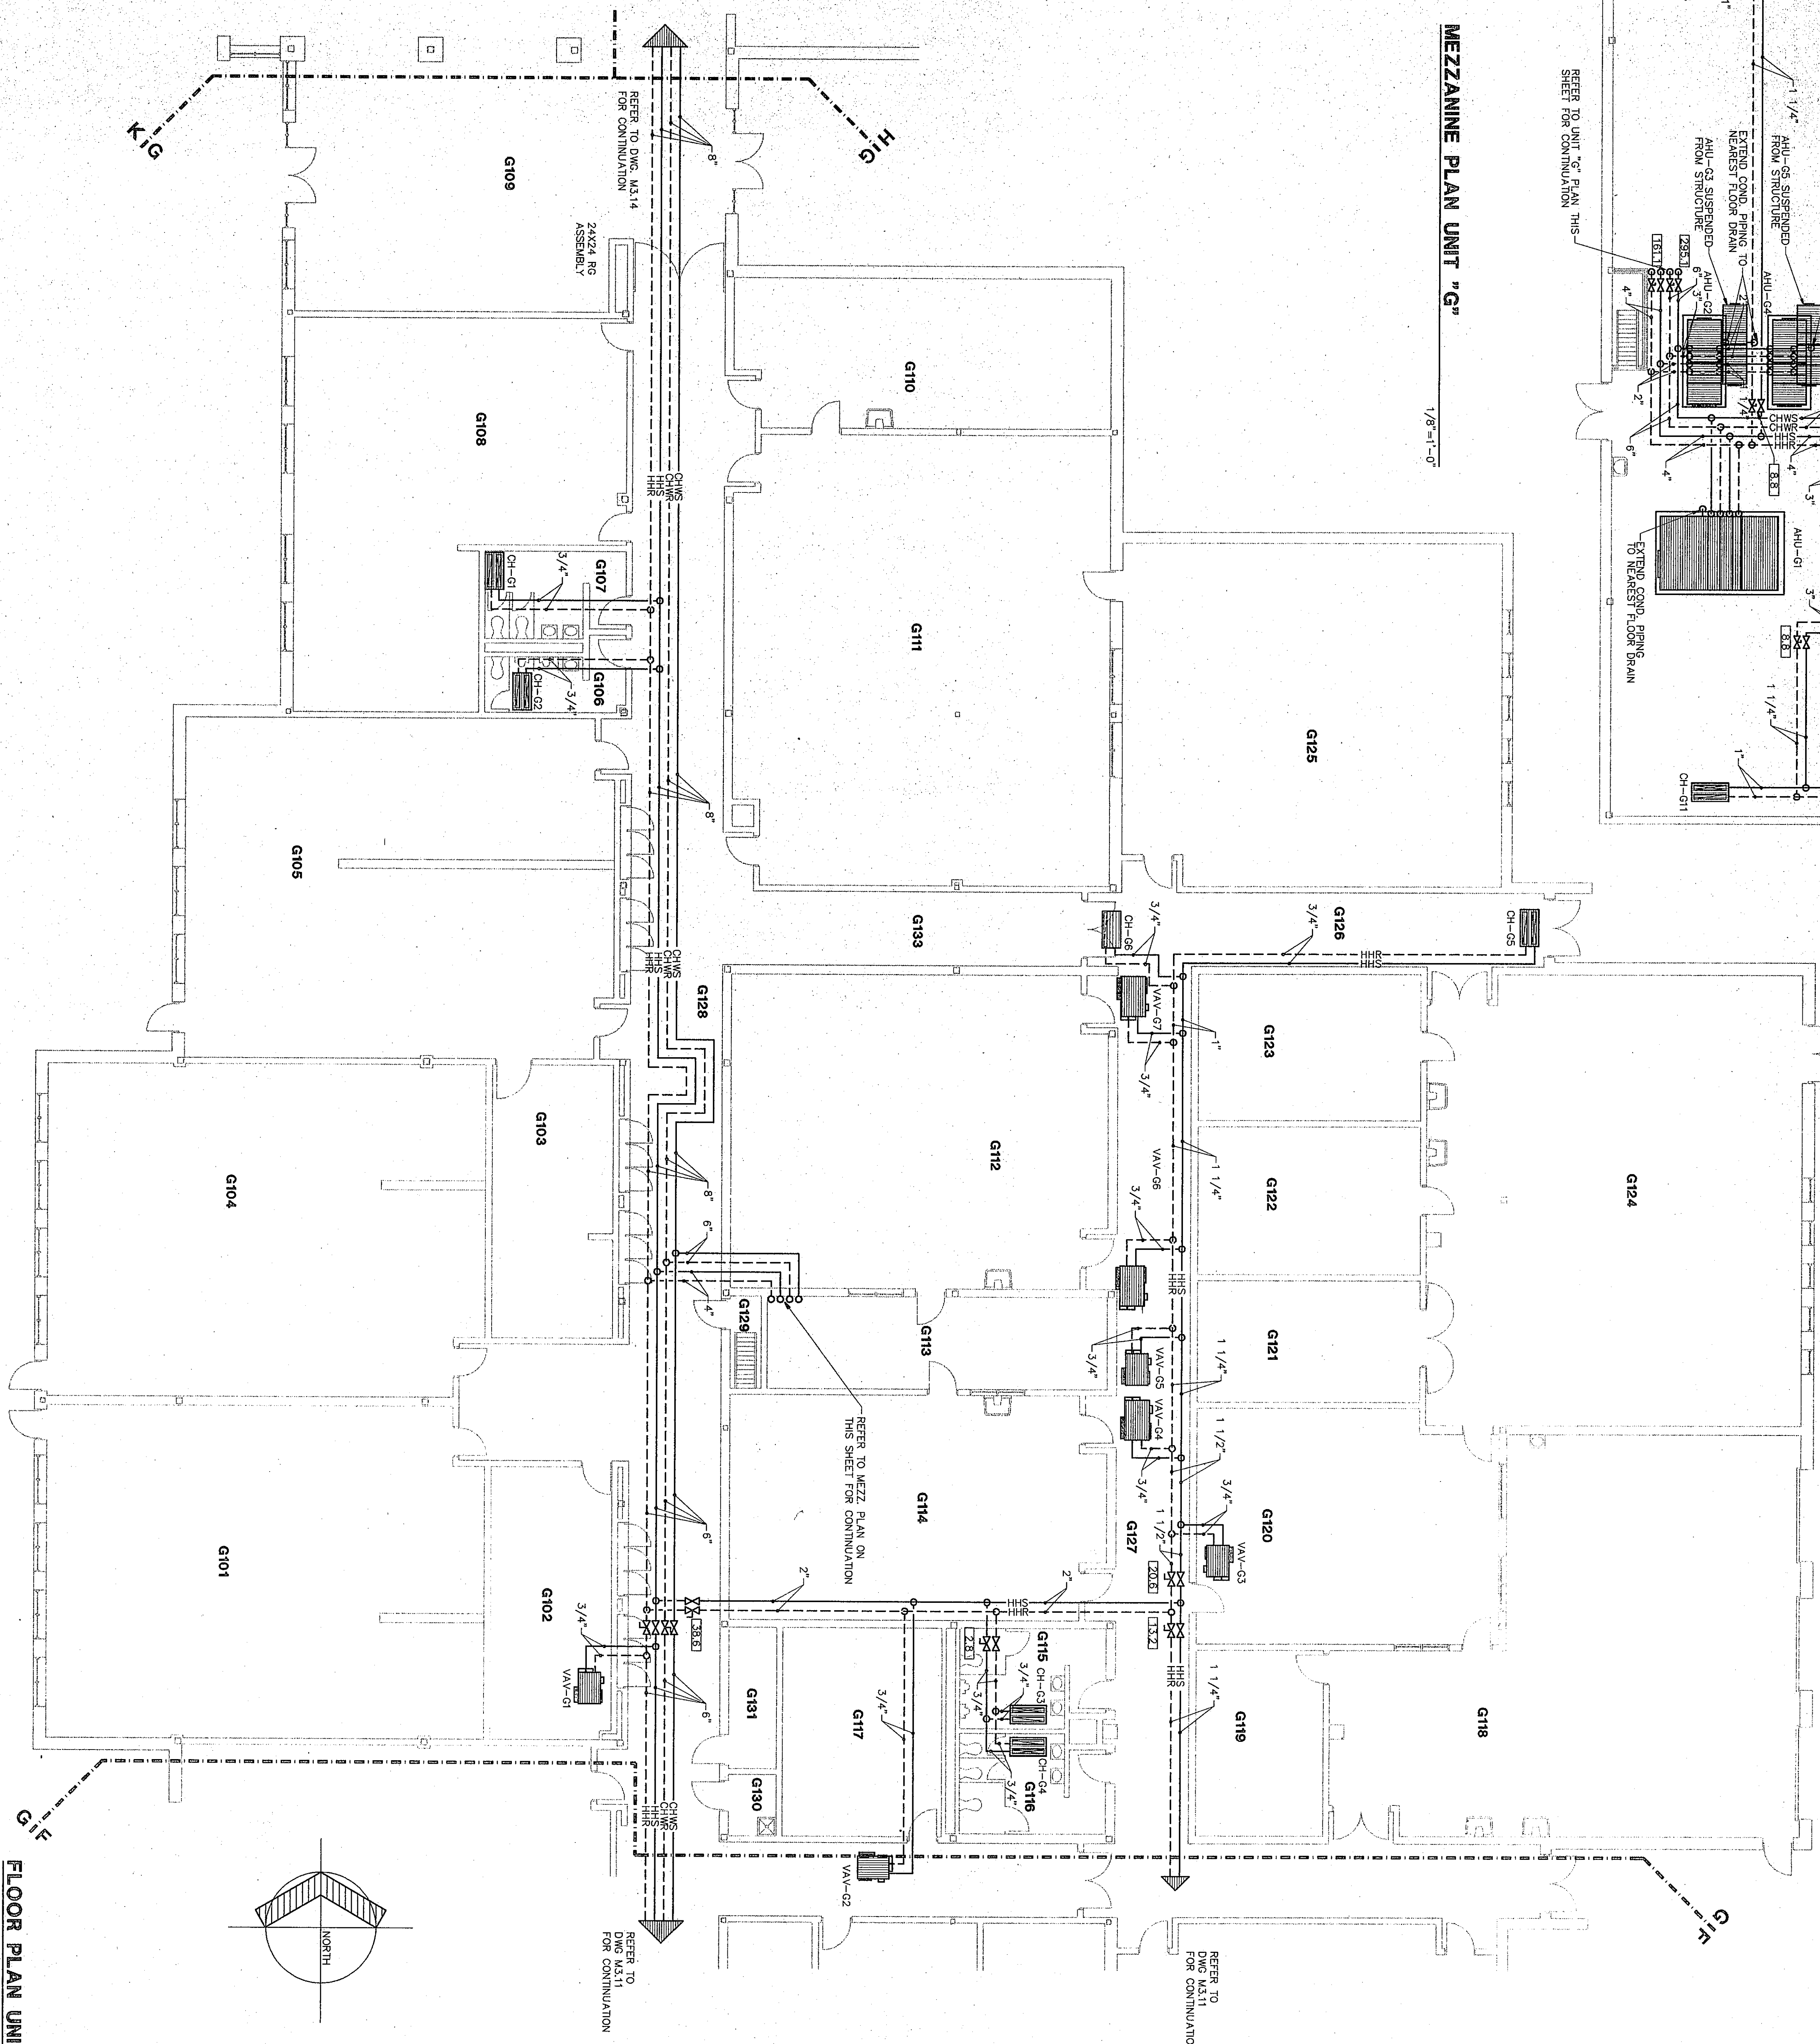

ROOM LEGEND "G"

ROOM NO.	ROOM NAME	AREA S.F.	CEILING HEIGHT
G101	20/20 LAB	1700	9'-4"
G102	20/20 LAB	1700	9'-4"
G103	20/20 LAB	1700	9'-4"
G104	20/20 LAB	1700	9'-4"
G105	20/20 LAB	1700	9'-4"
G106	20/20 LAB	1700	9'-4"
G107	20/20 LAB	1700	9'-4"
G108	20/20 LAB	1700	9'-4"
G109	20/20 LAB	1700	9'-4"
G110	20/20 LAB	1700	9'-4"
G111	20/20 LAB	1700	9'-4"
G112	20/20 LAB	1700	9'-4"
G113	20/20 LAB	1700	9'-4"
G114	20/20 LAB	1700	9'-4"
G115	20/20 LAB	1700	9'-4"
G116	20/20 LAB	1700	9'-4"
G117	20/20 LAB	1700	9'-4"
G118	20/20 LAB	1700	9'-4"
G119	20/20 LAB	1700	9'-4"
G120	20/20 LAB	1700	9'-4"
G121	20/20 LAB	1700	9'-4"
G122	20/20 LAB	1700	9'-4"
G123	20/20 LAB	1700	9'-4"
G124	20/20 LAB	1700	9'-4"
G125	20/20 LAB	1700	9'-4"
G126	20/20 LAB	1700	9'-4"
G127	20/20 LAB	1700	9'-4"
G128	20/20 LAB	1700	9'-4"
G129	20/20 LAB	1700	9'-4"
G130	20/20 LAB	1700	9'-4"
G131	20/20 LAB	1700	9'-4"
G132	20/20 LAB	1700	9'-4"
G133	20/20 LAB	1700	9'-4"

FLOOR PLAN UNIT "G"

1/8"=1'-0"


HEATING PLAN UNIT "G"

DRAWN BY: SCB COMM. NO.: 95067.00
 CHECKED BY: CAM DATE: APRIL 21, 1997

M3.13

REVISIONS NO. DATE

Fanning/Howey Associates, Inc.
 Architects Engineers Consultants

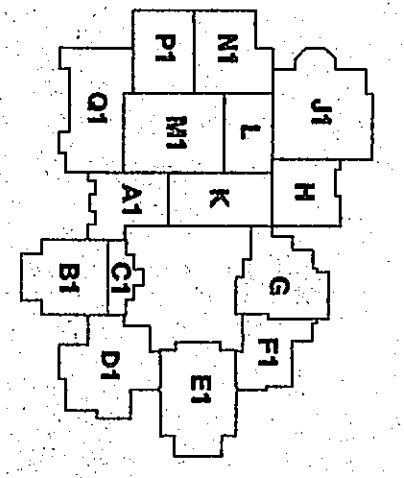

THE NEW CHESTERTON HIGH SCHOOL
 FOR THE
 DUNELAND SCHOOL CORPORATION
 CHESTERTON, INDIANA

Copyright 1997 by Fanning/Howey Associates, Inc.