

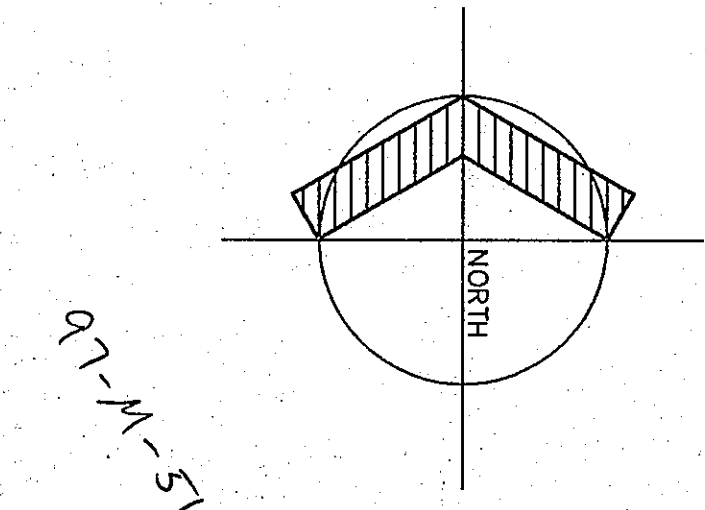


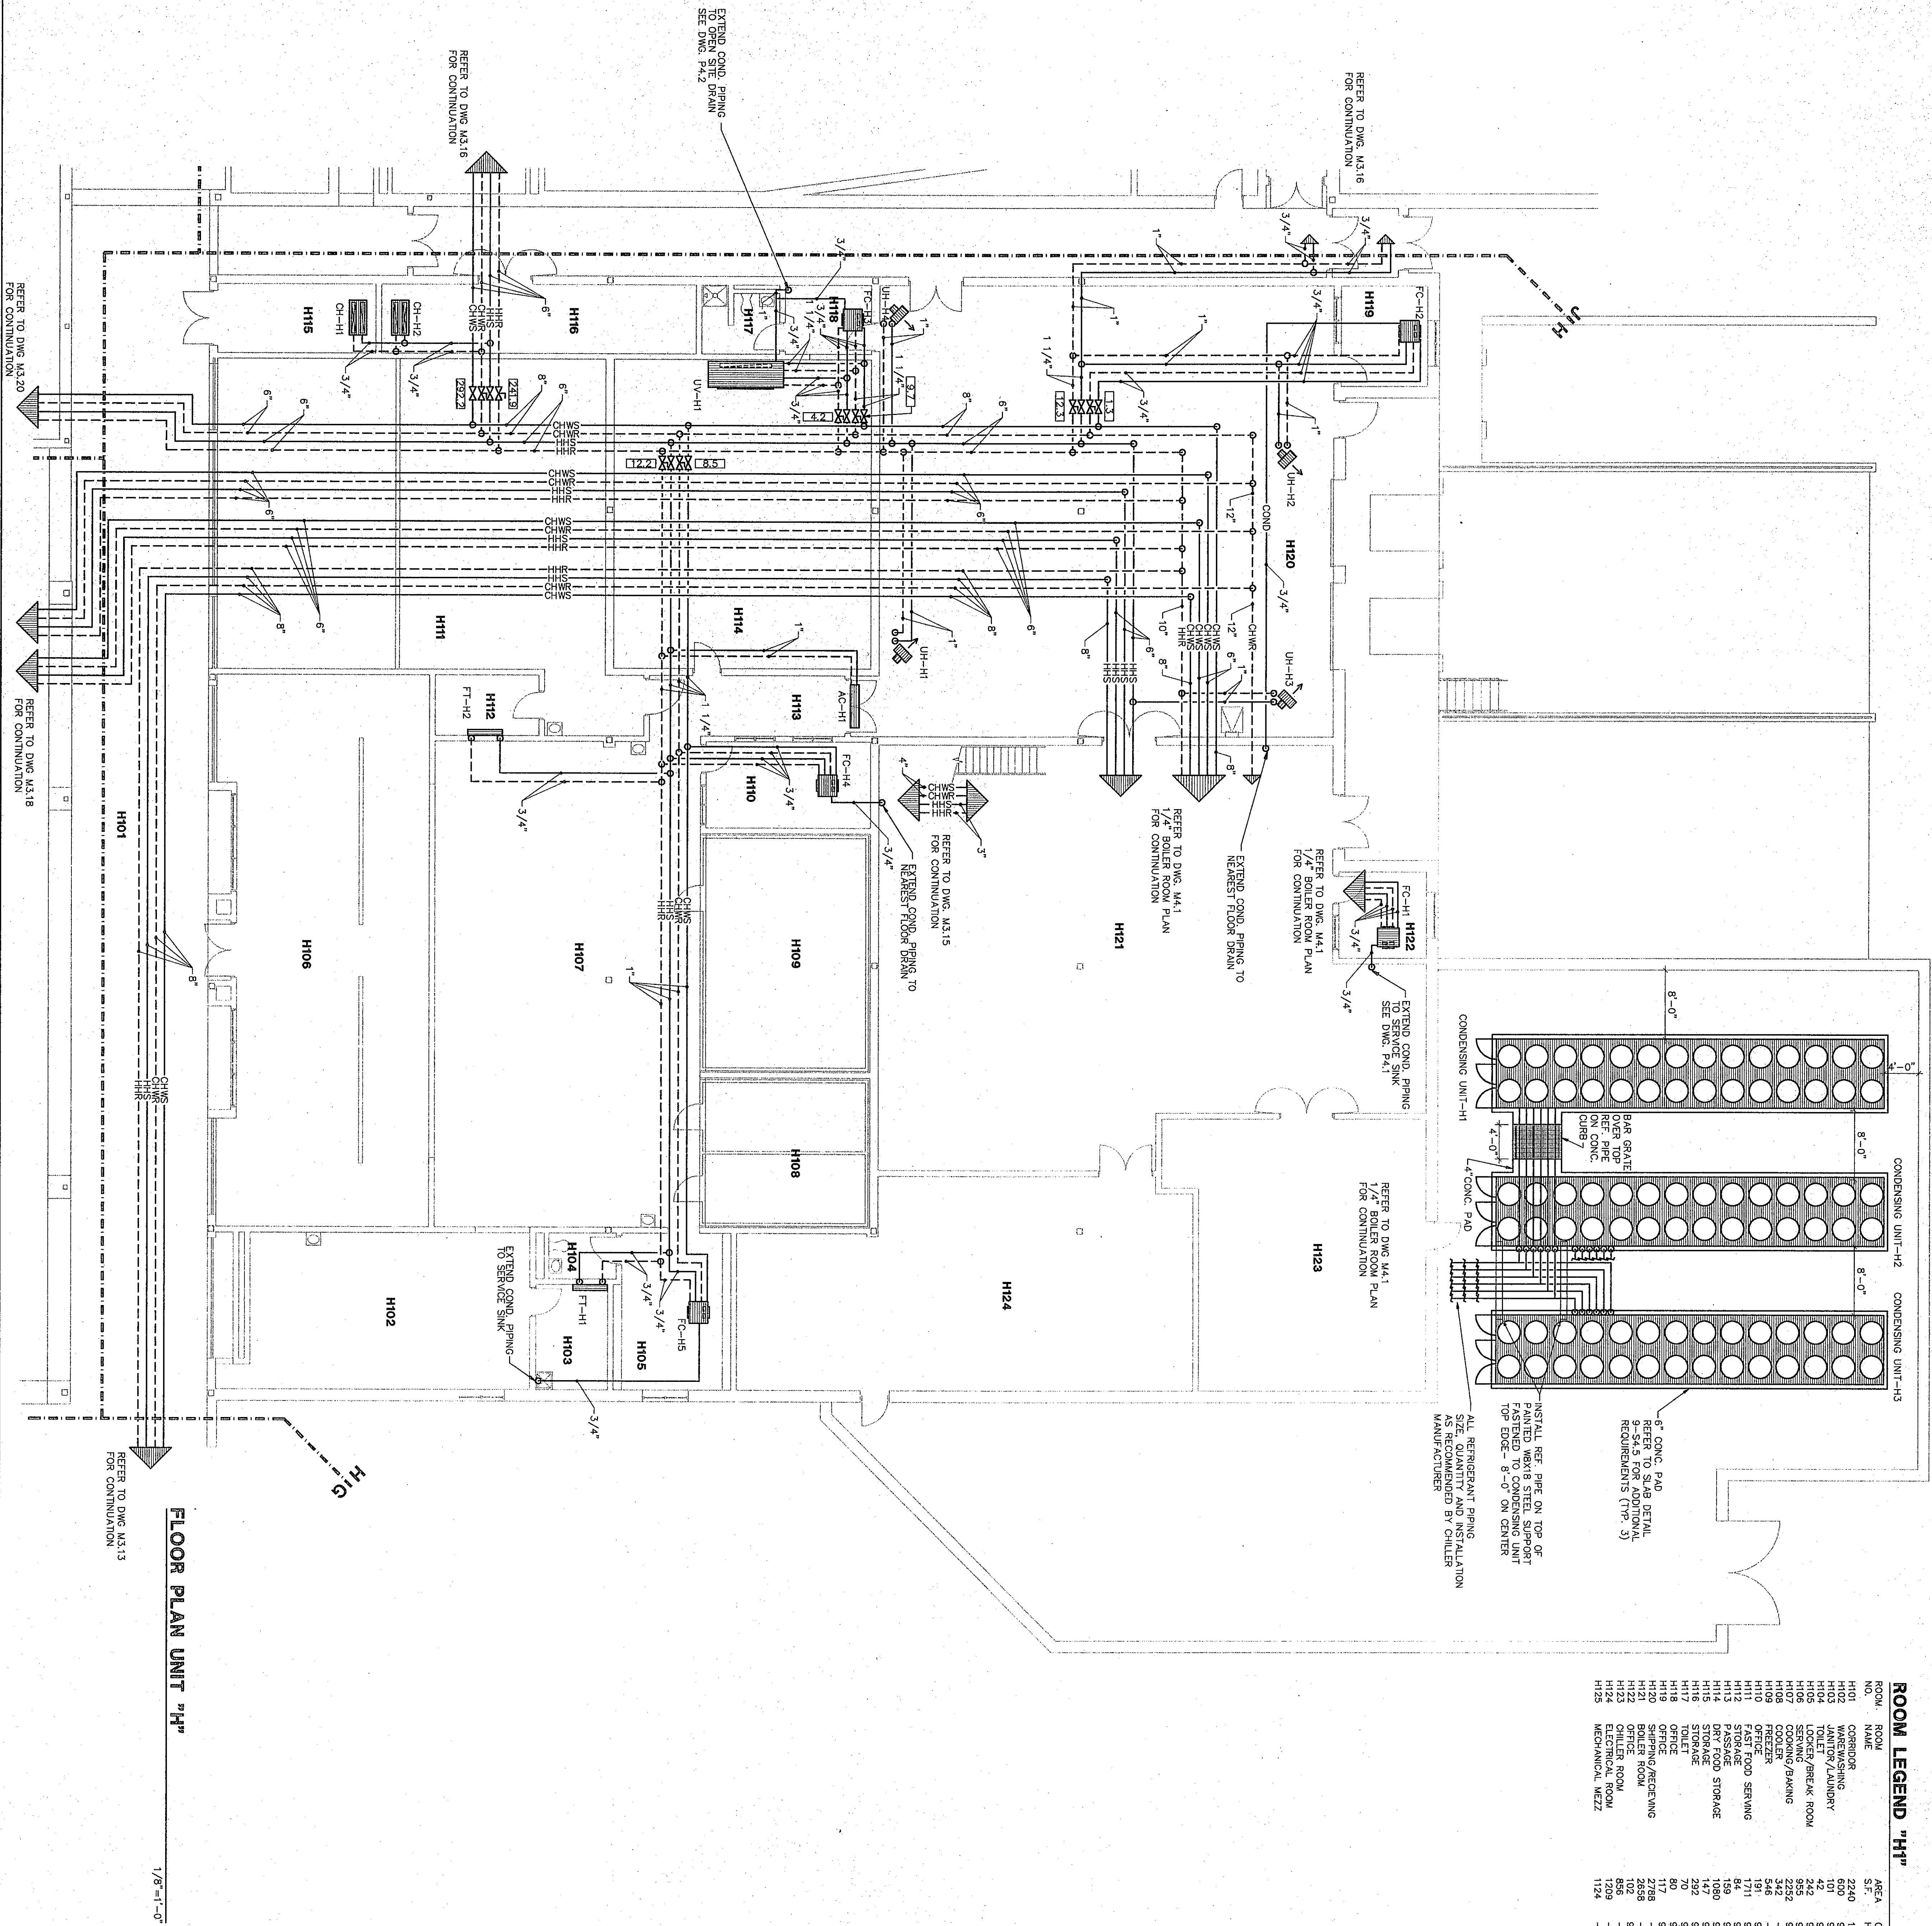

HEATING PLAN UNIT "H"
 DRAWN BY: SCB
 CHECKED BY: CAM
M3.14

COMM. NO.: 95067.00
 DATE: APRIL 21, 1997
 REVISIONS NO. DATE

Fanning/Howey Associates, Inc.
Architects Engineers Consultants

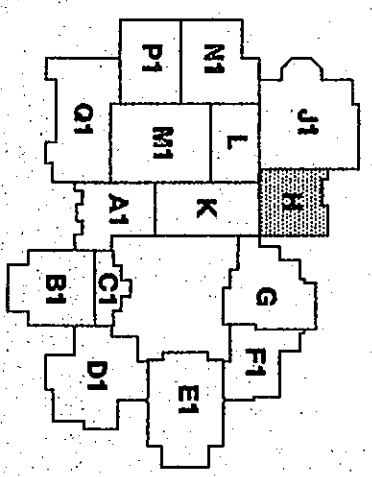

THE NEW
CHESTERTON HIGH SCHOOL
 FOR THE
 DUNELAND SCHOOL CORPORATION
 CHESTERTON, INDIANA

COPYRIGHT 1997 BY FANNING/HOWEY ASSOCIATES, INC.