


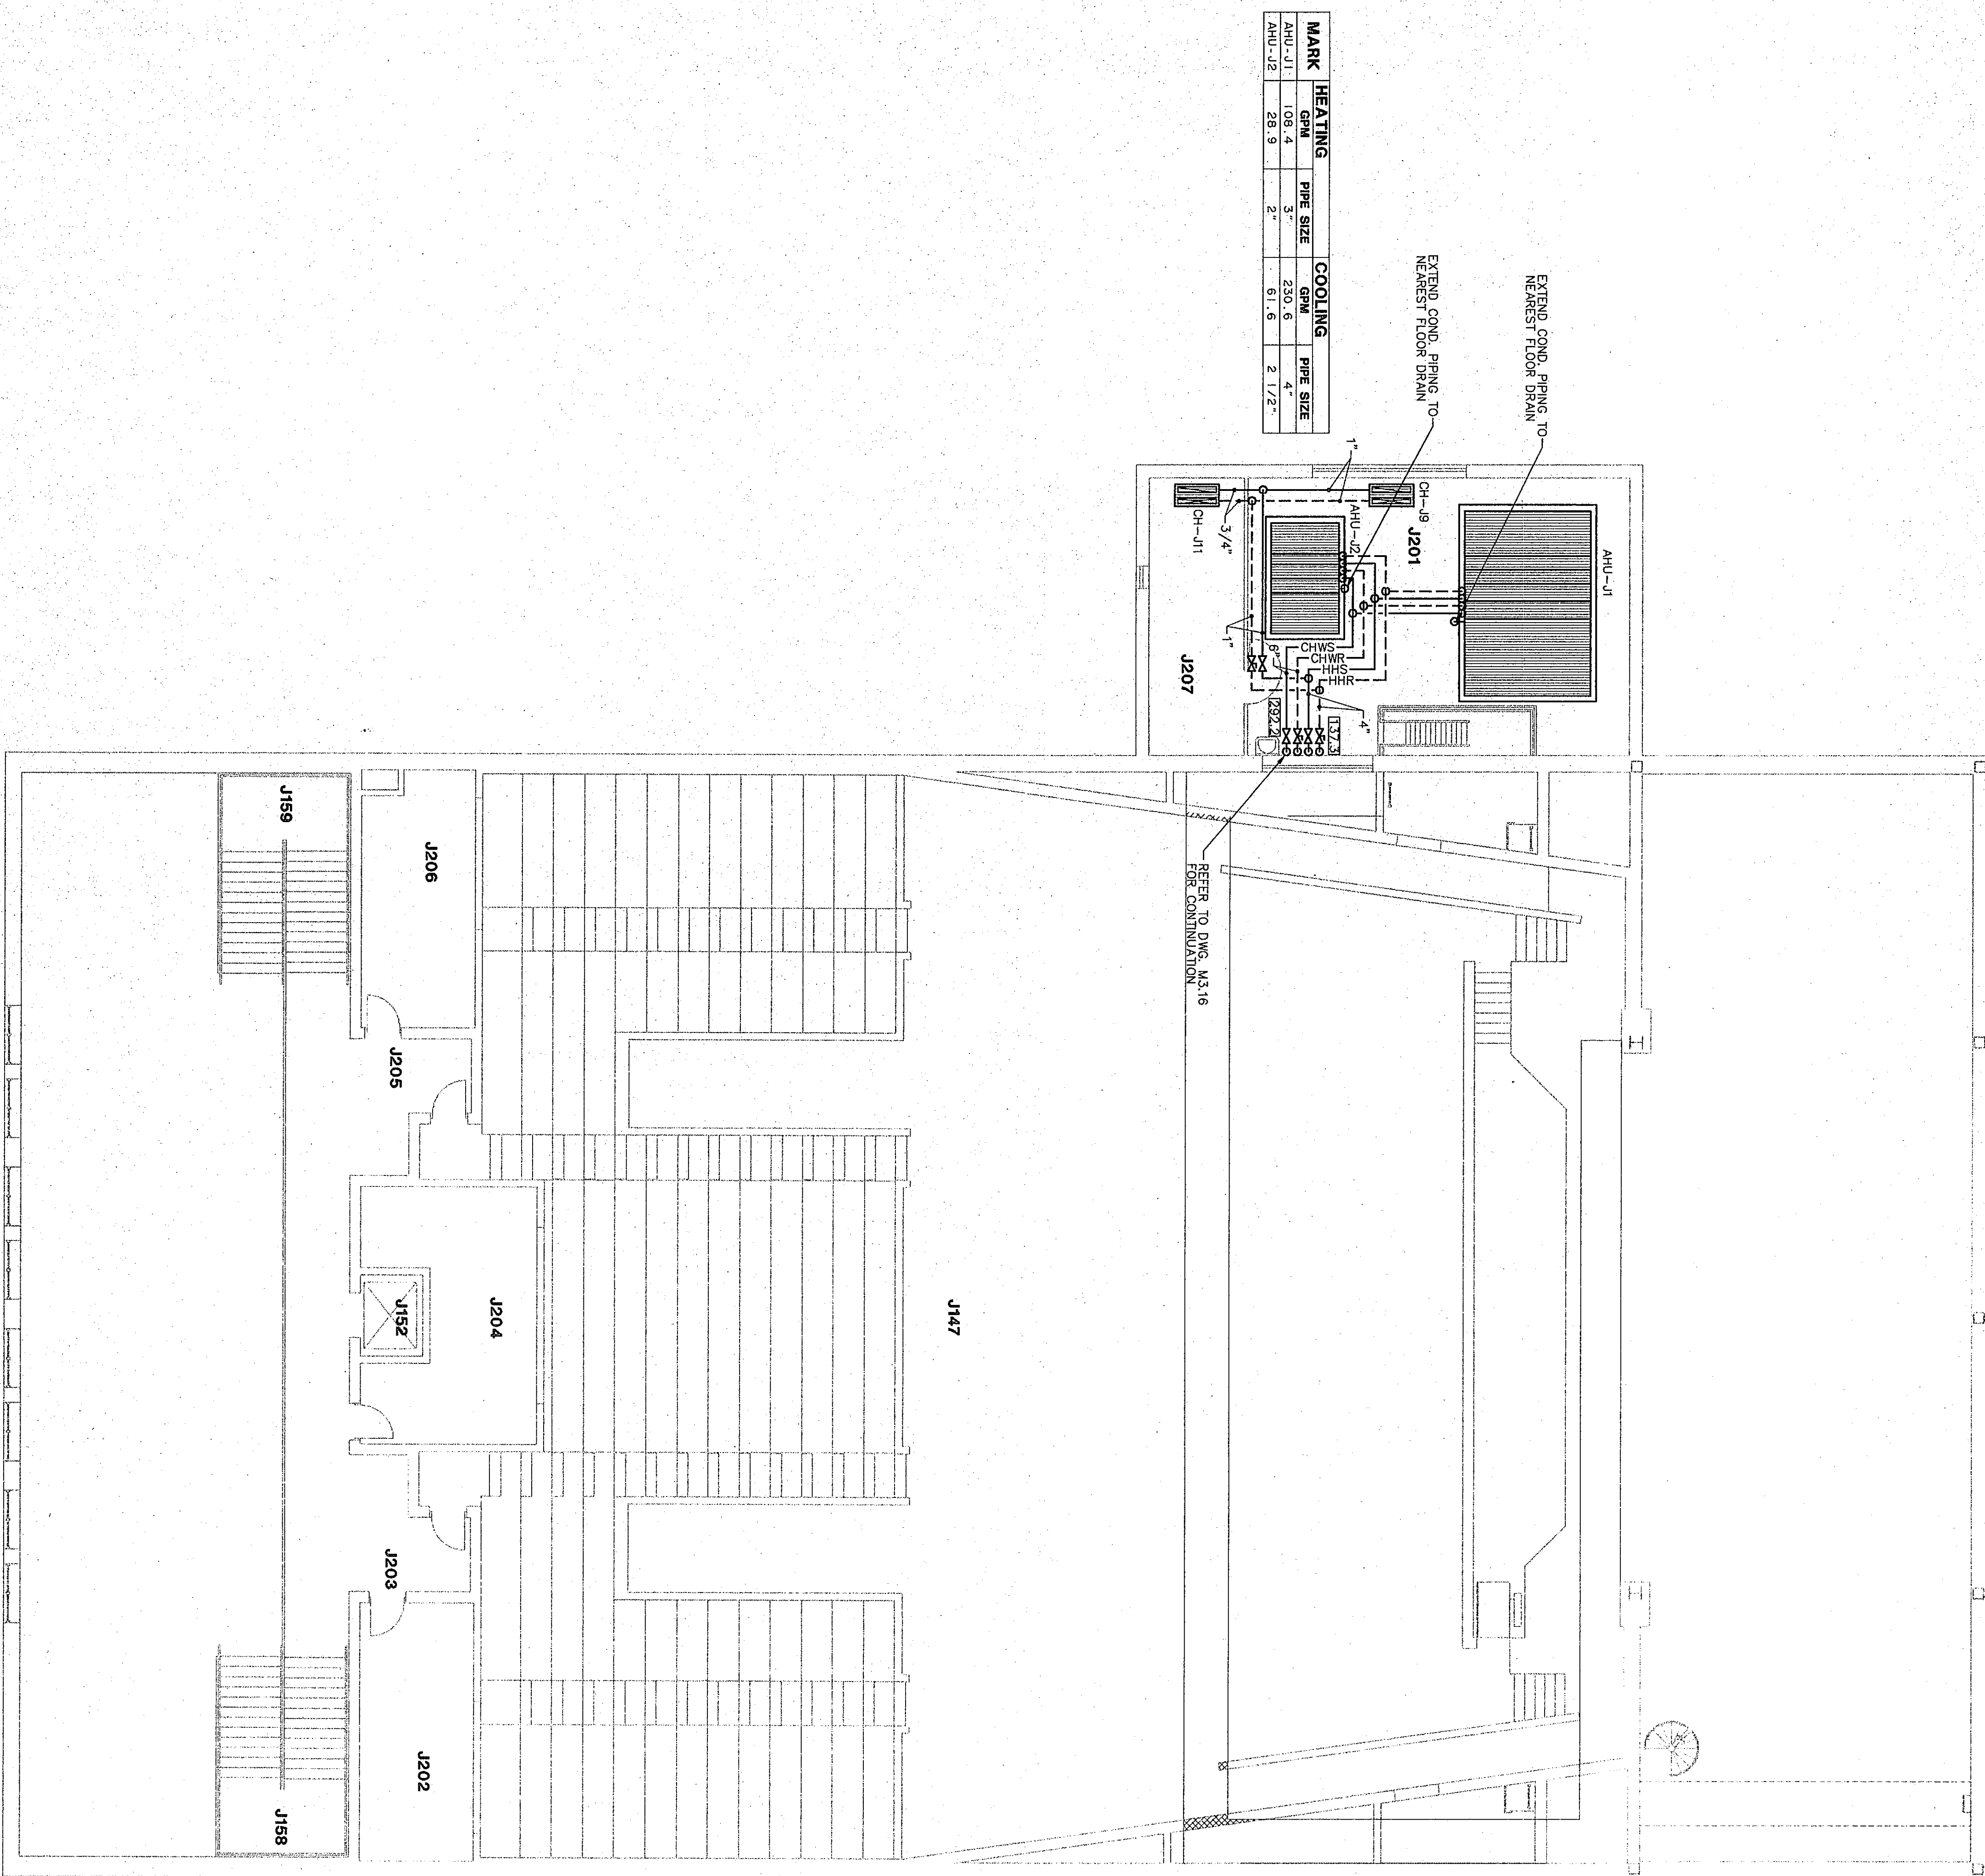


MARK	HEATING	PIPE SIZE	COOLING	PIPE SIZE
AHU-J1	108.4	3"	230.6	4"
AHU-J2	68.4	2"	61.0	2 1/2"

ROOM NO.	ROOM NAME	AREA S.F.	CEILING HEIGHT
J201	MECHANICAL MEZZANINE	808	11'-0"
J202	LEFT SPOT ROOM	234	9'-4"
J203	RIGHT SPOT ROOM	234	9'-4"
J204	SOUND ROOM	318	9'-4"
J205	BALCONY ROOM	112	9'-4"
J206	BALCONY ROOM	113	9'-4"
J207	ELECTRICAL ROOM	113	9'-4"
J208	TRANSMITTER ROOM	103	9'-4"

FLOOR PLAN UNIT "J2"

1/8"=1'-0"

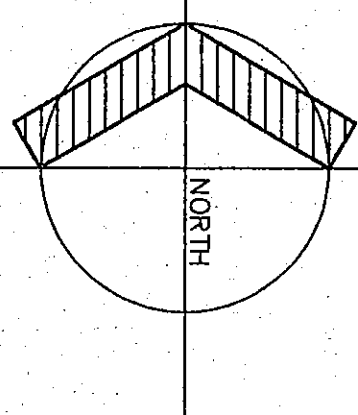


97-M-54

HEATING PLAN UNIT "J2"


DRAWN BY: SCB COMM. NO.: 95067.00
CHECKED BY: CAM DATE: APRIL 21, 1997

M3.17

REVISIONS NO. DATE

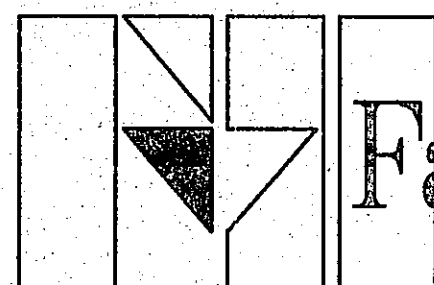

Fanning/Howey
Associates, Inc.
Architects Engineers Consultants

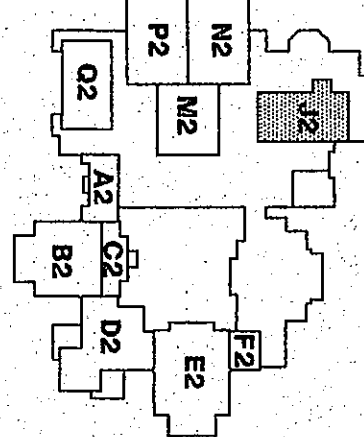

THE NEW
CHESTERTON HIGH SCHOOL
FOR THE
DUNELAND SCHOOL CORPORATION
CHESTERTON, INDIANA

COPYRIGHT 1997 BY FANNING/HOWEY ASSOCIATES, INC.

