


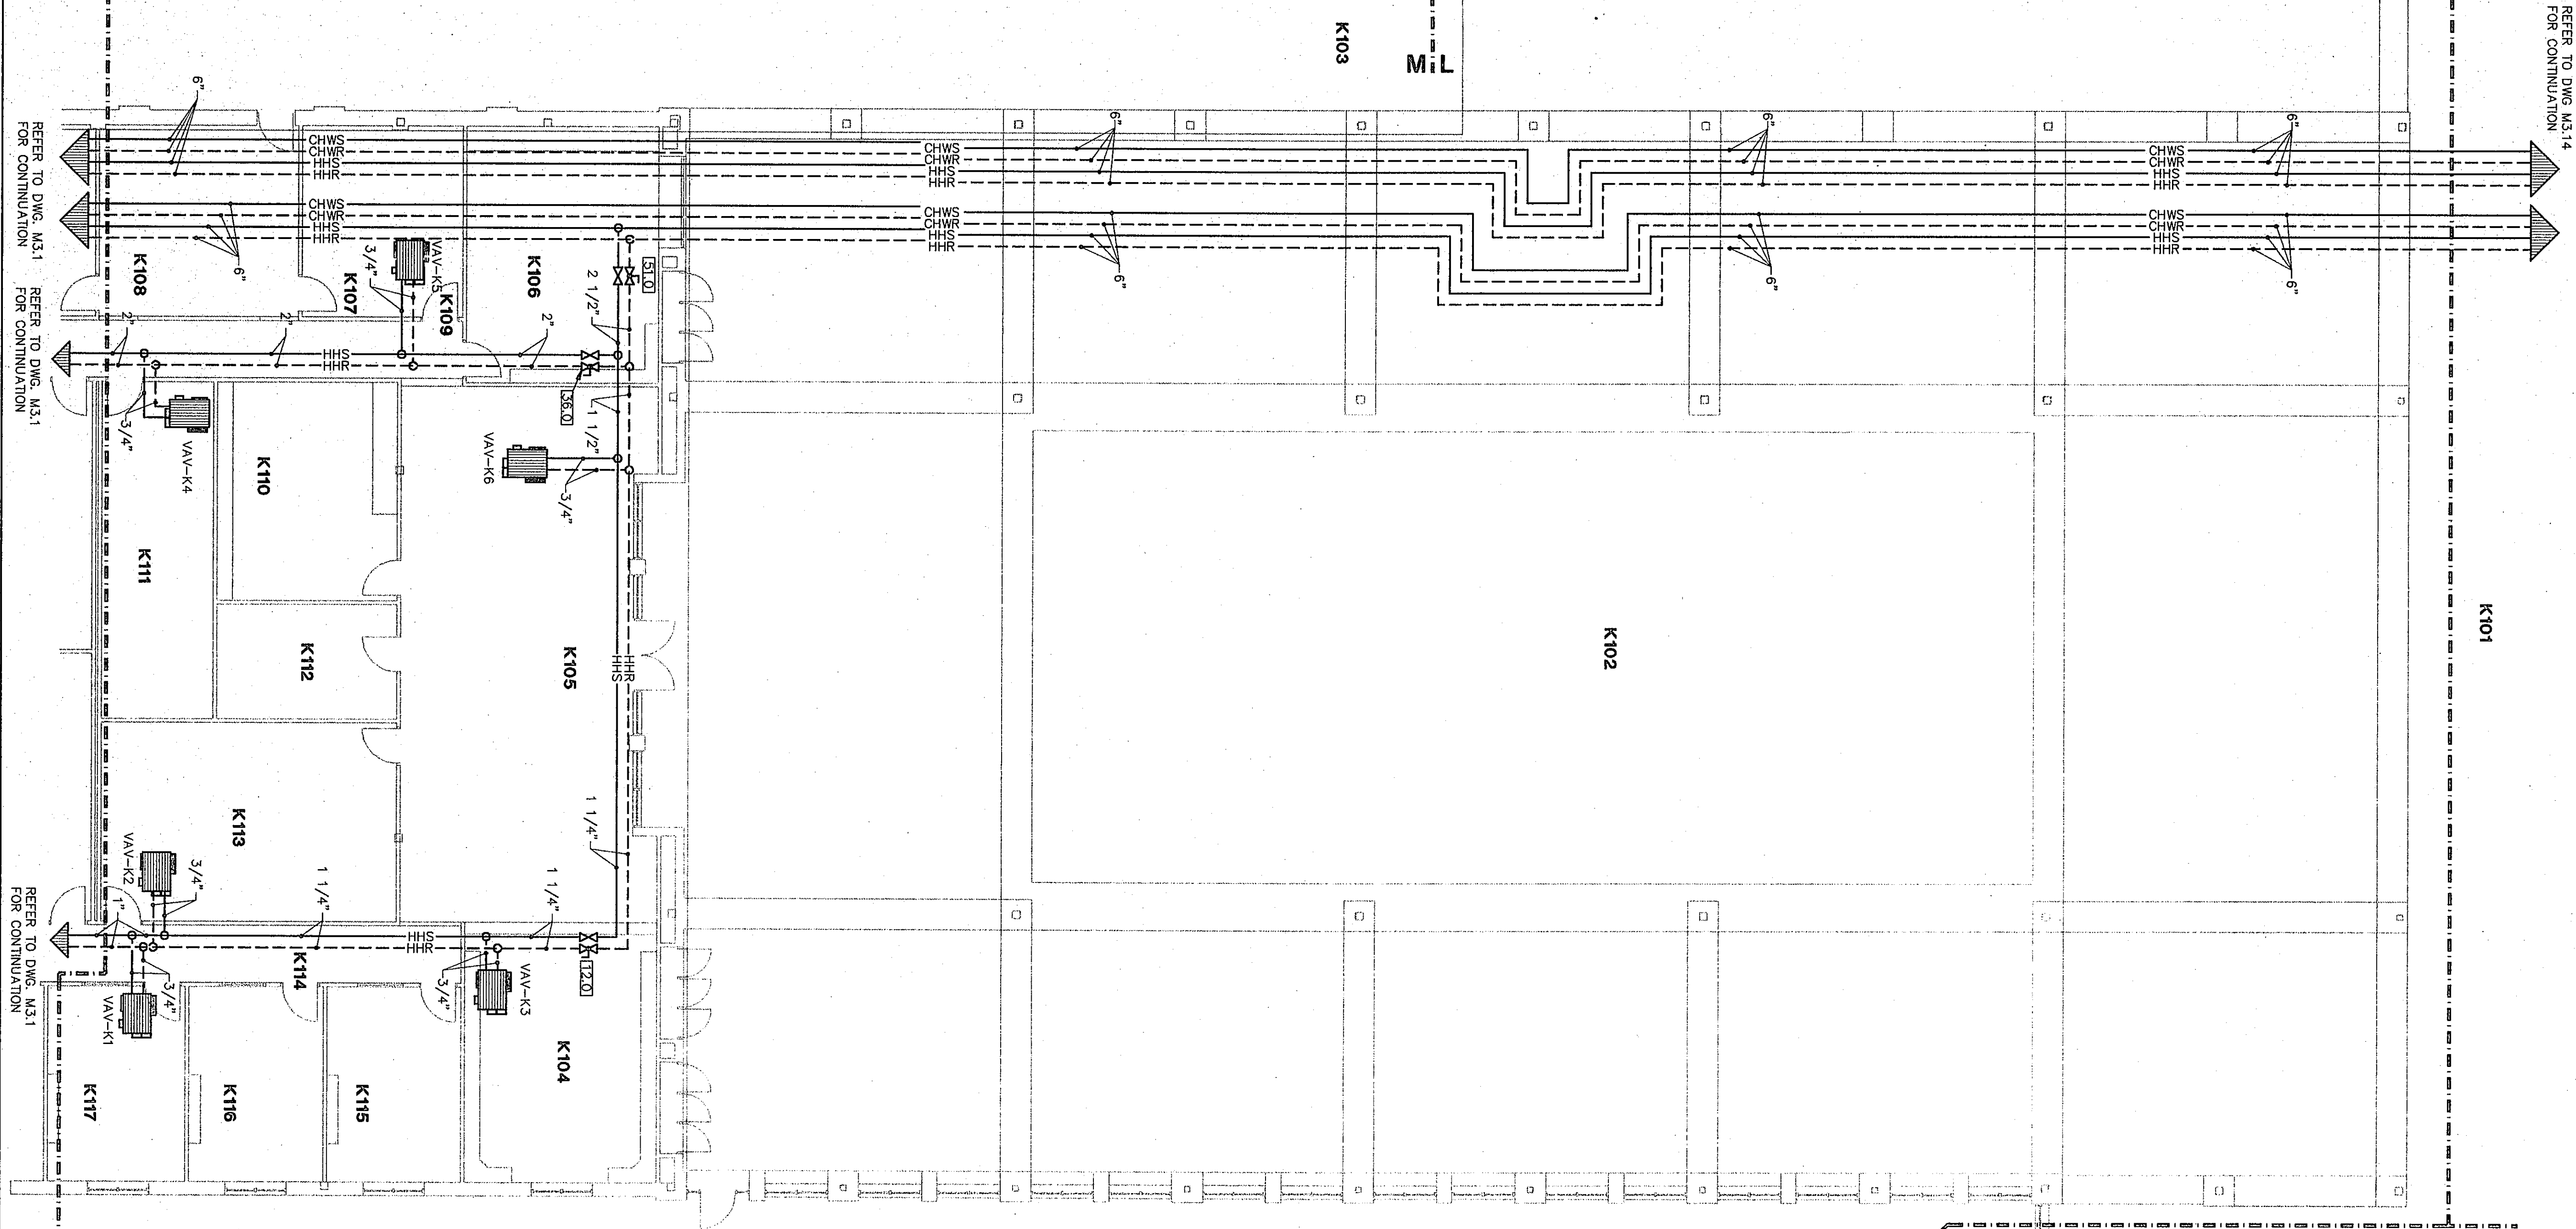


ROOM LEGEND "K"

ROOM	AREA	CEILING
K101	NOT USED	9'-4"
K102	STUDENT DINING	13'-6"
K103	CORRIDOR / CAREER CENTER	10'-0"
K104	RECEPTIONIST	9'-4"
K105	RECEPTIONIST	9'-4"
K106	RECEPTIONIST	9'-4"
K107	RECEPTIONIST	9'-4"
K108	RECEPTIONIST	9'-4"
K109	RECEPTIONIST	9'-4"
K110	RECEPTIONIST	9'-4"
K111	RECEPTIONIST	9'-4"
K112	RECEPTIONIST	9'-4"
K113	RECEPTIONIST	9'-4"
K114	RECEPTIONIST	9'-4"
K115	RECEPTIONIST	9'-4"
K116	RECEPTIONIST	9'-4"
K117	RECEPTIONIST	9'-4"

FLOOR PLAN UNIT "K"

1/8"=1'-0"

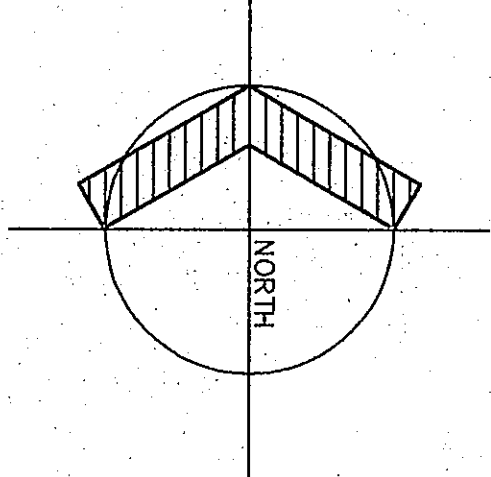

67-A-55

HEATING PLAN UNIT "K"

DRAWN BY: SCB
CHECKED BY: CAM


COMM. NO.: 95067.00
DATE: APRIL 21, 1997

M3.18

REVISIONS NO. DATE

Fanning/Howey Associates, Inc.

Architects Engineers Consultants

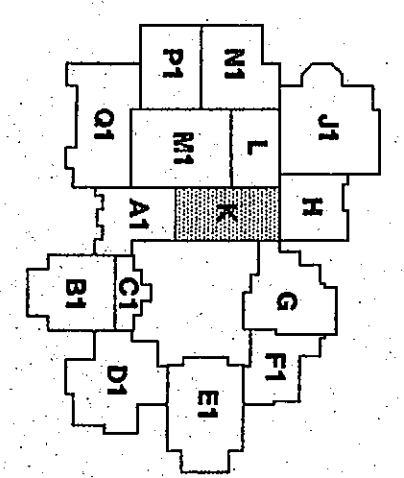

THE NEW CHESTERTON HIGH SCHOOL FOR THE DUNELAND SCHOOL CORPORATION CHESTERTON, INDIANA

COPYRIGHT 1997 BY FANNING/HOWEY ASSOCIATES, INC.

Professional Engineer Seal for Fanning/Howey Associates, Inc., State of Indiana, License No. 12030, dated 10/1/96.