

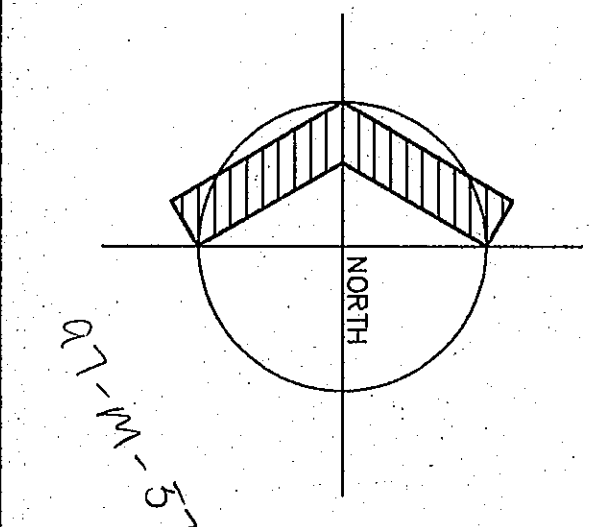


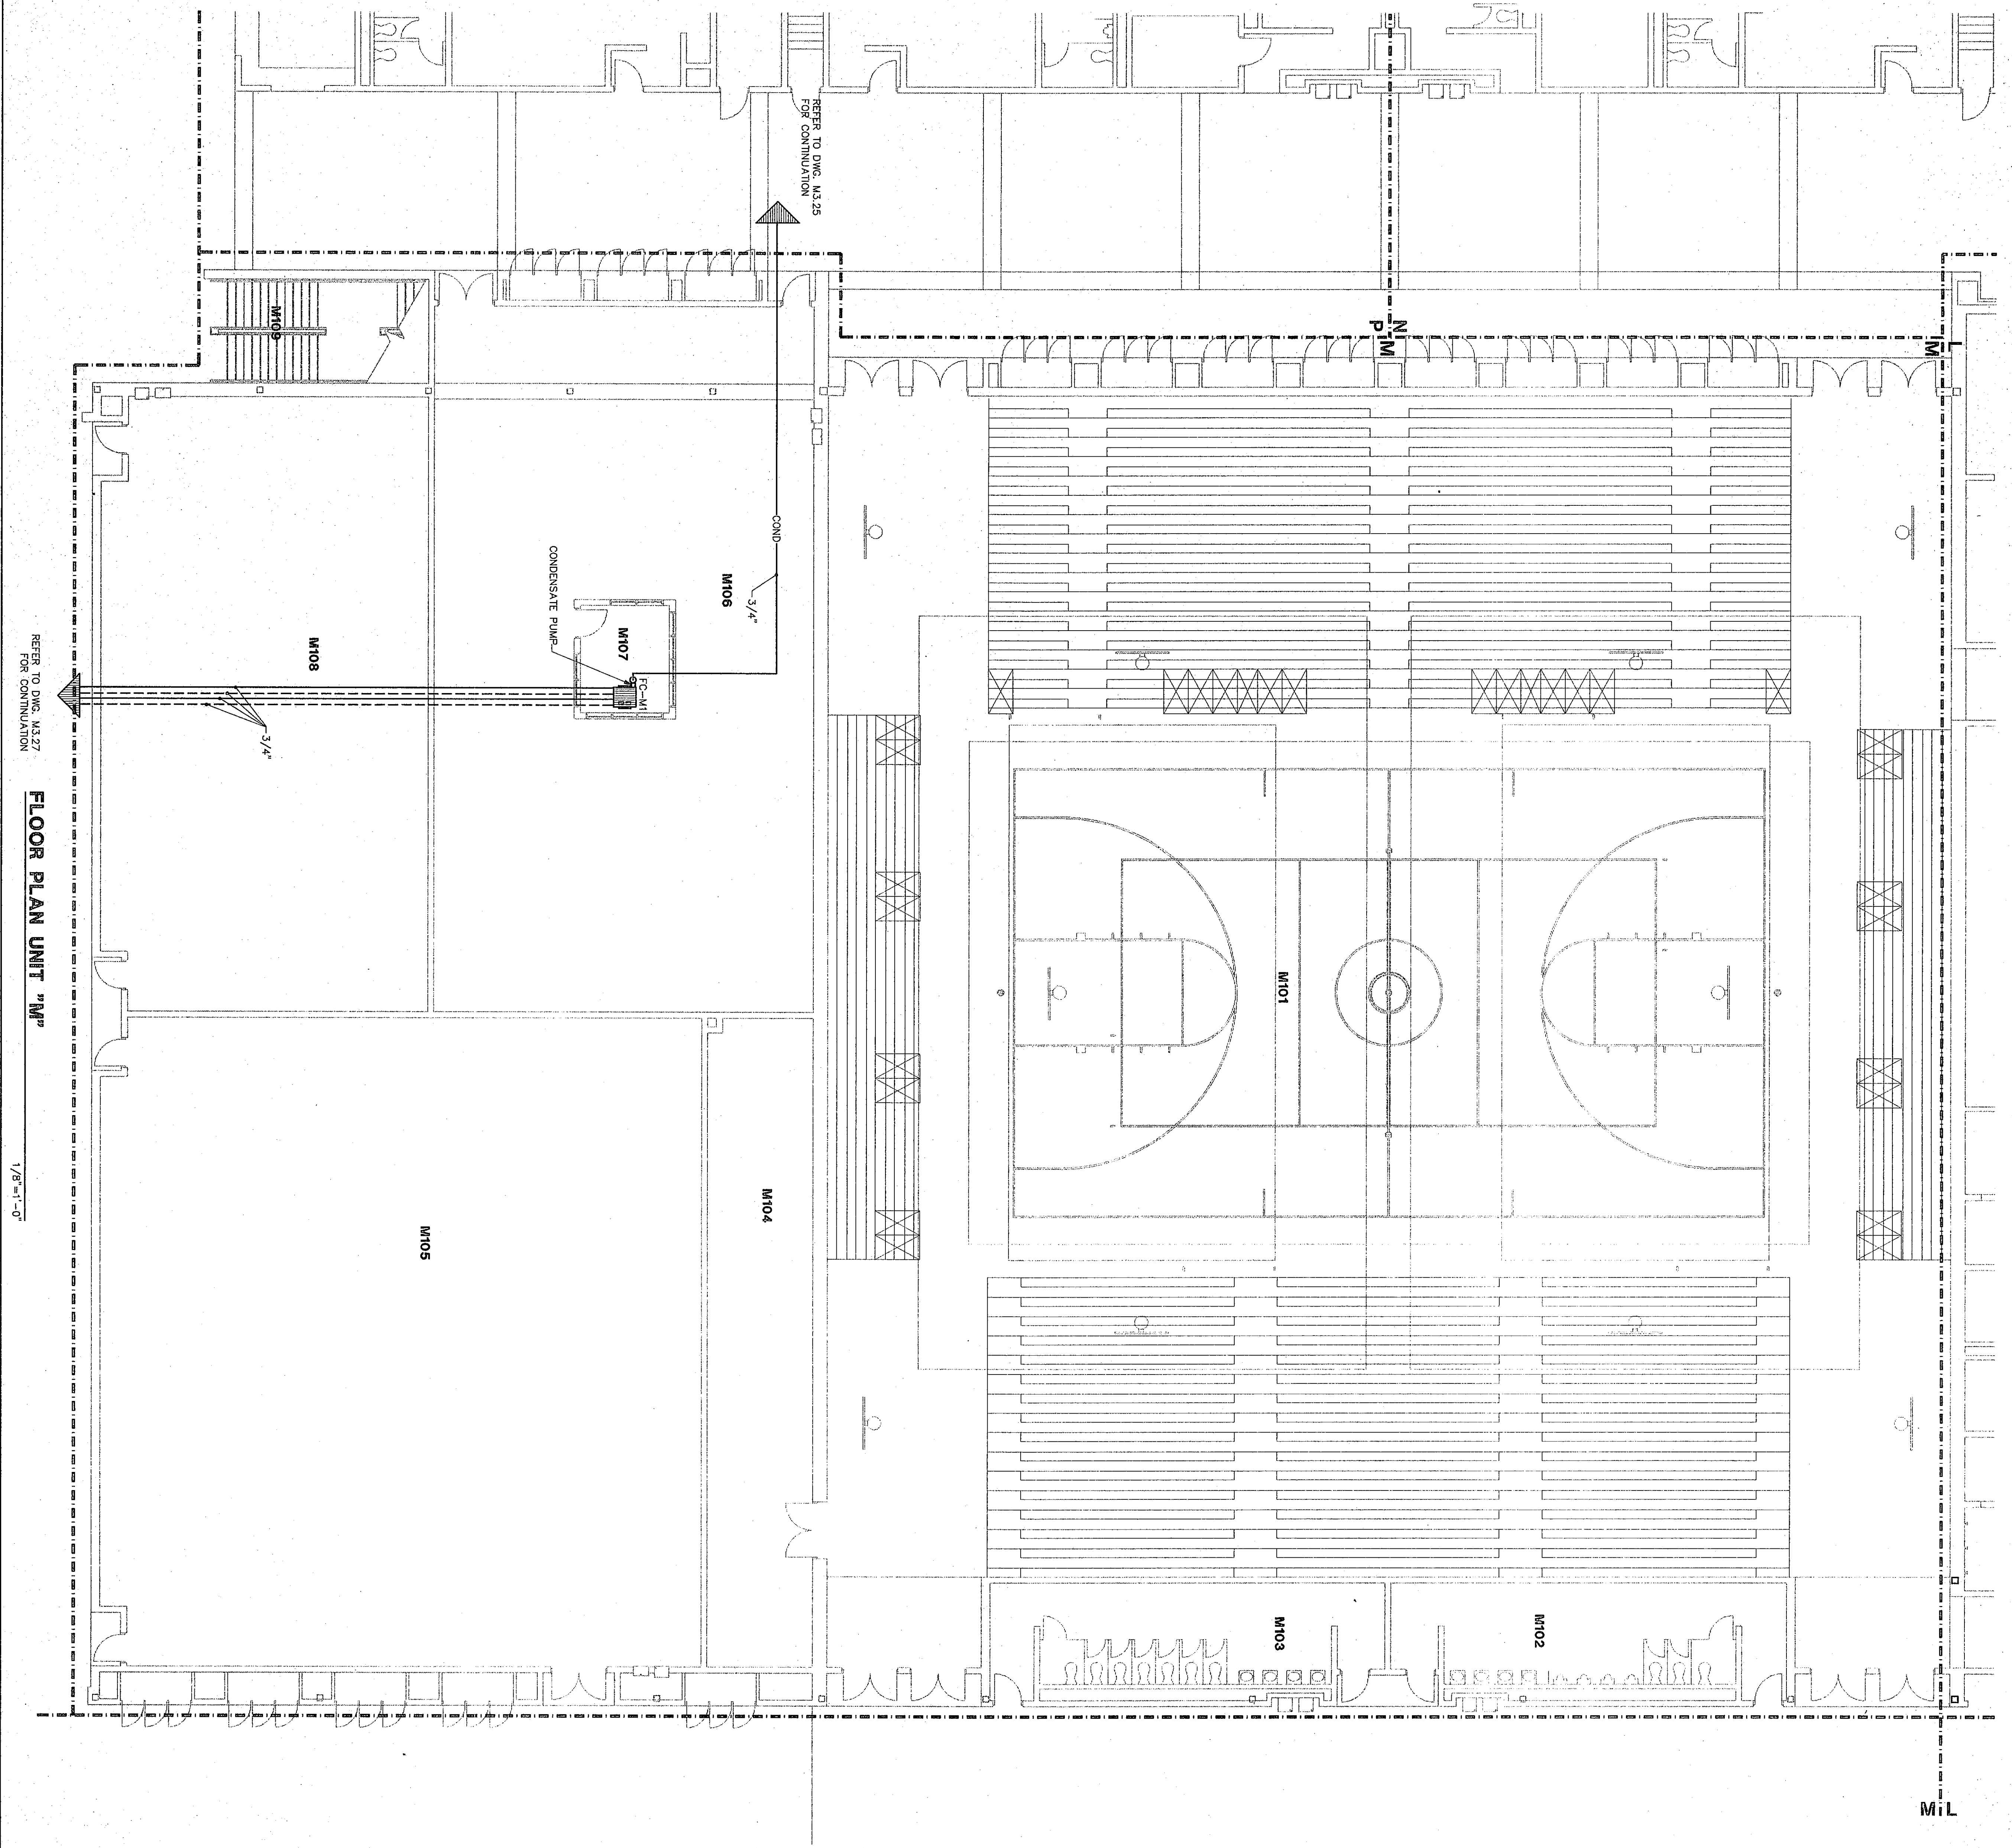

CHESTERTON HIGH SCHOOL
95067.00

HEATING PLAN UNIT "M"	
DRAWN BY: SCB	COMM. NO.: 95067.00
CHECKED BY: CAM	DATE: APRIL 21, 1997
M3.21	REVISIONS NO. DATE

Fanning/Howey
Associates, Inc.
Architects Engineers Consultants

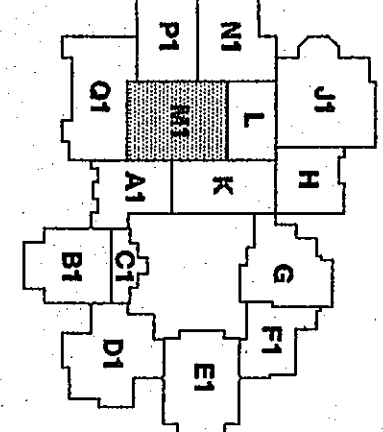

THE NEW
CHESTERTON HIGH SCHOOL
FOR THE
DUNELAND SCHOOL CORPORATION
CHESTERTON, INDIANA

