



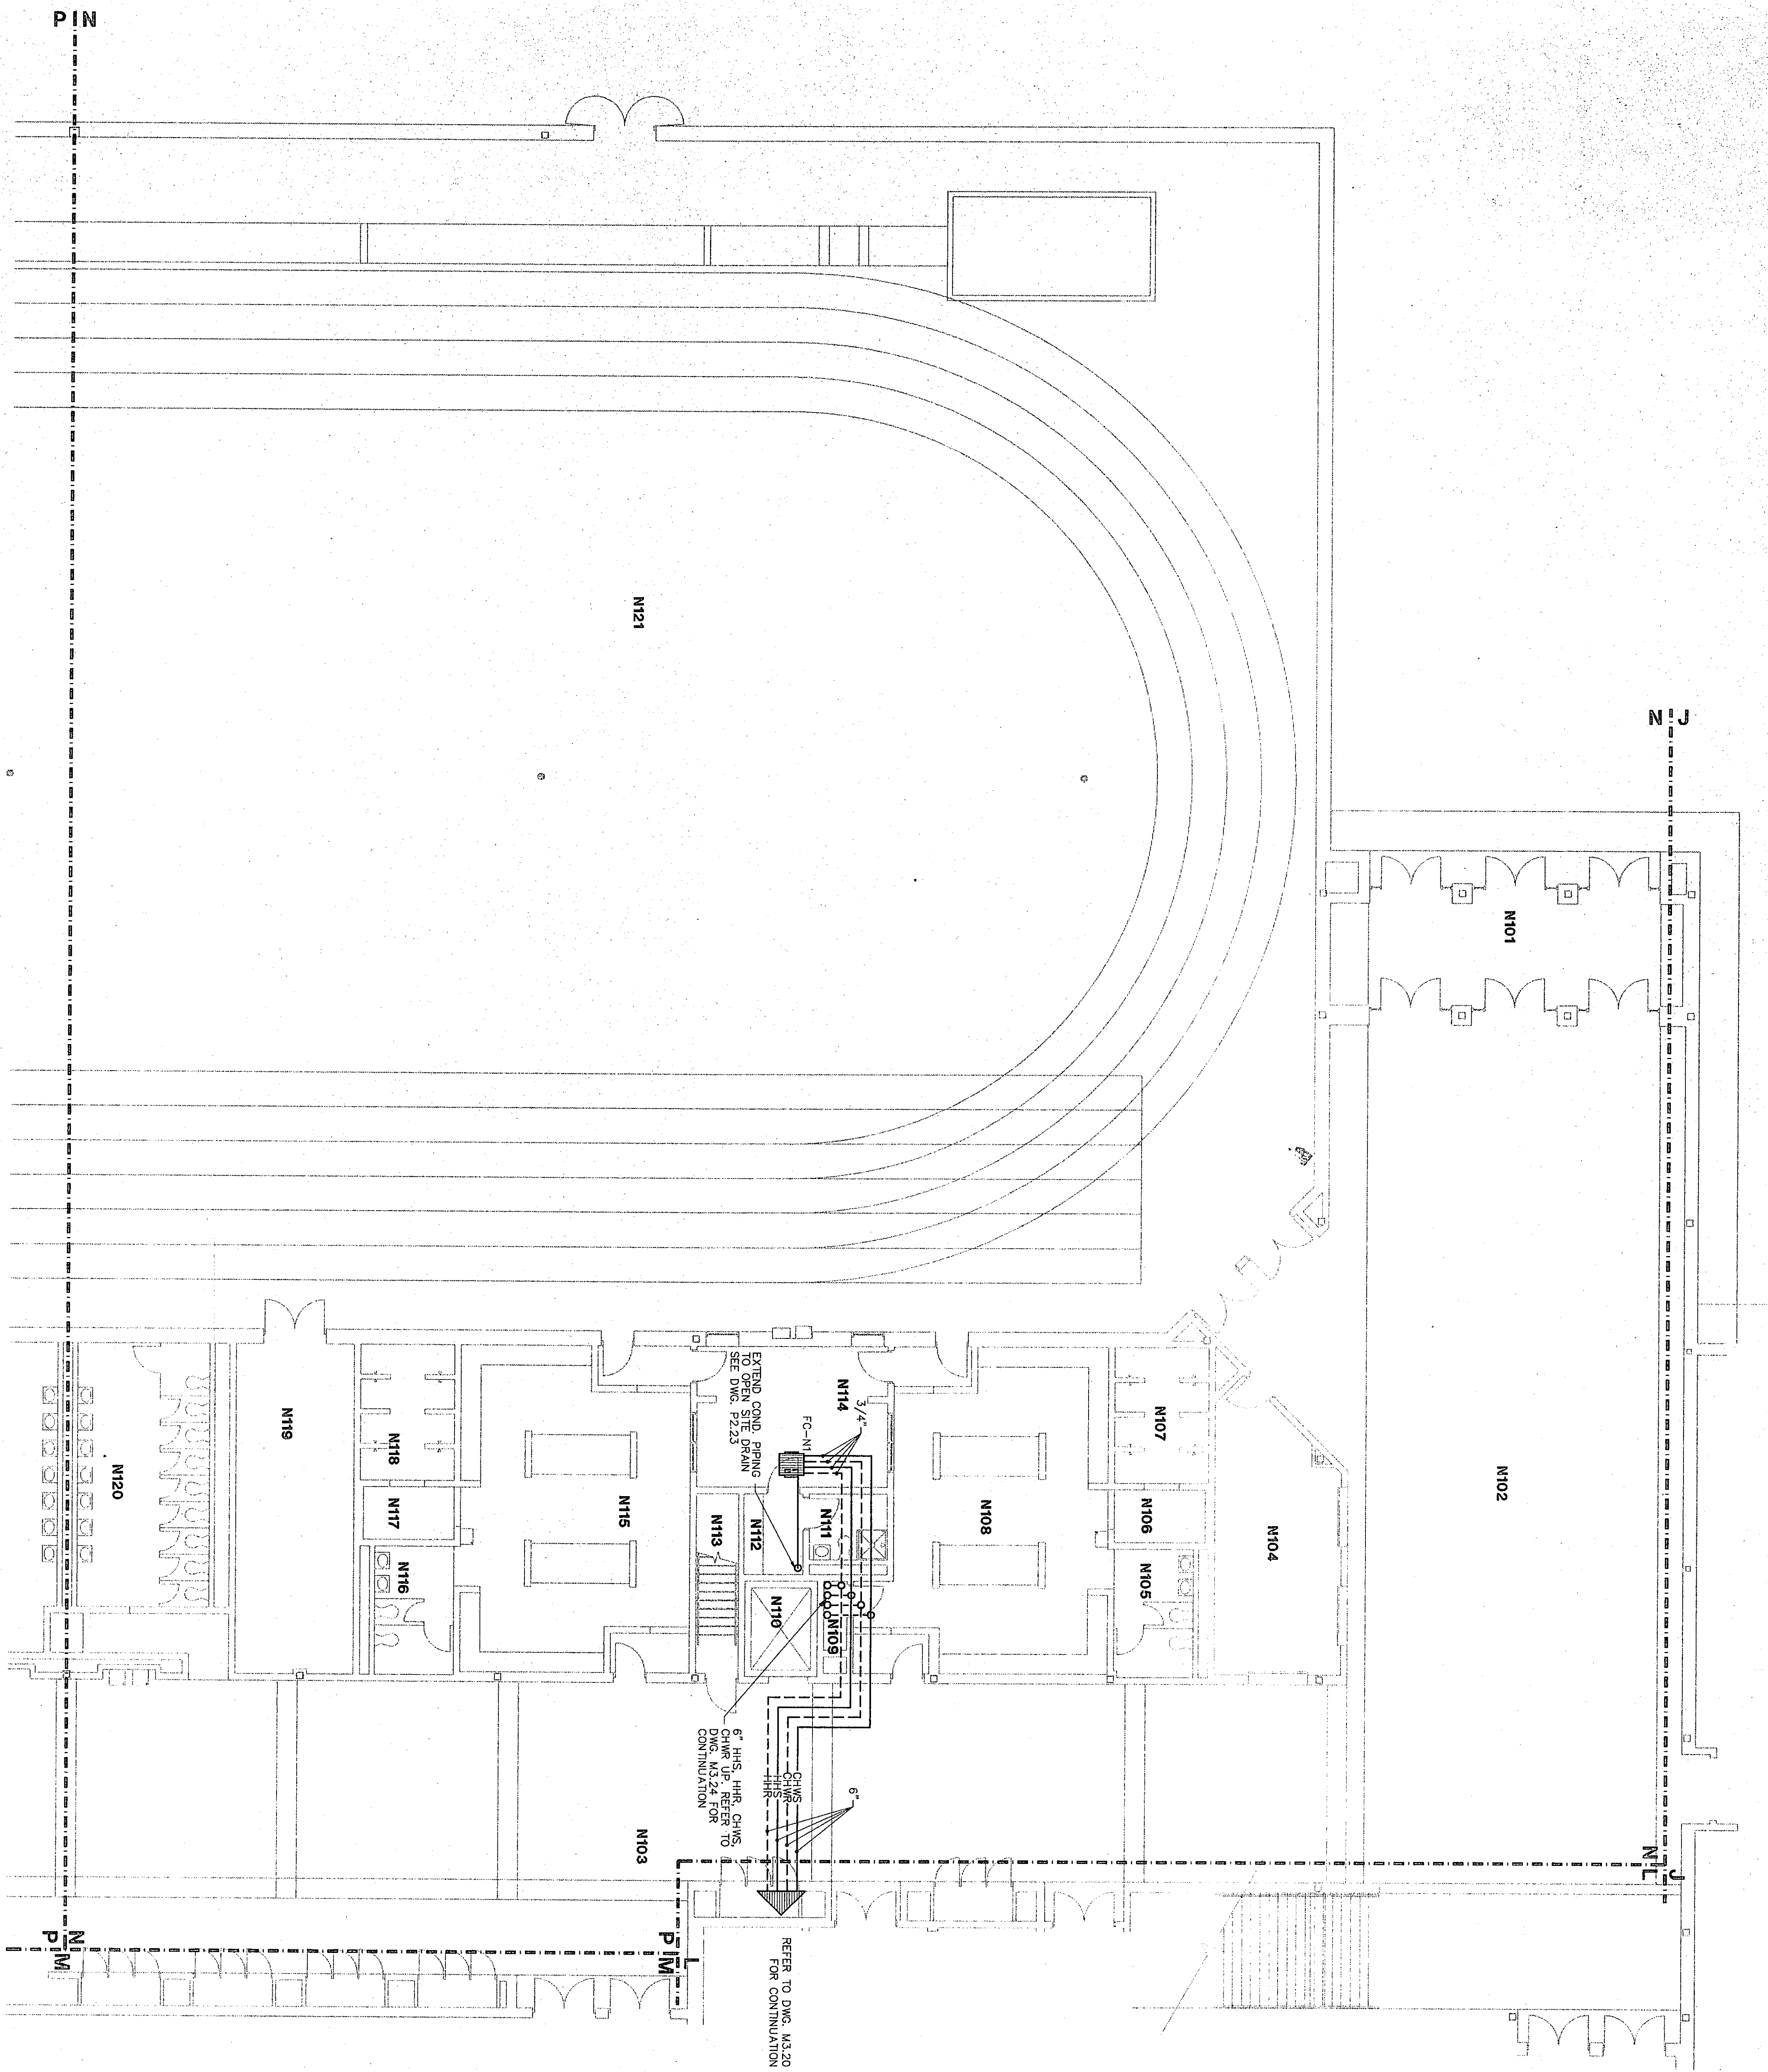


FLOOR PLAN UNIT "N"

1/8"=1'-0"

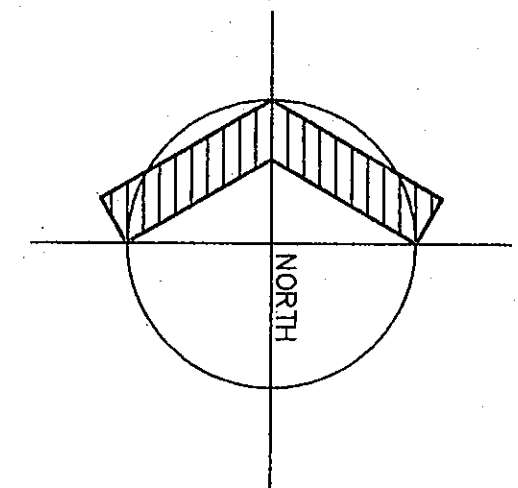

ROOM LEGEND "N"			
ROOM NO.	NAME	AREA S.F.	CEILING HEIGHT
N101	REAR LOBBY	3824	10'-0"
N102	CORRIDOR	3297	9'-4"
N103	TOILET	1037	9'-4"
N104	DRIVING ROOM	49	9'-4"
N105	DRIVING ROOM	49	9'-4"
N106	DRIVING ROOM	49	9'-4"
N107	DRIVING ROOM	49	9'-4"
N108	DRIVING ROOM	49	9'-4"
N109	DRIVING ROOM	49	9'-4"
N110	DRIVING ROOM	49	9'-4"
N111	DRIVING ROOM	49	9'-4"
N112	DRIVING ROOM	49	9'-4"
N113	DRIVING ROOM	49	9'-4"
N114	DRIVING ROOM	49	9'-4"
N115	DRIVING ROOM	49	9'-4"
N116	DRIVING ROOM	49	9'-4"
N117	DRIVING ROOM	49	9'-4"
N118	DRIVING ROOM	49	9'-4"
N119	DRIVING ROOM	49	9'-4"
N120	DRIVING ROOM	49	9'-4"
N121	DRIVING ROOM	49	9'-4"

Fanning/Howey Associates, Inc.
Architects Engineers Consultants

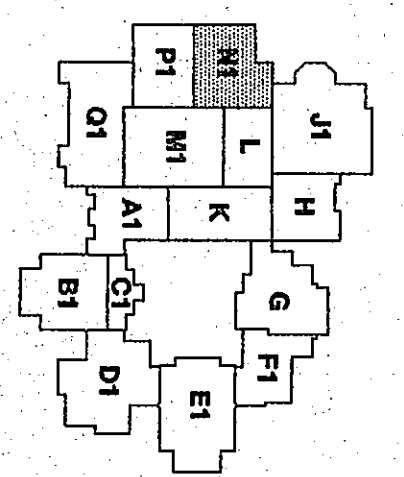

THE NEW
CHESTERTON HIGH SCHOOL
FOR THE
DUNELAND SCHOOL CORPORATION
CHESTERTON, INDIANA

COPYRIGHT 1997 BY FANNING/HOWEY ASSOCIATES, INC.

HEATING PLAN UNIT "N"

DRAWN BY: SCB COMM. NO.: 95067.00
CHECKED BY: CAM DATE: APRIL 21, 1997

M3.23

REVISIONS NO. DATE

5-11-M-5-8