



ROOM LEGEND "P"			
ROOM NO.	ROOM NAME	AREA S.F.	CEILING HEIGHT
P101	MEN'S TOILET	429	9'-4"
P102	ATHLETIC STORAGE	794	9'-4"
P103	BOILER ROOM	105	9'-4"
P104	DRIVING ROOM	49	9'-4"
P105	BOILER ROOM	730	9'-4"
P106	BOILER ROOM	71	9'-4"
P107	JANITOR	71	9'-4"
P108	STORAGE	79	9'-4"
P109	COACH LOCKER	52	9'-4"
P110	OFFICE	22	9'-4"
P111	BOY'S PE LOCKER	747	9'-4"
P112	BOY'S PE LOCKER	406	9'-4"
P113	SHOWER	130	9'-4"
P114	FOOD SERVICE STAND	133	9'-4"
P115	FOOD SERVICE STAND	133	9'-4"
P116	FOOD SERVICE STAND	133	9'-4"
P117	FOOD SERVICE STAND	133	9'-4"
P118	FOOD SERVICE STAND	133	9'-4"
P119	FOOD SERVICE STAND	133	9'-4"
P120	ELECTRICAL ROOM	3893	10'-0"

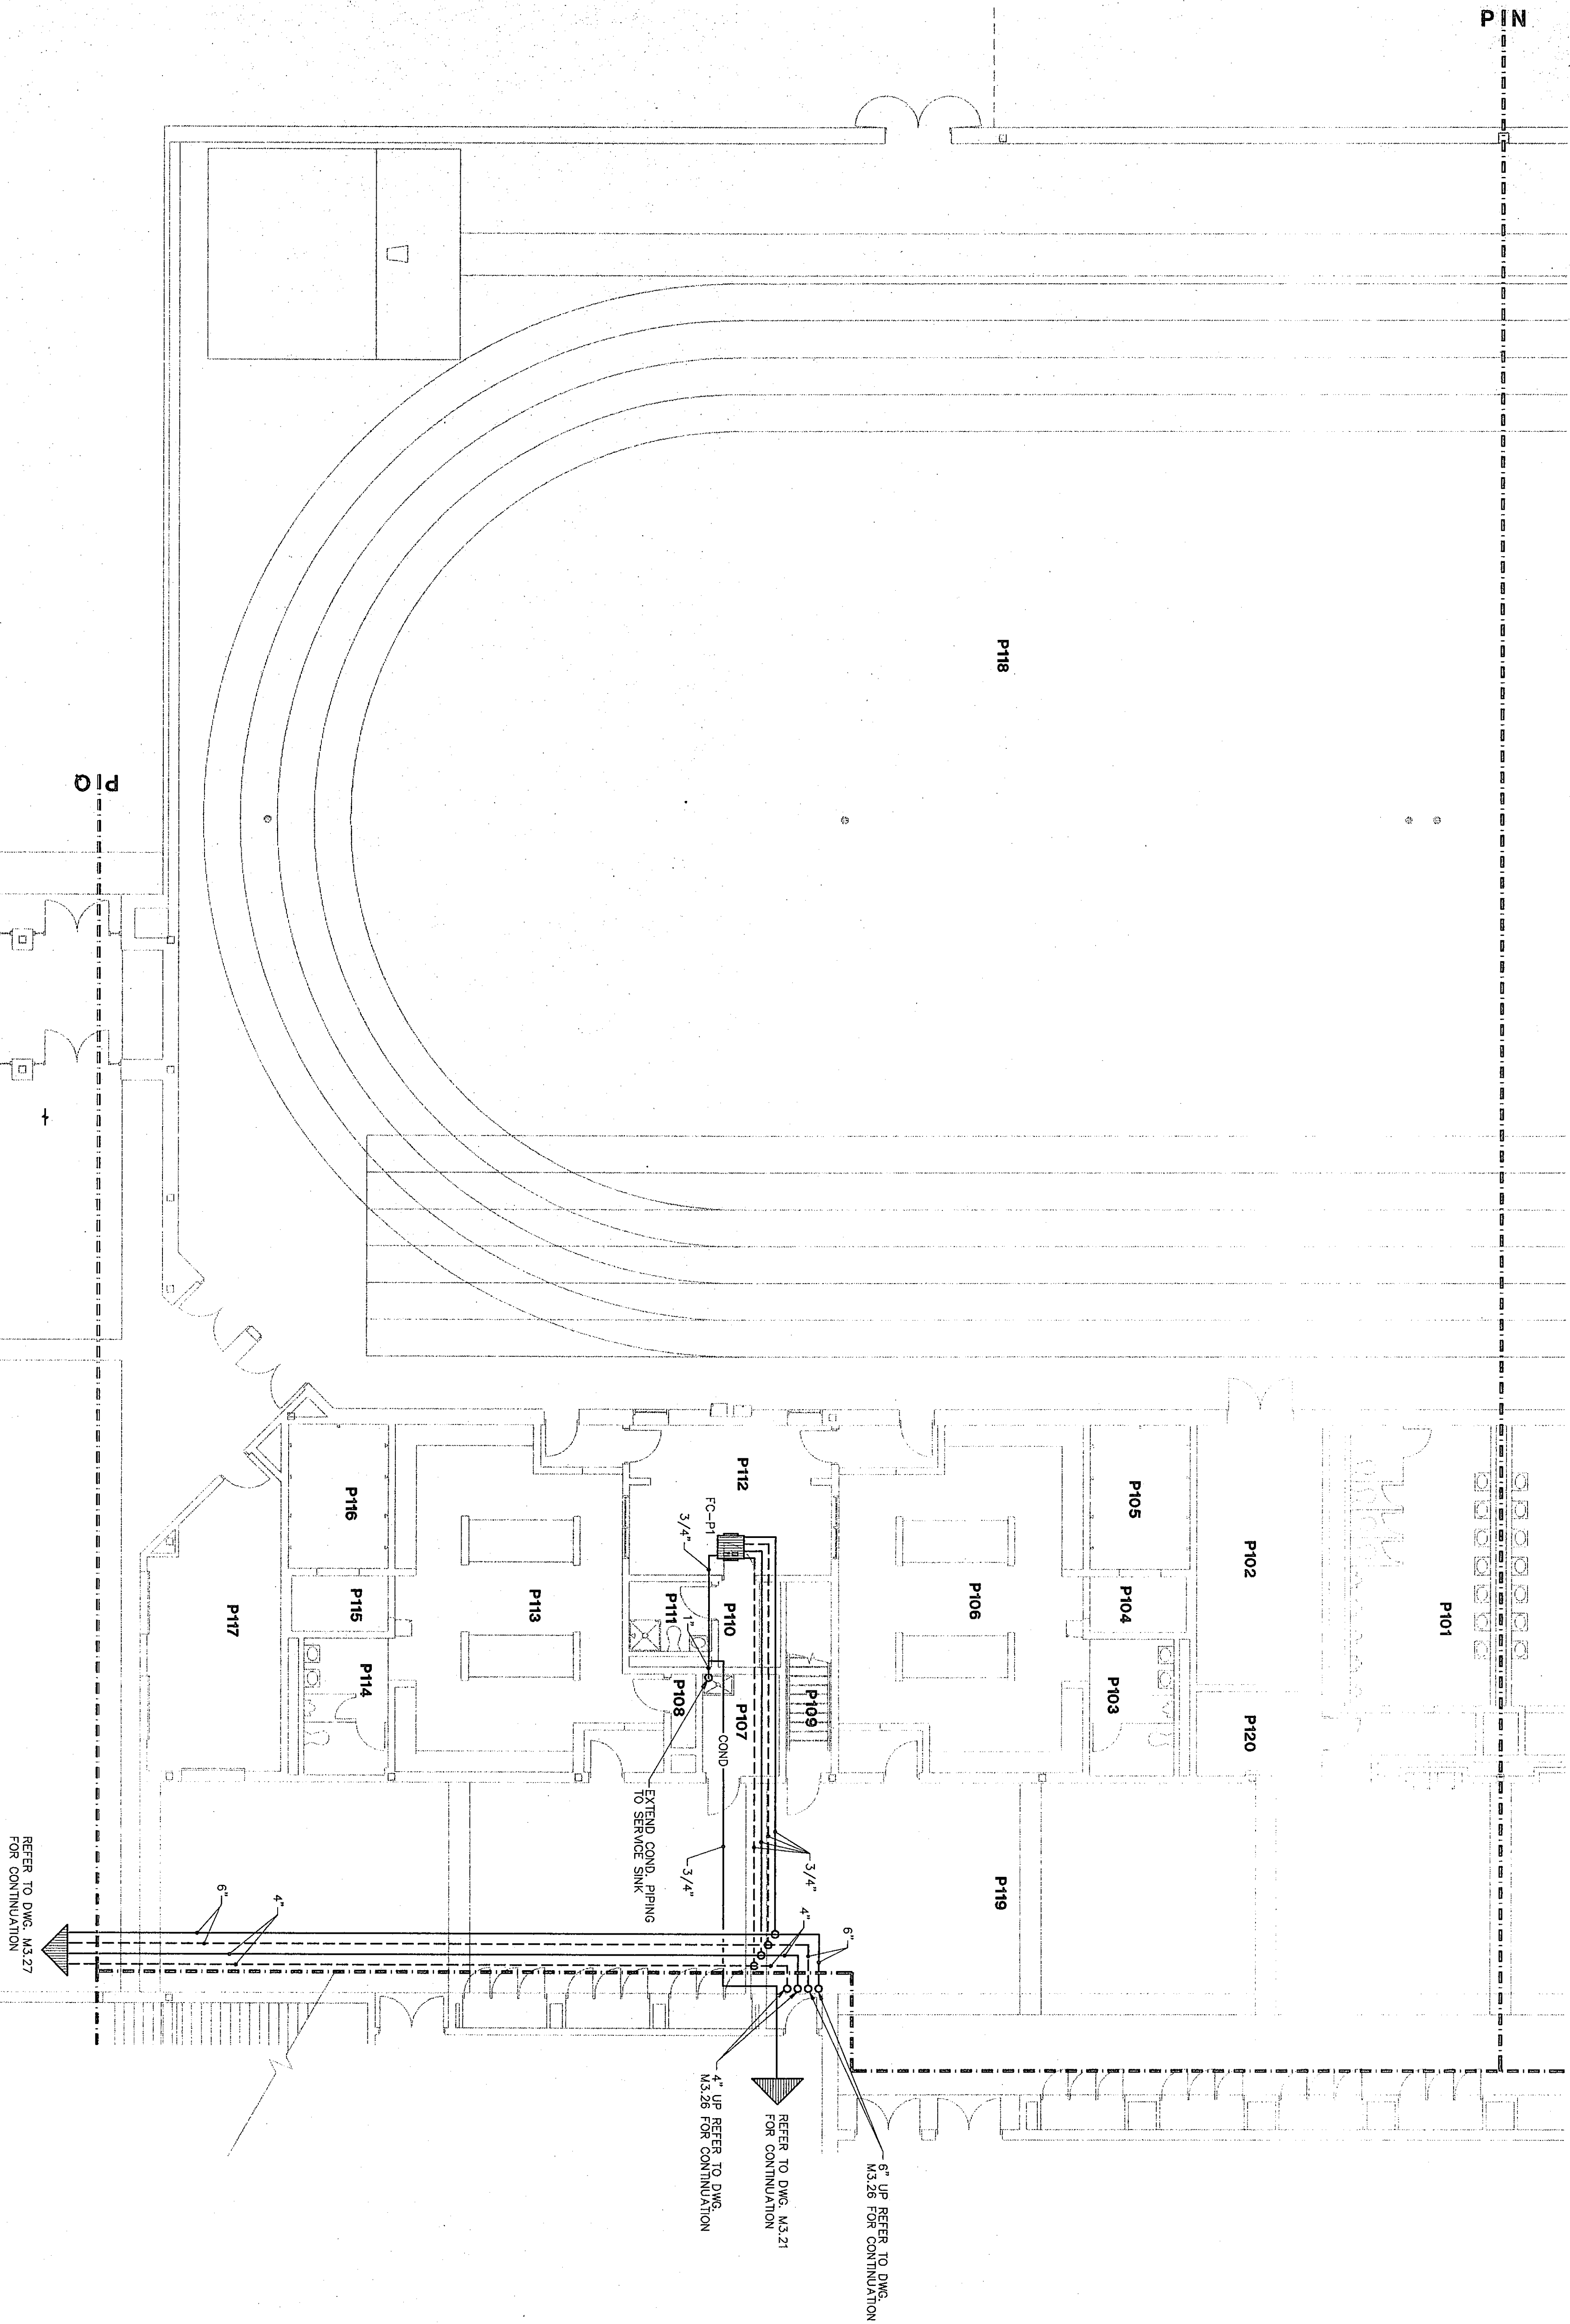

FLOOR PLAN UNIT "P"

1/8"=1'-0"

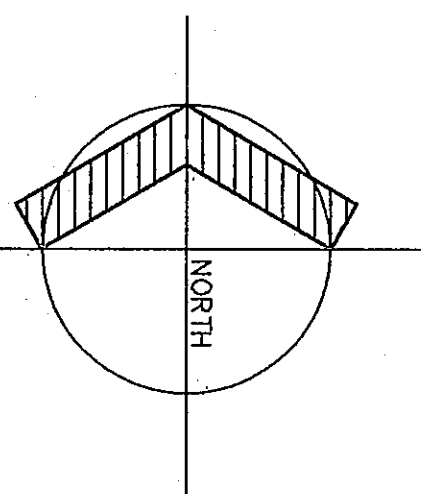


97-11-10

HEATING PLAN UNIT "P"


DRAWN BY: SCB COMM. NO.: 95067.00
CHECKED BY: CAM DATE: APRIL 21, 1997

M3.25

REVISIONS NO. DATE

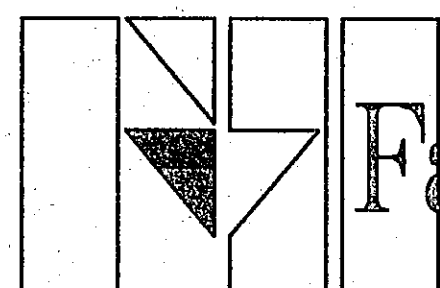

Fanning/Howey Associates, Inc.
Architects Engineers Consultants

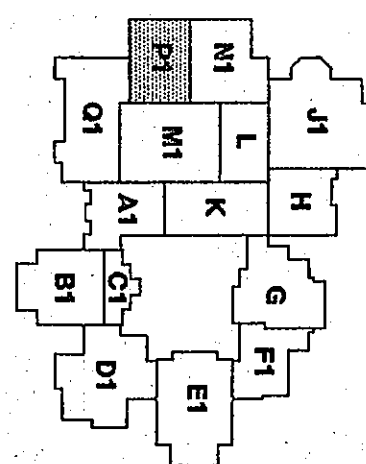

THE NEW
CHESTERTON HIGH SCHOOL
FOR THE
DUNELAND SCHOOL CORPORATION
CHESTERTON, INDIANA

COPYRIGHT 1997 BY FANNING/HOWEY ASSOCIATES, INC.

