


PIN

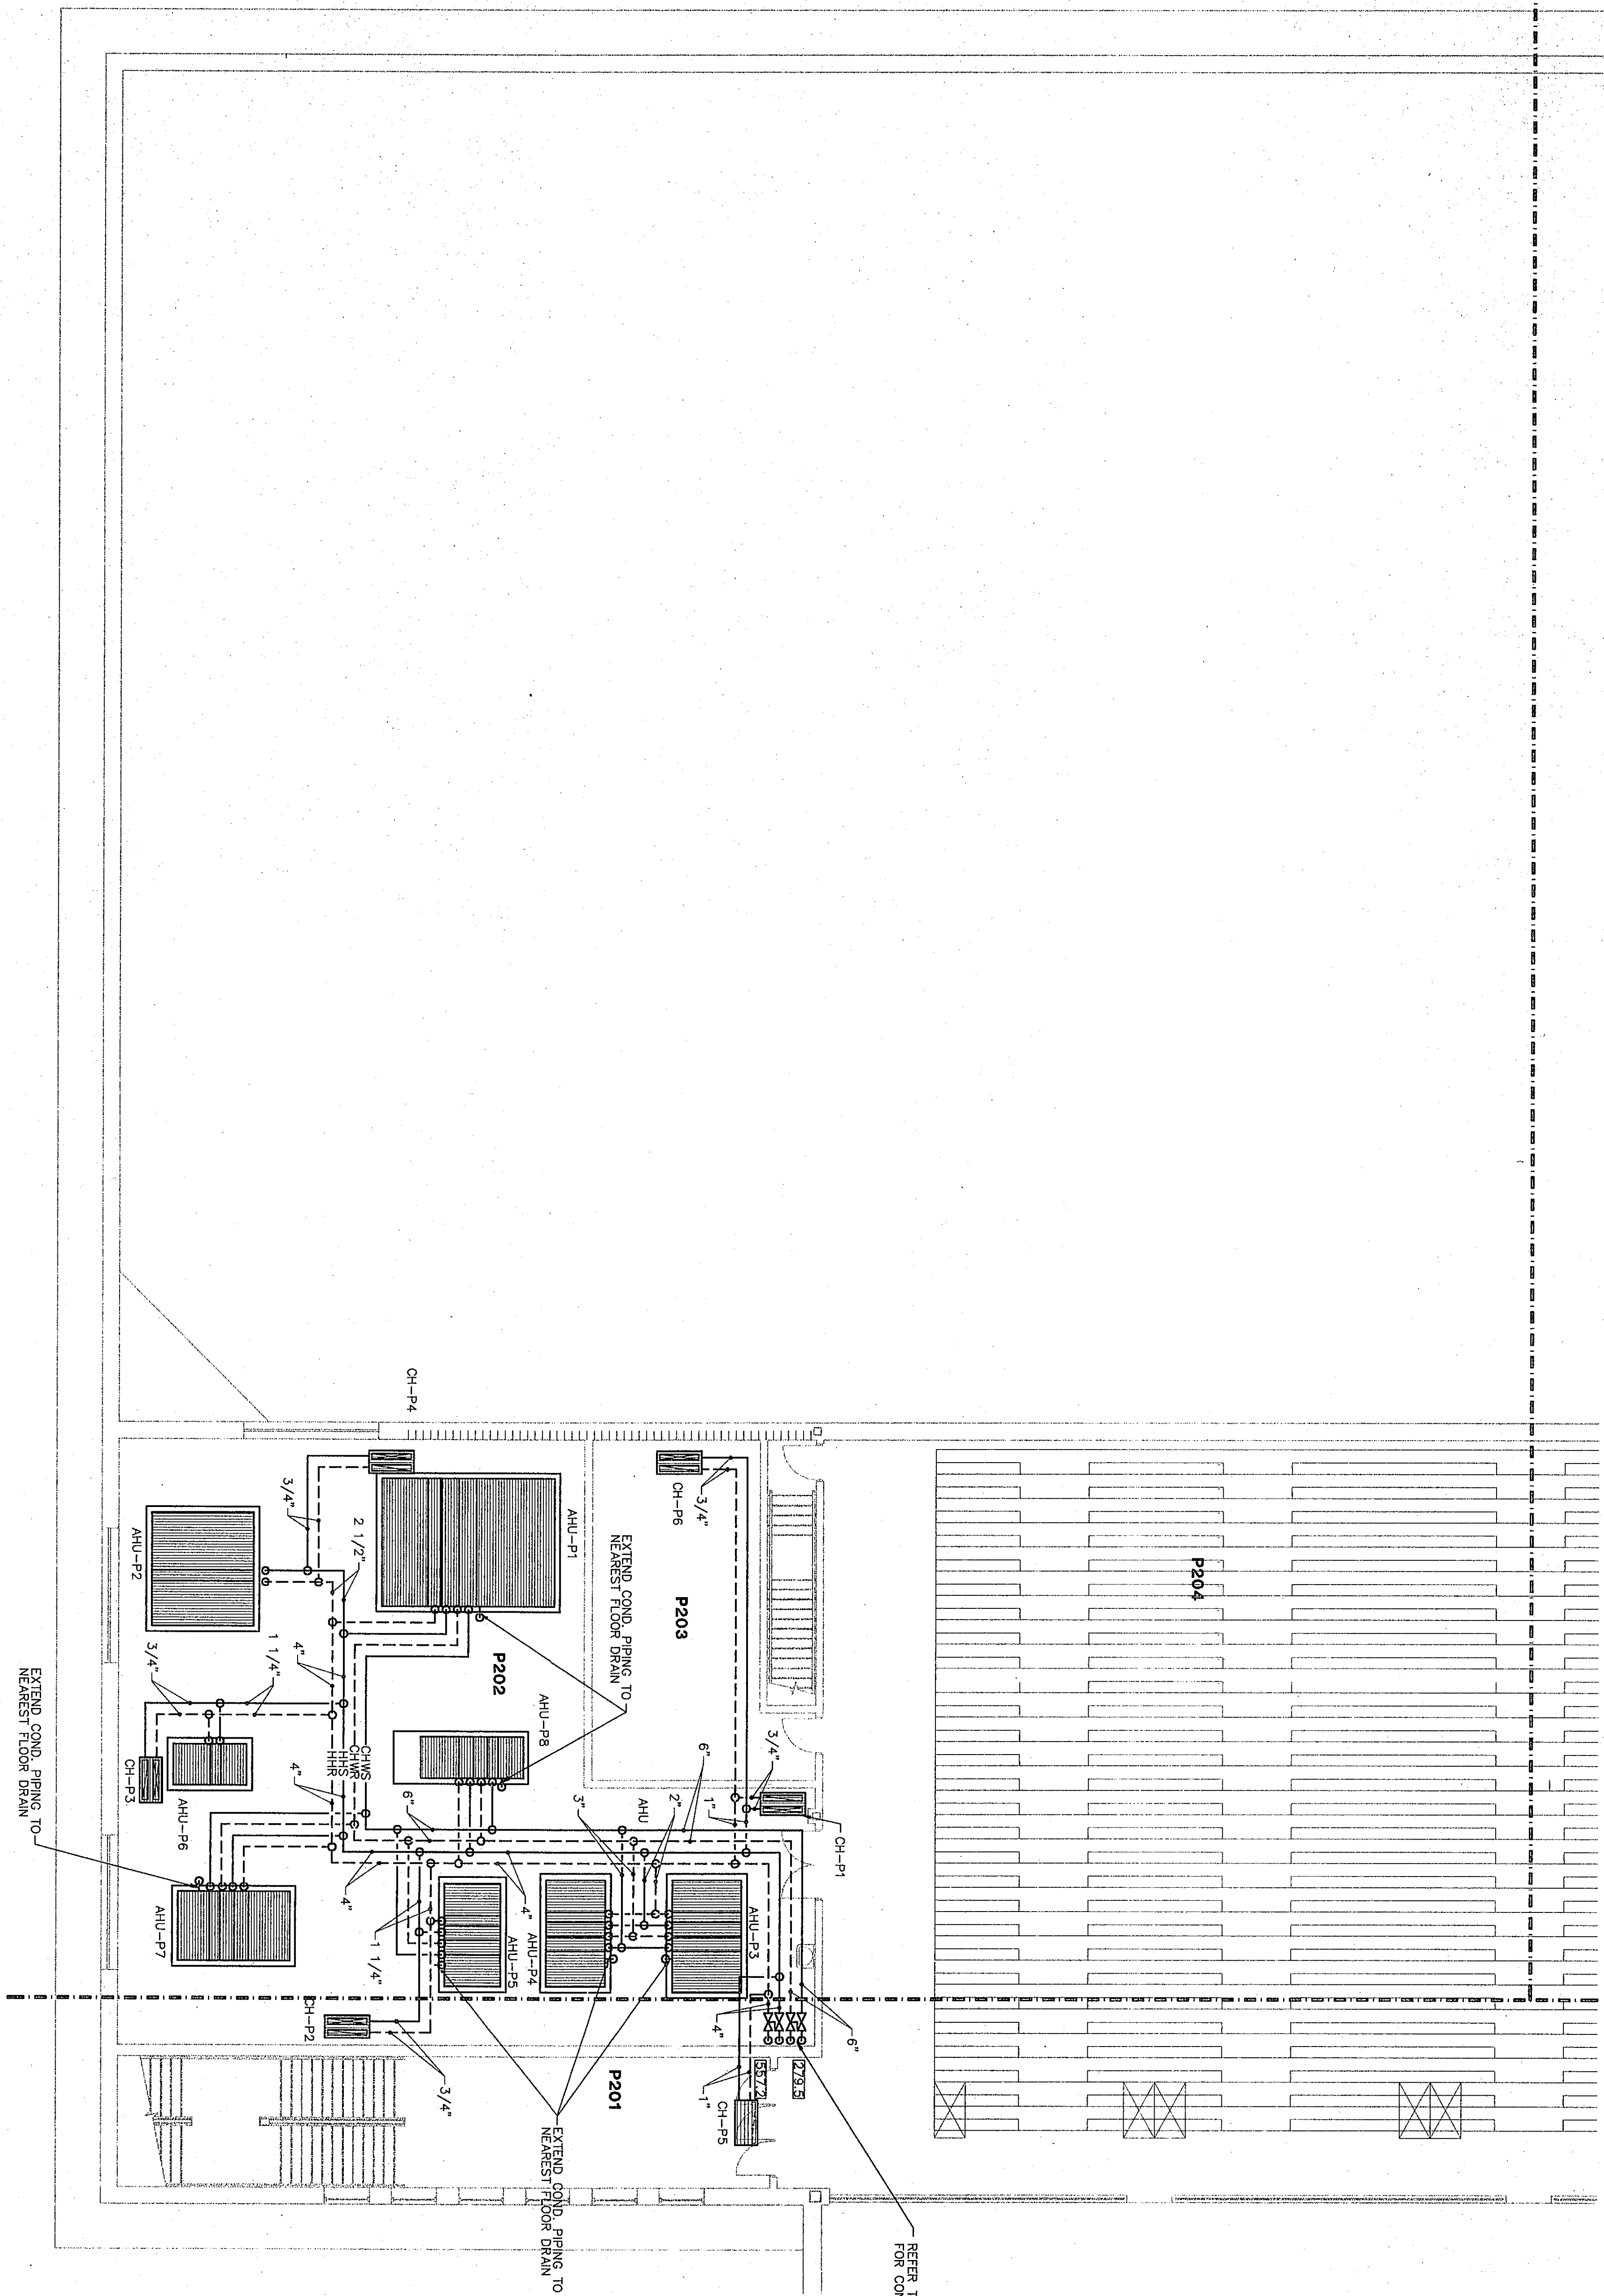



ROOM LEGEND "P2"			
ROOM NO.	ROOM NAME	AREA S.F.	CEILING HEIGHT
P201	STAIR	681	10'-6"
P202	STAIR	493	9'-4"
P203	STAIR	438	9'-4"
P204	BALCONY COURT	---	---

MARK	HEATING		COOLING	
	GPM	PIPE SIZE	GPM	PIPE SIZE
AHU-P1	108.4	3"	317.6	6"
AHU-P2	54.2	2 1/2"	---	---
AHU-P3	21.7	2 1/2"	61.6	2 1/2"
AHU-P4	11.4	1 1/2"	35.1	2"
AHU-P5	11.4	1 1/2"	---	---
AHU-P6	8.1	1 1/4"	---	---
AHU-P7	27.1	2"	77.1	2 1/2"
AHU-P8	12.6	1 1/4"	26.9	2"

FLOOR PLAN UNIT "P2"

1/8"=1'-0"

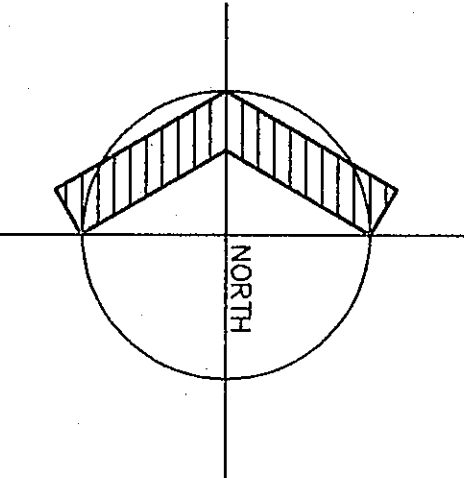


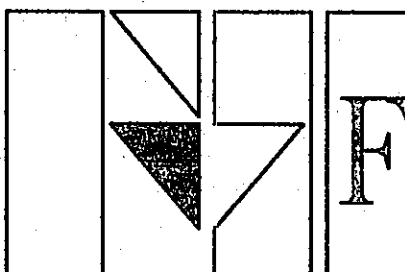

Fanning/Howey



Associates, Inc.

Architects Engineers Consultants

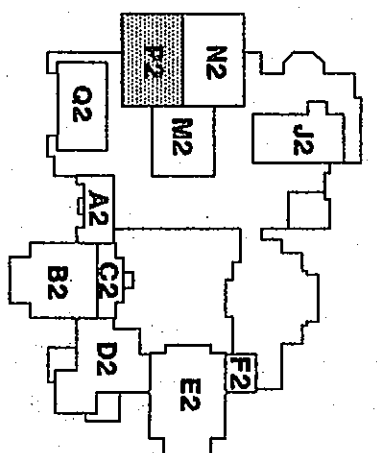

THE NEW
CHESTERTON HIGH SCHOOL
FOR THE
DUNELAND SCHOOL CORPORATION
CHESTERTON, INDIANA

COPYRIGHT 1997 BY FANNING/HOWEY ASSOCIATES, INC.

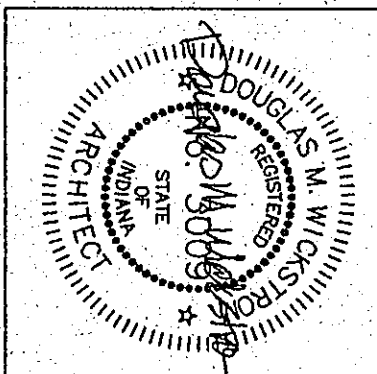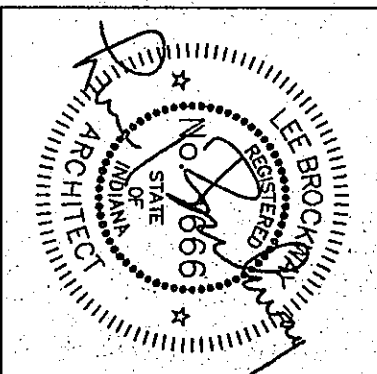

HEATING PLAN UNIT "P2"

DRAWN BY: SCB
CHECKED BY: CAM

COMM. NO.: 95067.00
DATE: APRIL 21, 1997

M3.26

REVISIONS NO. DATE