



EVAPORATOR WATER PIPING DETAIL
NOT TO SCALE

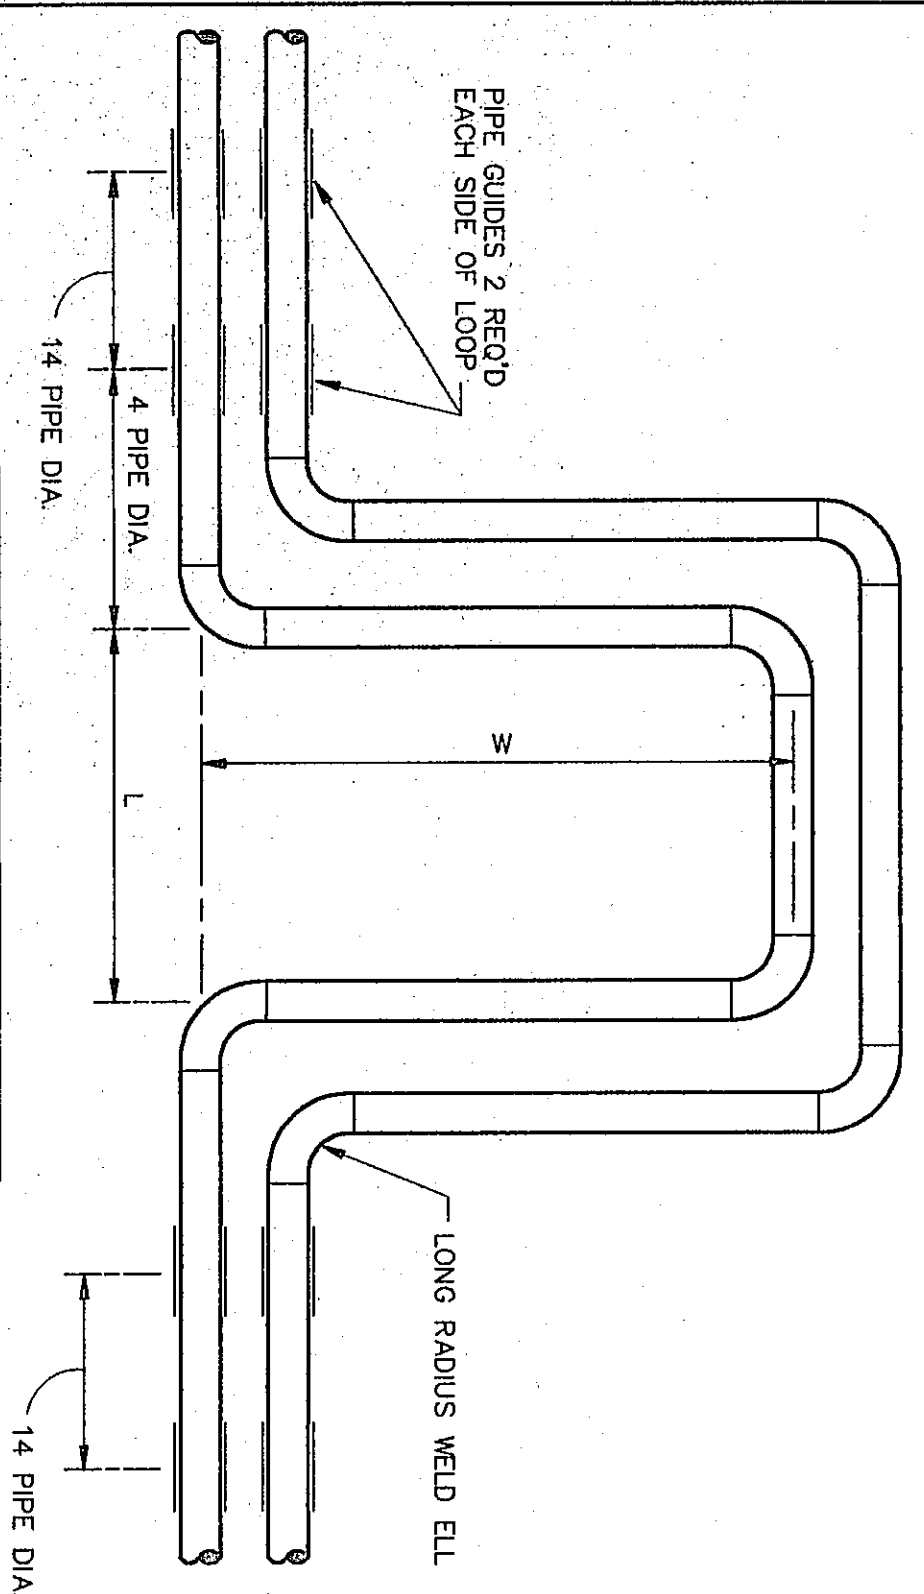


EXPANSION LOOP SCHEDULE

PIPE SIZE	LENGTH (L)	WIDTH (W)
3/4"-1 1/2"	2'	4'
2"	4'-0"	4'-0"
3"	4'-0"	4'-0"
4"	4'-0"	5'-0"
6"	4'-0"	6'-0"
8"	4'-0"	8'-0"


HEATING PIPE EXPANSION LOOP DETAIL
NOT TO SCALE

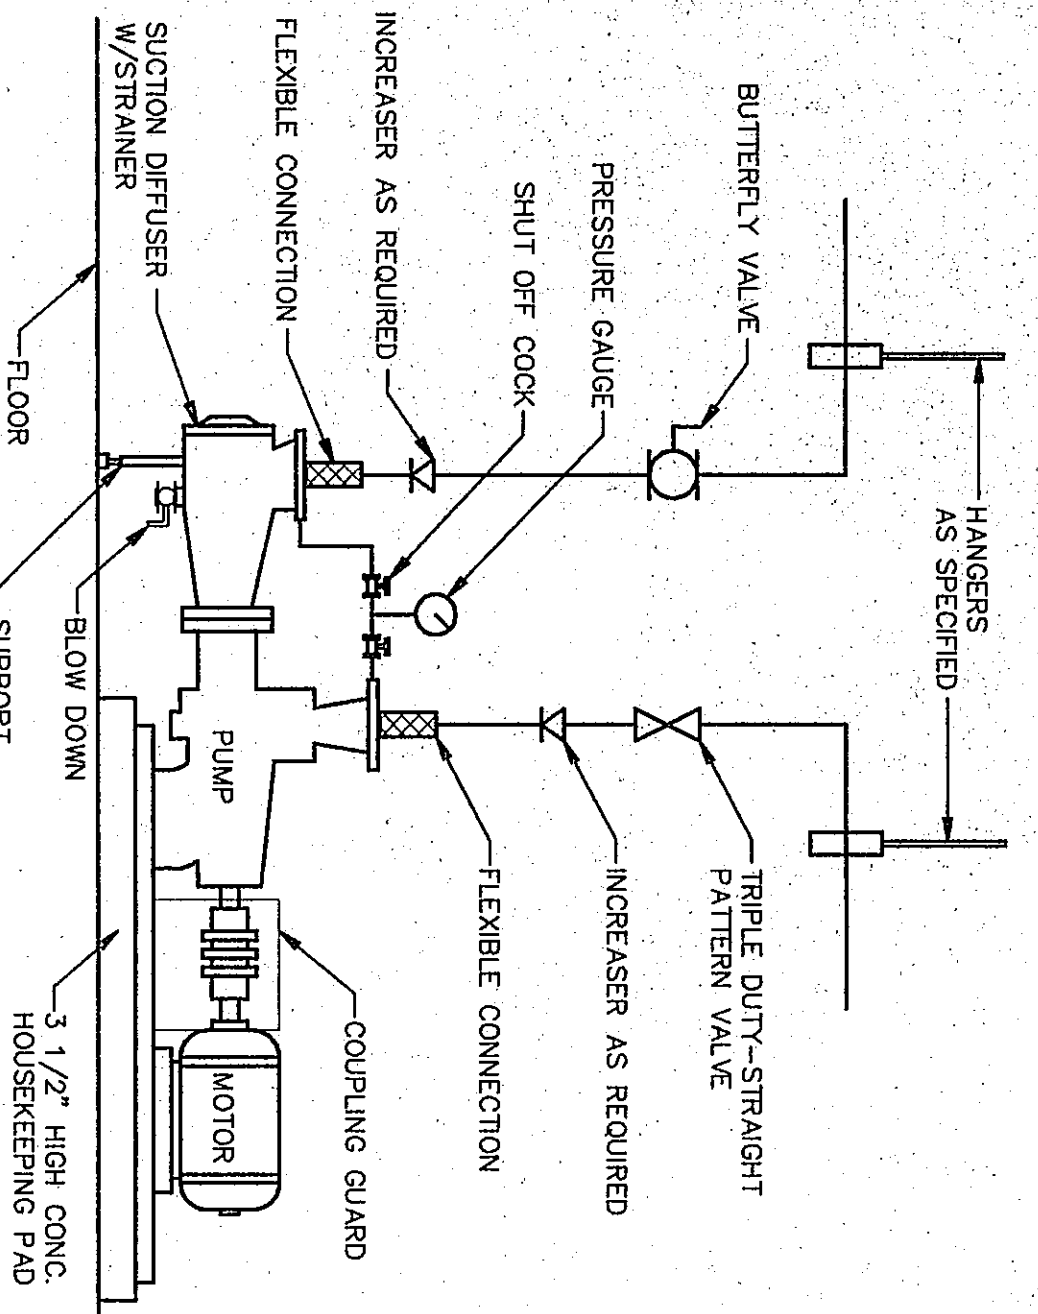


BASE MOUNTED PUMP PIPING DETAIL
NOT TO SCALE

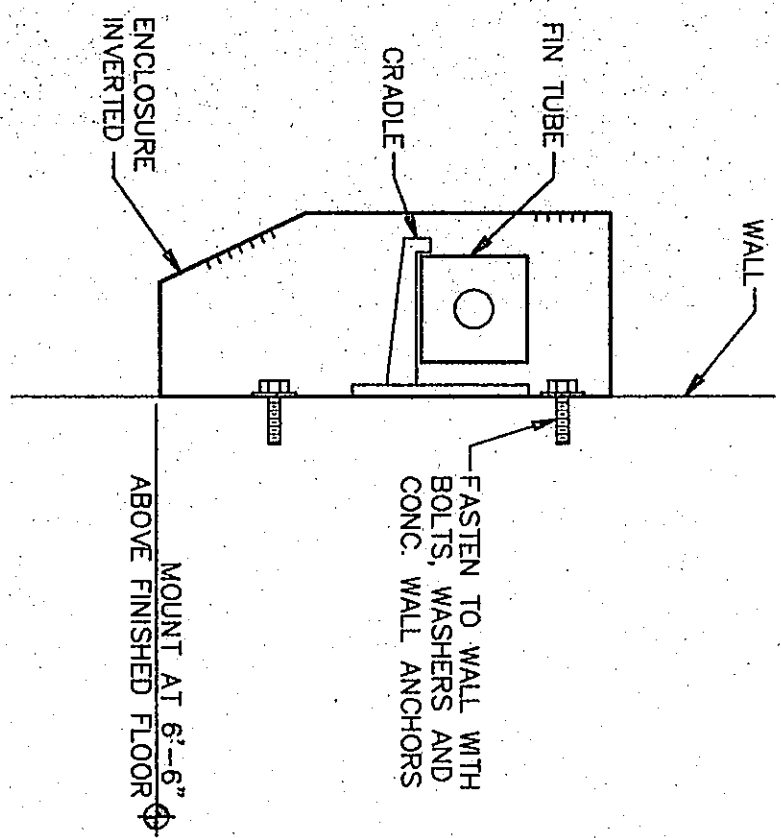


FIN TUBE INSTALLATION DETAIL
NOT TO SCALE

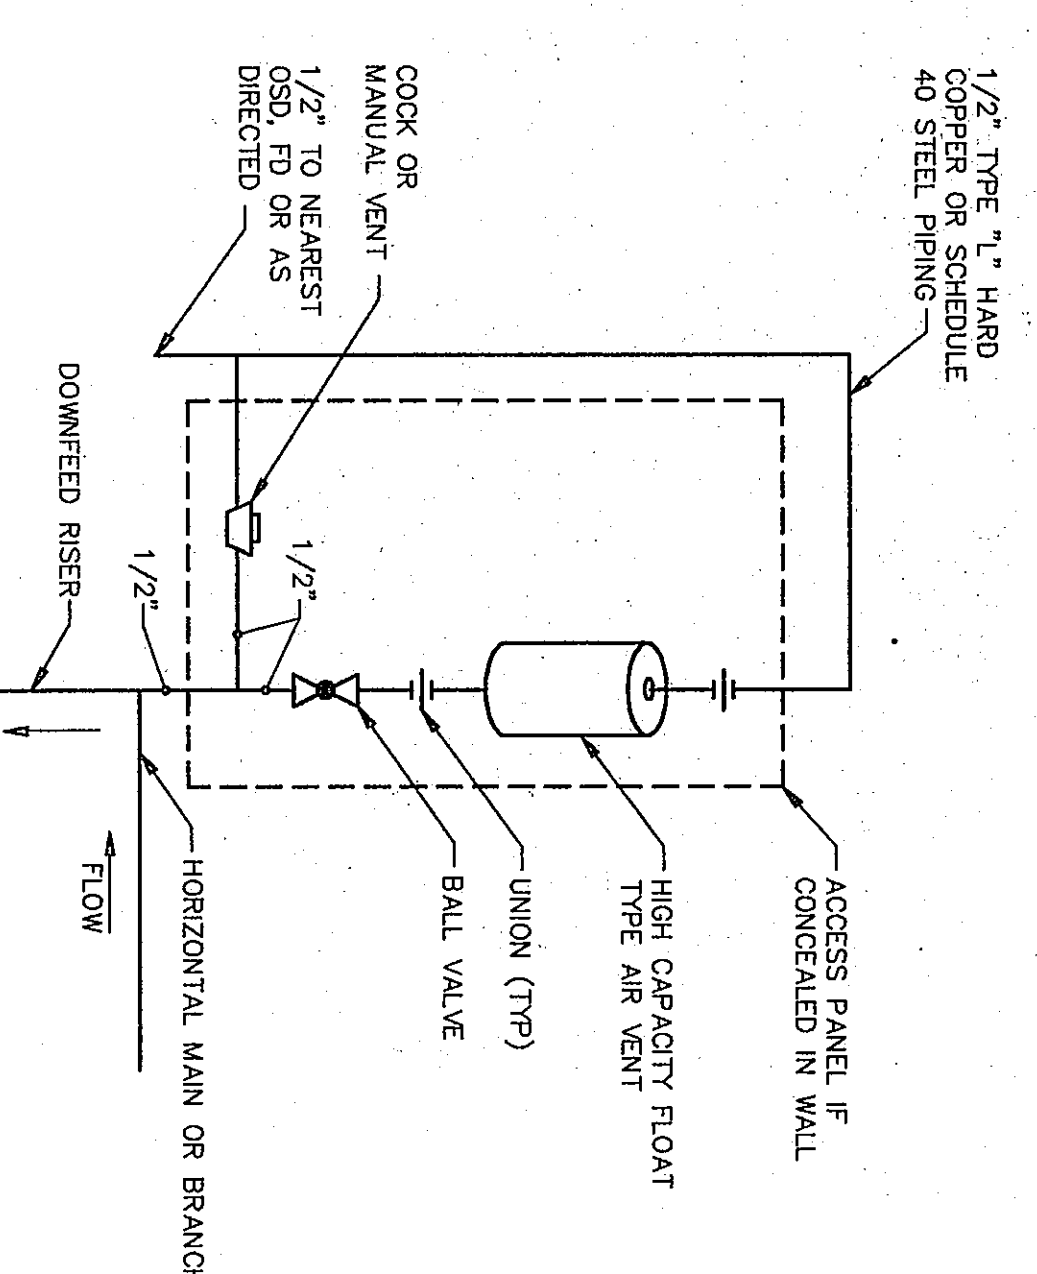


FLOAT AIR VENT DETAIL
NOT TO SCALE

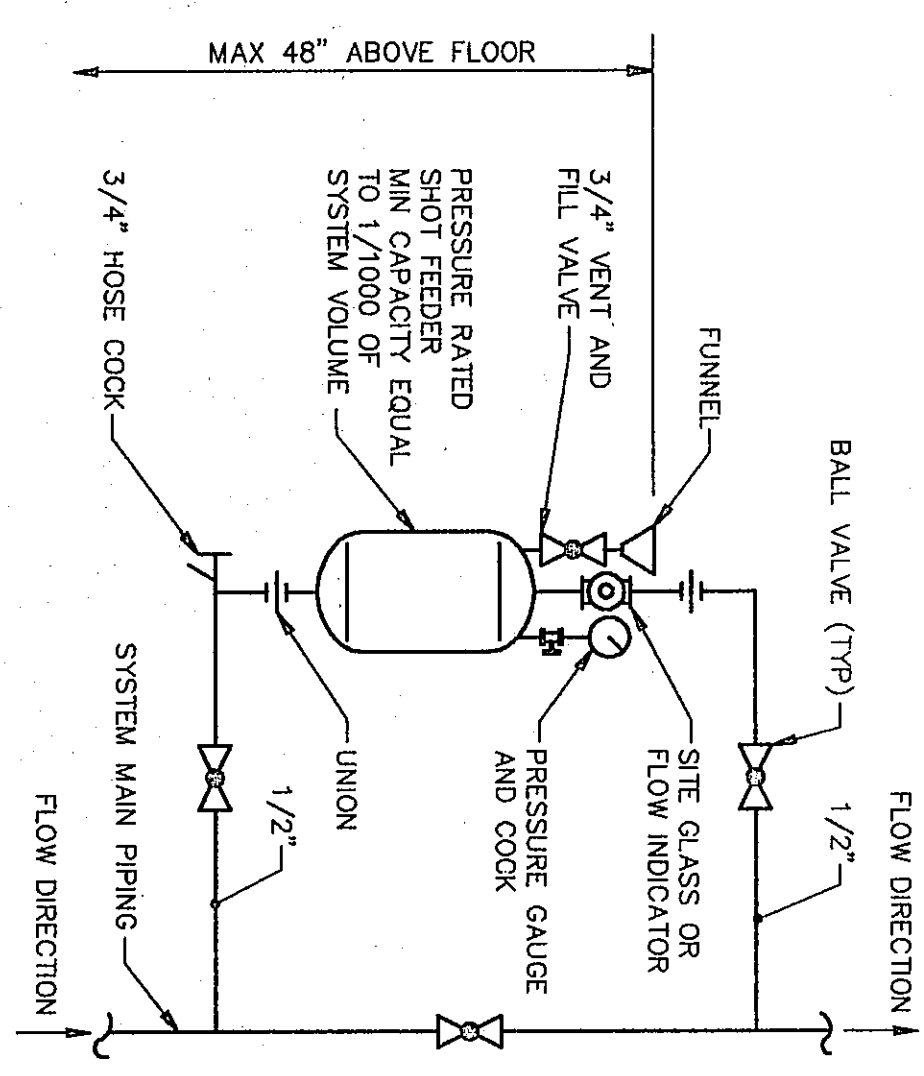


CHEMICAL SHOT FEEDER DETAIL
NOT TO SCALE

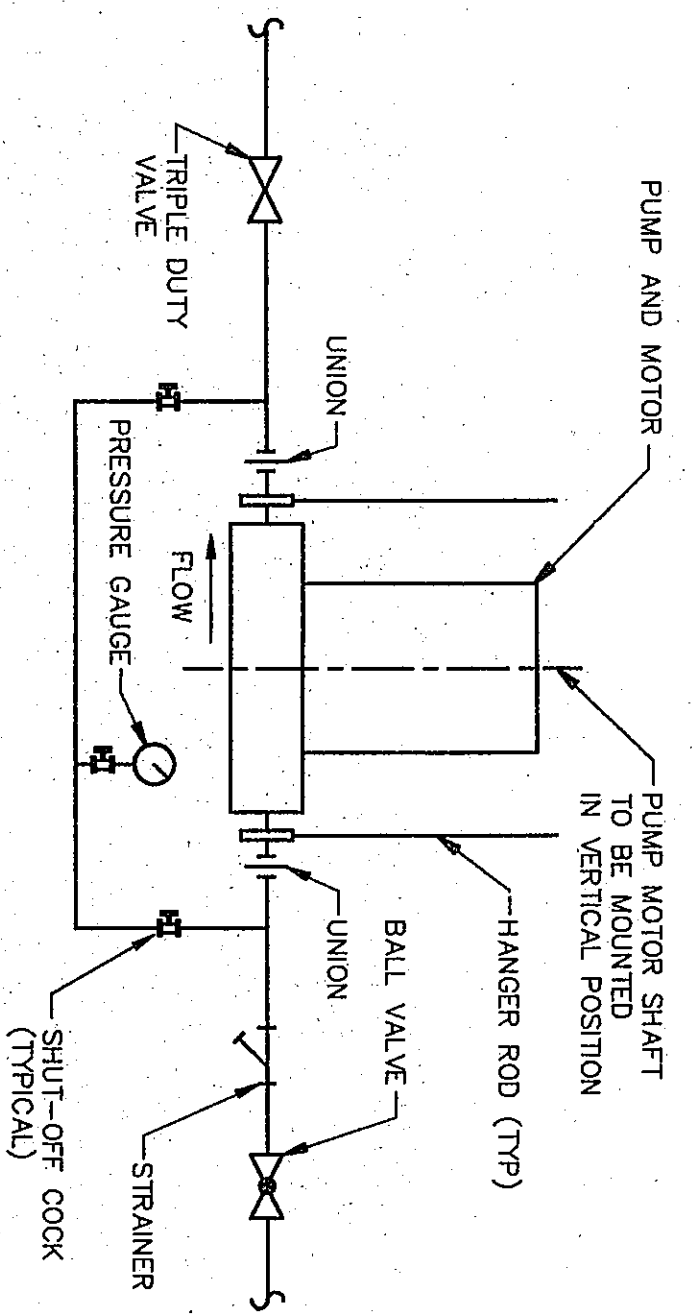


IN-LINE PUMP PIPING DETAIL
NOT TO SCALE

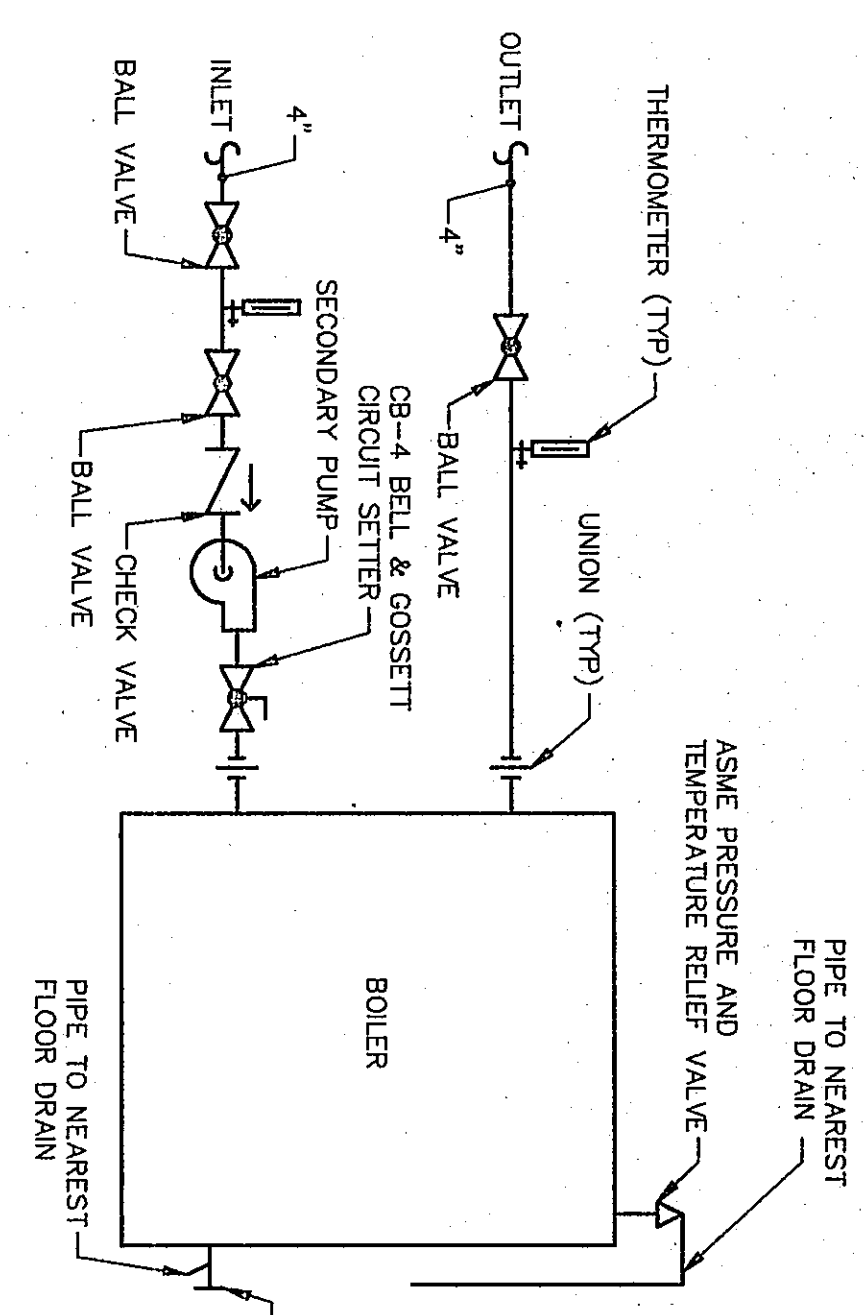


CAST IRON BOILER PIPING DETAIL
NOT TO SCALE

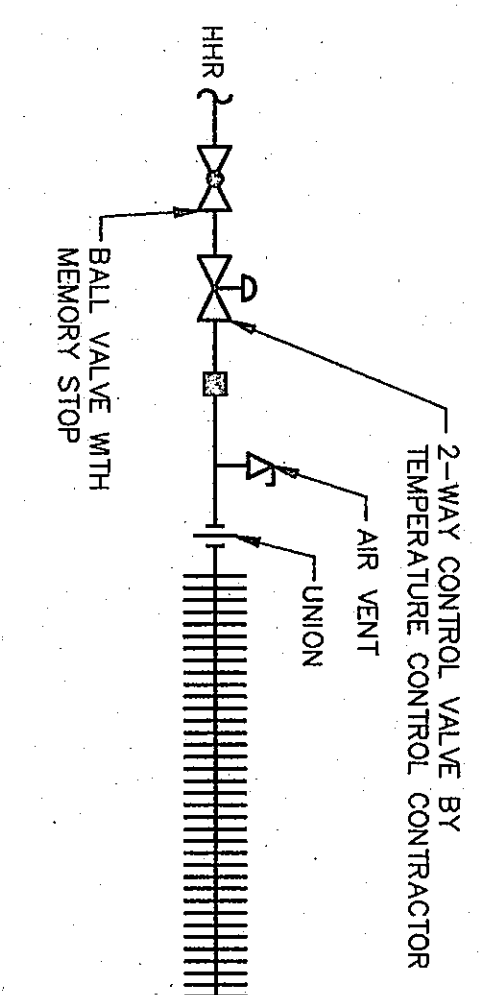


FIN TUBE RADIATION PIPING DETAIL
NOT TO SCALE

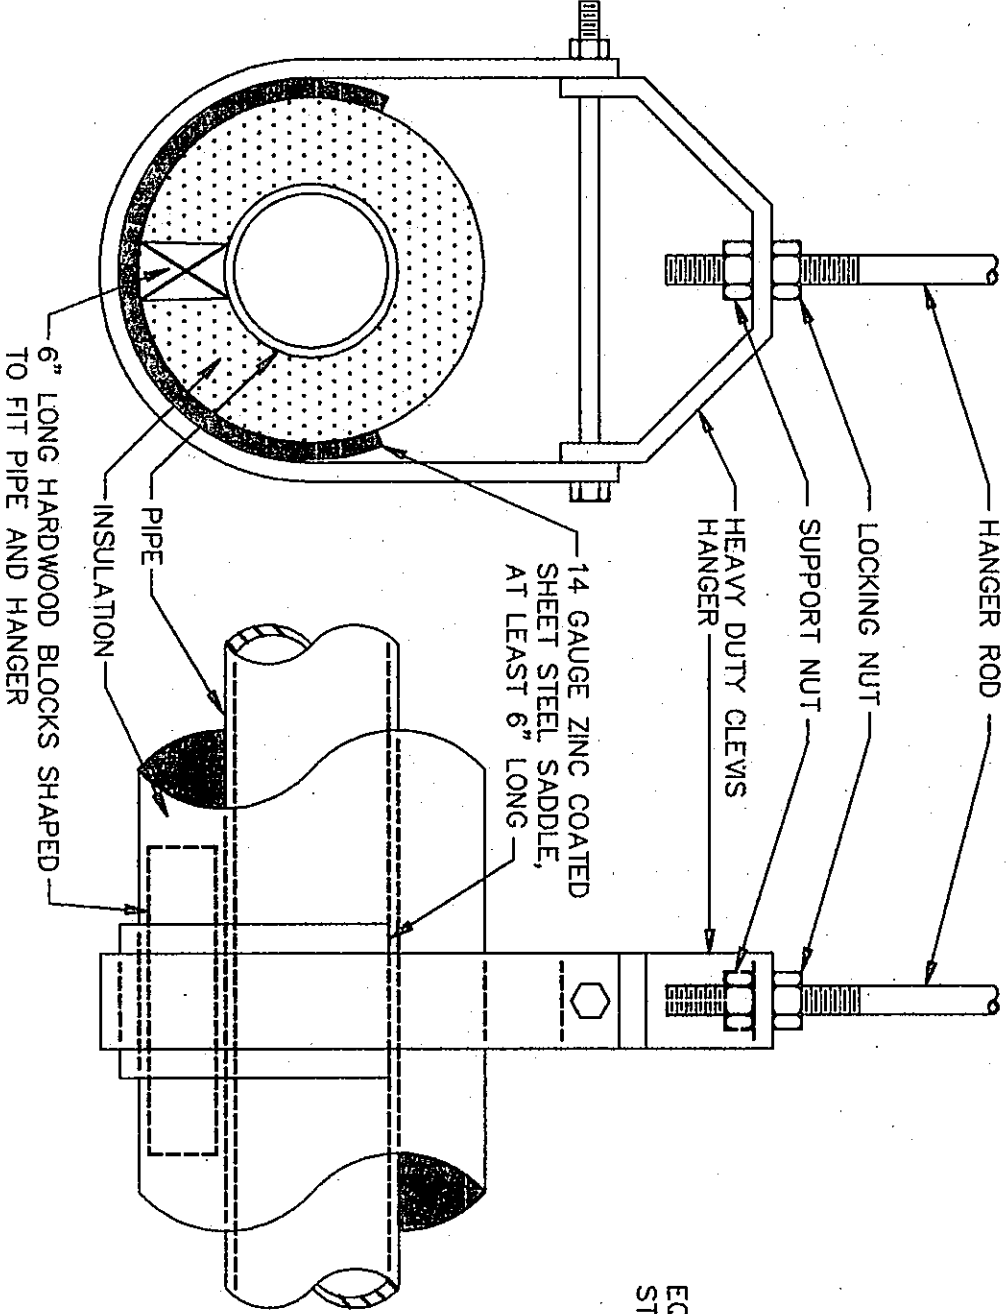


PIPE HANGERS (6" AND SMALLER)
NOT TO SCALE

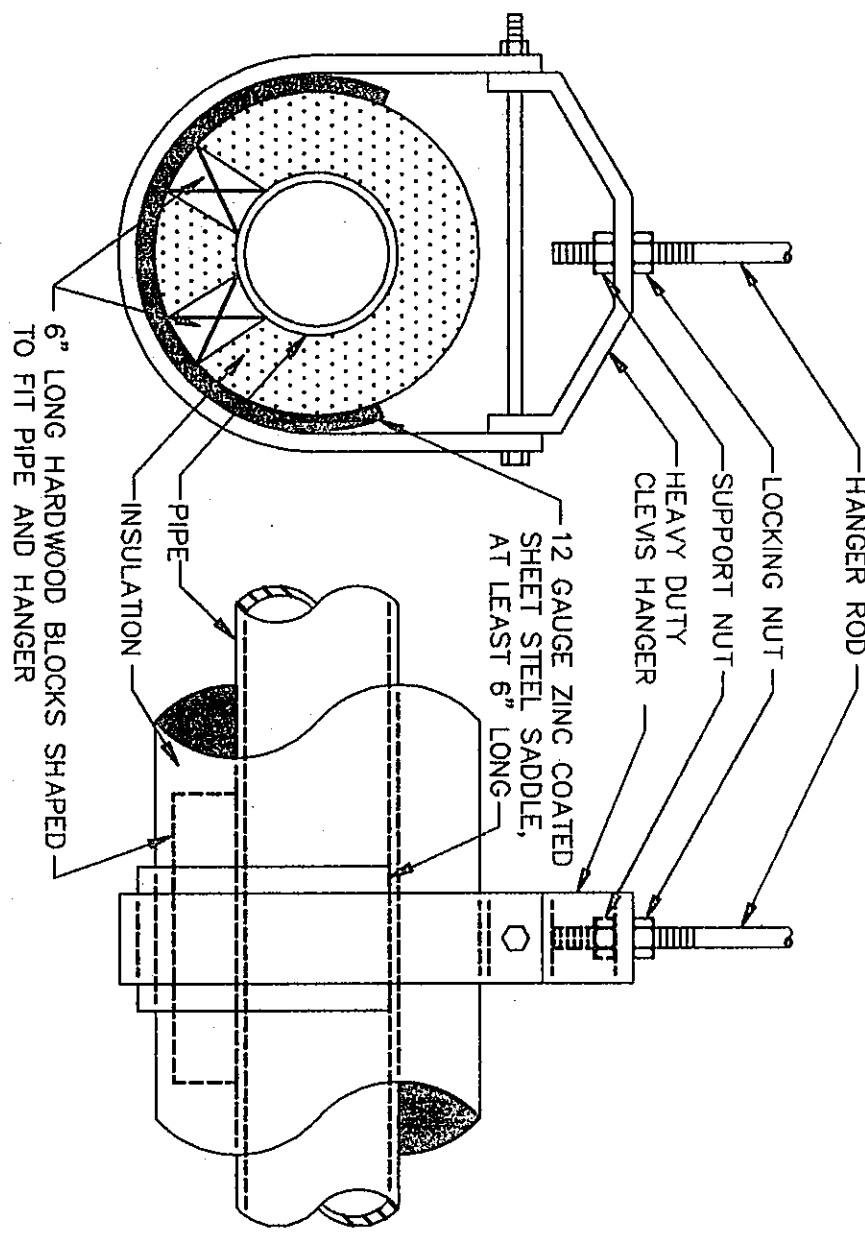


PIPE HANGERS (8" AND LARGER)
NOT TO SCALE

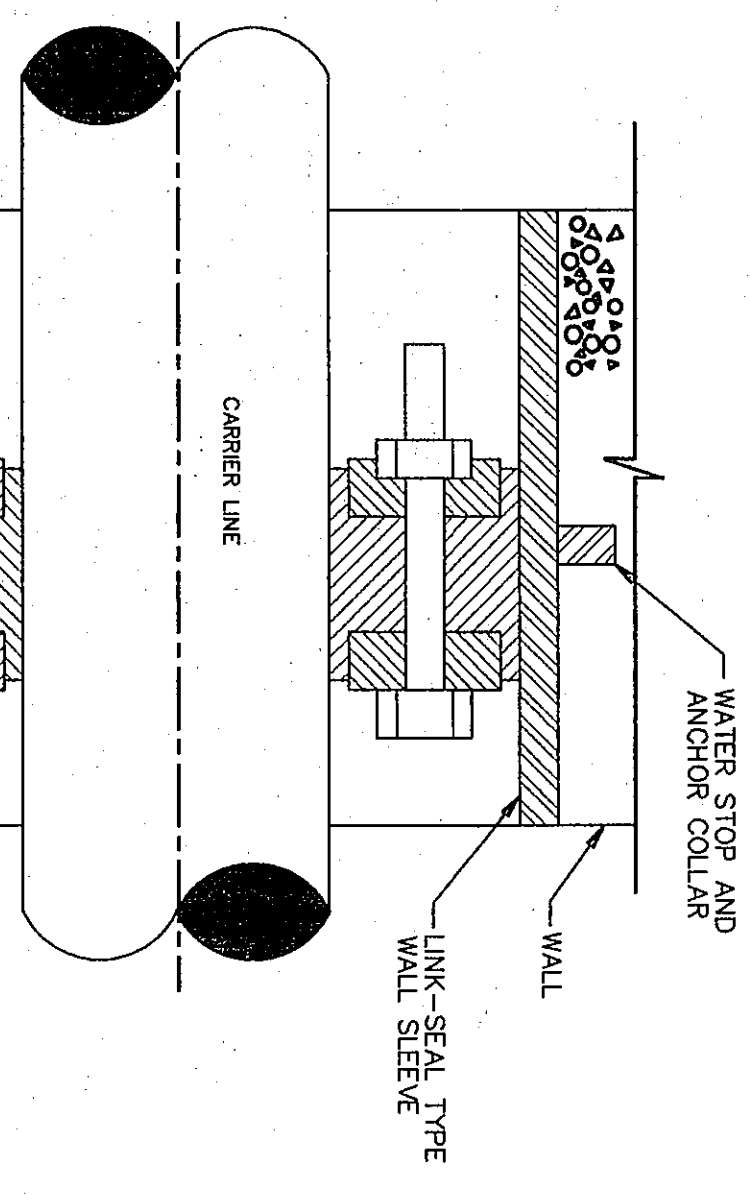


WALL/FLOOR SLEEVE DETAIL
NOT TO SCALE

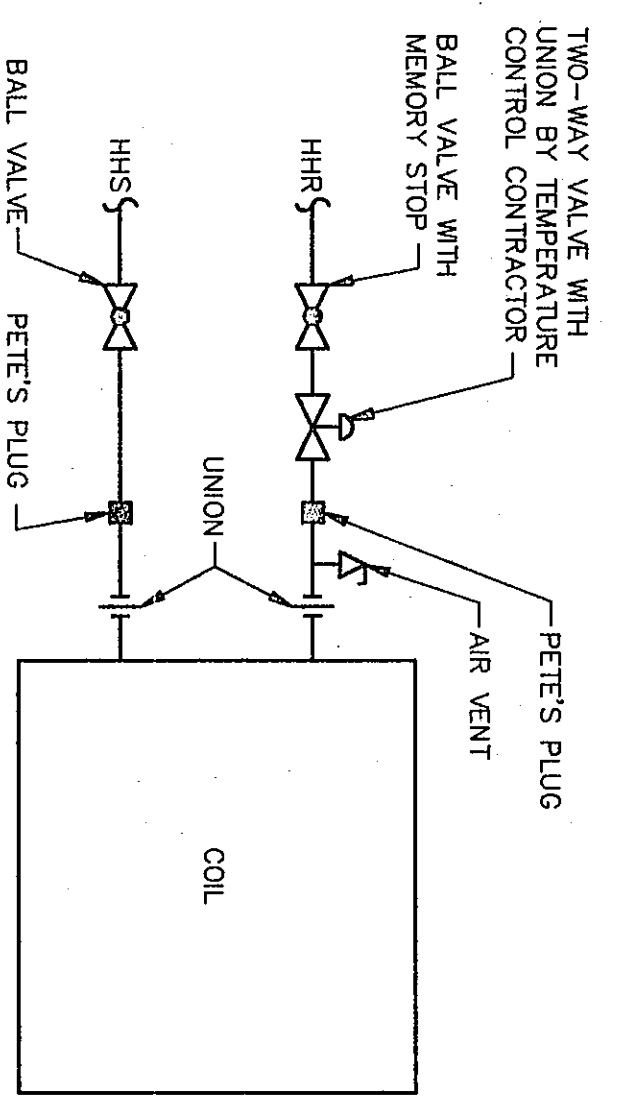


CAR. HEATER & BLOWER COIL PIPING DTL.
NOT TO SCALE

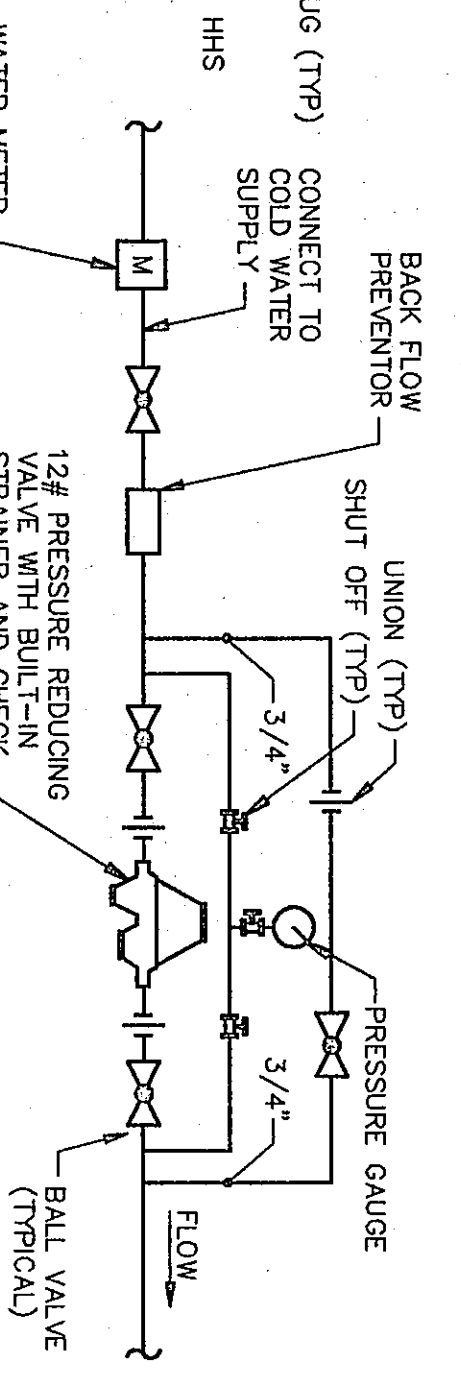


COLD WATER MAKE-UP DETAIL
NOT TO SCALE

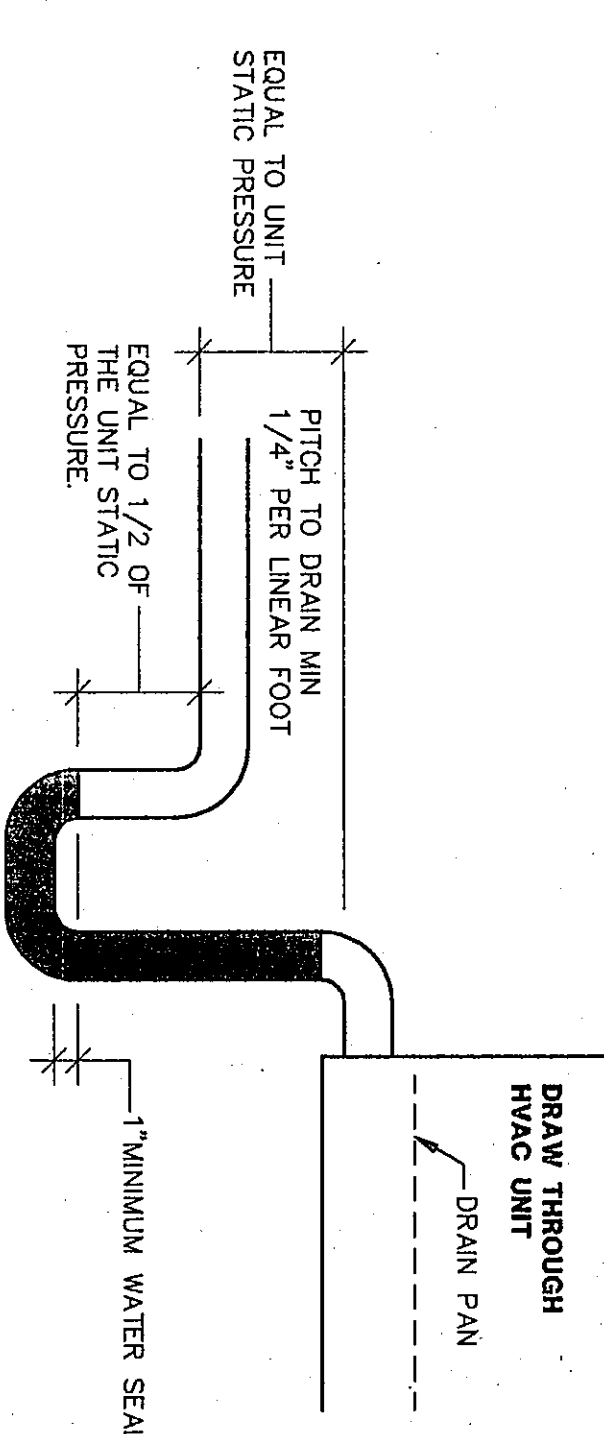


MANUAL AIR VENT DETAIL
NOT TO SCALE

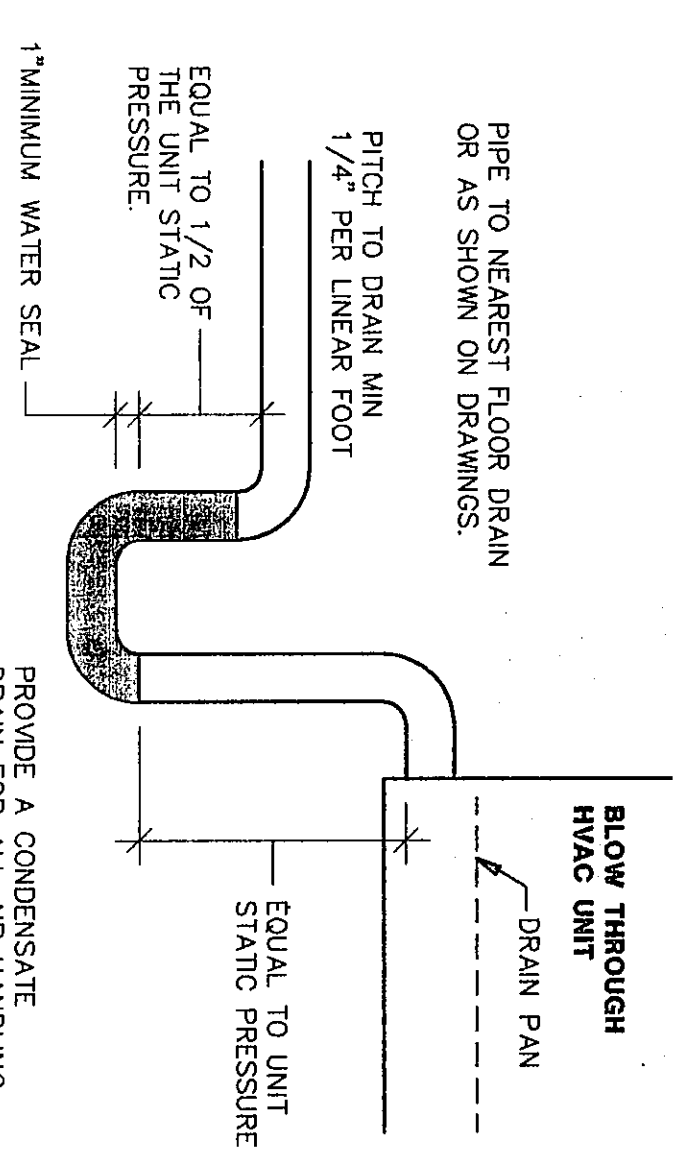


CONDENSATE TRAP PIPING DETAIL
NOT TO SCALE

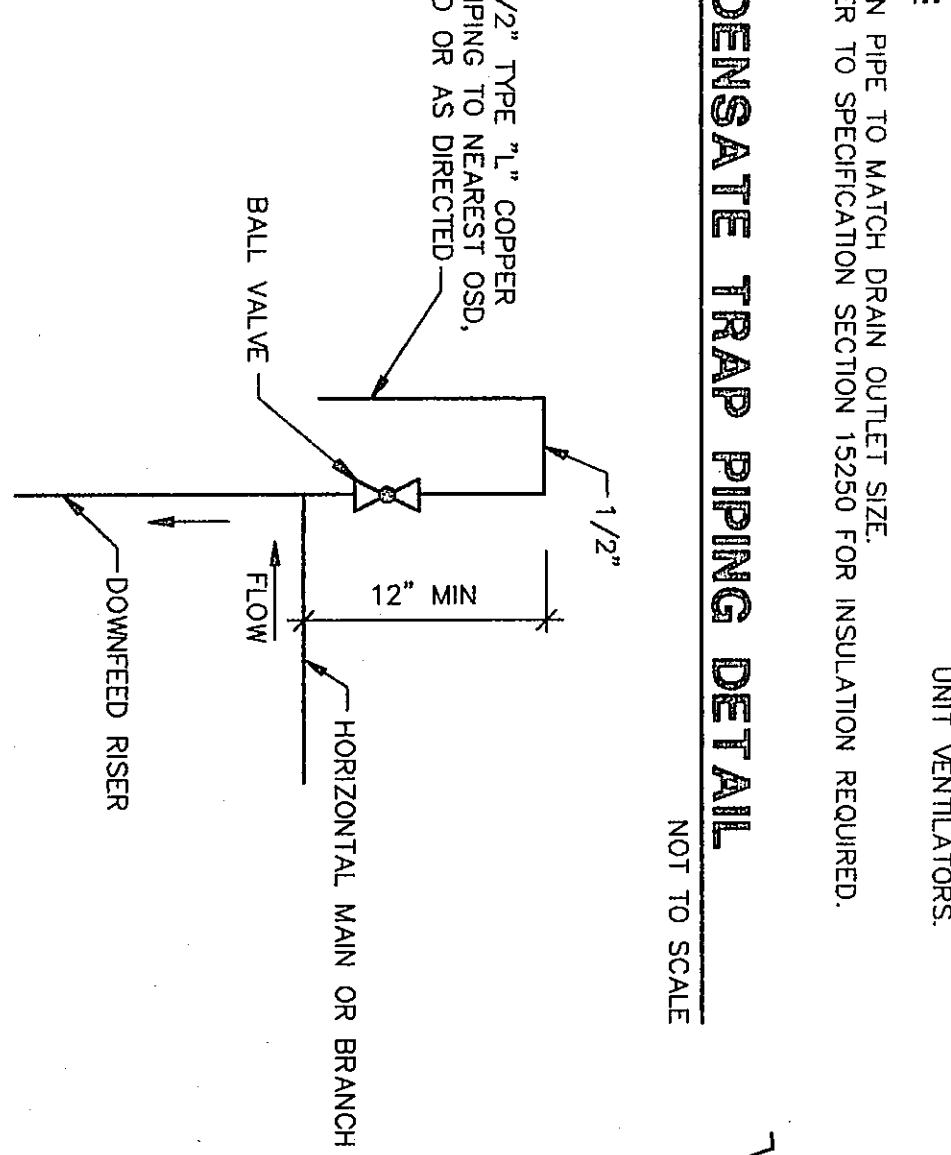


VAV COIL PIPING DETAIL
NOT TO SCALE

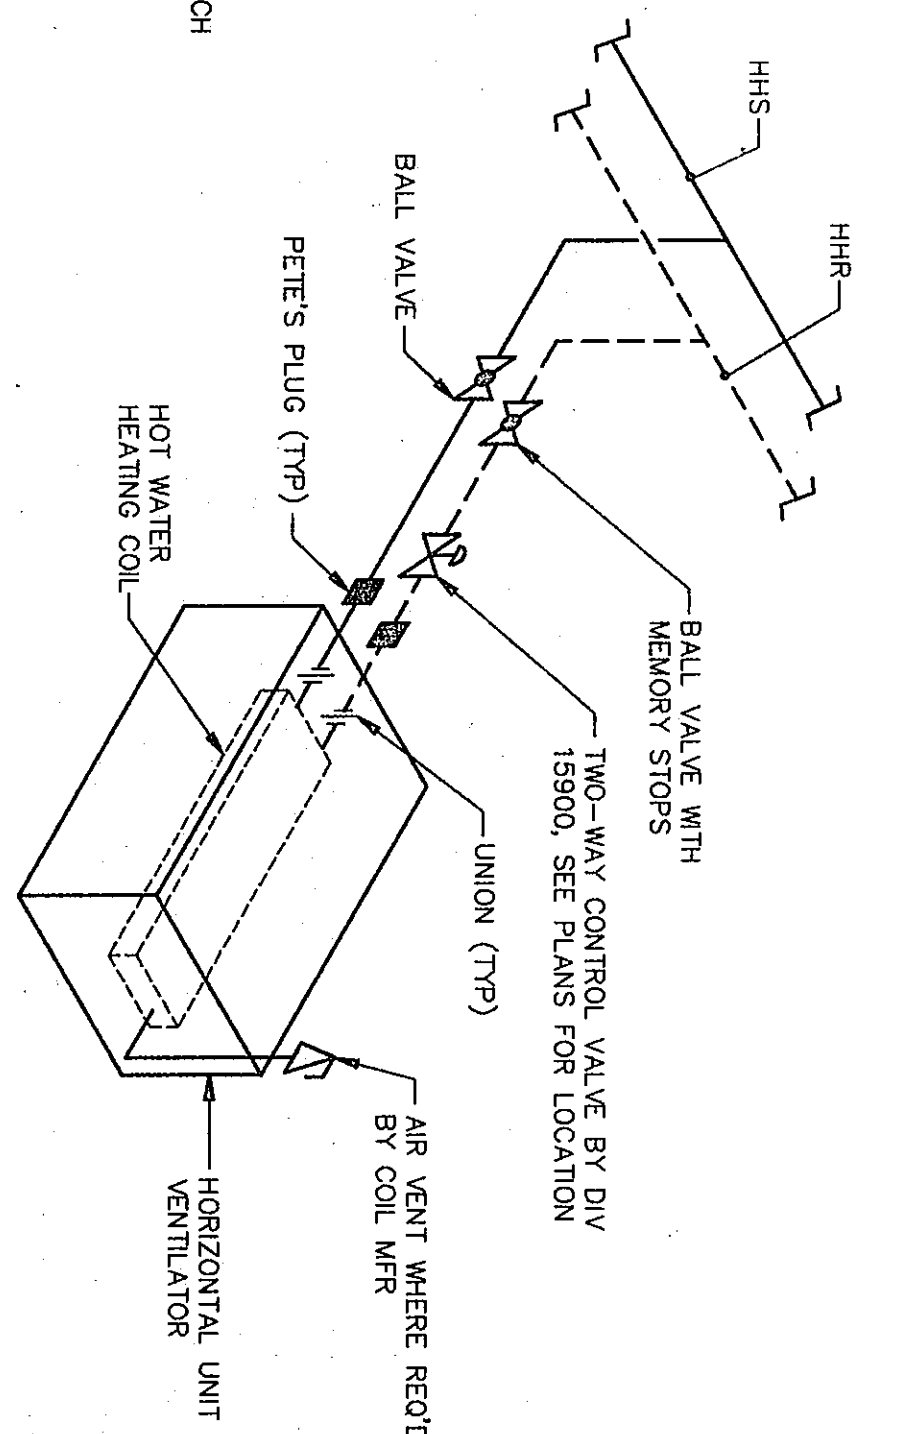


HORIZONTAL U.V. PIPING DETAIL
NOT TO SCALE

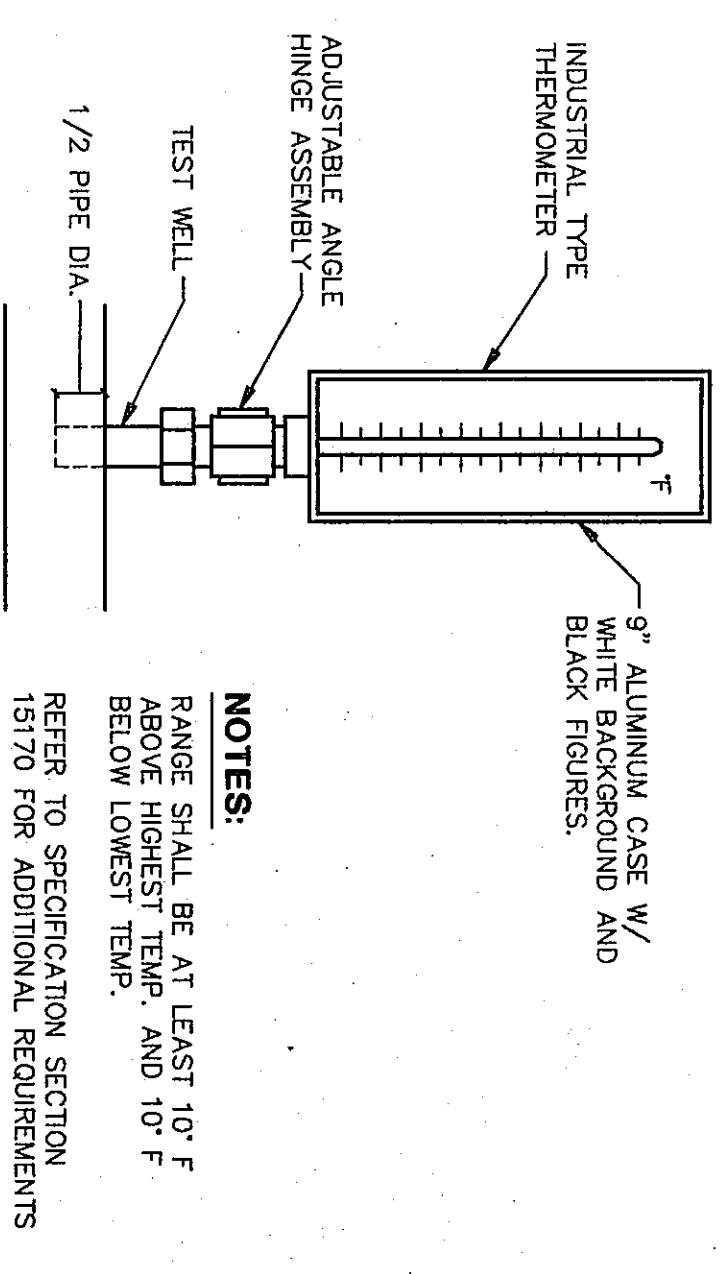


TYPICAL THERMOMETER DETAIL
NOT TO SCALE

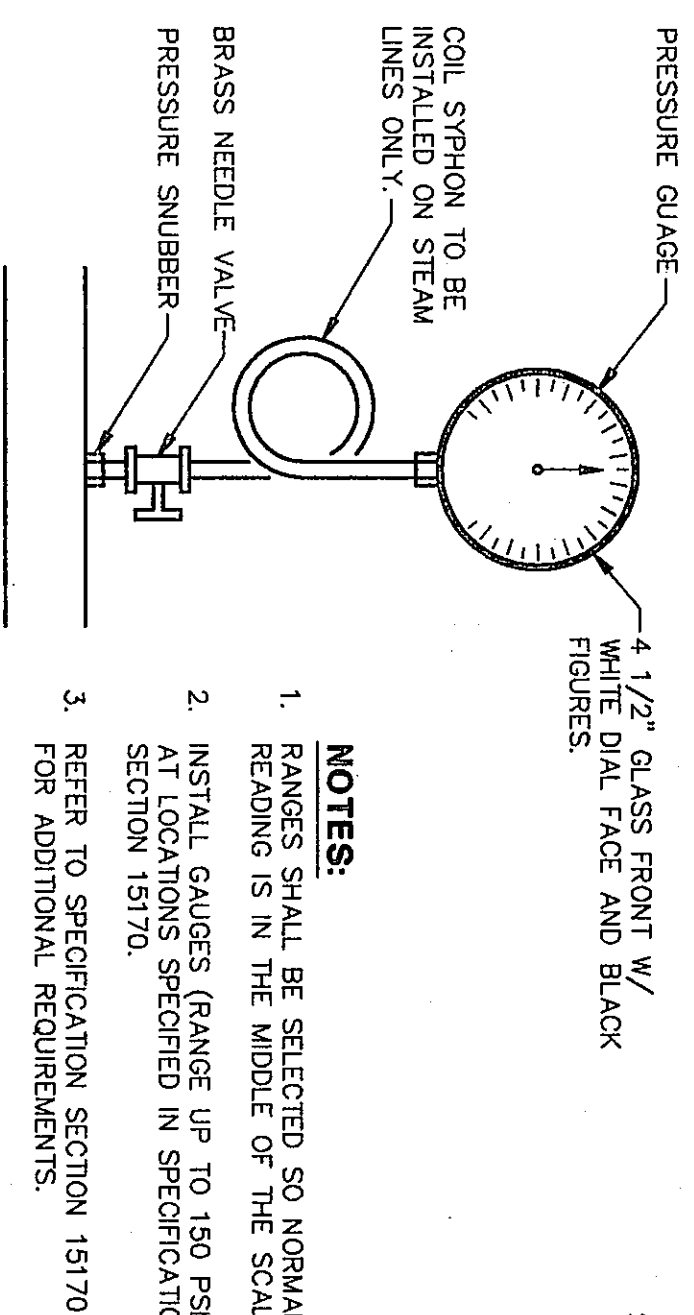


TYPICAL PRESSURE GAUGE DETAIL
NOT TO SCALE

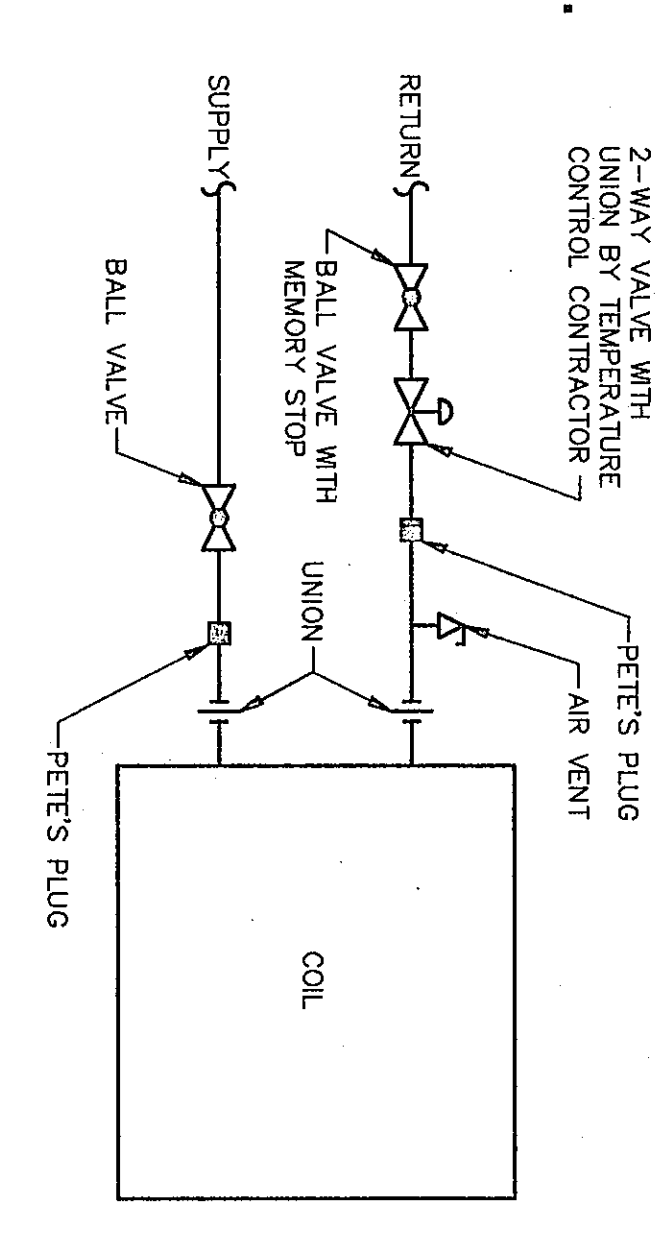

FAN COIL PIPING DETAIL
NOT TO SCALE

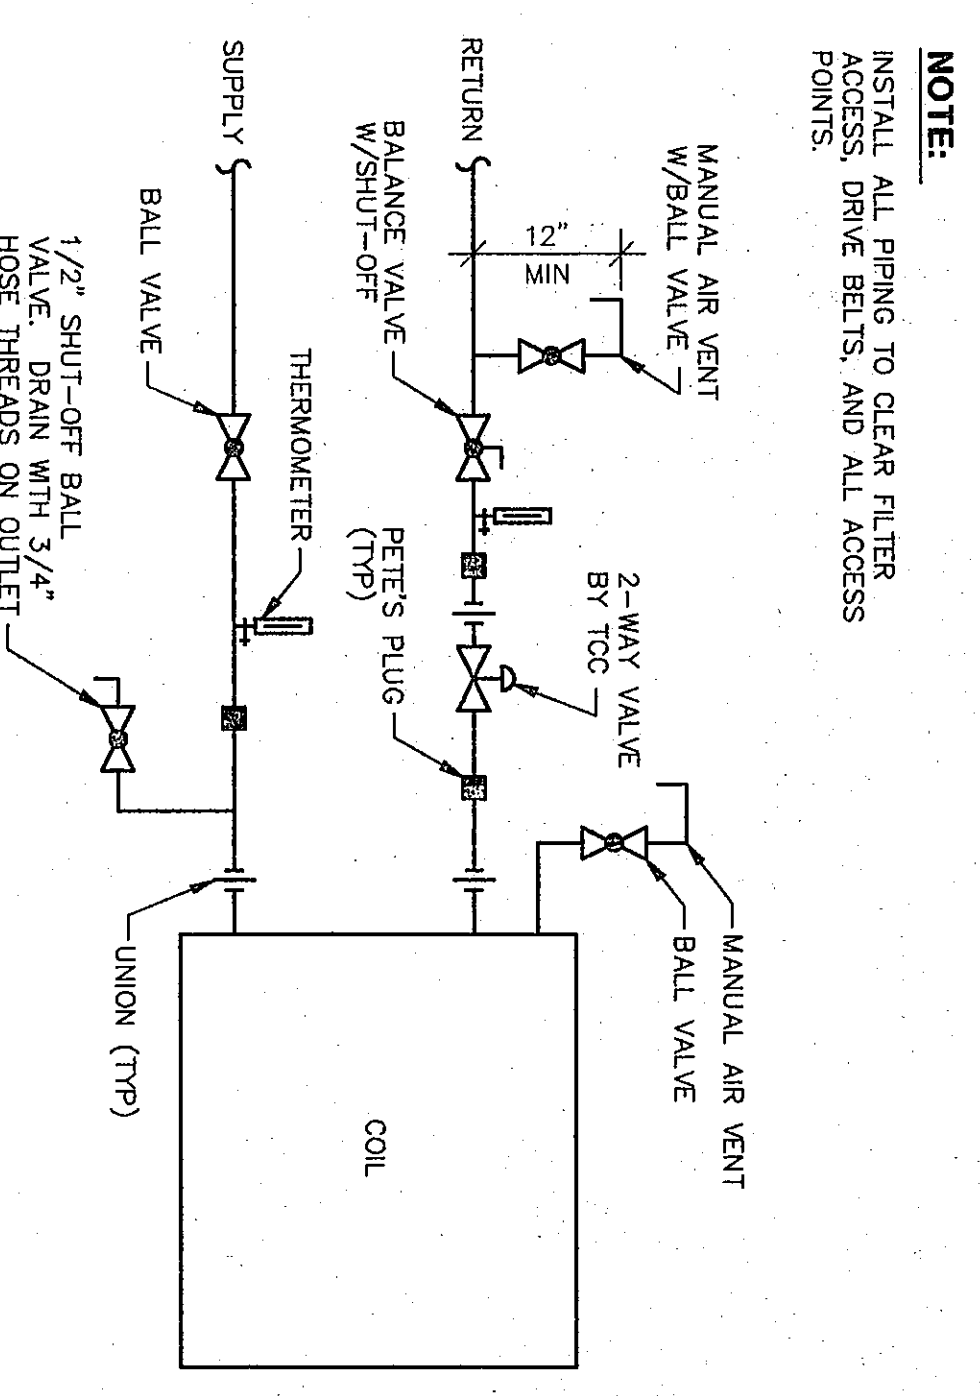


AIR HANDLER COIL PIPING DETAIL
NOT TO SCALE

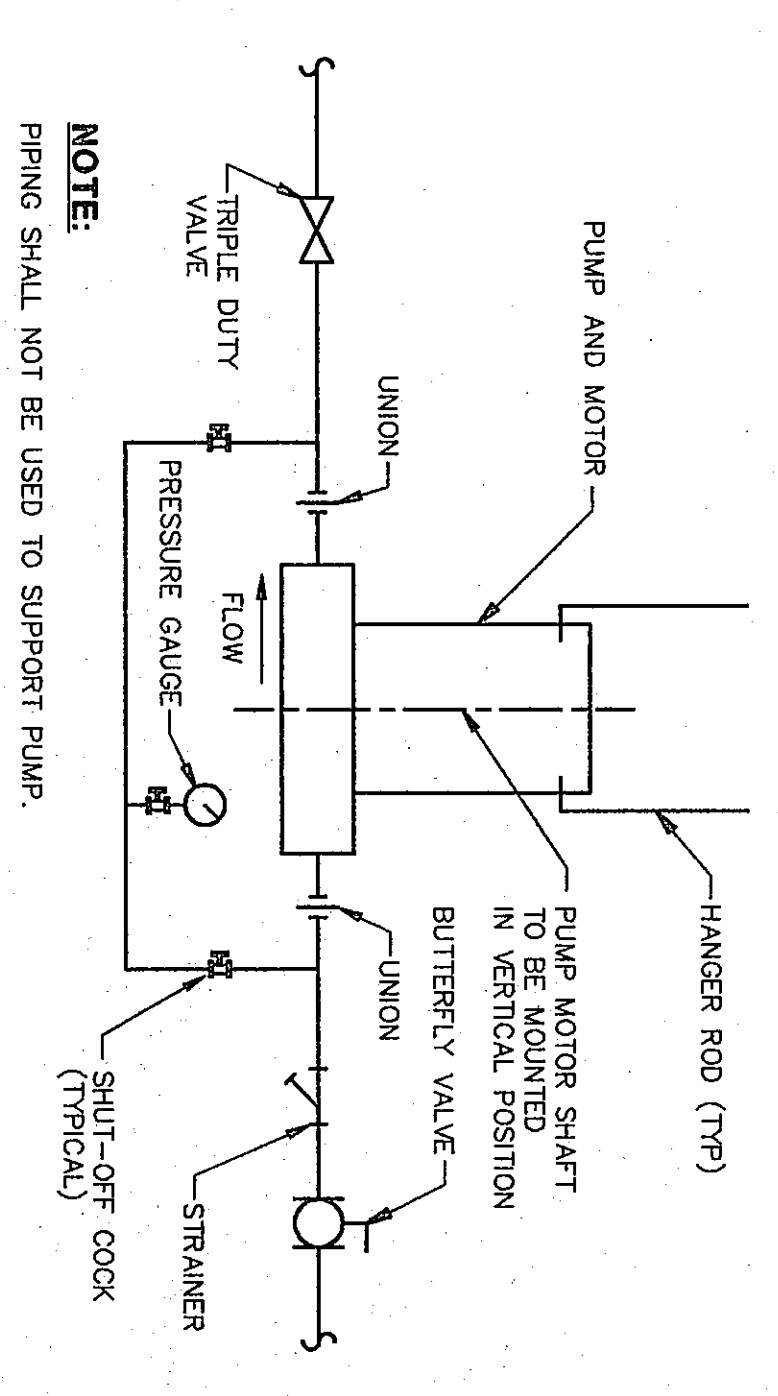


IN-LINE PUMP PIPING DETAIL
NOT TO SCALE

COPYRIGHT 1997 BY FANNING/HOWEY ASSOCIATES, INC.

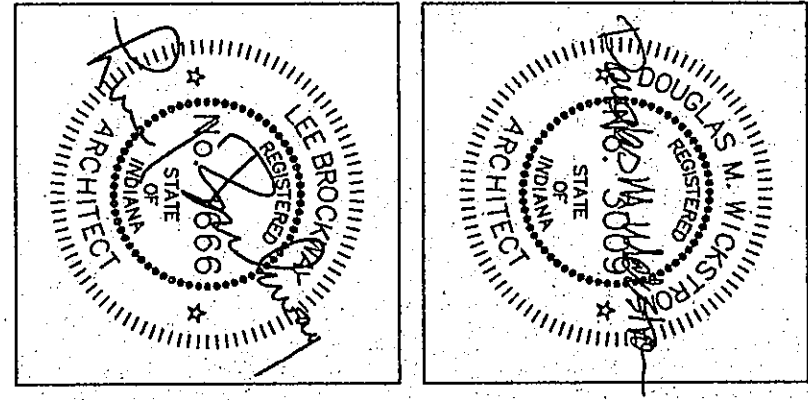

THE NEW
CHESTERTON HIGH SCHOOL
FOR THE
DUNELAND SCHOOL CORPORATION
CHESTERTON, INDIANA

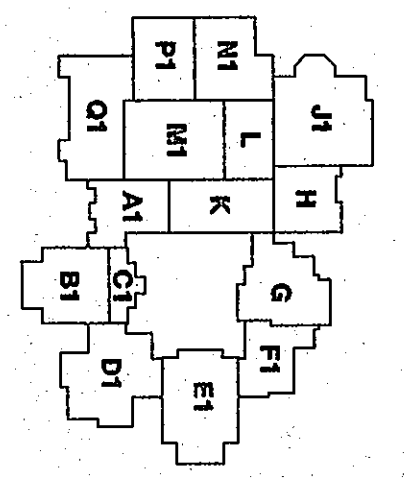

Fanning/Howey Associates, Inc.
Architects Engineers Consultants

HEATING DETAILS
DRAWN BY: SCB
CHECKED BY: CAM
COMM. NO.: 95067.00
DATE: APRIL 21, 1997
REVISIONS NO. DATE
M5.1