



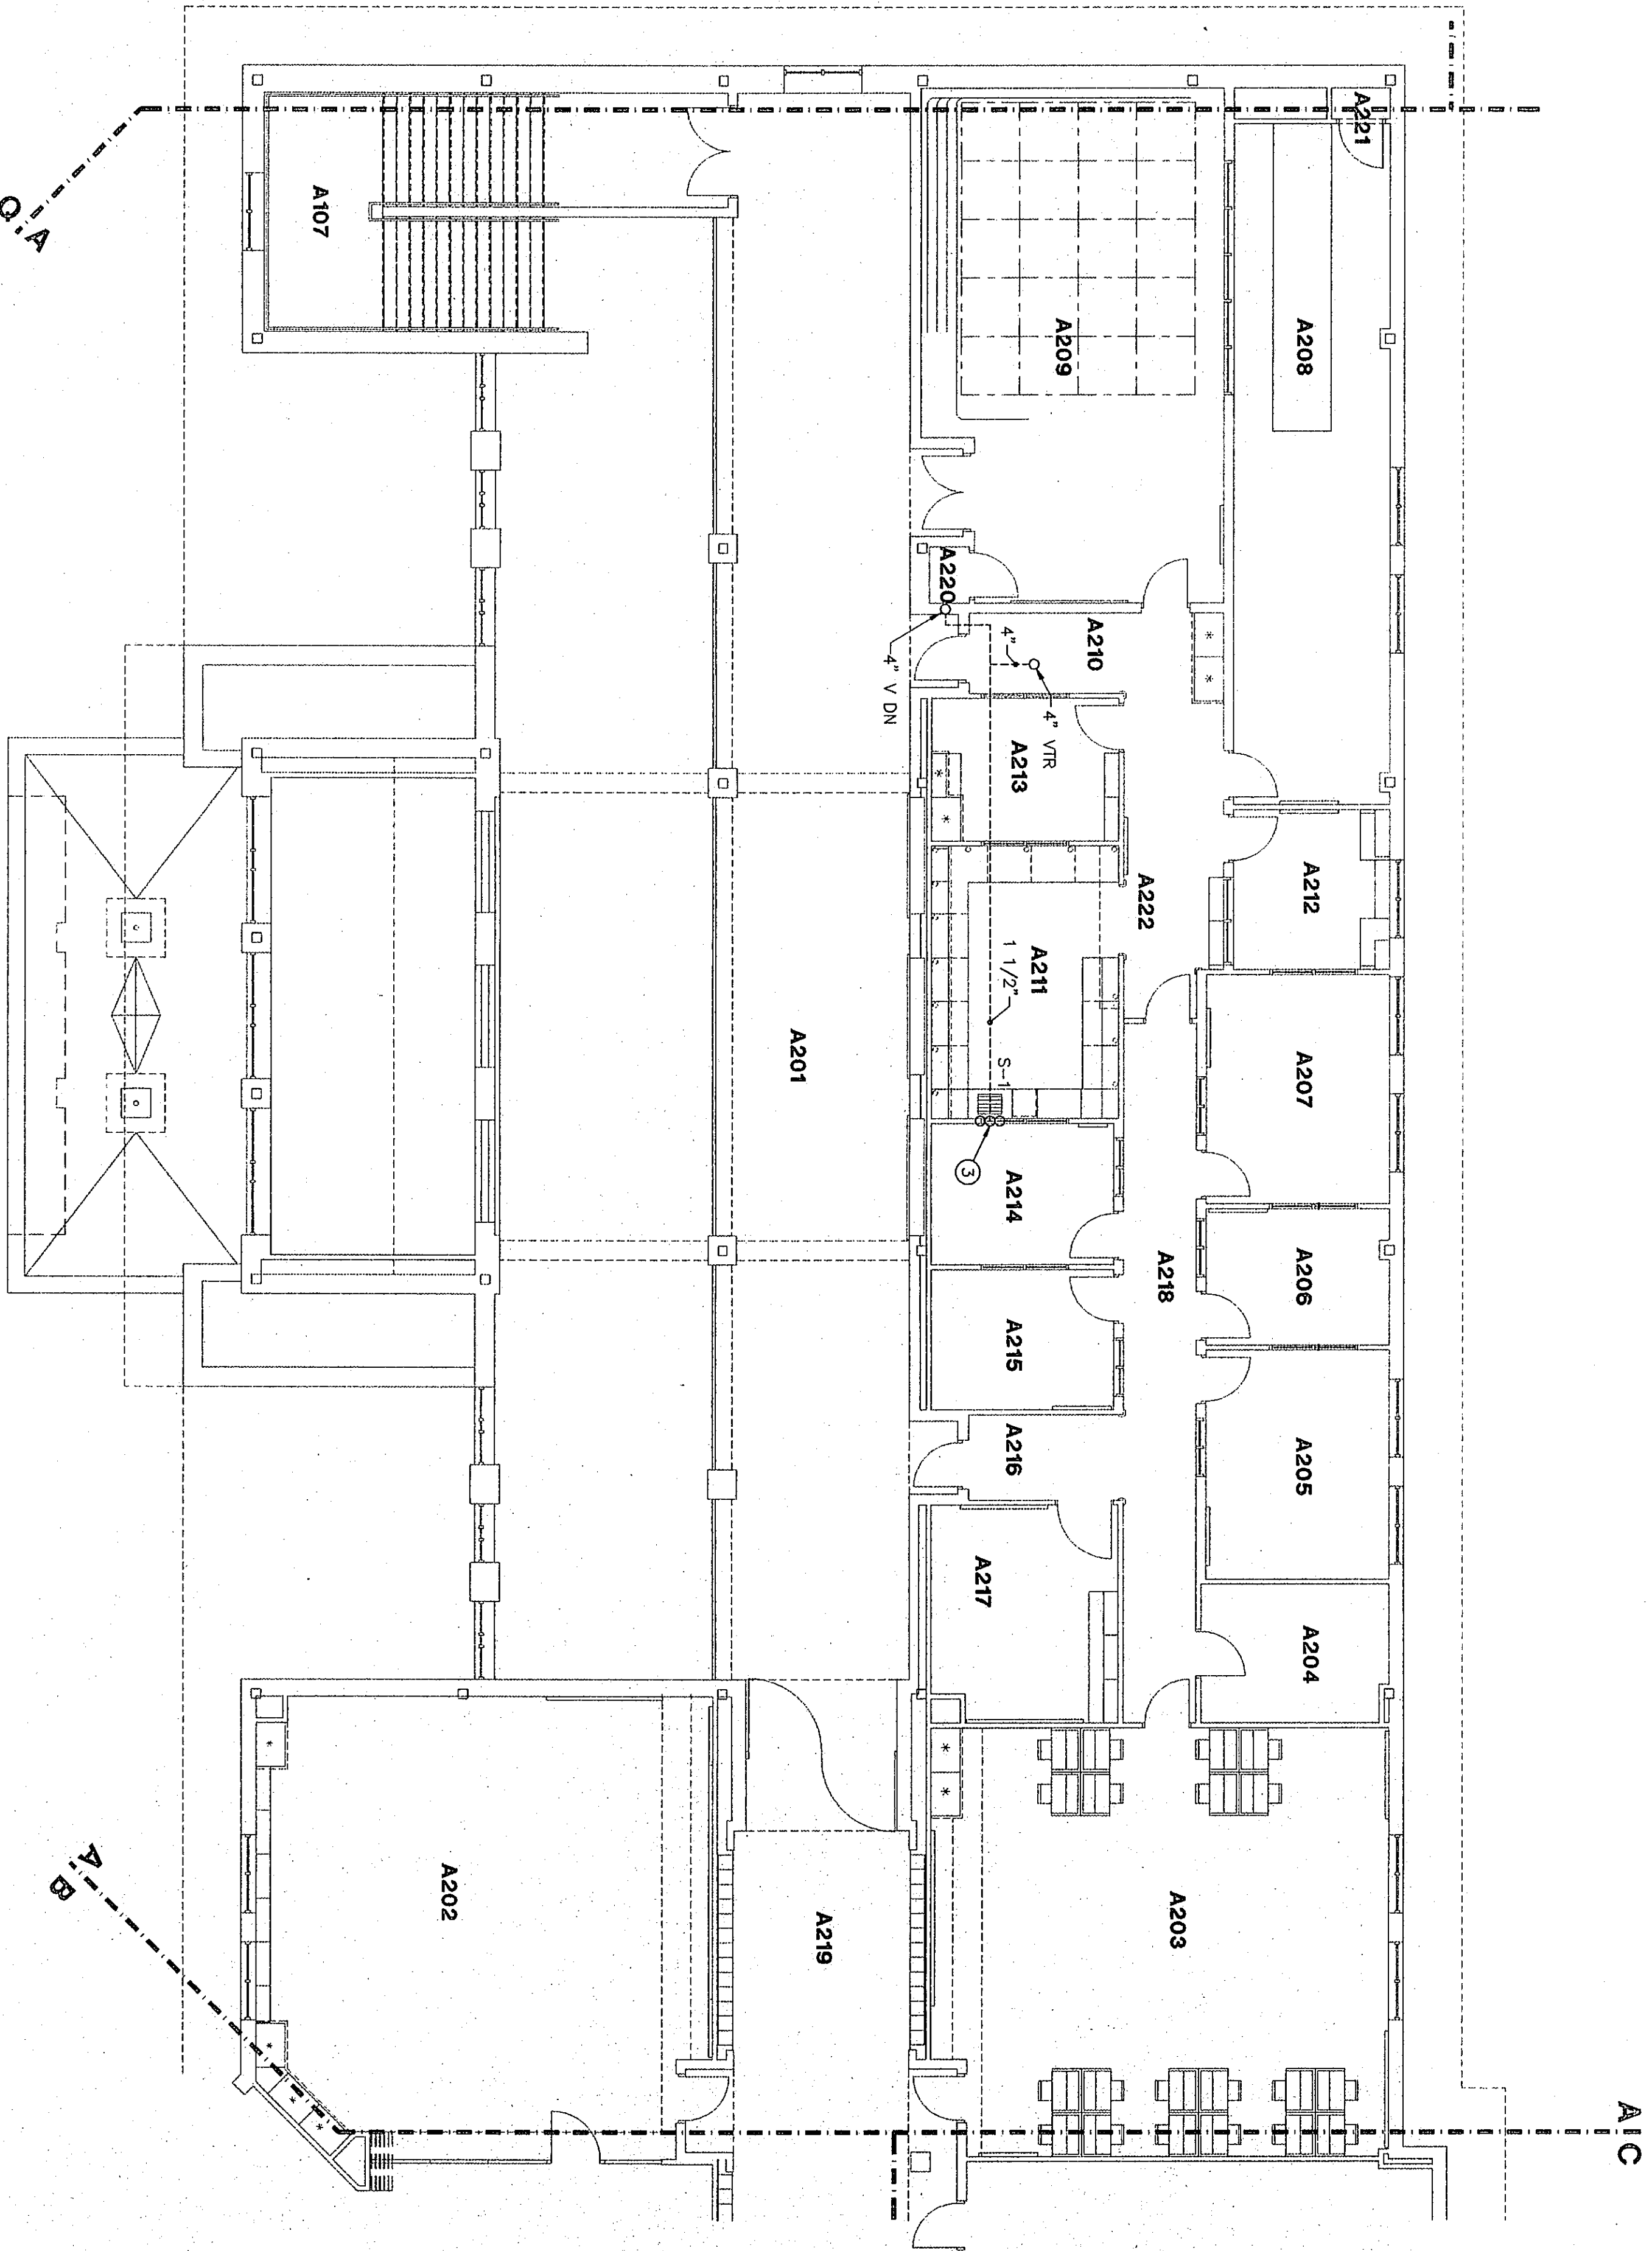

FLOOR PLAN UNIT "A2"

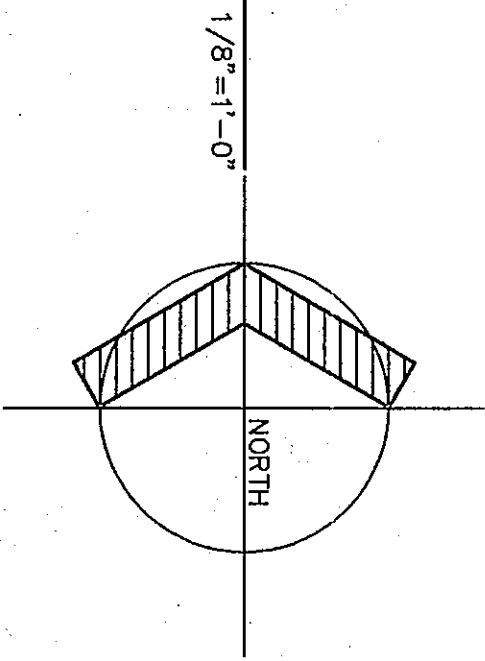

ROOM LEGEND "A2"			
ROOM NO.	ROOM NAME	AREA	CEILING HEIGHT
A201	CORRIDOR	182	9'-4"
A202	CLASSROOM	902	9'-4"
A203	CLASSROOM	902	9'-4"
A204	LIBRARY	120	9'-4"
A205	NEWS	119	9'-4"
A206	NEWS	119	9'-4"
A207	STUDIO	201	9'-4"
A208	STUDIO	201	9'-4"
A209	STUDIO	201	9'-4"
A210	STUDIO	201	9'-4"
A211	STUDIO	201	9'-4"
A212	STUDIO	201	9'-4"
A213	STUDIO	201	9'-4"
A214	STUDIO	201	9'-4"
A215	STUDIO	201	9'-4"
A216	STUDIO	201	9'-4"
A217	STUDIO	201	9'-4"
A218	STUDIO	201	9'-4"
A219	STUDIO	201	9'-4"
A220	STUDIO	201	9'-4"
A221	STUDIO	201	9'-4"
A222	STUDIO	201	9'-4"

PLUMBING PLAN NOTES:

- 1/2" H&C WATER, 1 1/2" WASTE UP TO FUTURE ABOVE
- 1/2" COLD WATER UP AND DOWN TO DMC.
- 1/2" HOT AND COLD WATER, 1 1/2" WASTE DOWN TO FLOOR BELOW.
- 1/2" COW DOWN TO 6" ABOVE FLOOR. VALVE AND CAP FOR REFRIGERATION ICEMAKER.
- DISHWASHER TO BE CONNECTED TO WATER AND WASTE PLUMBING OF ADJACENT SINK.
- HOT WATER AND/OR COLD WATER, GAS, AND SANITARY VENT PIPING ARE TO BE INSTALLED IN COVERED FLOOR VENT CHASES TO BE DETAIL OF THROUGH INCLUDED ON ARCHITECTURAL PLANS.
- HOT WATER AND/OR COLD WATER AND/OR GAS AND/OR SANITARY VENT PIPING TO BE INSTALLED IN BASE FRAMING OF CASEWORK BENEATH CABINETRY AND ABOVE FLOOR. "IN-SINK-EXTRACTOR", MODEL 77, 3/4 HP.
- INSTALL DISPOSER AT THIS LOCATION. TO BE "IN-SINK-EXTRACTOR", MODEL 77, 3/4 HP.
- GAS PIPING DOWN TO SQUEED VALVE WITHIN RECESSED CABINET, AND UP FROM CABINET. REFER TO DETAIL.
- WASHING MACHINE FITTING. REFER TO DETAIL DMC. P.3.1
- 1/2" GAS AT 6" ABOVE FLOOR WITH STOP VALVE FOR RANGE CONNECTION.
- DABROOM SINK WITH MIXING FAUCET BY DIVISION 11.470. ISCO. VENT. ALL CONNECTIONS.
- 1/2" COMPRESSED AIR PIPING DOWN TO 48" ABOVE FINISHED FLOOR. ALL AND BE WITH BRL LEG. AND FLS FOR FUTURE QUICK DISCONNECT BY OWNER.
- GAS REGULATOR TO PROVIDE 48 CU. FT. OF 7"WC NATURAL GAS PRESSURE FROM 2" FS. REFER TO DETAIL DMC. P.3.1
- GAS VALVE CABINET REFER TO DETAIL DMC. P.3.1
- COMPRESSED AIR PRESSURE REGULATOR PIPING DETAIL. REFER TO DETAIL DMC. P.3.1
- FLOOR DRAIN TO BE JOM. 3523-2, WITH HINGED GRATE AND SEDIMENT BUCKET. TO BE INSTALLED W/ TRAP
- SUMP PUMP TO BE LITTLE GALT MODEL GE-014-BRS TO PUMP 30 GPM @ 20 FT. HD. 1/2 HP. 120V. COMPLETE WITH CHECK VALVE, UNION AND 24" BASIN
- 1 1/2" OPEN SITE DRAIN. SEE DETAIL DMC. P.3.1. LOCATE ABOVE CEILING TO ALLOW FOR MAINTENANCE ACCESS.


21-P-03

PLUMBING PLAN UNIT "A2"


DRAWN BY: JUD COMM. NO: 95067.00
CHECKED BY: CAM DATE: APRIL 21, 1997

P2.2

REVISIONS NO. DATE

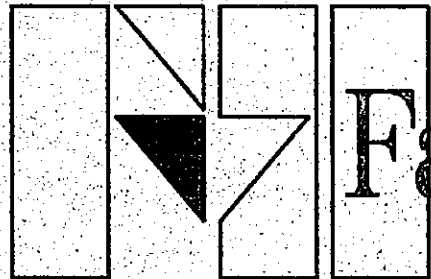

Fanning/Howey
Associates, Inc.
Architects Engineers Consultants

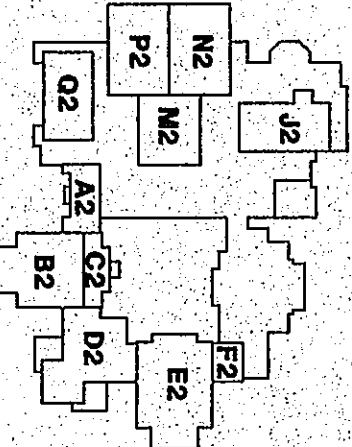

THE NEW
CHESTERTON HIGH SCHOOL
FOR THE
DUNELAND SCHOOL CORPORATION
CHESTERTON, INDIANA

COPYRIGHT 1997 BY FANNING/HOWEY ASSOCIATES, INC.

