


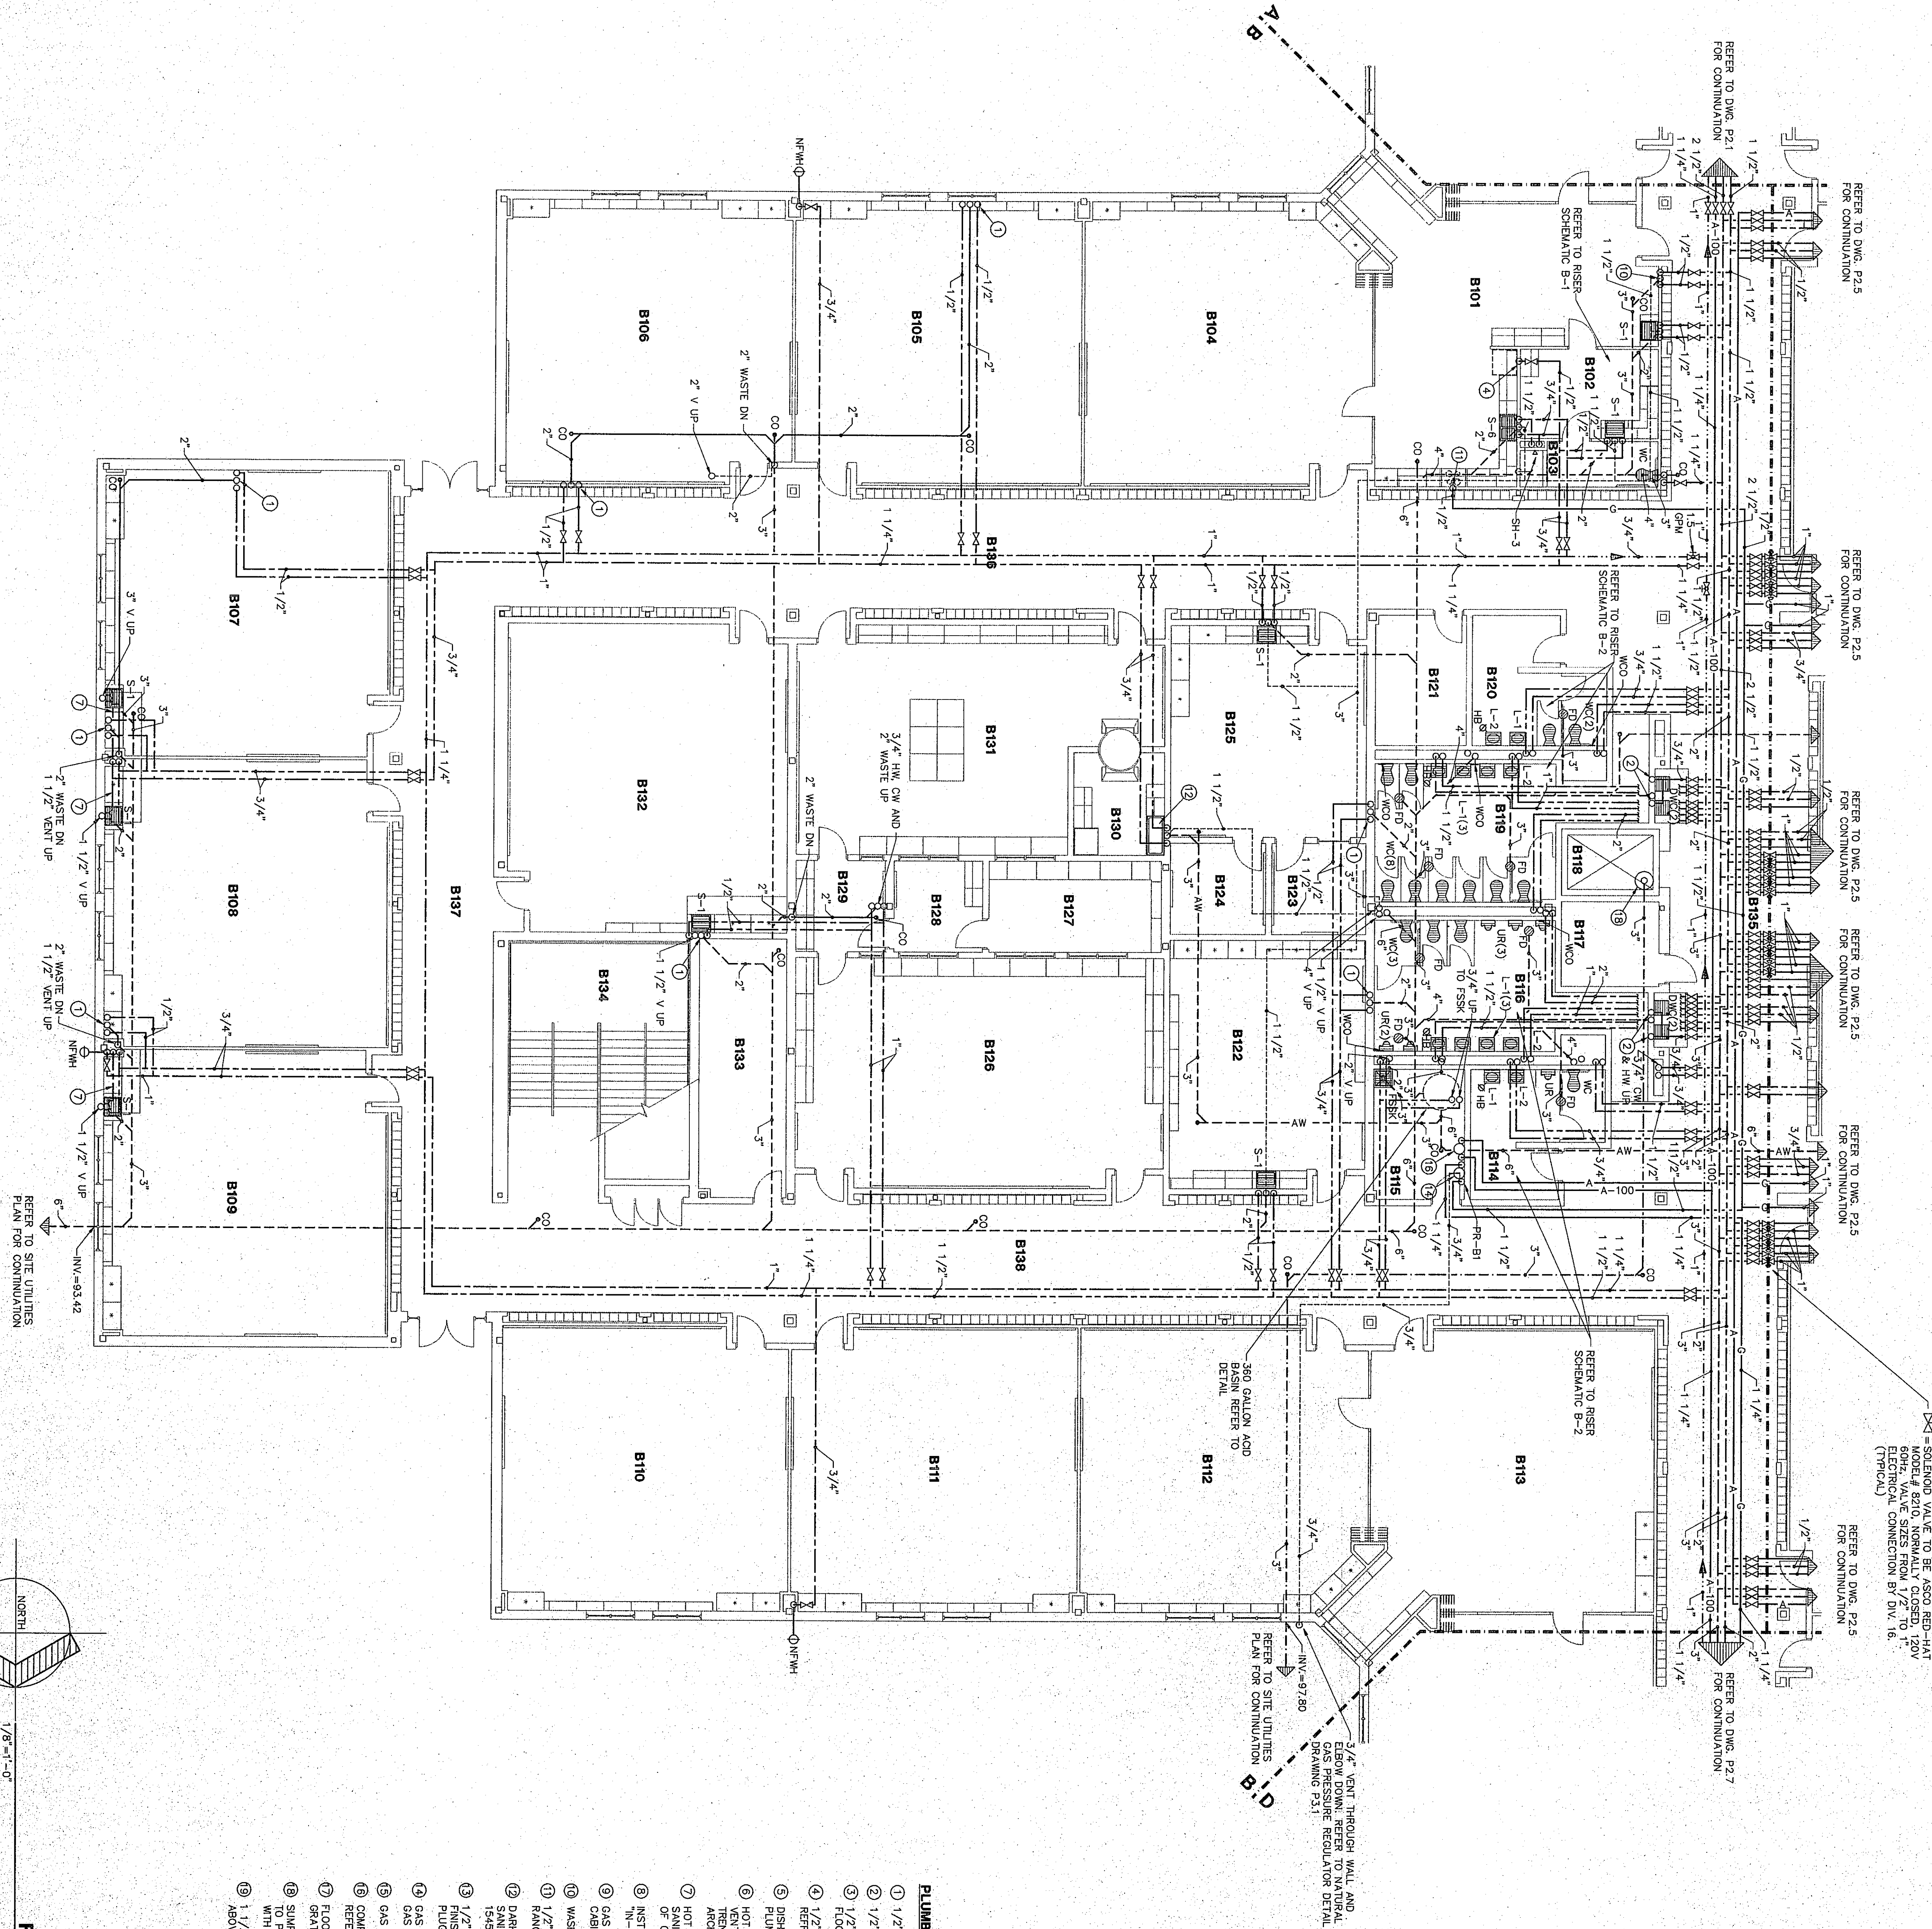

ROOM LEGEND "B"			
ROOM NO.	ROOM NAME	AREA S.F.	CEILING HEIGHT
B101	HEALTH MAINTENANCE	753	9'-4"
B102	HEALTH MAINTENANCE	753	9'-4"
B103	HEALTH MAINTENANCE	753	9'-4"
B200	HEALTH MAINTENANCE	753	9'-4"

PLUMBING PLAN NOTES:

- 1/2" H&C WATER, 1/2" WASTE UP TO FUTURE ABOVE
- 1/2" COLD WATER UP AND DOWN TO DMC.
- 1/2" HOT AND COLD WATER, 1/2" WASTE DOWN TO FLOOR BELOW.
- 1/2" COLD WATER, 1/2" WASTE DOWN TO REFRIGERATOR COOLAGE.
- DISHWASHER TO BE CONNECTED TO WATER AND WASTE PLUMBING OF ADJACENT SINK.
- HOT WATER AND/OR COLD WATER, GAS, AND SANITARY VENT PIPING ARE TO BE INSTALLED IN COVERED FLOOR ARCHITECTURAL PLANS.
- HOT WATER AND/OR COLD WATER AND/OR GAS AND/OR SANITARY VENT PIPING TO BE INSTALLED IN BASE FRAMING OF CASEWORK, BENCH, CABINETS, AND ABOVE FLOOR.
- INSTALL DISPOSER AT THIS LOCATION, TO BE "N-SINK-EXTRACTOR", MODEL 77, 3/4" HP.
- GAS PIPING DOWN TO GAS ENJOY VALVE WITHIN RECESSED CABINET, AND UP FROM CABINET, REFER TO DETAIL.
- WASHING MACHINE FITTING, REFER TO DETAIL DMC P3.1 RANGE CONNECTION.
- 1/2" GAS AT 6" ABOVE FLOOR WITH STOP VALVE FOR RANGE CONNECTION.
- DARKROOM SINK WITH WARM FAUCET BY DIVISION 11470, 15500, VERIFY ALL CONNECTIONS.
- 1/2" COMPRESSED AIR PIPING DOWN TO 48" ABOVE FINISHED FLOOR, VALVE AND TEE WITH DIRT LEG, AND FLOOR FOR FUTURE SINK DISCONNECT BY OWNER.
- GAS REGULATOR TO PROVIDE 45 CU. FT. OF 7"WC NATURAL GAS PRESSURE FROM 2 PSI, REFER TO DETAIL DMC P3.1
- GAS VALVE CABINET REFER TO DETAIL DMC P3.1
- COMPRESSED AIR PRESSURE REGULATOR PIPING DETAIL, REFER TO DETAIL DMC P3.1
- FLOOR DRAIN TO BE JOSAY 3533-2, WITH HINGED GRATE AND SEDIMENT BUCKET, TO BE INSTALLED W/ TRAP
- SINK DRAIN TO BE LITTLE GANT MODEL 65-04-RS TO PUMP 30 GPM @ 20 FT. HEAD, 1/2" DIA. 1/2" DIA. COMPLETE WITH CHECK VALVE, UNION AND 24" BASIN
- 1/2" OPEN SITE DRAIN, SEE DETAIL DMC P3.1, LOCATE ABOVE CEILING TO ALLOW FOR MAINTENANCE ACCESS


FLOOR PLAN UNIT "B"

PLUMBING PLAN UNIT "B"


DRAWN BY: JD COMM. NO.: 95067.00
CHECKED BY: CAM DATE: APRIL 21, 1997

P2.3

REVISIONS NO. DATE

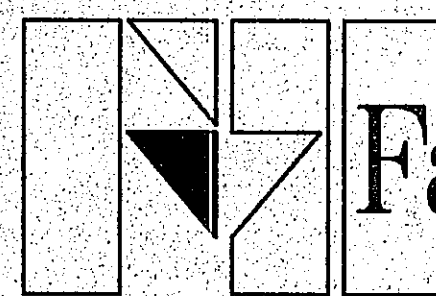

Fanning/Howey
Associates, Inc.
Architects Engineers Consultants

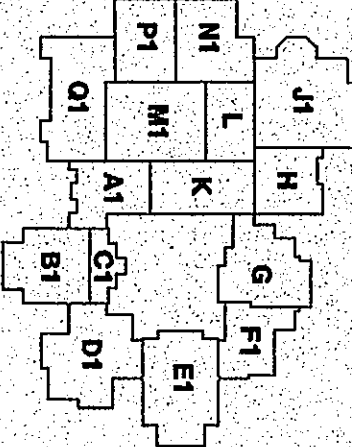

THE NEW
CHESTERTON HIGH SCHOOL
FOR THE
DUNELAND SCHOOL CORPORATION
CHESTERTON, INDIANA

COPYRIGHT 1997 BY FANNING/HOWEY ASSOCIATES, INC.

