


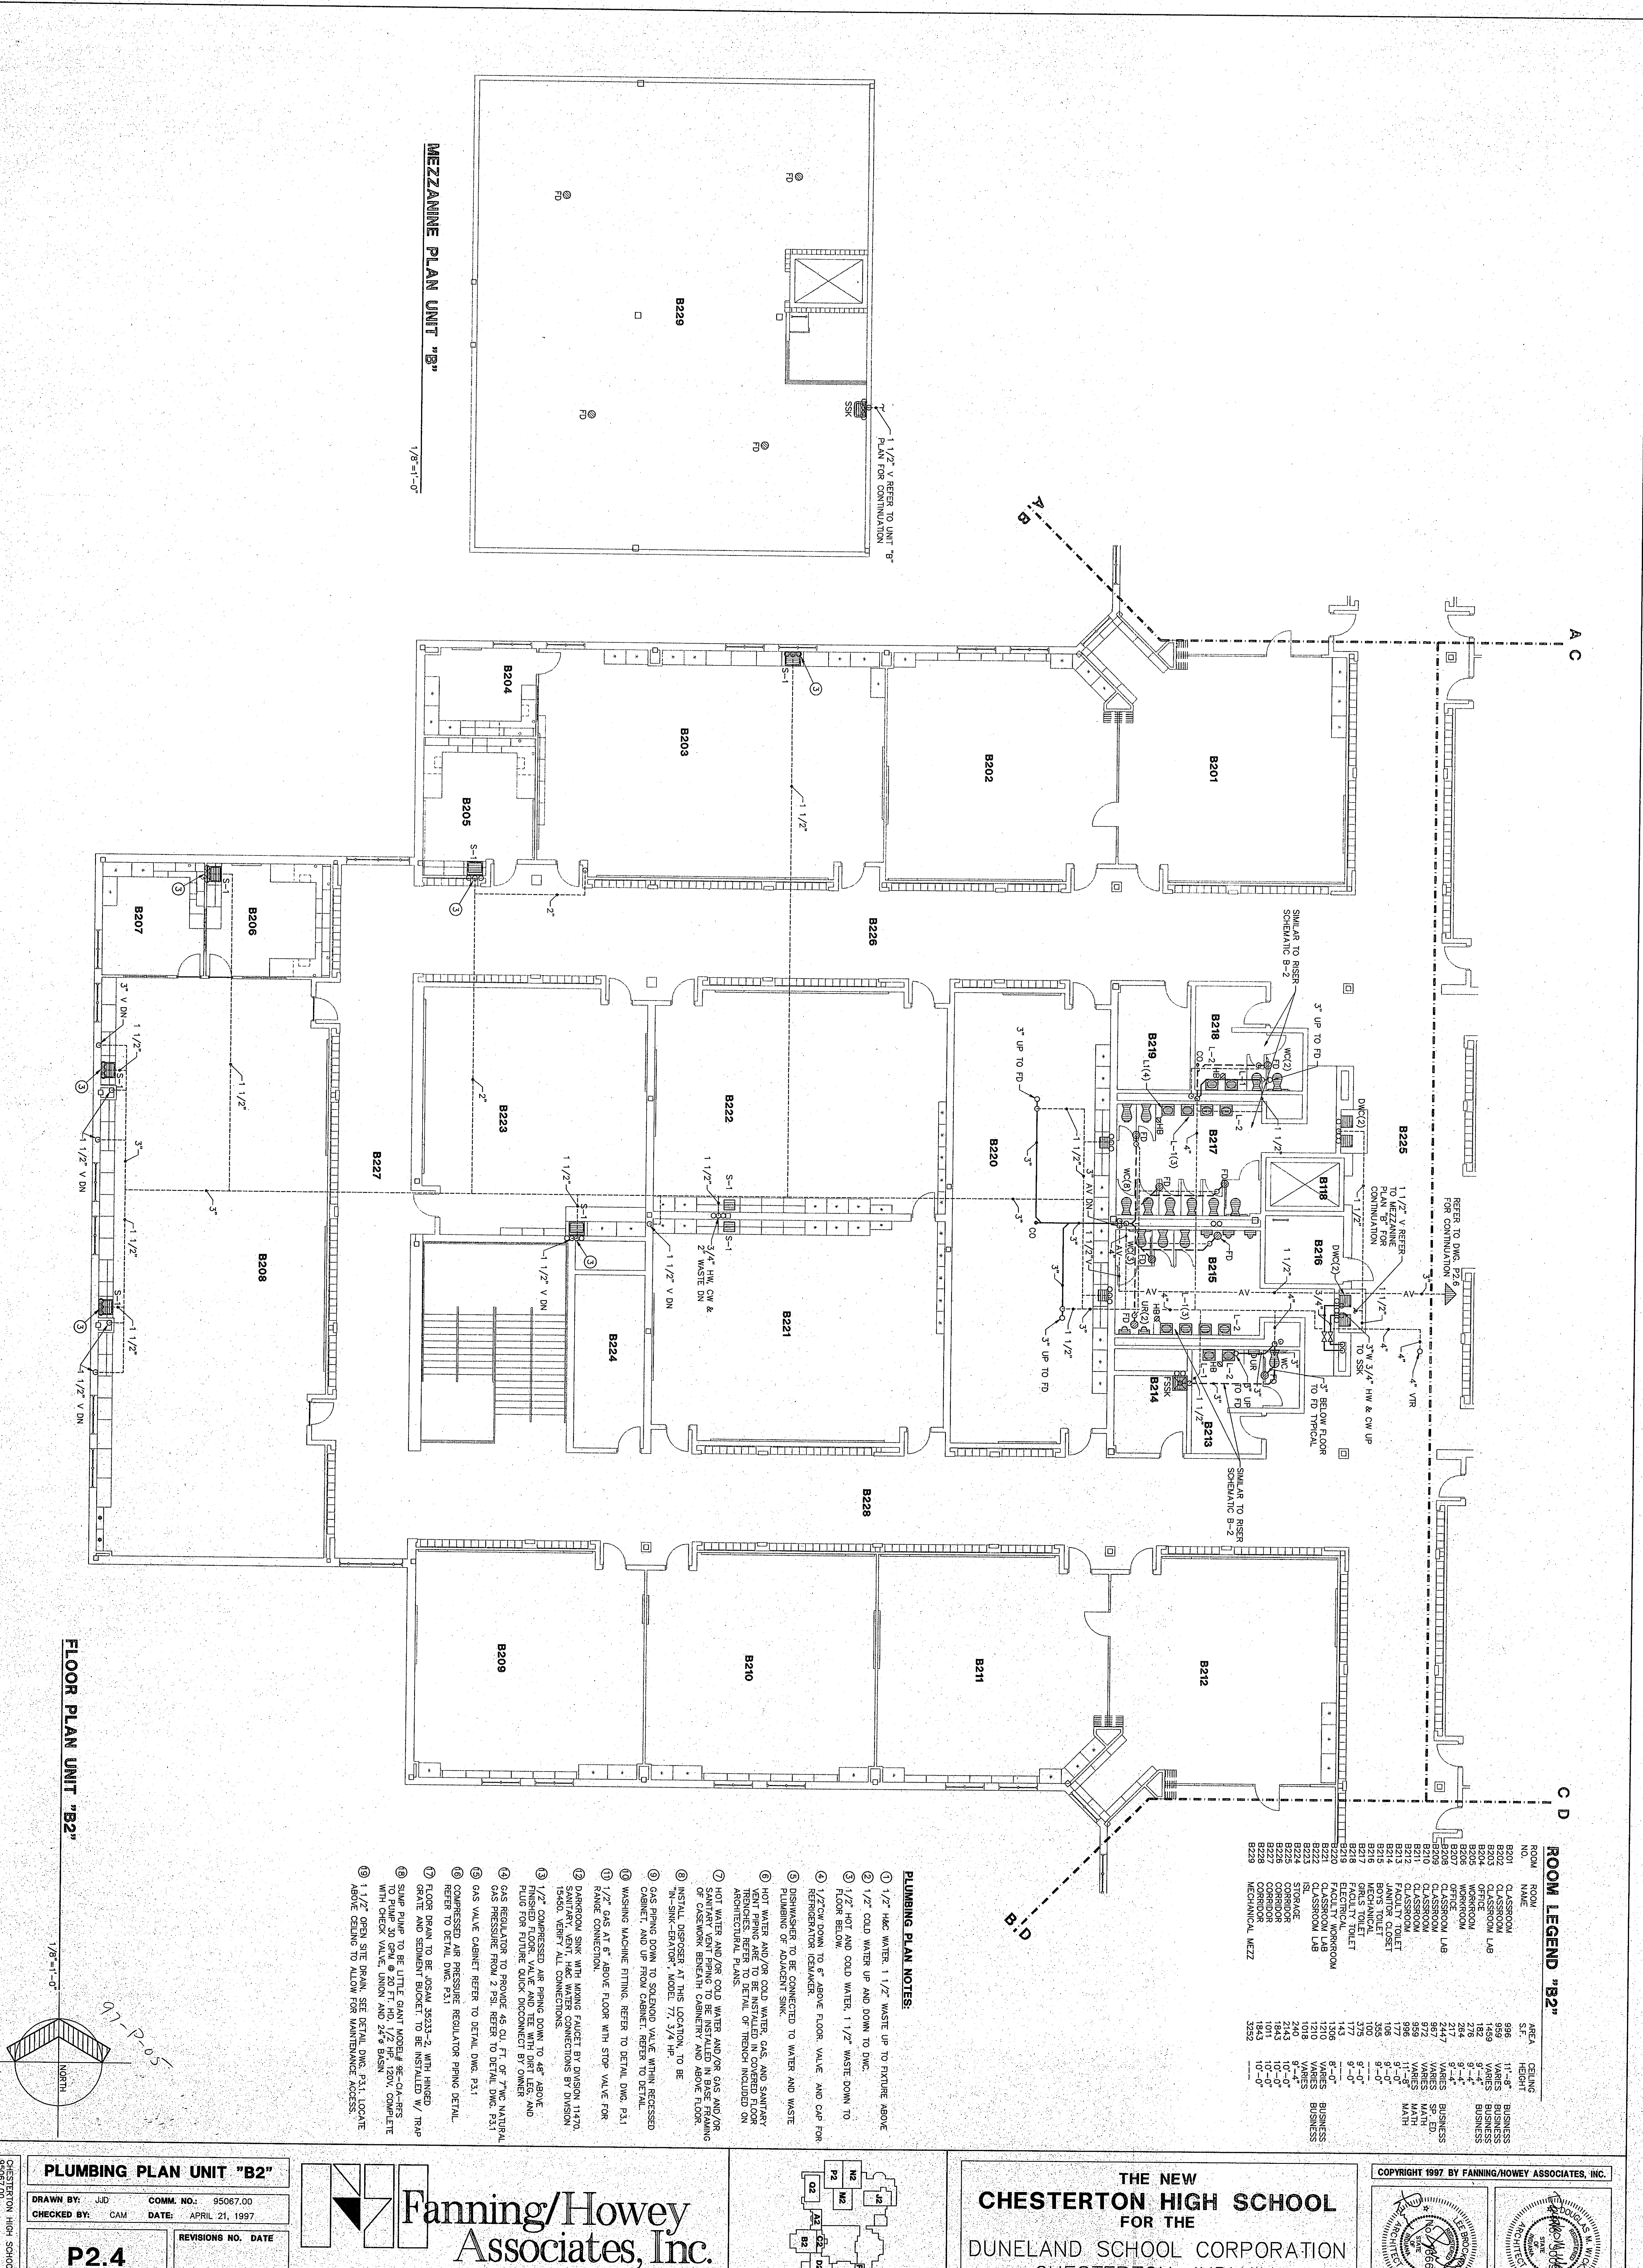


PLUMBING PLAN UNIT "B2"

DRAWN BY: JUD COMM. NO.: 95067.00
CHECKED BY: CAM DATE: APRIL 21, 1997

P2.4

REVISIONS NO. DATE

Fanning/Howey
Associates, Inc.
Architects Engineers Consultants

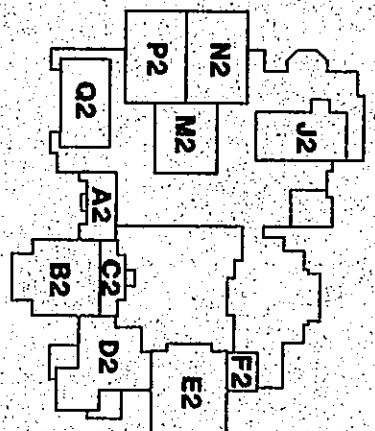

THE NEW
CHESTERTON HIGH SCHOOL
FOR THE
DUNELAND SCHOOL CORPORATION
CHESTERTON, INDIANA

COPYRIGHT 1997 BY FANNING/HOWEY ASSOCIATES, INC.

ARCHITECT

ENGINEER