
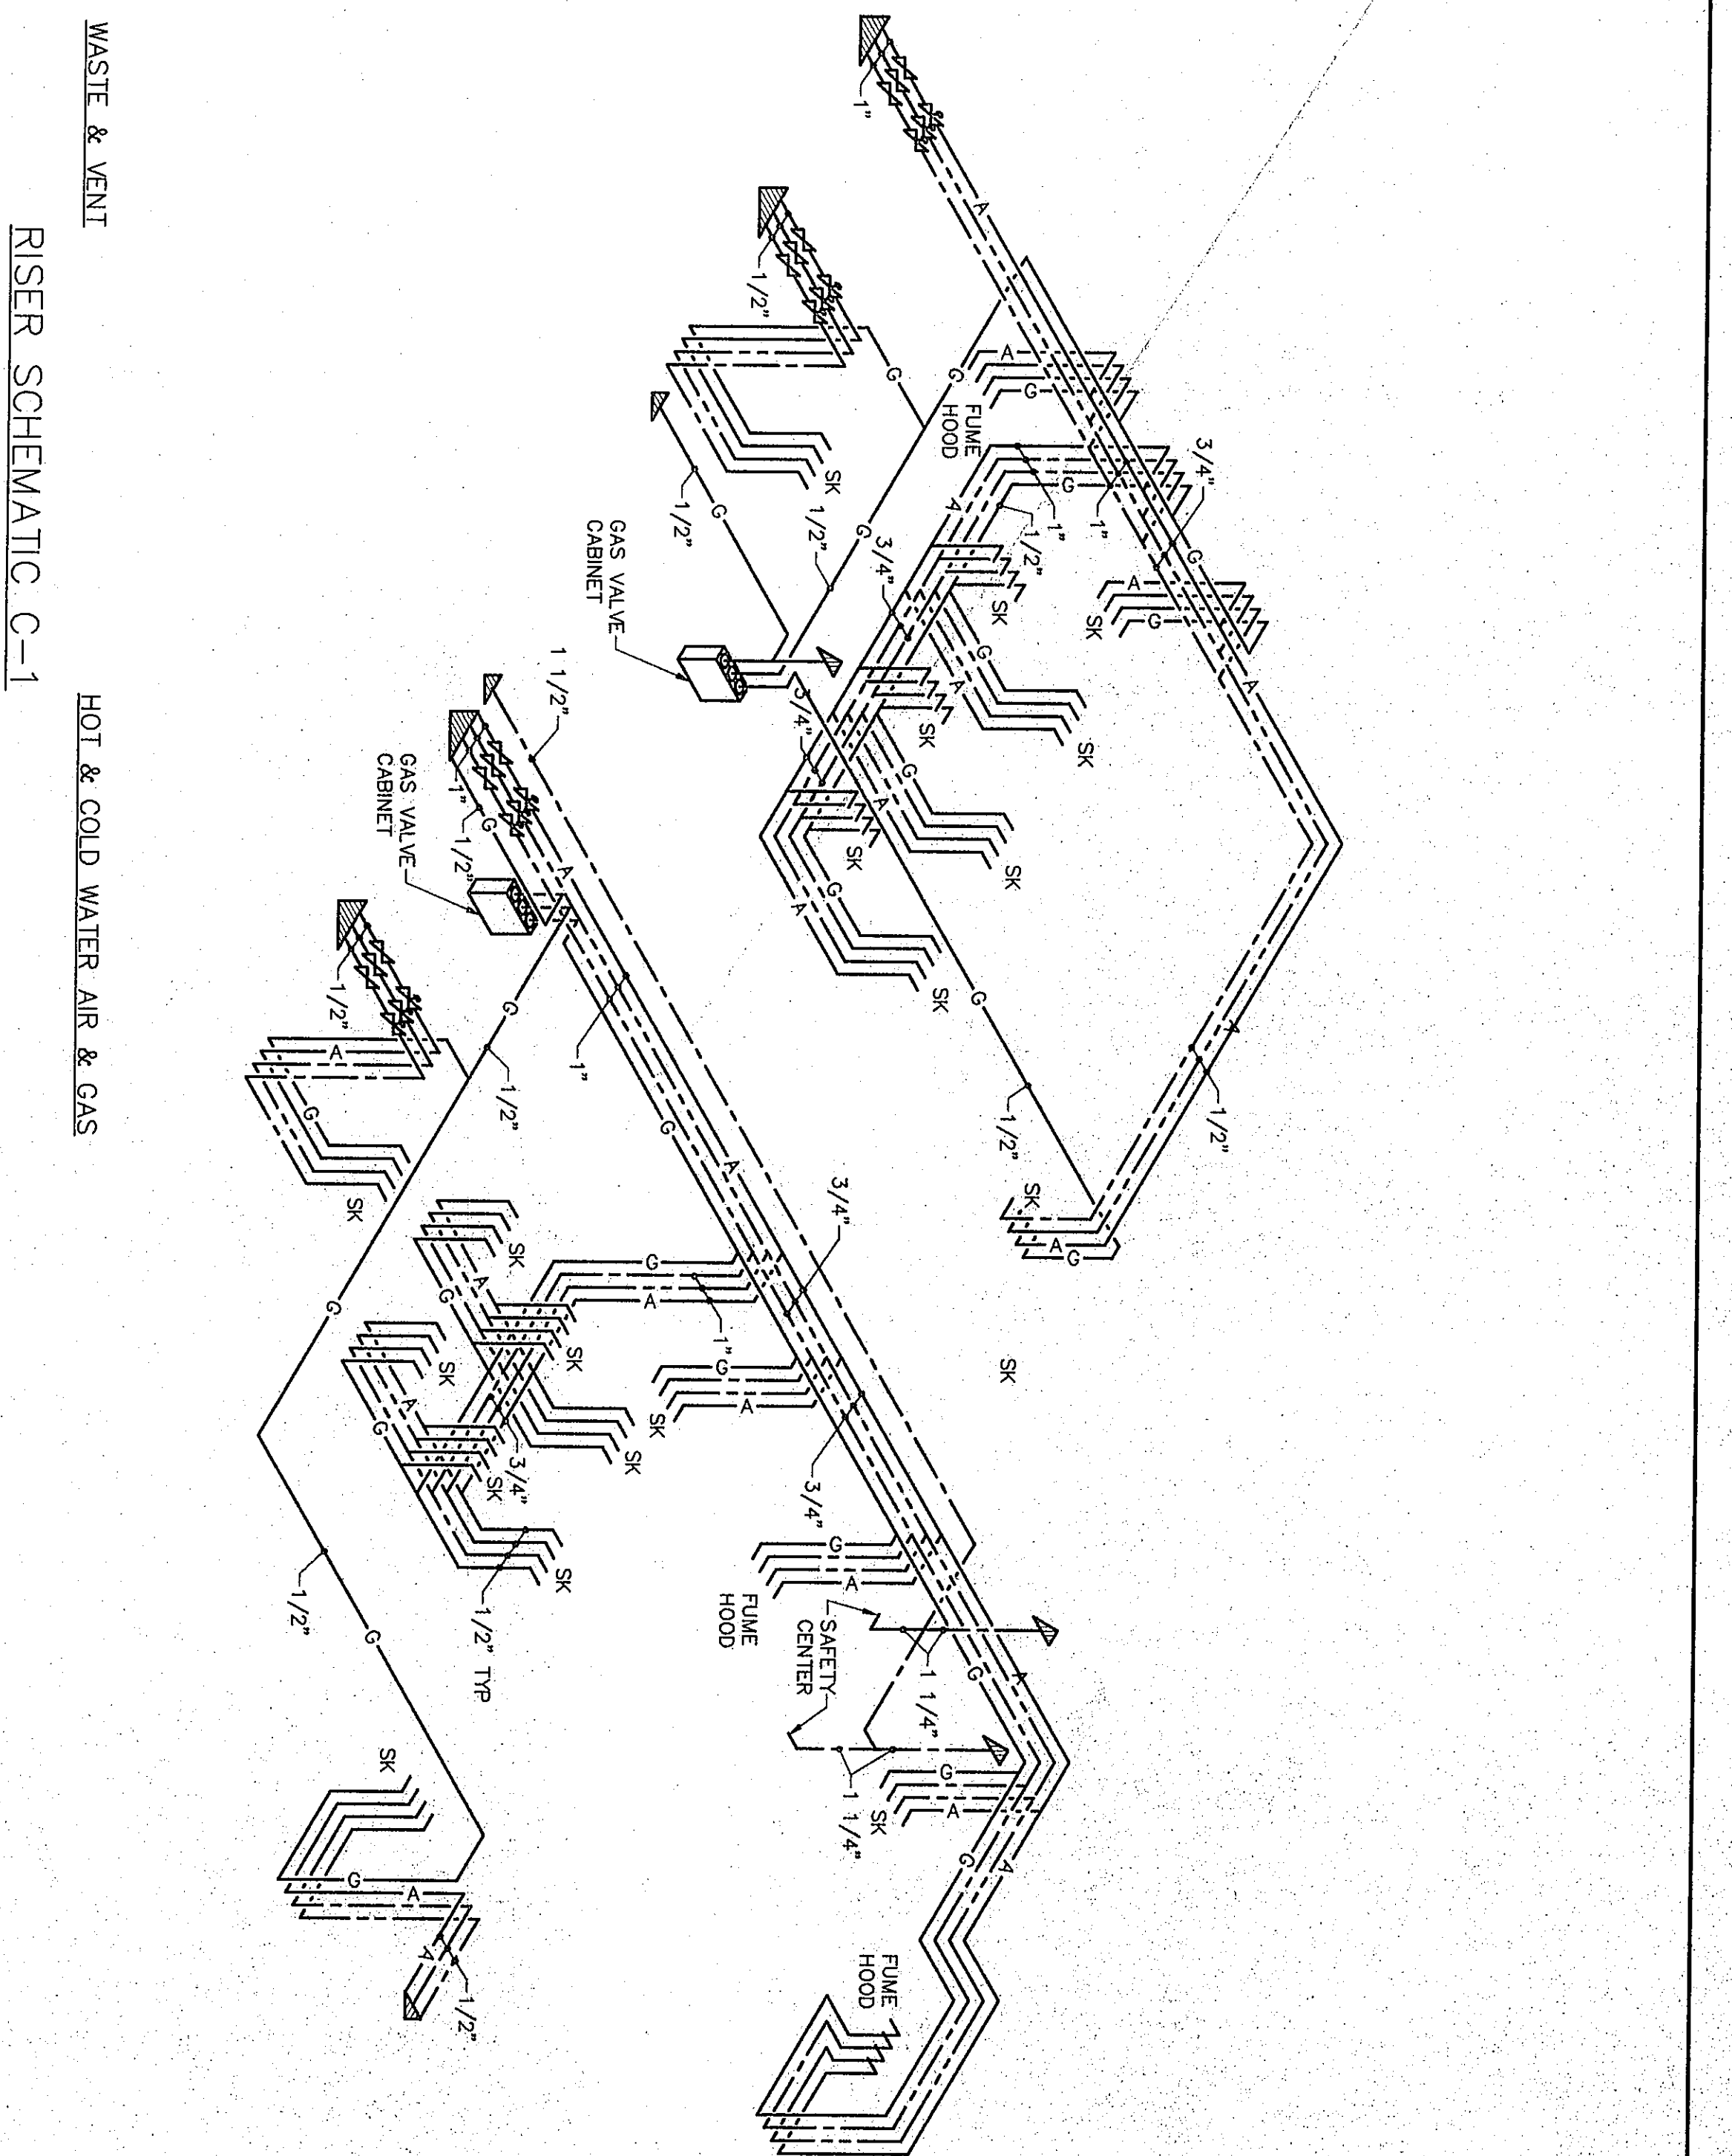


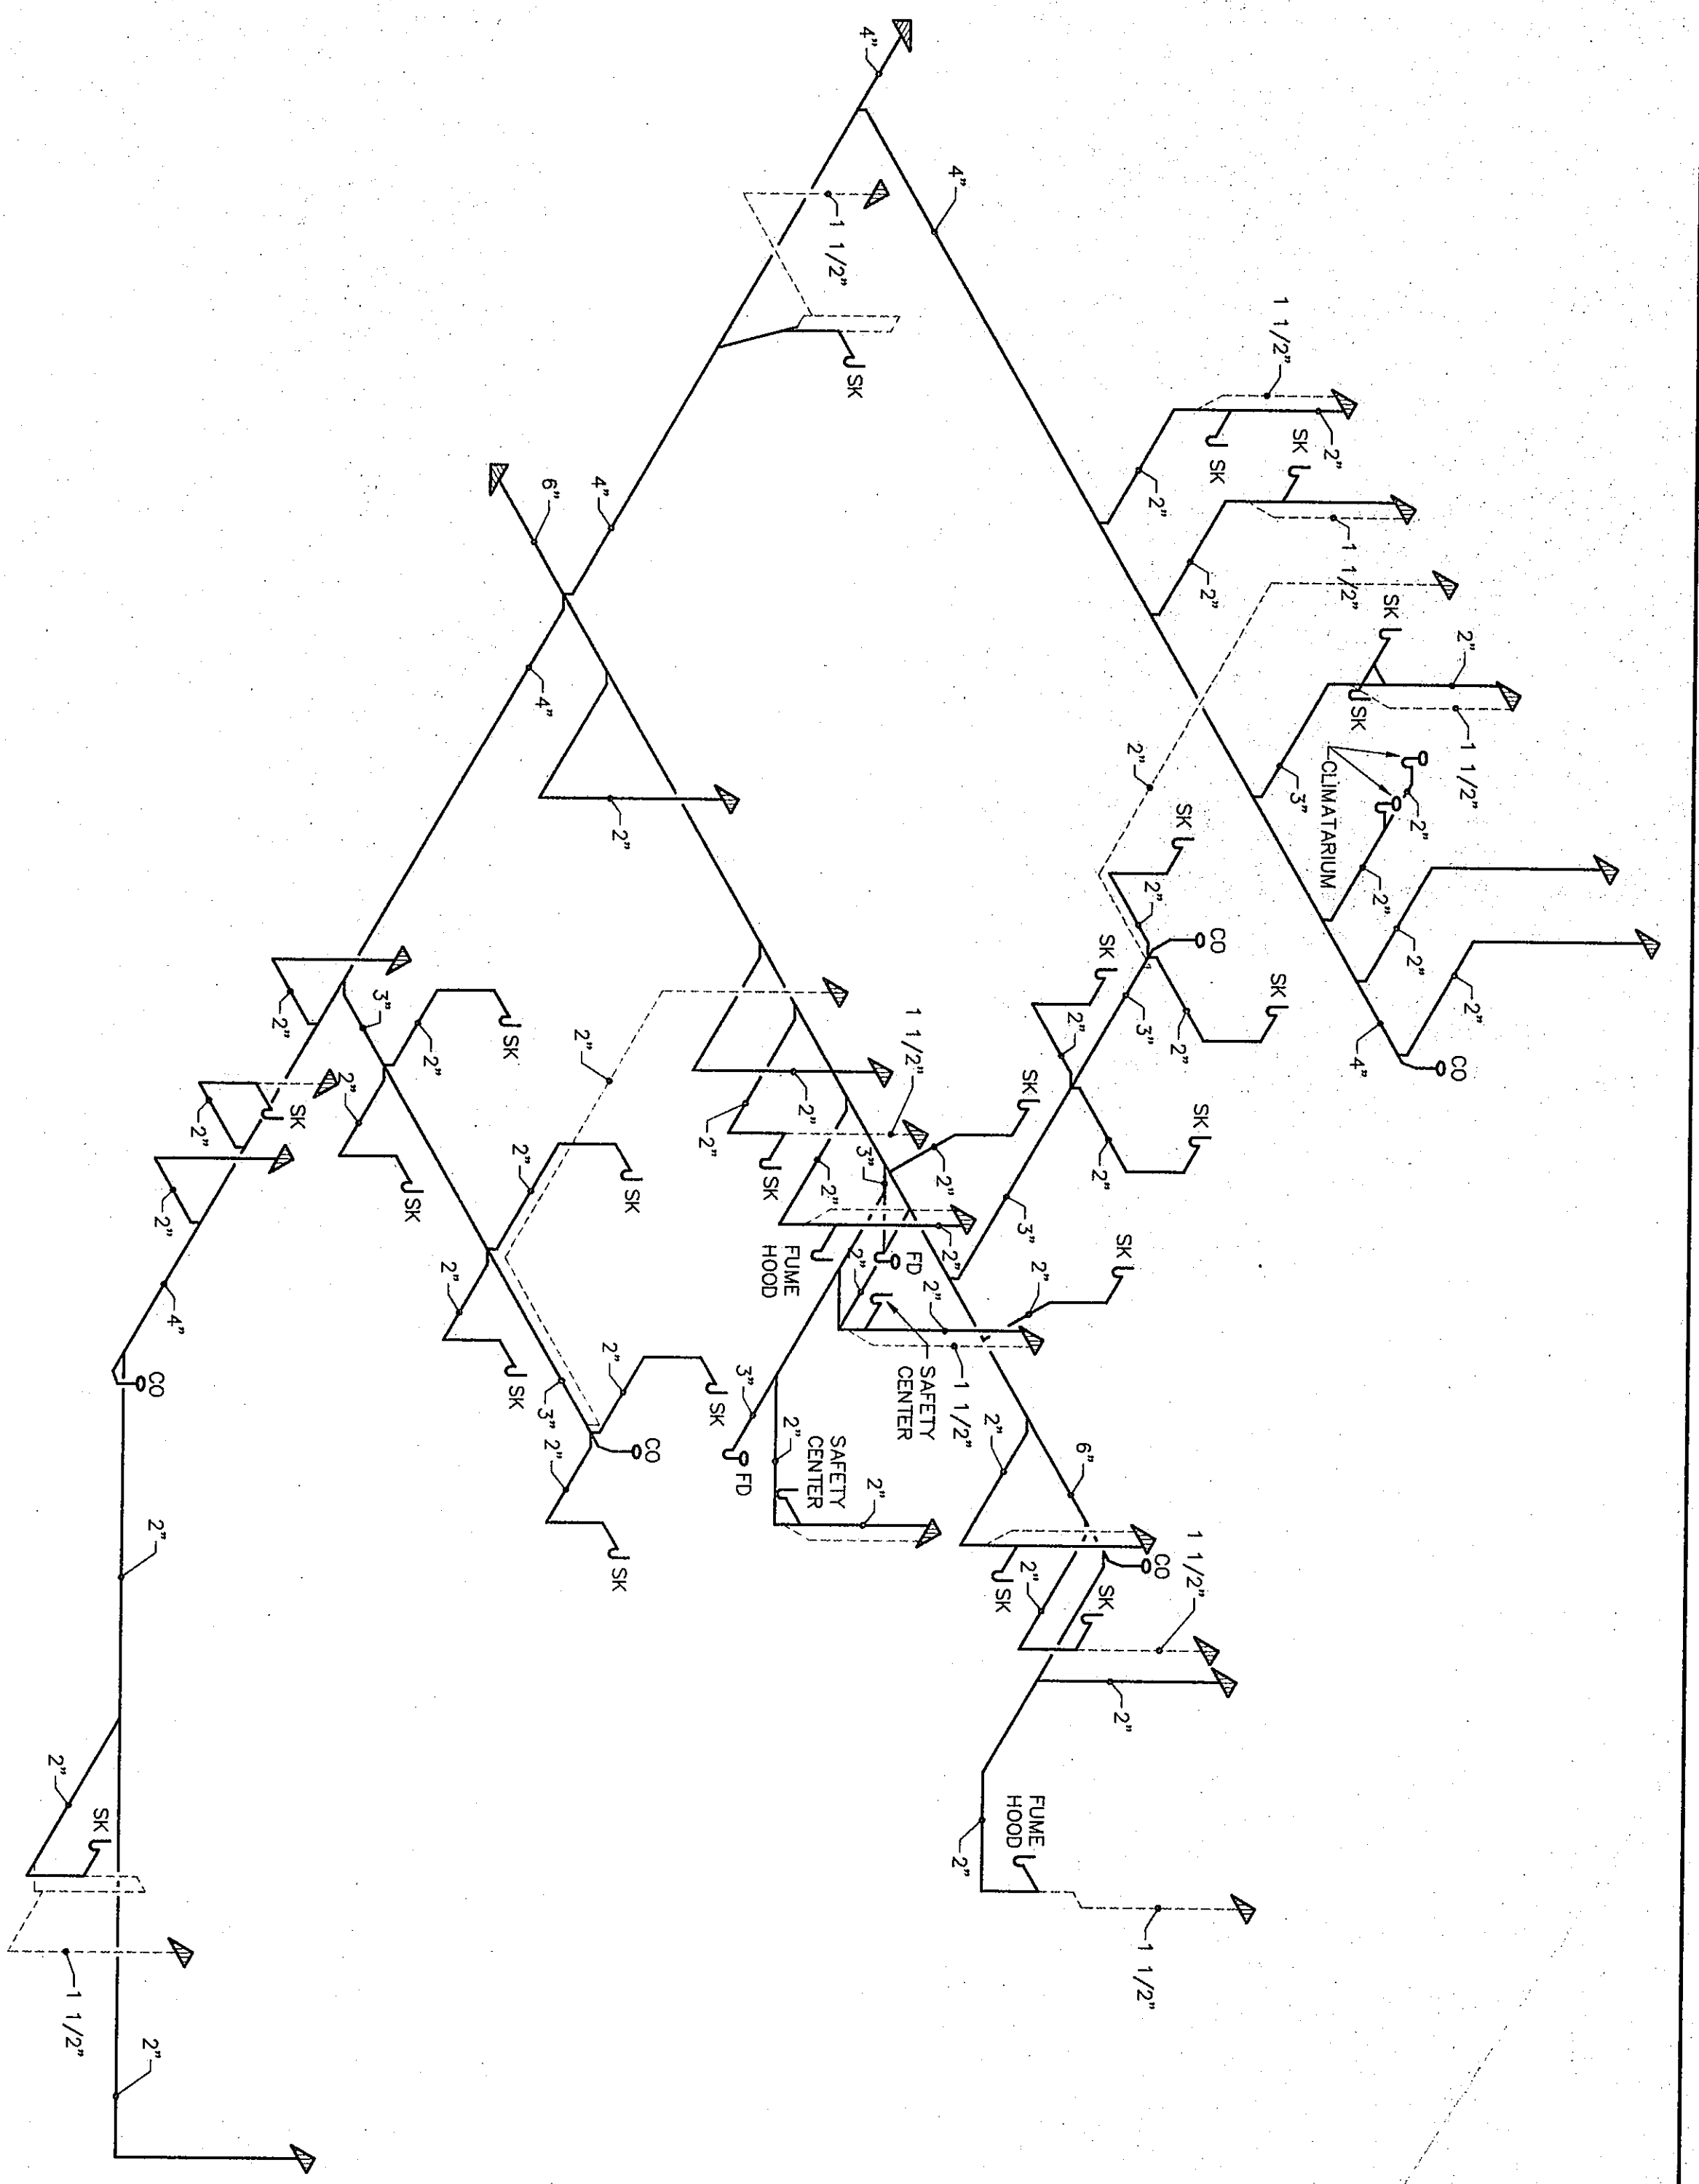

SCIENCE ROOM NOTES:

- ① REFER TO DRAWING P2.10 FOR CONTINUATION
- ② CONTINUATION OF THIS PIPING TO BE SIMILAR (N. REVERSE) TO (O) PIPING SHOWN IN ROOMS C101, C102 & C103 UNLESS OTHERWISE INDICATED.
- ③ GAS PIPING IN ROOMS C101, C102 & C103 TO BE SIMILAR (N. REVERSE) TO ROOMS C104, C105, C106, C107.


HOSE REEL TO BE CHICAGO NO. 537 RETRACTABLE HOSE REEL W/ 35 FT. HOSE REEL, 1/2" HOSE, SUSPENDED AND FLUSH WITH CEILING. (TYP. 2) COMPLETE WITH VACUUM BREAKER.

ROOM LEGEND "C"

ROOM NO.	ROOM NAME	AREA S.F.	CEILING HEIGHT
C101	SCIENCE LAB	1809	9'-2"
C102	SCIENCE LAB	1809	9'-2"
C103	SCIENCE LAB	1809	9'-2"
C104	GREENHOUSE	580	13'-8"
C105	SCIENCE LAB	1441	9'-2"
C106	SCIENCE LAB	1809	9'-2"
C107	SCIENCE LAB	1809	9'-2"



PLUMBING PLAN NOTES:

- ① 1/2" H&C WATER, 1 1/2" WASTE UP TO FIXTURE ABOVE
- ② 1/2" COLD WATER UP AND DOWN TO DMC.
- ③ 1/2" HOT AND COLD WATER, 1 1/2" WASTE DOWN TO FLOOR BELOW.
- ④ 1/2" COLD WATER, 1 1/2" WASTE DOWN TO RETRIBUTOR/ICE MAKER.
- ⑤ DISHWASHER TO BE CONNECTED TO WATER AND WASTE PLUMBING OF ADJACENT SINK.
- ⑥ HOT WATER AND/OR COLD WATER, GAS AND SANITARY VENT PIPING ARE TO BE INSTALLED IN COVERED FLOOR ARCHITECTURAL PLANS.
- ⑦ HOT WATER AND/OR COLD WATER AND/OR GAS AND/OR SANITARY VENT PIPING ARE TO BE INSTALLED IN COVERED FLOOR OF CLOSET/BATH CABINETS AND ABOVE FLOOR IN SINK-CRATOR, MODEL 77, 3/4" HP.
- ⑧ GAS PIPING DOWN TO STAND VALVE WITH RECESSED CABINET, AND UP FROM CLOSET, REFER TO DETAIL.
- ⑨ 1/2" GAS AT 6" ABOVE FLOOR WITH STOP VALVE FOR RANGE CONNECTION.
- ⑩ DRAINAGE SINK WITH MIXING FAUCET BY DIVISION 14470 SANITARY VENT, H&C WATER CONNECTIONS BY DIVISION 15450, VERIFY ALL CONNECTIONS.
- ⑪ 1/2" COMPRESSED AIR PIPING DOWN TO 48" ABOVE FINISHED FLOOR, VALVE AND TEE WITH DIRT LEG, AND FLUG FOR FUTURE QUICK DISCONNECT BY OWNER.
- ⑫ GAS REGULATOR TO PROVIDE 45 CU. FT. OF 7"WC NATURAL GAS PRESSURE FROM 2 PSI. REFER TO DETAIL DMC P2.1
- ⑬ GAS VALVE CABINET REFER TO DETAIL DMC P2.1
- ⑭ COMPRESSED AIR PRESSURE REGULATOR PIPING DETAIL REFER TO DETAIL DMC P2.1
- ⑮ FLOOR DRAIN TO BE INSTALLED 3500-2 WITH HINGED GRATE AND SEDIMENT BUCKET TO BE INSTALLED 1/4" TRAP
- ⑯ SUMP PUMP TO BE LITTLE GIANI MODEL 95-CA-RS WITH CHECK VALVE, UNION AND 24" BASIN
- ⑰ 1 1/2" OPEN SITE DRAIN, SEE DETAIL DMC P2.1, LOCATE ABOVE CEILING TO ALLOW FOR MAINTENANCE ACCESS

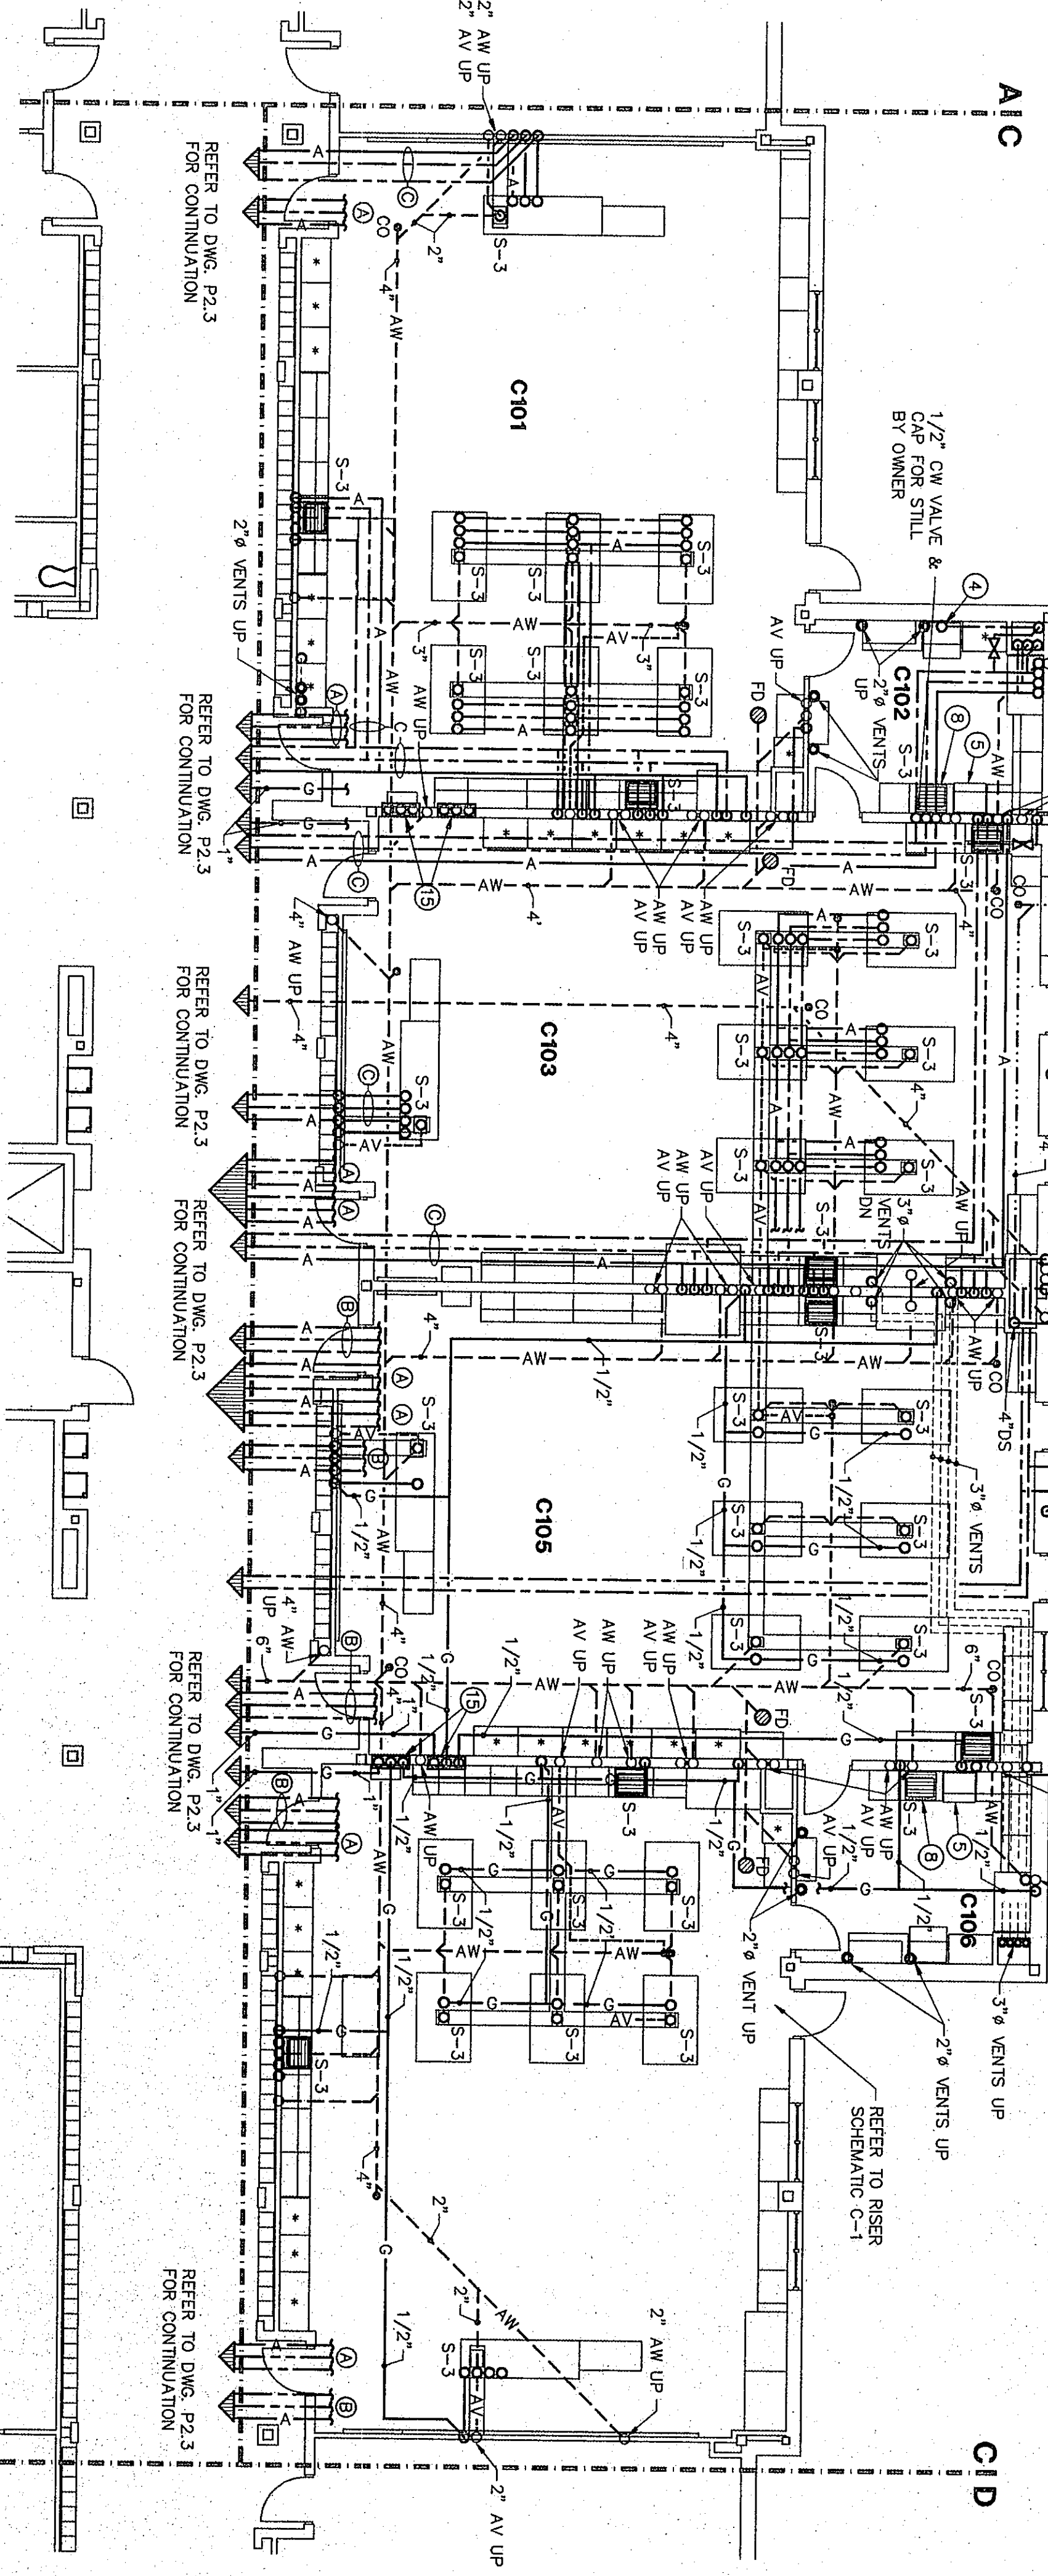


FLOOR PLAN UNIT "C"


1/8"=1'-0"

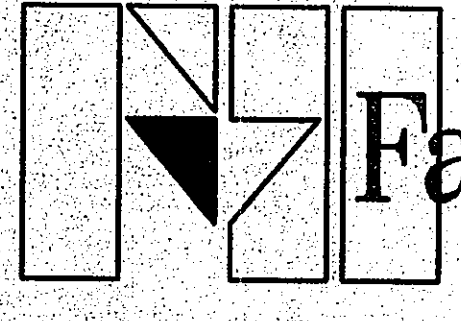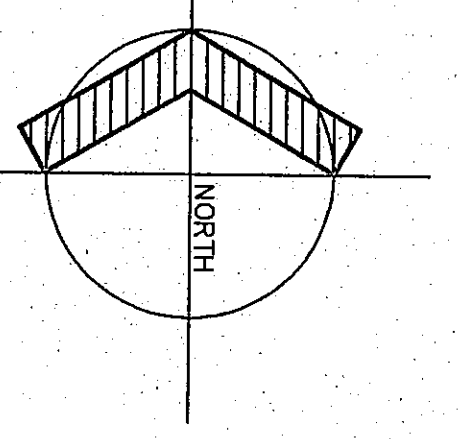

Fanning/Howe Associates, Inc.
Architects Engineers Consultants

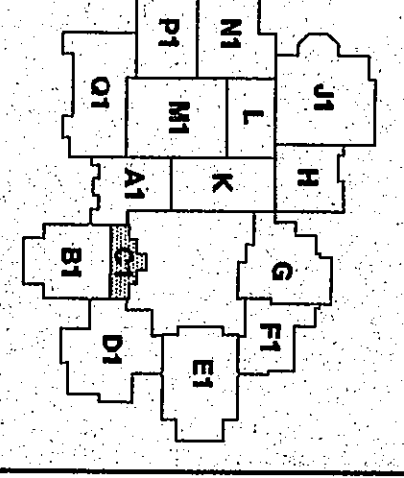

THE NEW
CHESTERTON HIGH SCHOOL
FOR THE
DUNELAND SCHOOL CORPORATION
CHESTERTON, INDIANA

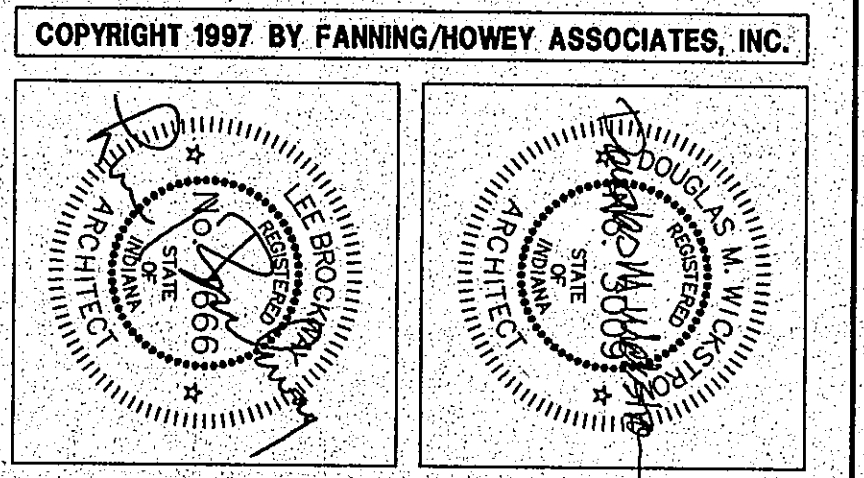

PLUMBING PLAN UNIT "C"

DRAWN BY: JJD COMM. NO.: 95067.00
CHECKED BY: CAM DATE: APRIL 21, 1997

P2.5

REVISIONS NO. DATE

CHESTERTON HIGH SCHOOL
35051100