


ROOM LEGEND "C2"			
ROOM	AREA	CEILING	FLOOR
C201	1569	W/4-ES	CHEM
C202	200	W/4-ES	CHEM
C203	1436	W/4-ES	CHEM
C204	1436	W/4-ES	CHEM
C205	1509	W/4-ES	CHEM
C206	1509	W/4-ES	CHEM



SCIENCE ROOM NOTES:

- ① REFER TO DRAWING P2.3 FOR CONTINUATION
- ② CONTINUATION OF THIS PIPING TO BE SIMILAR (IN REVERSE) TO PIPING SHOWN IN ROOMS C201, C202 & C203 UNLESS OTHERWISE INDICATED.
- ③ GAS PIPING IN ROOMS C201, C202 & C203 TO BE SIMILAR (IN REVERSE) TO ROOMS C204, C205 & C206. ALL VENT PIPING SHOWN IN ROOMS C201-C206 TO BE LOCATED IN SECOND FLOOR CEILING.

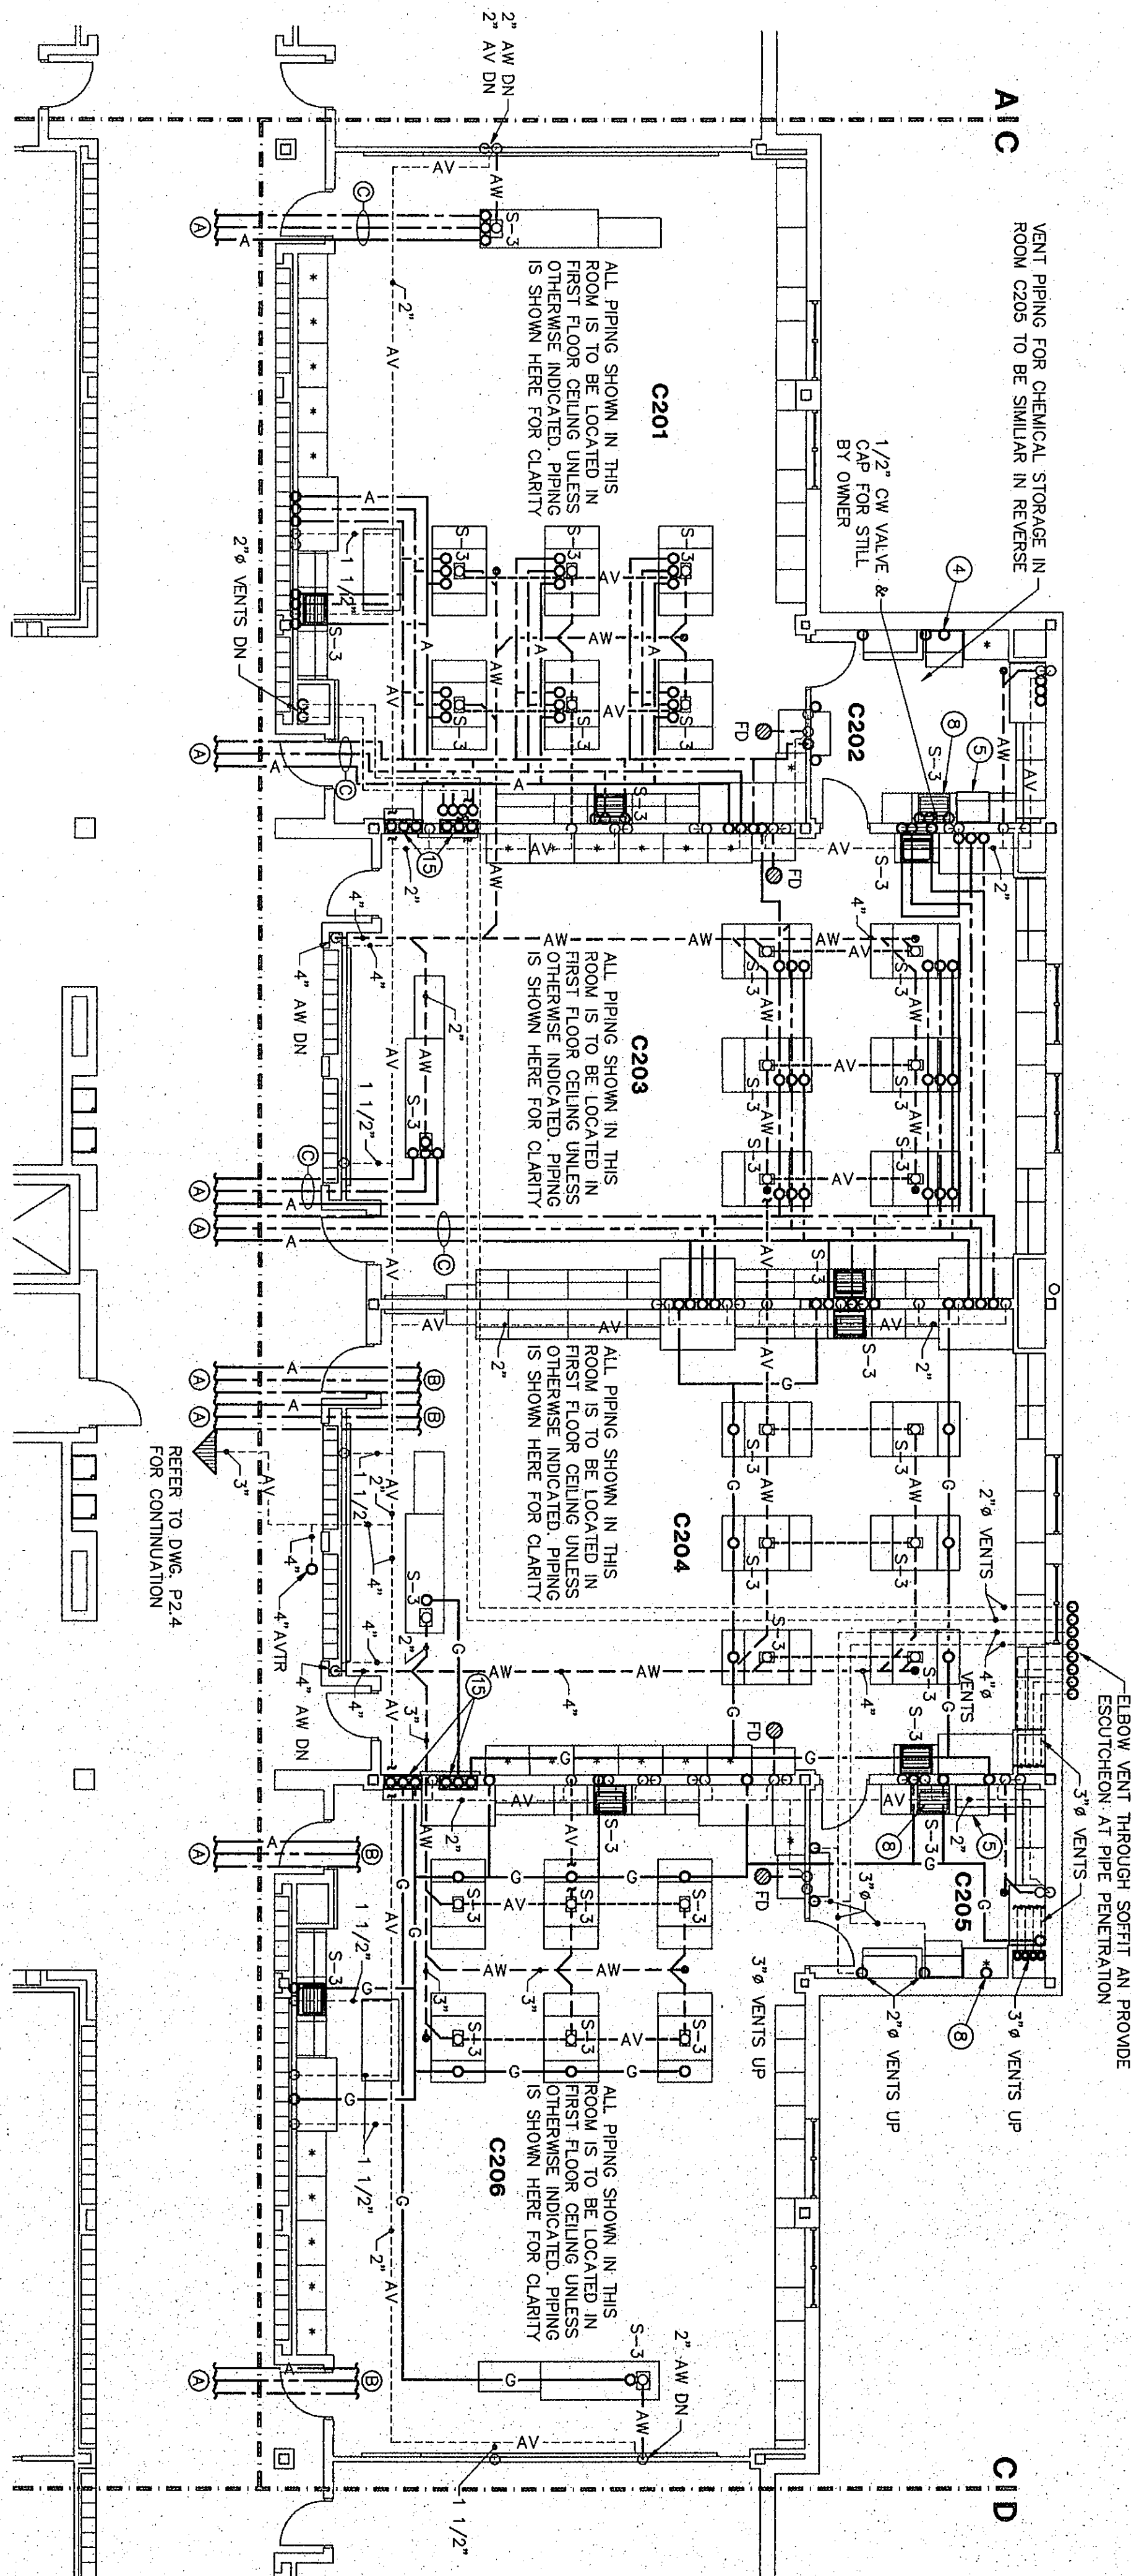


- #### PLUMBING PLAN NOTES:
- ① 1/2" H&C WATER, 1 1/2" WASTE UP TO FIXTURE ABOVE
 - ② 1/2" COLD WATER UP AND DOWN TO DWG.
 - ③ 1/2" HOT AND COLD WATER, 1 1/2" WASTE DOWN TO FLOOR BELOW
 - ④ 1/2" DOWN TO 6" ABOVE FLOOR. VALVE AND CAP FOR REFRIGERATION ICEMAKERS.
 - ⑤ DISHWASHER TO BE CONNECTED TO WATER AND WASTE PIPING OF ADJACENT SINK.
 - ⑥ HOT WATER AND/OR COLD WATER, GAS, AND SANITARY TRENCHES REFER TO DETAIL OF TRENCH INDICATED ON ARCHITECTURAL PLANS.
 - ⑦ HOT WATER AND/OR COLD WATER AND/OR GAS AND/OR SANITARY VENT PIPING TO BE INSTALLED IN BASE FRAMING OF CASEWORK, BENEATH CABINETRY AND ABOVE FLOOR.
 - ⑧ INSTALL DISPOSER AT THIS LOCATION, TO BE "IN-SINK-ERATOR", MODEL 771, 3/4 HP.
 - ⑨ GAS PIPING DOWN TO SLOTTED VALVE WITHIN RECESSED CABINET, AND UP FROM CABINET, REFER TO DETAIL.
 - ⑩ WASHING MACHINE FITTING, REFER TO DETAIL DWG. P3.1
 - ⑪ 1/2" GAS AT 6" ABOVE FLOOR WITH STOP VALVE FOR RANGE CONNECTION.
 - ⑫ DRAINROCK SINK WITH MIXING FAUCET BY DIVISION 11-470, SANITARY VENT, H&C WATER CONNECTIONS BY DIVISION 12-401, VENT, ALL CONNECTIONS.
 - ⑬ 1/2" COMPRESSED AIR PIPING DOWN TO 48" ABOVE FLOOR, REFER TO DETAIL DWG. P3.1 AND P3.2 FOR FUTURE QUICK DISCONNECT BY OWNER.
 - ⑭ GAS REGULATOR TO PROVIDE 45 PSI, 6" 7" W/4 NATURAL GAS PRESSURE FROM 2 PSI, REFER TO DETAIL DWG. P3.1
 - ⑮ GAS VALVE CABINET REFER TO DETAIL DWG. P3.1
 - ⑯ COMPRESSED AIR PRESSURE REGULATOR PIPING DETAIL, REFER TO DETAIL DWG. P3.1
 - ⑰ FLOOR DRAIN TO BE JOSEPH 35233-2, WITH HINGED GRATE AND SEDIMENT BUCKET, TO BE INSTALLED W/ TRAP TO PUMP 30 GPM @ 20 FT. HD, 1/2 HP, 120V, COMPLETE WITH CHECK VALVE, UNION AND 24" BASIN
 - ⑱ 1 1/2" OPEN SITE DRAIN, SEE DETAIL DWG. P3.1, LOCATE ABOVE CEILING TO ALLOW FOR MAINTENANCE ACCESS.

FLOOR PLAN UNIT "C2"

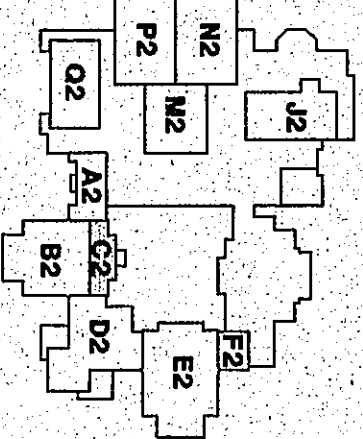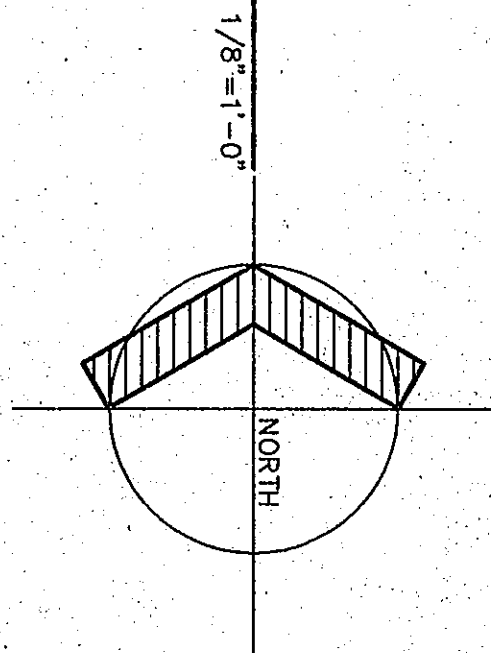

THE NEW
CHESTERTON HIGH SCHOOL
FOR THE
DUNELAND SCHOOL CORPORATION
CHESTERTON, INDIANA

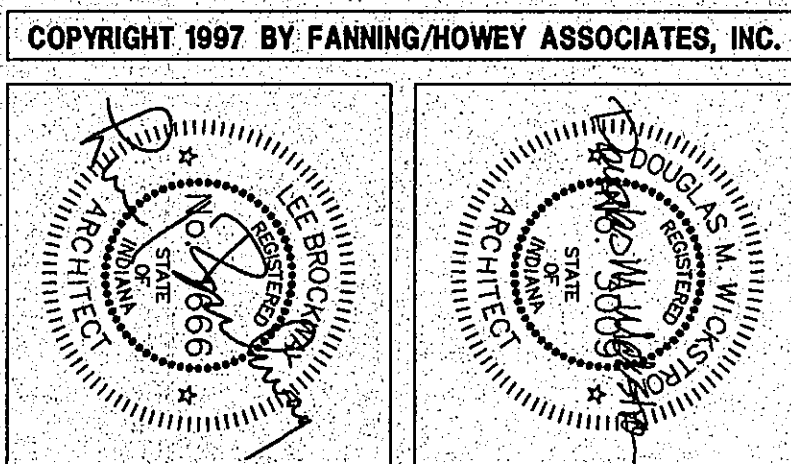

Fanning/Howey Associates, Inc.
Architects Engineers Consultants

PLUMBING PLAN UNIT "C2"
DRAWN BY: JLD COMM. NO.: 95067.00
CHECKED BY: CAM DATE: APRIL 21, 1997
P2.6

CHESTERTON HIGH SCHOOL
95067.00

07-P-007